




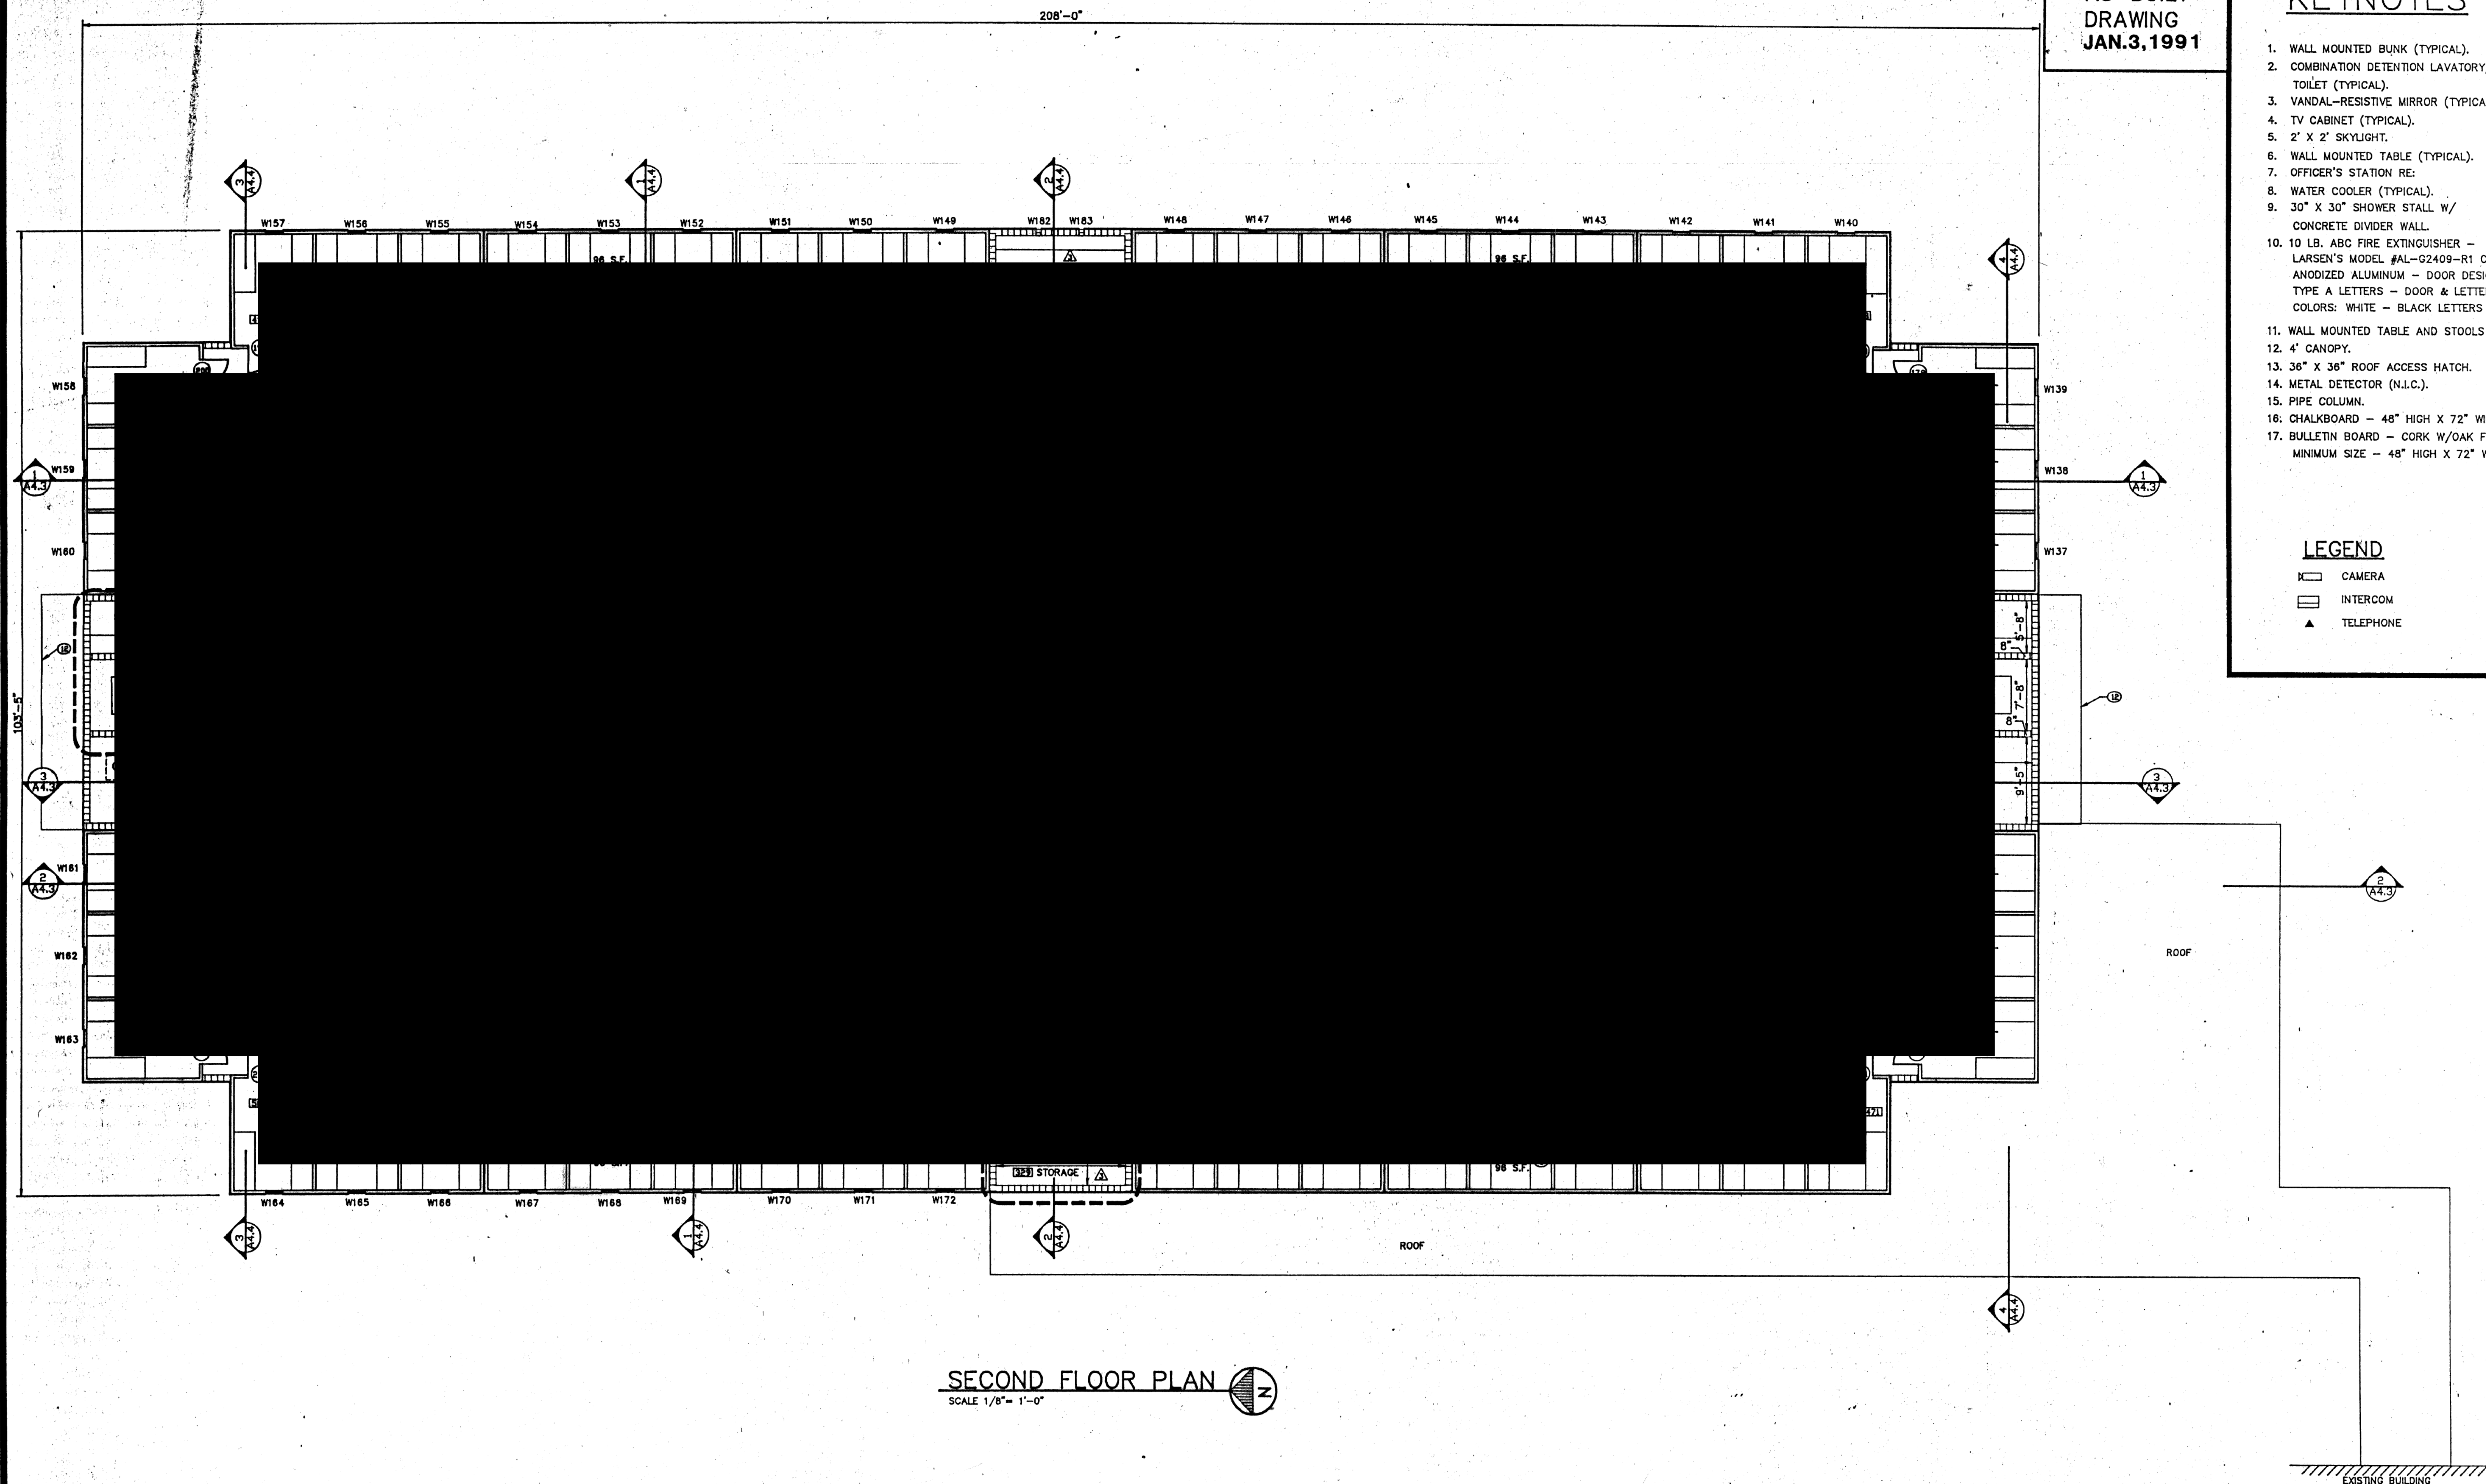
ATTACHEMENT 6, BUILDING ELEVATIONS AS-BUILT DRAWING
IFBC 20-R073858AJ MANATEE COUNTY JAIL - STOCKADE ROOF
REPLACEMENT

KEYNOTES

1. WALL MOUNTED BUNK (TYPICAL).
2. COMBINATION DETENTION LAVATORY/
TOILET (TYPICAL).
3. VANDAL-RESISTIVE MIRROR (TYPICAL).
4. TV CABINET (TYPICAL).
5. 2' X 2' SKYLIGHT.
6. WALL MOUNTED TABLE (TYPICAL).
7. OFFICER'S STATION RE:
8. WATER COOLER (TYPICAL).
9. 30" X 30" SHOWER STALL W/
CONCRETE DIVIDER WALL.
10. 10 LB. ABC FIRE EXTINGUISHER -
LARSEN'S MODEL #AL-G2409-R1 CLEAR
ANODIZED ALUMINUM - DOOR DESIGN:
TYPE A LETTERS - DOOR & LETTERING
COLORS: WHITE - BLACK LETTERS
11. WALL MOUNTED TABLE AND STOOLS (TYP.)
12. 4' CANOPY.
13. 36" X 36" ROOF ACCESS HATCH.
14. METAL DETECTOR (N.I.C.).
15. PIPE COLUMN.
16. CHALKBOARD - 48" HIGH X 72" WIDE
17. BULLETIN BOARD - CORK W/OAK FRAME-
MINIMUM SIZE - 48" HIGH X 72" WIDE.


LEGEND

-  CAMERA
 INTERCOM
 TELEPHONE



SECOND FLOOR PLAN

SCALE 1/8" = 1'-0"



▲				
▲	12/20/90	AS-BUILT		
▲	06/18/90	GENERAL REVISIONS		
▲	06/11/90	ADDED CLOSETS TO ROOMS 338 & 340; DOORS 351 & 332		
▲	06/02/90	GENERAL REVISIONS		
REV	DATE	DESCRIPTION	CHKD	APPR



**JAMES DELAUNE, JR.
AND ASSOCIATES, INC.**

661 CENTERVILLE ST. TELEPHONE
DENHAM SPRINGS, LA 70728 (504) 664-8865



**INTERNATIONAL SYSTEMS,
INC.**
POST OFFICE DRAWER 1667
BROOKLEY INDUSTRIAL COMPLEX
MOBILE, ALA. 36601
(205) 432-3881

PROJECT NO. 121389C	DESIGNED —
FILE NAME MCSA2-2	DRAWN M.E.P.
DATE 4/6/90	CHECKED —

DRAWING TITLE
FLOOR PLAN

PROJECT TITLE
MANATEE COUNTY STOCKADE
FACILITY EXPANSION
PALMETTO, FLORIDA

DRAWING NO.
A2.2
SHEET NO. — OF —

LEGEND:

F-# FAN

INTAKE HOOD


EXHAUST FAN

ROOF HATCH




SKY LITE

T.O.R. - TOP OF ROOF
T.O.W. - TOP OF WALL

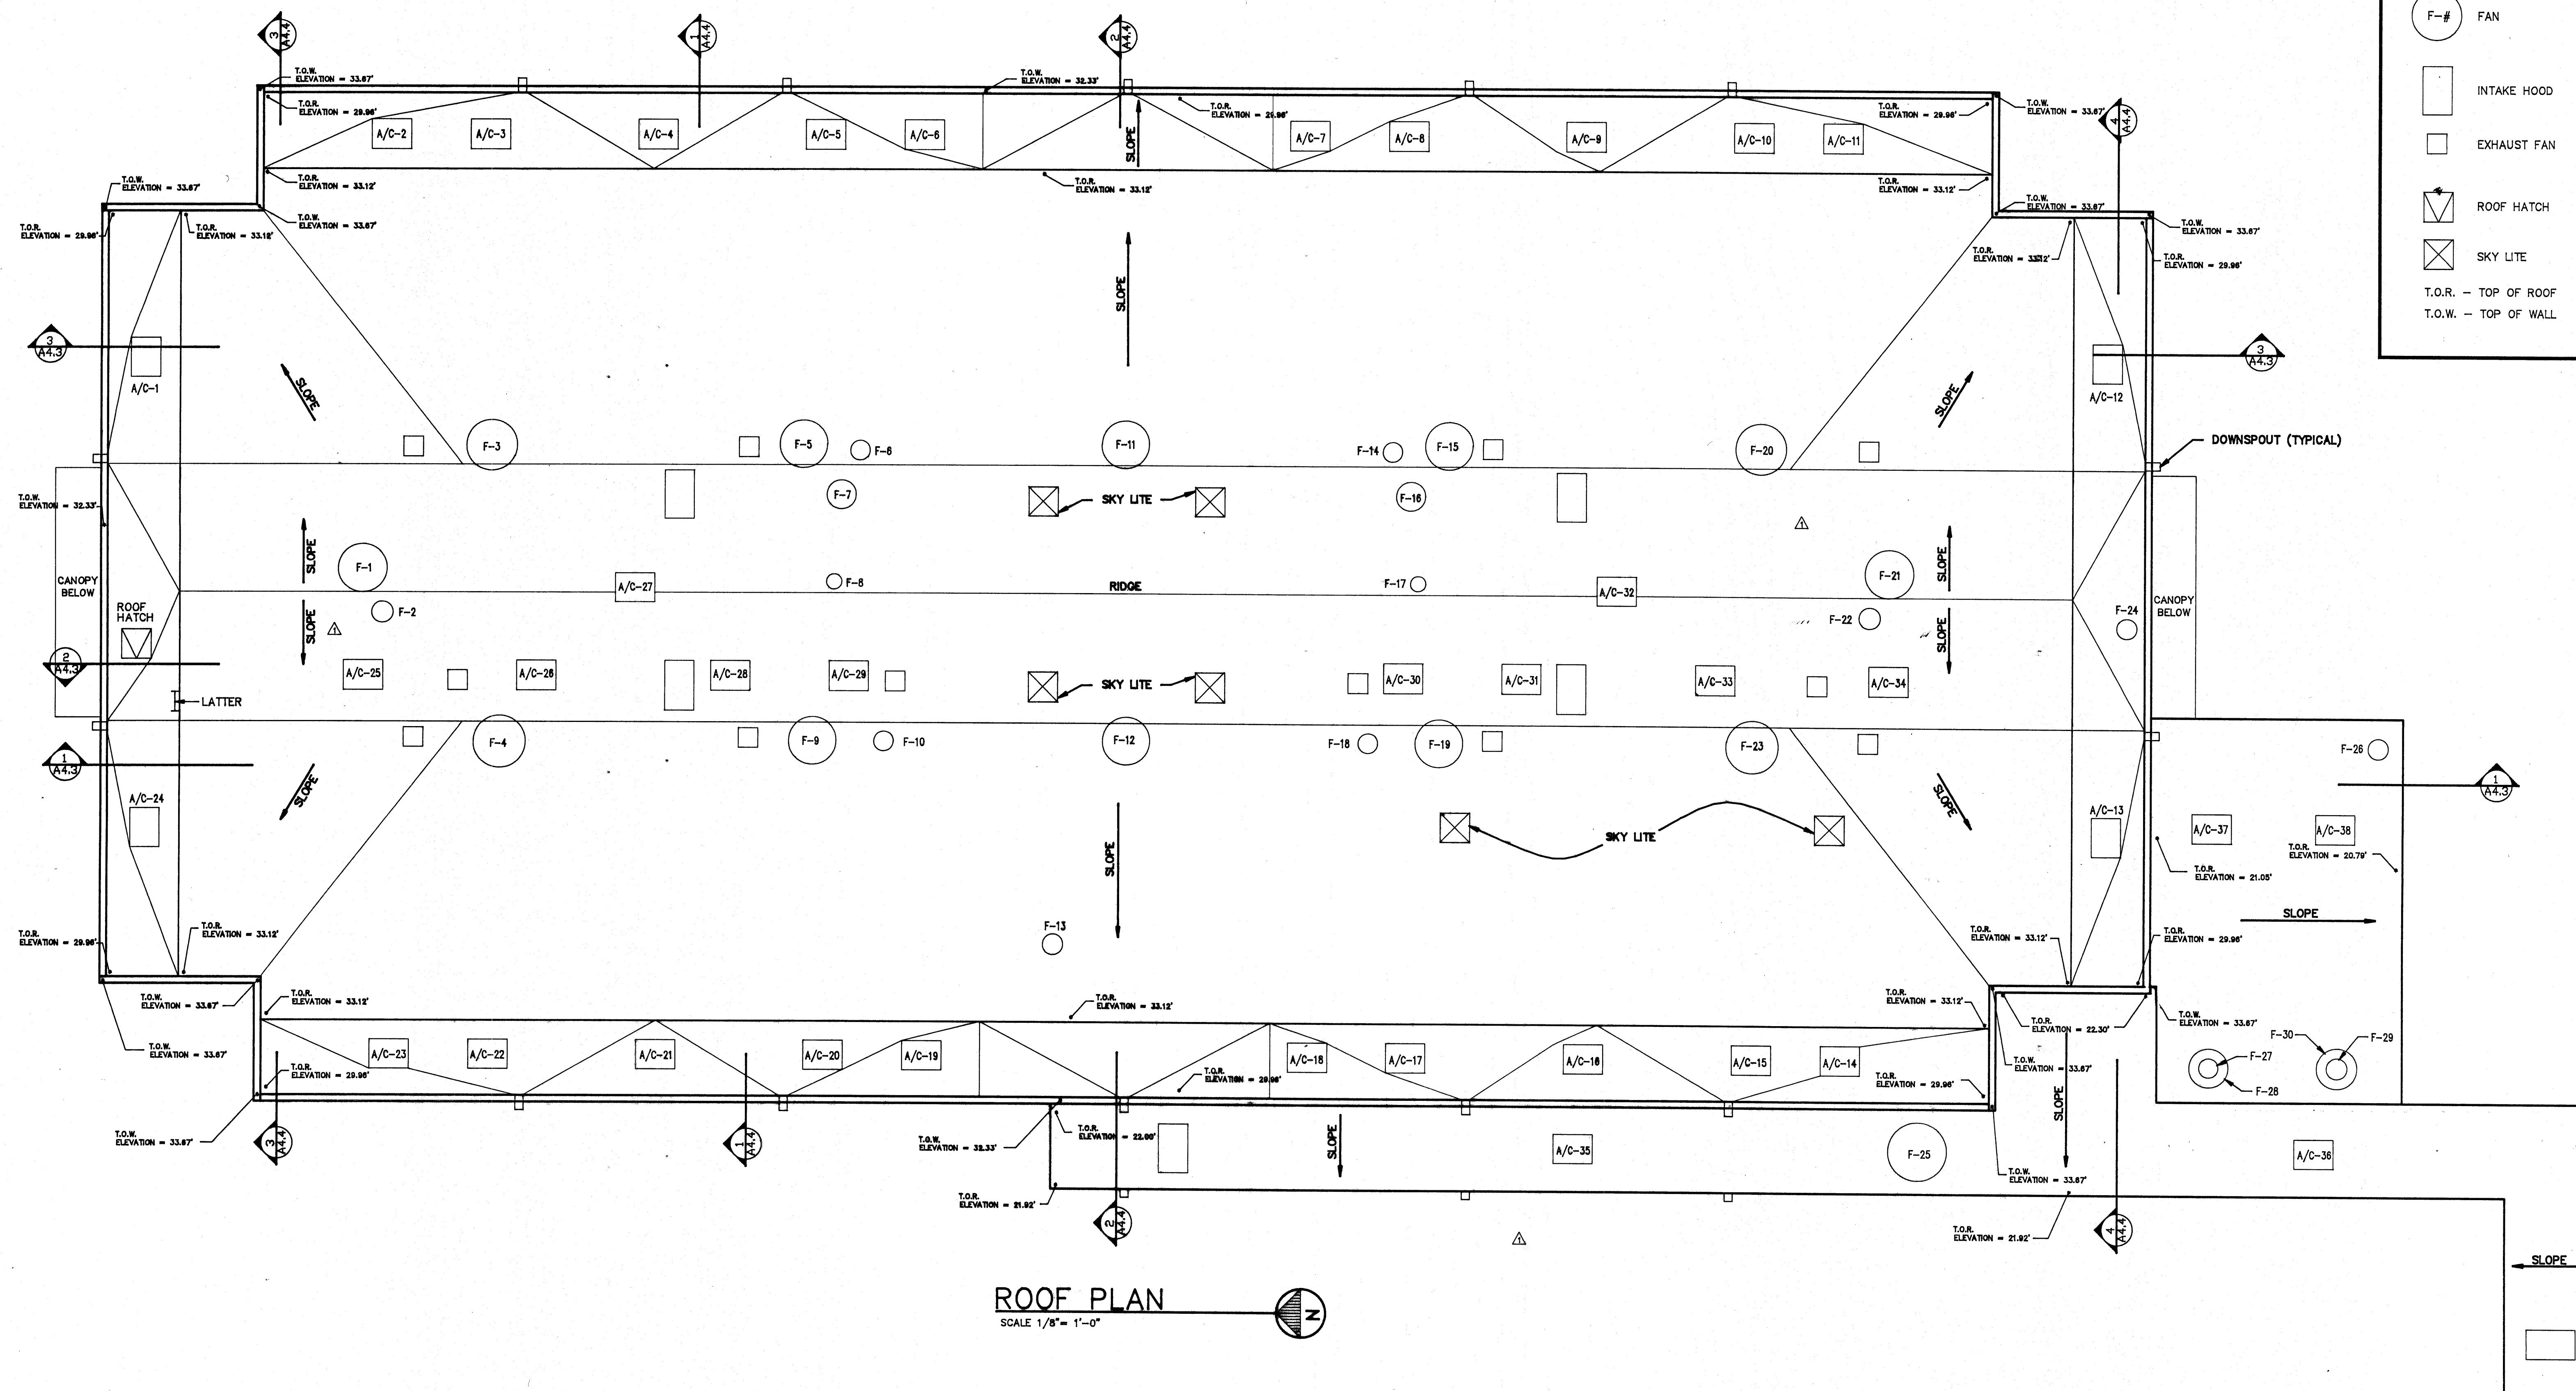


ROOF PLAN

△				
△				
△				
△				
△	12/20/90	AS-BUILT		
REV	DATE	DESCRIPTION	CHKD	APPR

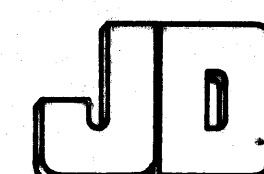

**JAMES DELAUNE, JR.
AND ASSOCIATES, INC.**
681 CENTERVILLE ST. TELEPHONE:
DENHAM SPRINGS, LA 70728 (504) 884-8885

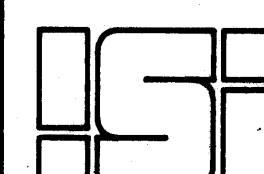

**INTERNATIONAL SYSTEMS,
INC.**

POST OFFICE DRAWER 1667
BROOKLEY INDUSTRIAL COMPLEX

MOBILE, ALA. 36601
(205) 438-3501

PROJECT NO.	121300C
FILE NAME	MCSA2-5A
DATE STARTED	05/01/90

DESIGNED BY:	
DRAWN BY:	DJO
CHECKED BY:	

DRAWING TITLE
ROOF PLAN
—
—

PROJECT TITLE
MANATEE COUNTY STOCKADE
FACILITY EXPANSION
PALMETTO, FLORIDA


DRAFTING NO.

A2.5


12/20/90
05/09/90

KEYNOTES

- △ 1. PLACO FINISH
- 2. CONCRETE PAD
- 3. METAL CANOPY
- 4. 4" PVC DOWNSPOUT INCASED BY DRYVIT
- 5. DETENTION WINDOW - 20" W X 5" H
- 6. CAP TRIM
- 7. DETENTION DOOR
- 8. ROOF TOPPING
- △ 9. RAZOR WIRE
- △ 10. STUCCO FINISH
- △ 11. SPRINKLER INSPECTION LINE

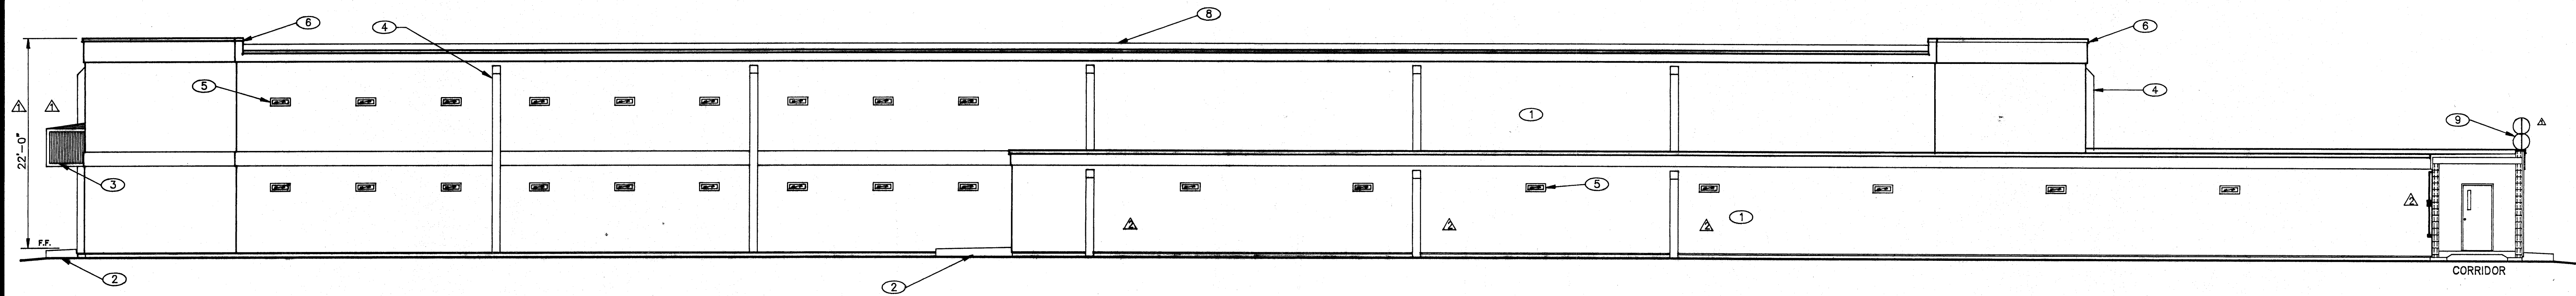


1 WEST ELEVATION
SCALE: 1/8" = 1'-0"

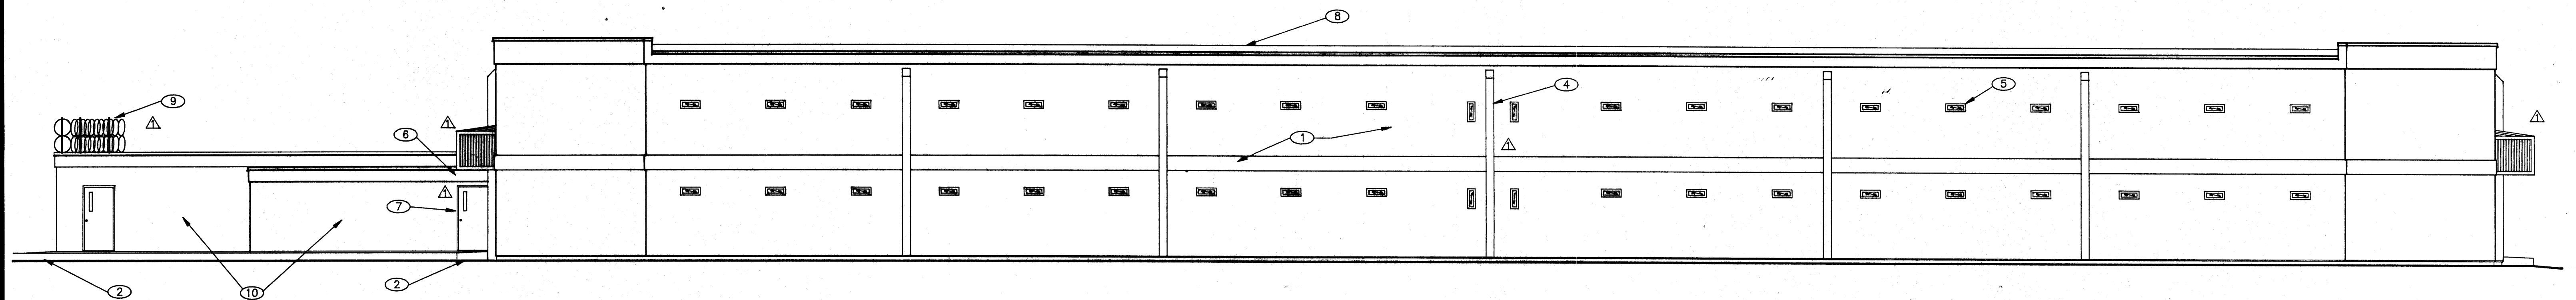


2 EAST ELEVATION
SCALE: 1/8" = 1'-0"

AS-BUILT
DRAWING
JAN. 8, 1991

REV	DATE	DESCRIPTION	CHKD	APPR
△	12/20/90	AS-BUILT		
△	07/10/90	GENERAL REVISIONS		

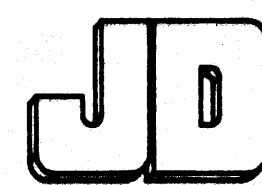

**JAMES DELAUNE, JR.
AND ASSOCIATES, INC.**
681 CENTERVILLE ST.
DENHAM SPRINGS, LA 70728
TELEPHONE:
(504) 884-8865

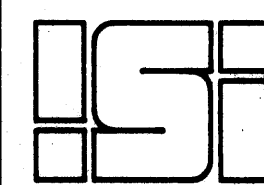

**INTERNATIONAL SYSTEMS,
INC.**
POST OFFICE DRAWER 1067
BROOKLEY INDUSTRIAL COMPLEX
MOBILE, ALA. 36601
(205) 438-3881

PROJECT NO. 121389C	DESIGNED BY: —
FILE NAME MCSA4-1A	DRAWN BY: DJU
DATE STARTED 5/01/90	CHECKED BY: —


DRAWING TITLE EAST & WEST BUILDING ELEVATIONS

PROJECT TITLE
**MANATEE COUNTY STOCKADE
FACILITY EXPANSION
PALMETTO, FLORIDA**


DRAWING NO.
A4.1
SHEET NO. — OF —

KEYNOTES

1. PLACO FINISH
2. CONCRETE PAD
3. METAL CANOPY
4. 4" PVC DOWNSPOUT INCASED BY DRYVIT
5. DETENTION WINDOW - 20" W X 5" H
6. CAP TRIM
7. DETENTION DOOR
8. ROOF TOPPING
9. RAZOR WIRE
10. STUCCO FINISH
11. FIRE LINE RISER
12. INTERCOM
13. CIGARETTE LIGHTER
14. SPRINKLER INSPECTION LINE

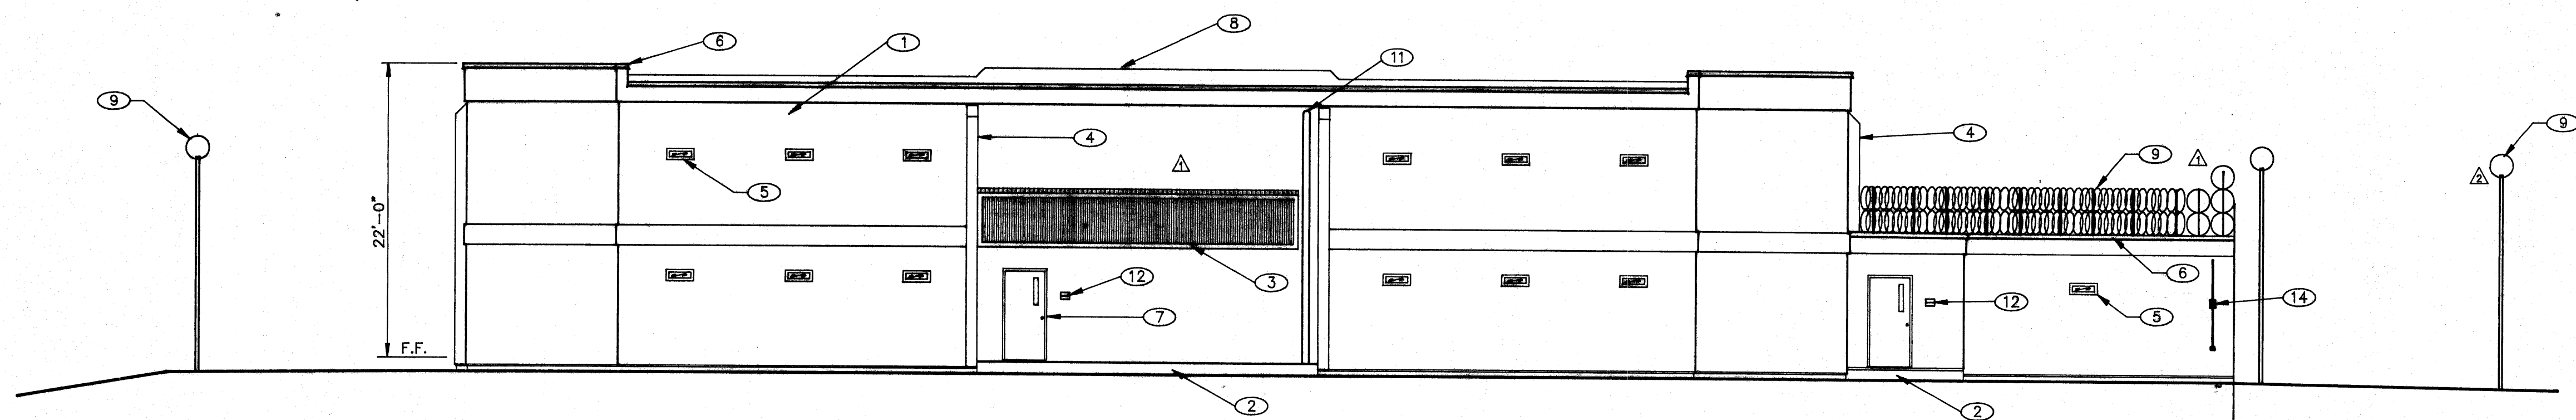


1 NORTH ELEVATION
SCALE: 1/8" = 1'-0"

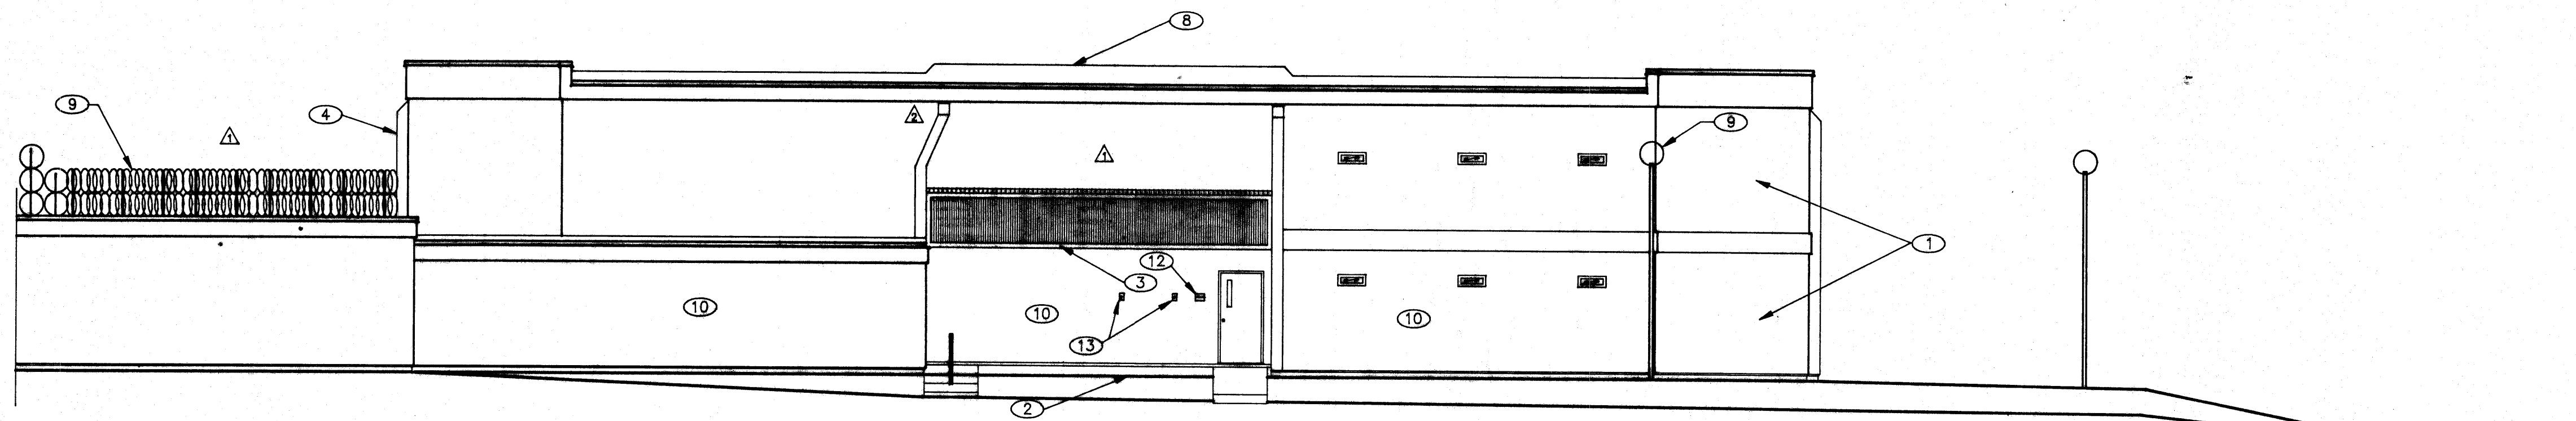


2 SOUTH ELEVATION
SCALE: 1/8" = 1'-0"

AS-BUILT
DRAWING
JAN.3,1991

REV	DATE	DESCRIPTION	CHKD	APPR
1	12/20/90	AS-BUILT		
2	7/11/90	GENERAL REVISIONS		

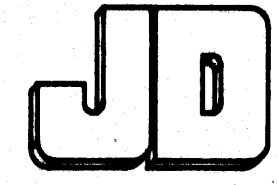

**JAMES DELAUNE, JR.
AND ASSOCIATES, INC.**
681 CENTERVILLE ST.
DENHAM SPRINGS, LA 70728
TELEPHONE:
(504) 884-8885

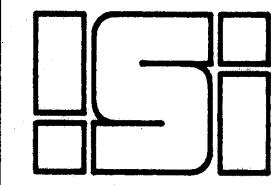

**INTERNATIONAL SYSTEMS,
INC.**
POST OFFICE DRAWER 1987
BROOKLEY INDUSTRIAL COMPLEX
MOBILE, ALA. 36601
(205) 438-3881

PROJECT NO. 121389C	DESIGNED BY: -
FILE NAME MCSA4-2A	DRAWN BY: DJO
DATE STARTED 5/01/90	CHECKED BY: -

DRAWING TITLE NORTH & SOUTH BUILDING ELEVATIONS


PROJECT TITLE MANATEE COUNTY STOCKADE FACILITY EXPANSION PALMETTO, FLORIDA
--

DRAWING NO.
A4.2
SHEET NO. - OF -

AS-BUILT
DRAWING
JAN. 3, 1991

LEGEND:


- A/C # A.C. UNIT
- F-# FAN
- INTAKE HOOD

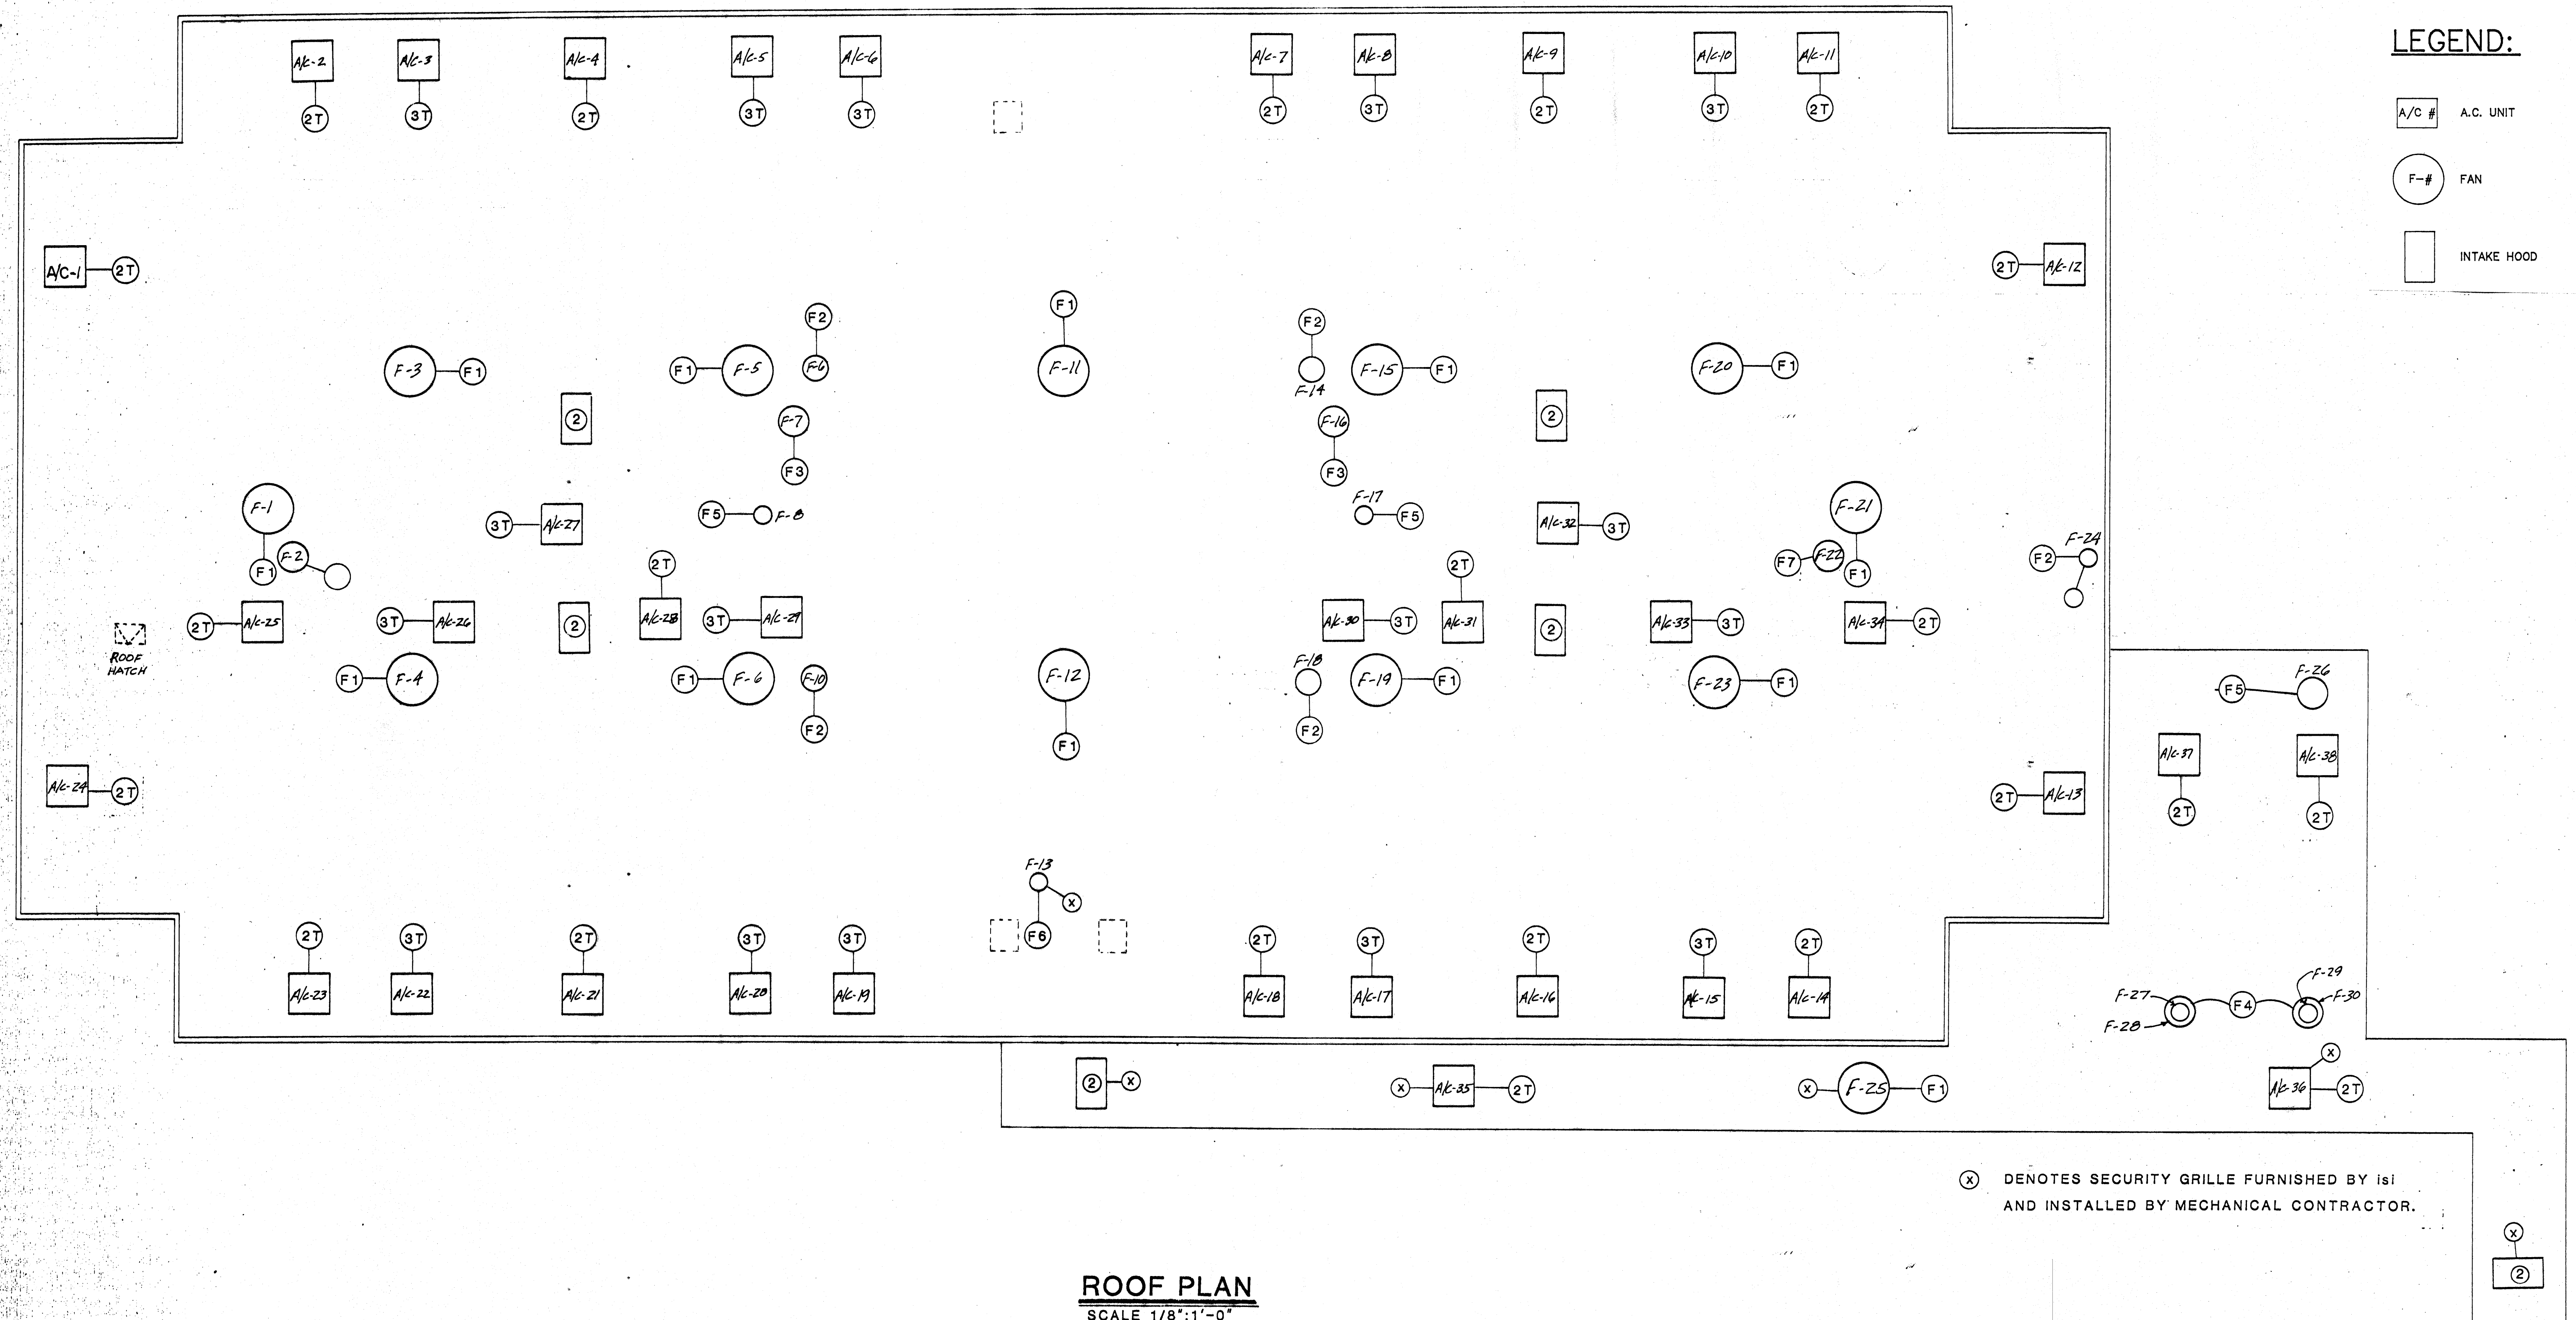


ROOF PLAN
SCALE 1/8"=1'-0"

FRANK M. BREWER & ASSOCIATES, INC.
Consulting Engineers
6030-P UNITY DRIVE
NORCROSS, GEORGIA 30071
(404) 447-5547

REV	DATE	DESCRIPTION	CHKD	APPR
1	12-27-90	AS-BUILT		

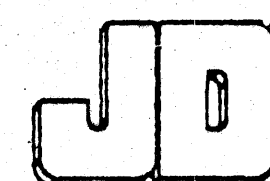

JAMES DELAUNE, JR.
AND ASSOCIATES, INC.
881 CENTERVILLE ST.
DENHAM SPRINGS, LA 70728
TELEPHONE:
(504) 864-8465

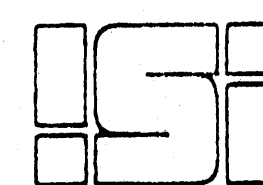

INTERNATIONAL SYSTEMS,
INC.
POST OFFICE DRAWER 1667
BROOKLEY INDUSTRIAL COMPLEX
MOBILE, ALA. 36601
(205) 432-3561

PROJECT NO.	DESIGNED
FILE NAME	DRAWN
DATE	CHECKED

MANATEE COUNTY STOCKADE
FACILITY EXPANSION
PALMETTO, FLORIDA

ROOF PLAN

M-4

SHEET NO. OF