

 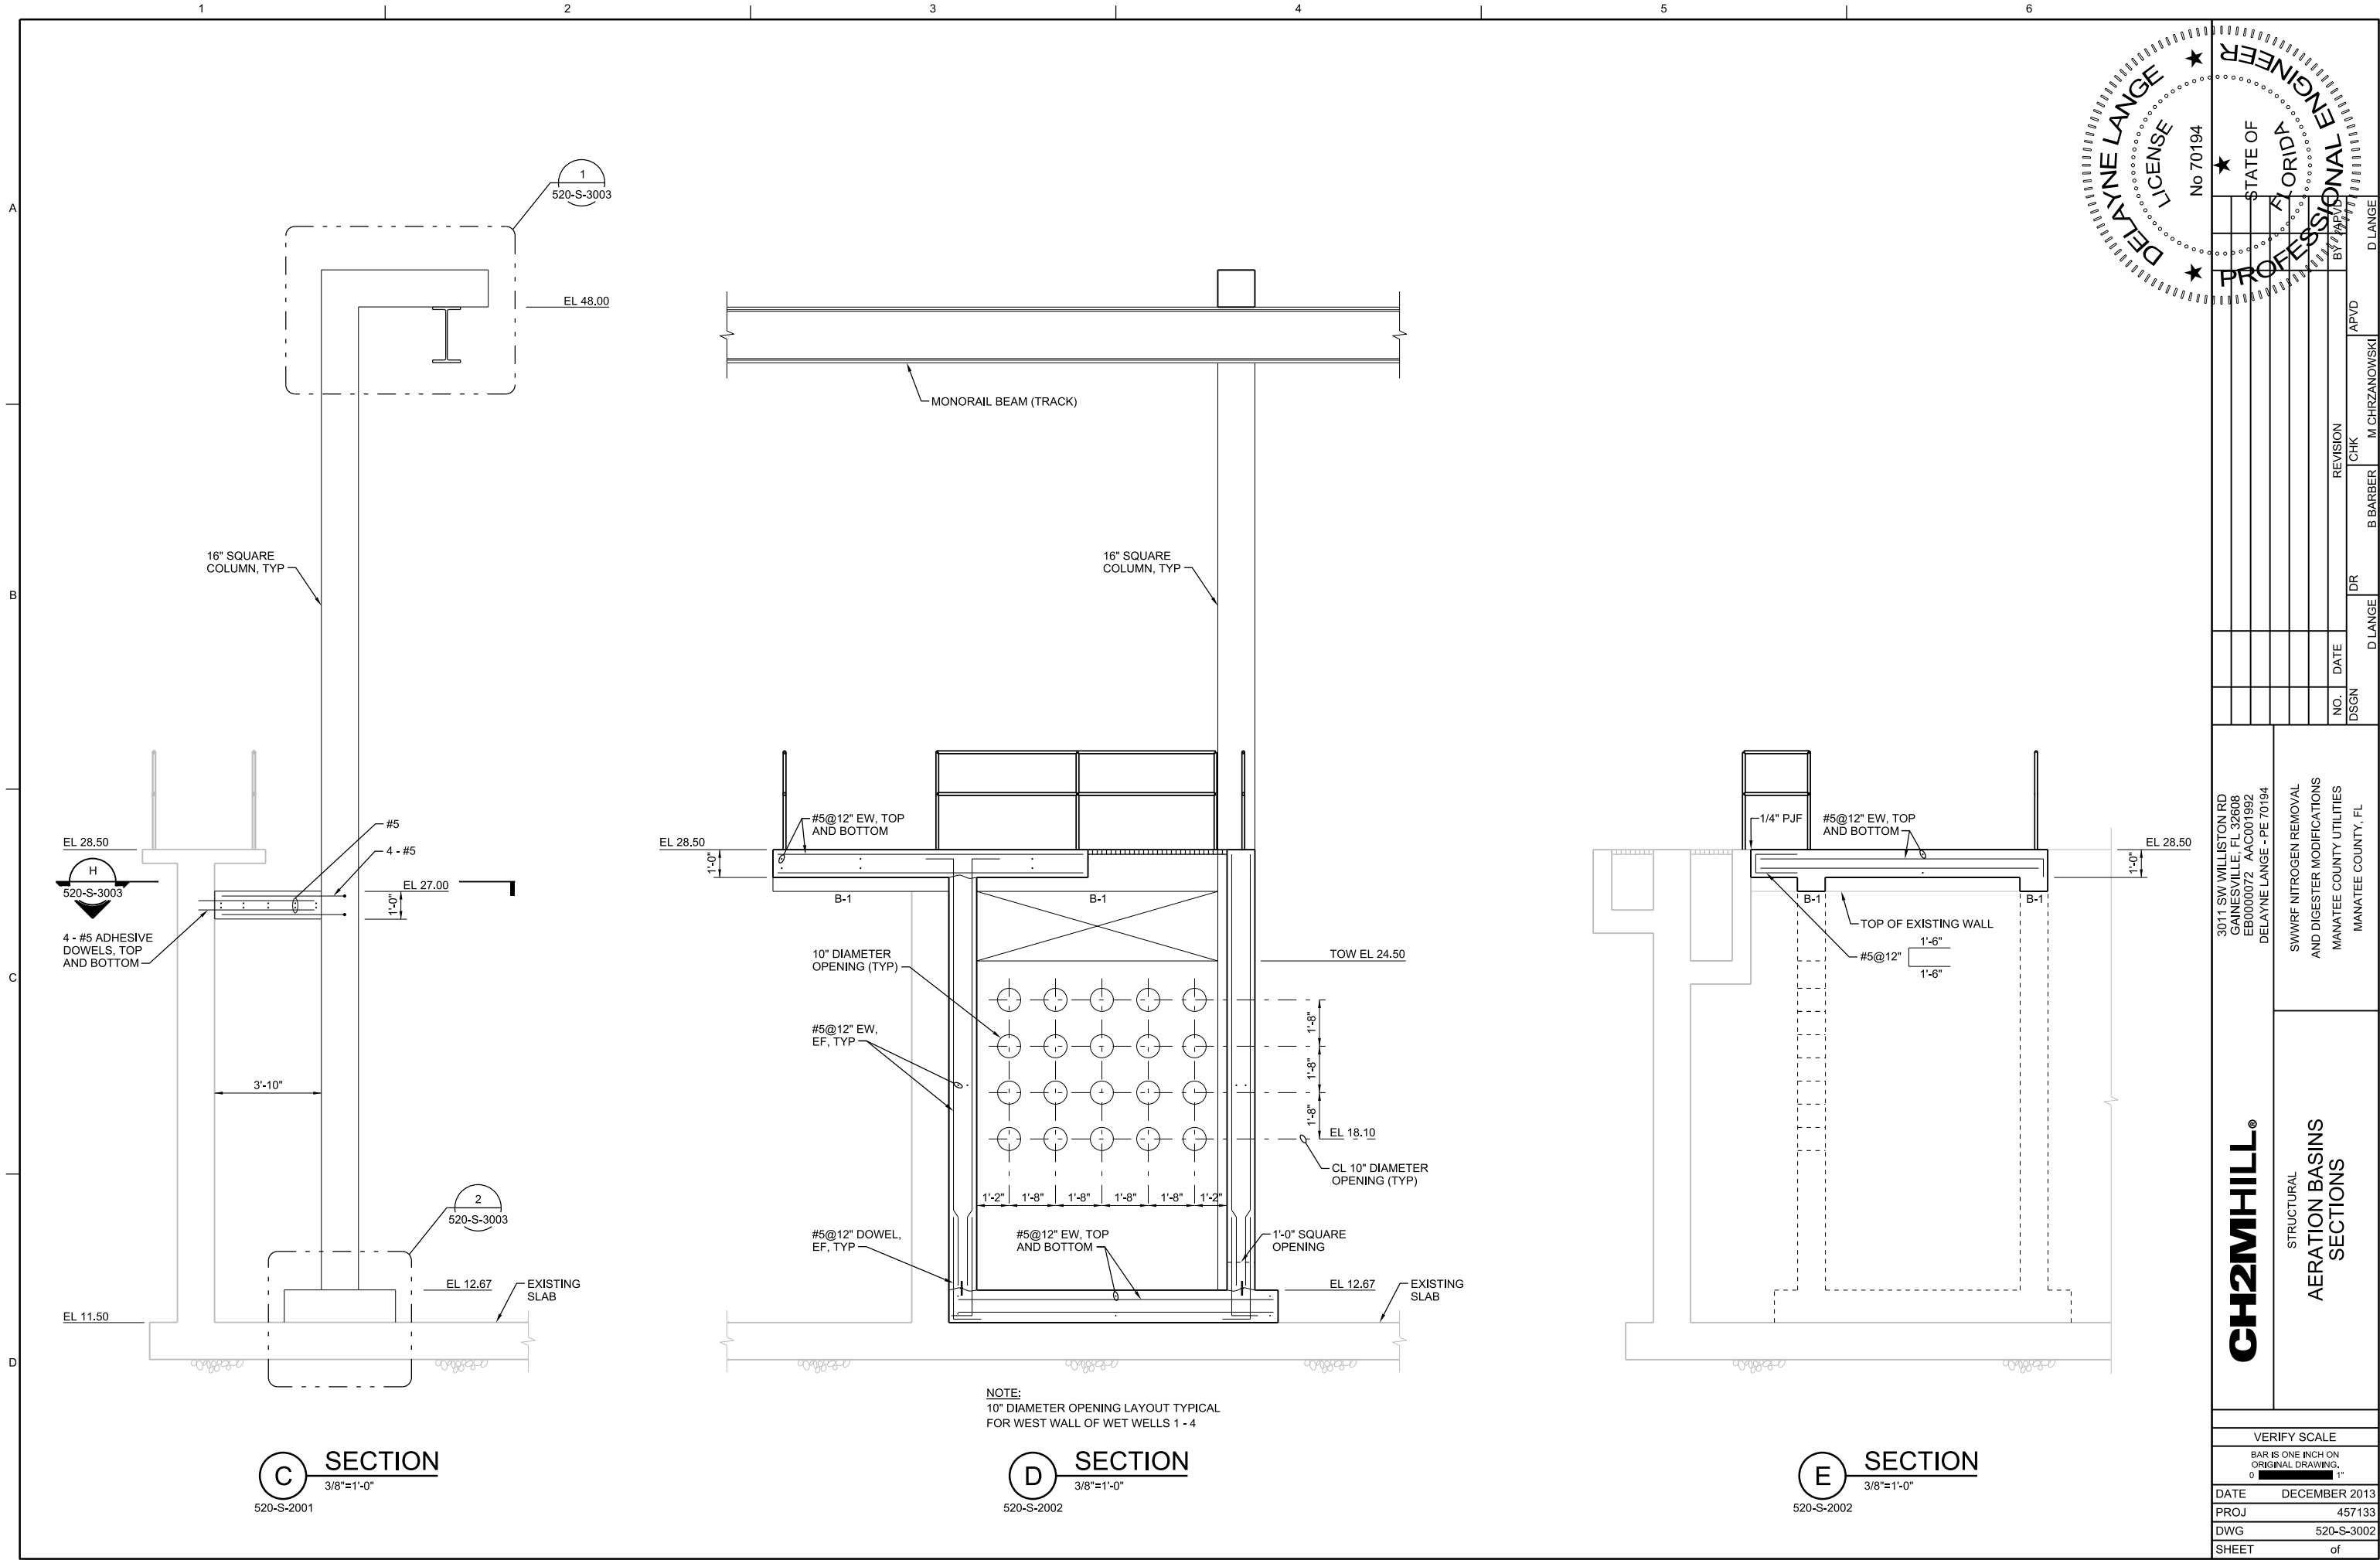
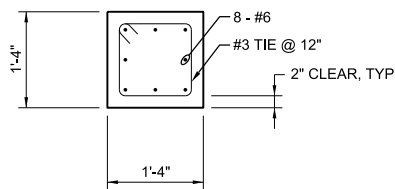


3011 SW WILLISTON RD GAINESVILLE, FL 32608 EB0000072 - AAC001982 DELAYNE LANGE - PE 70194		SWWRF NITROGEN REMOVAL AND DIGESTER MODIFICATIONS MANATEE COUNTY UTILITIES MANATEE COUNTY, FL	
CH2MHILL®		STRUCTURAL AERATION BASINS SECTIONS	
VERIFY SCALE BAR IS ONE INCH ON ORIGINAL DRAWING, 1"			
DATE		DECEMBER 2013	
PROJ		457133	
DWG		520-S-3002	
SHEET		of	
D LANGE		APVD	
B BARBER		CHK	
M CHRZANOWSKI		DR	
D LANGE		DSGN	
NO. DATE		REVISION	
BY		DATE	
PROFESSIONAL ENGINEER		STATE OF FLORIDA	
LICENSE		No 70194	
DELAYNE LANGE		★	





Technical drawing of a square column cross-section. The column is 4'-0" square and 11'-2" high. It features 8 #6 dowels, #3 tie bars at 12" intervals, and #5 bars at the top and bottom. The column is shown on an existing slab. Dimensions include 1'-0" typical height for the upper section and 6" for the lower section. The elevation is marked as EL 12.67.

2 DETAIL
3/4"=1'-0"
520-S-3002

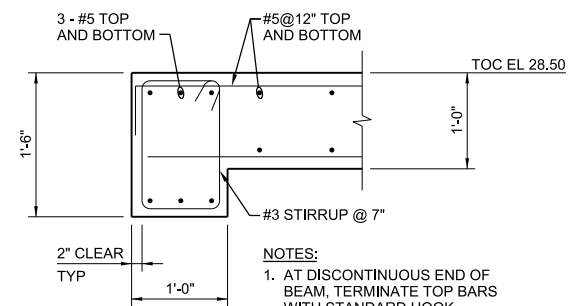

 G SECTION
1"=1'-0"
520-S-2002

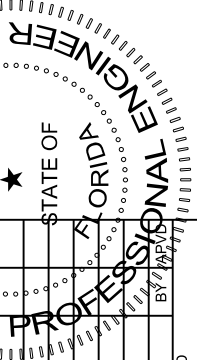



3011 SW WILLISTON RD GAINESVILLE, FL 32608 EB0000072 AAC001992 DELAUNE LANGE - PE 70194	SWWRF NITROGEN REMOVAL AND DIGESTER MODIFICATIONS MANATEE COUNTY UTILITIES MANATEE COUNTY, FL
--	--

CH2MHILL®

VERIFY SCALE BAR IS ONE INCH ON ORIGINAL DRAWING. 0  1"	
DATE	DECEMBER 20
PROJ	4571
DWG	520-S-30
SHEET	of


[illegible]

FILENAME: 520-S-3003_457133.dgn PLOT DATE: 12/13/2013 PLOT TIME: 2:15:44 PM

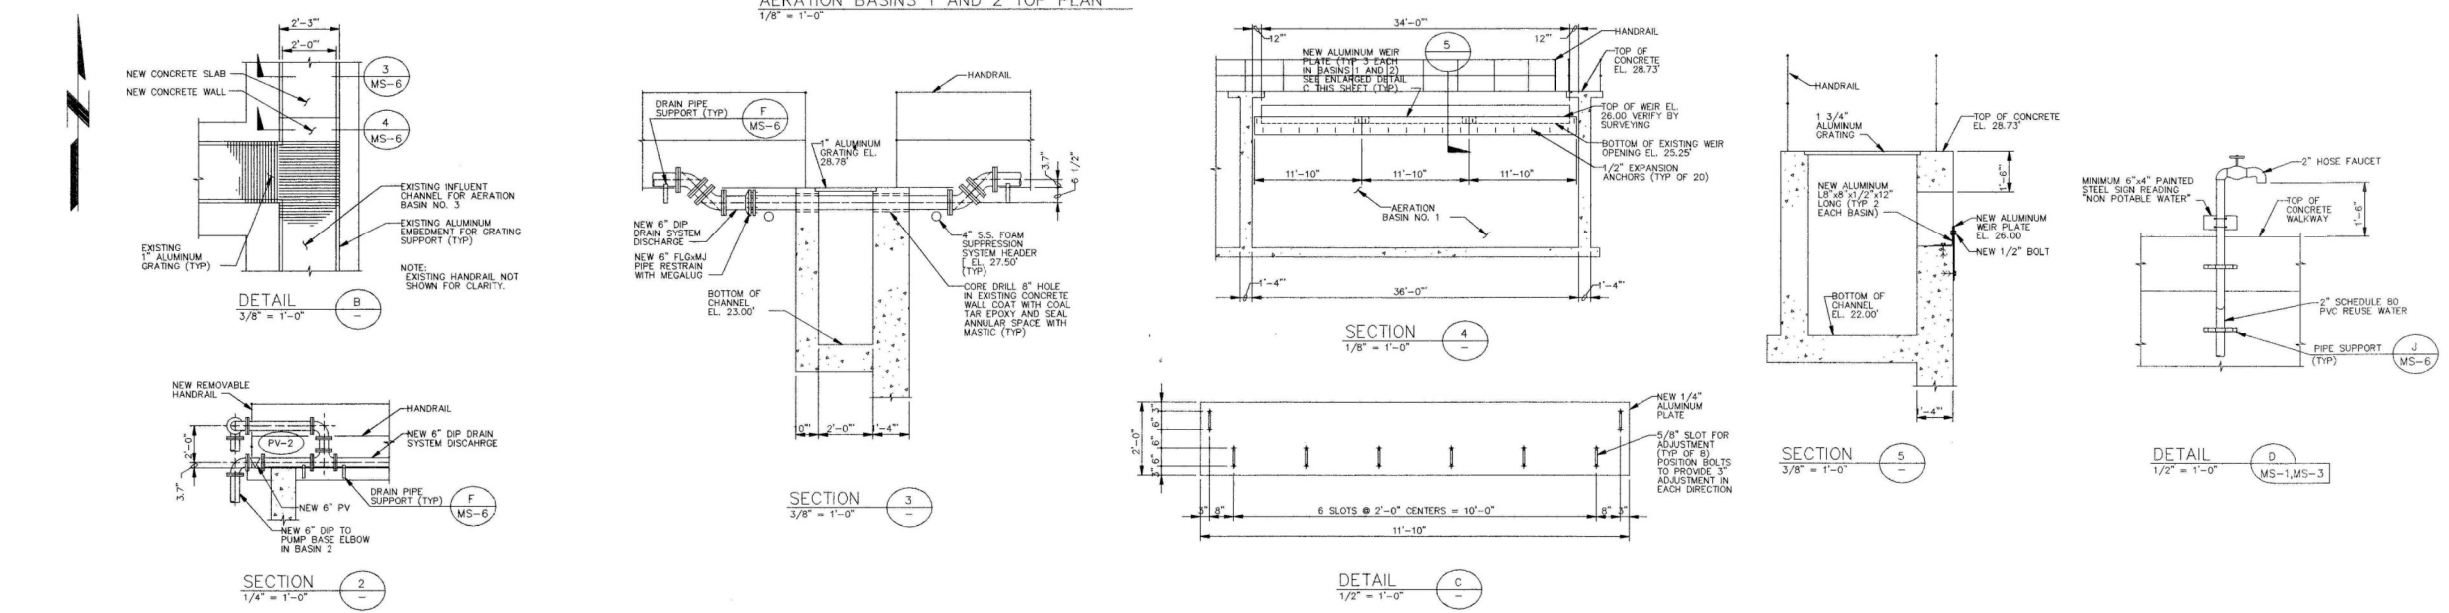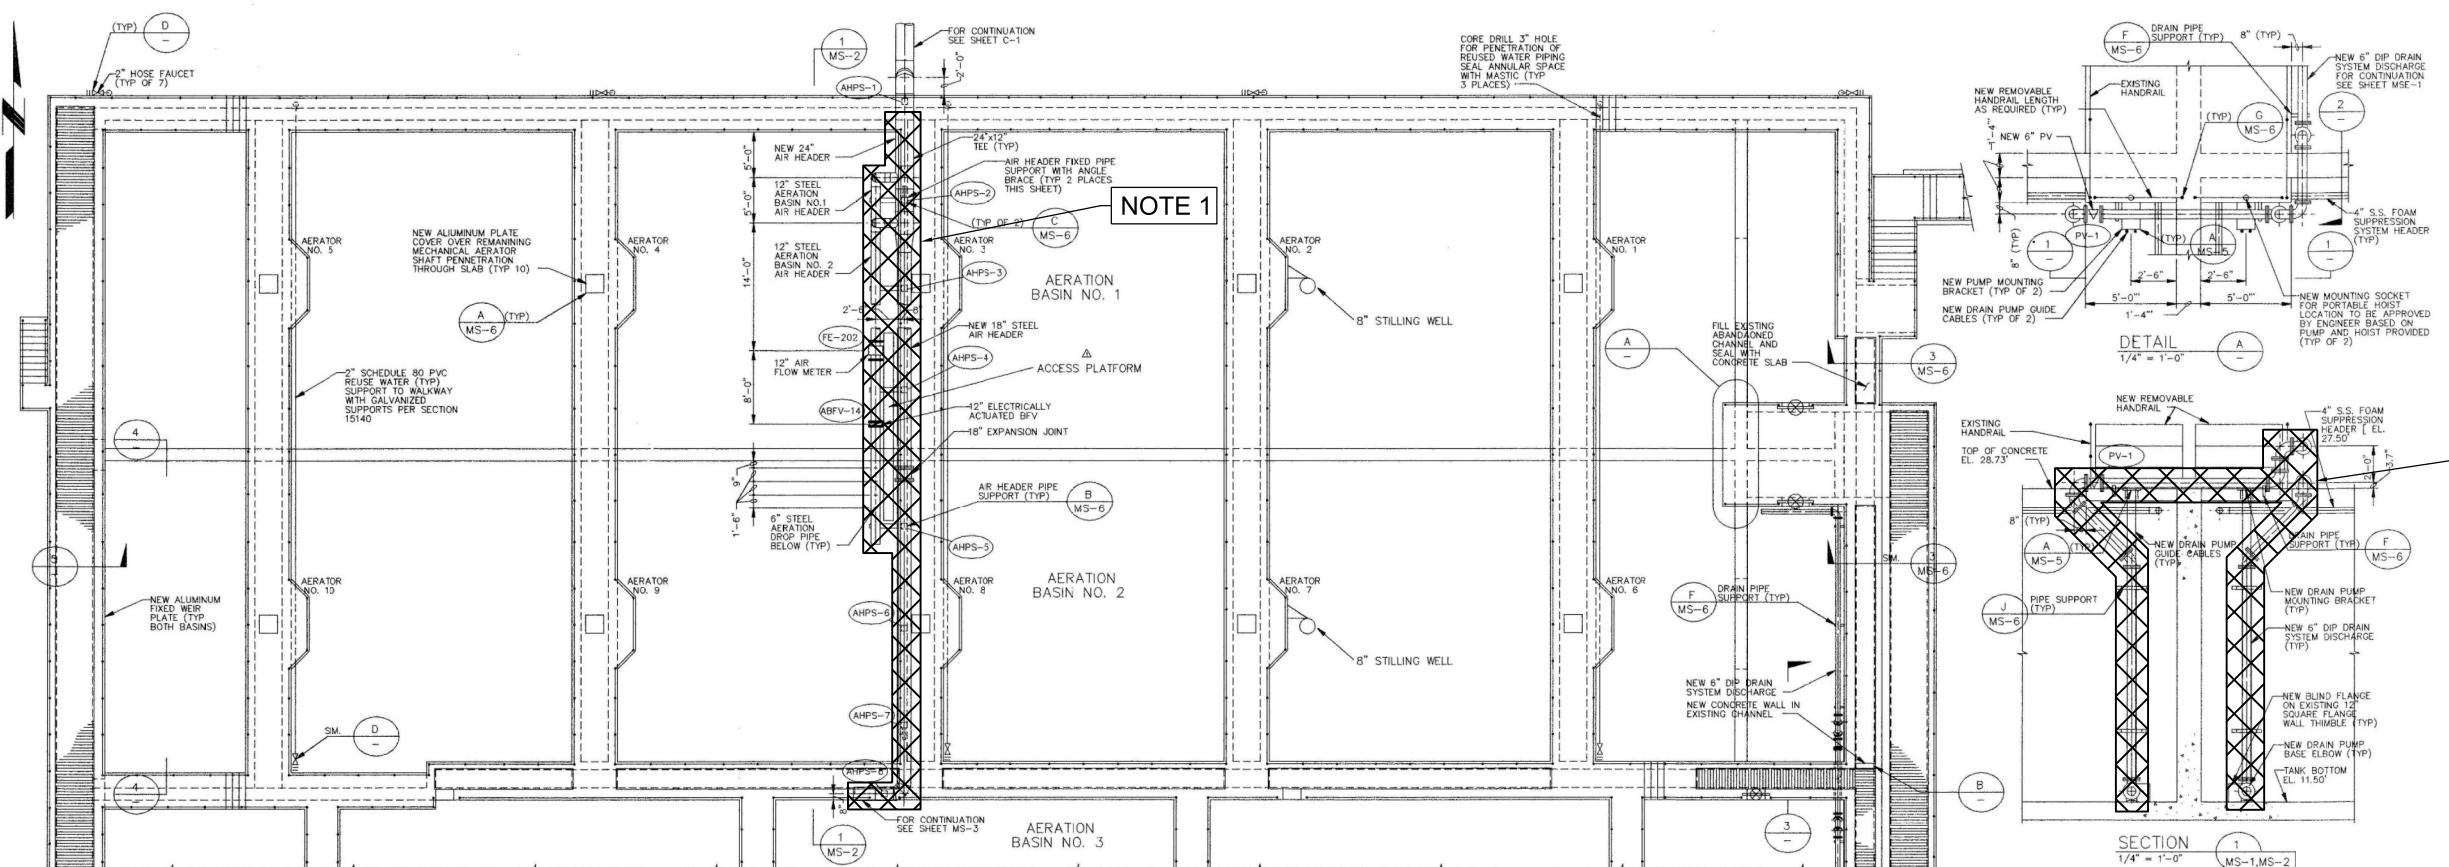


DEMOLITION PLAN & SECTIONS

- NOTES:
1. DEMOLISH AIR PIPING, VALVES, INSTRUMENTS, AND ASSOCIATED PIPE SUPPORTS DOWNSTREAM OF NEW 24"-V510. PLUG EXISTING 24" PIPE.
 2. DEMOLISH AERATION HEADERS

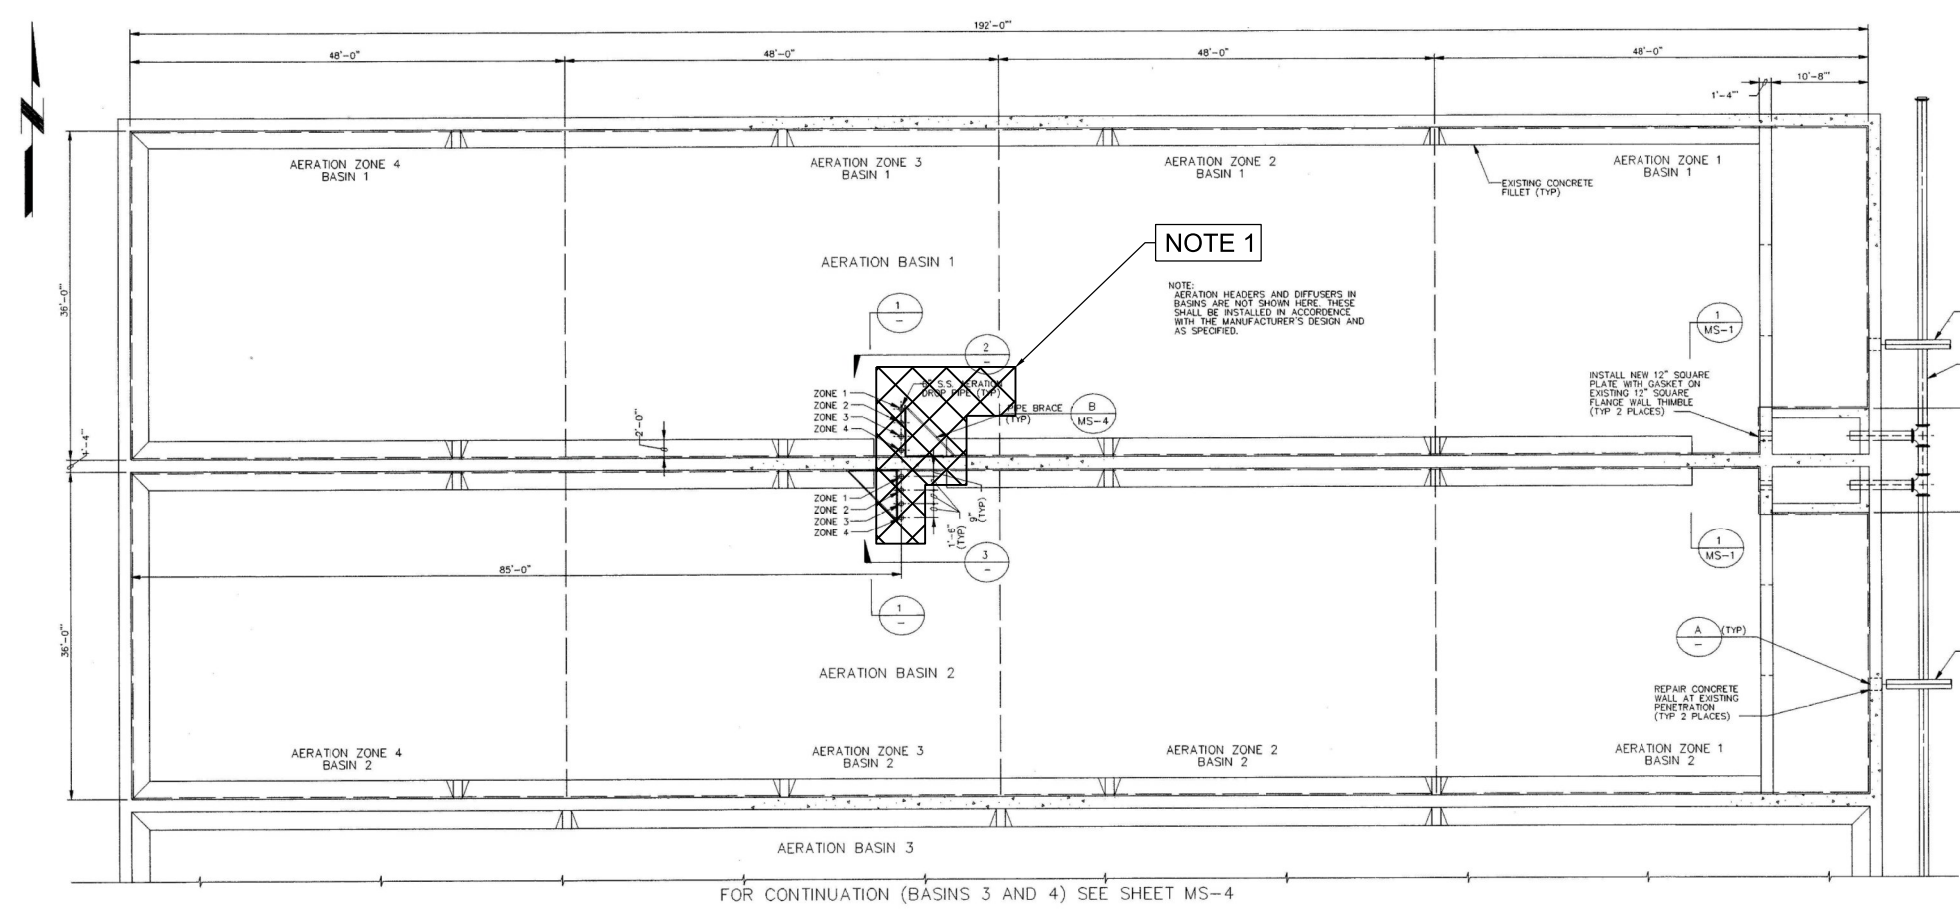


NOTE 1
AERATION HEADERS AND DIFFUSERS IN BASINS ARE NOT SHOWN HERE. THESE SHALL BE INSTALLED IN ACCORDANCE WITH THE MANUFACTURER'S DESIGN AND AS SPECIFIED.

AERATION BASINS 1 AND 2 SECTIONAL PLAN
1/8" = 1'-0"

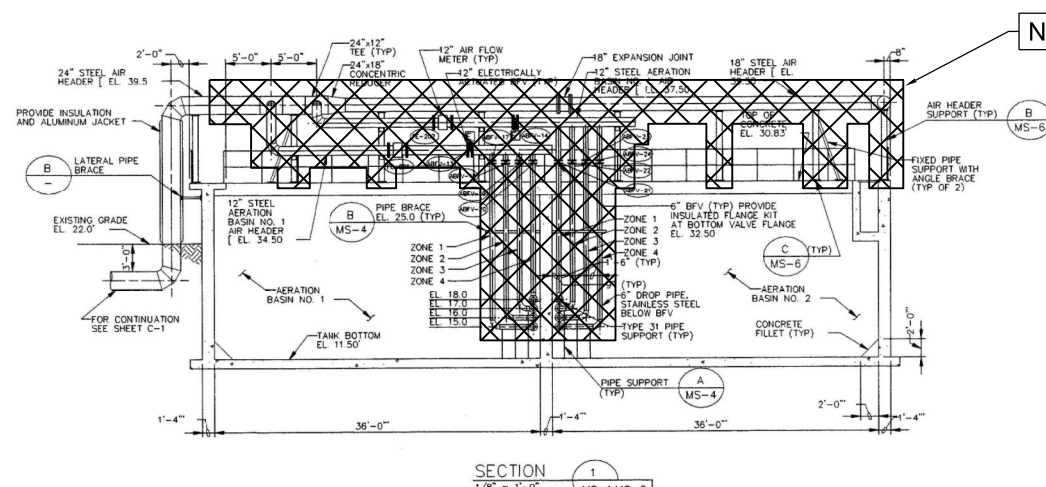


NOTE 1


SECTION 1
1/8" = 1'-0"

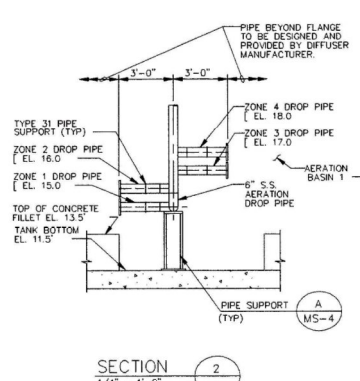

SECTION 2
1/4" = 1'-0"

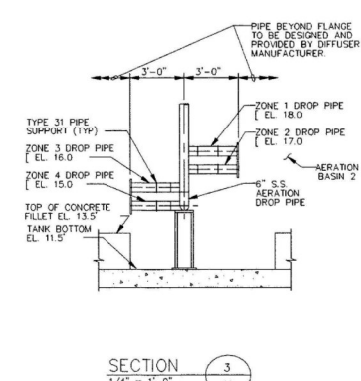

SECTION 3
1/4" = 1'-0"

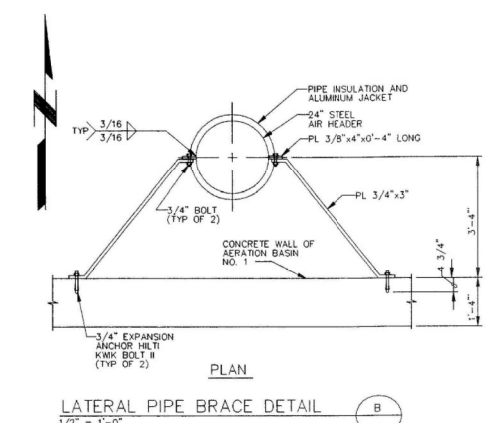

LATERAL PIPE BRACE DETAIL
1/2" = 1'-0"


DETAIL A
NO SCALE

NOTES:

- DEMOLISH AIR PIPING, VALVES, INSTRUMENTS, AND ASSOCIATED PIPE SUPPORTS DOWNSTREAM OF NEW 24"-V510. PLUG EXISTING 24" PIPE.
- DEMOLISH AERATION HEADERS AND DIFFUSERS AND THEIR SUPPORTS IN ALL FOUR BASINS. (NOT SHOWN ON DRAWINGS)
- REMOVE ALL CONCRETE ANCHORS AND EMBEDDED ITEMS TO 2" BELOW CONCRETE SURFACE. REFER TO DETAIL

0330-143

DEMOLITION PLAN & SECTIONS
NTS

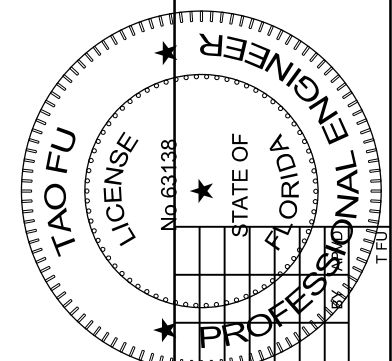

3011 SW WILLISTON RD
GAINESVILLE, FL 32608
EB0000072 AAC001992
TAO FU - PE 63138






SWWRF NITROGEN REMOVAL
AND DIGESTER MODIFICATIONS
MANATEE COUNTY UTILITIES
MANATEE COUNTY, FL

DEMOLITION
AERATION BASINS 1 & 2
LOWER PLAN AND SECTIONS

VERIFY SCALE
BAR IS ONE INCH ON ORIGINAL DRAWING, 1" = 1'
DATE DECEMBER 2013
PROJ 457133
DWG 520-D-1002
SHEET of

1 2 3 4 5 6

FOR CONTINUATION (BASINS 1 AND 2) SEE SHEET MS-1

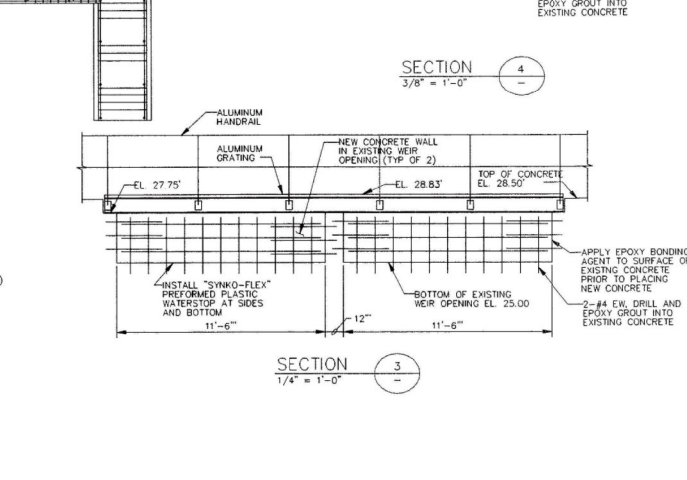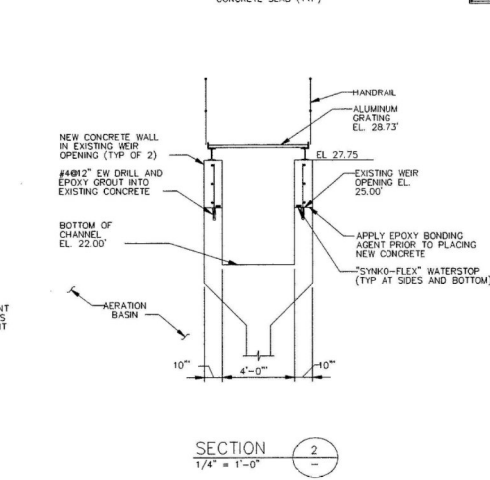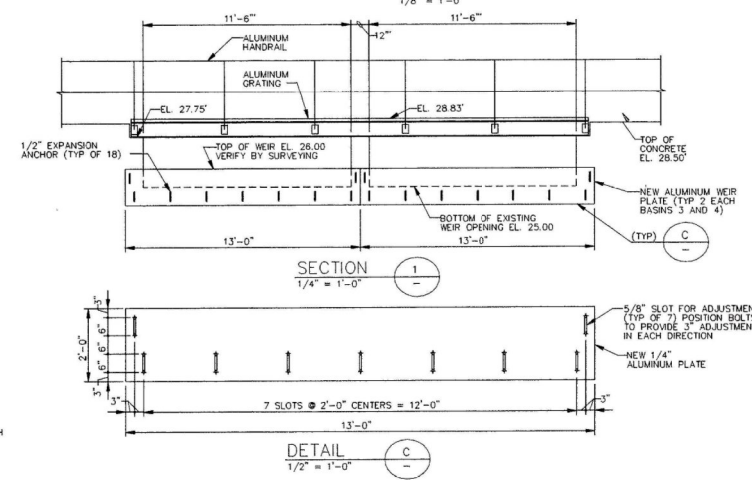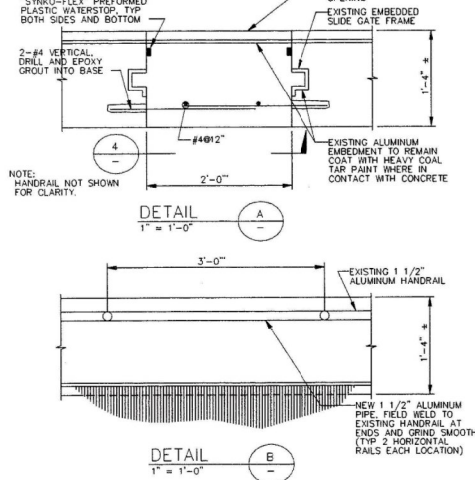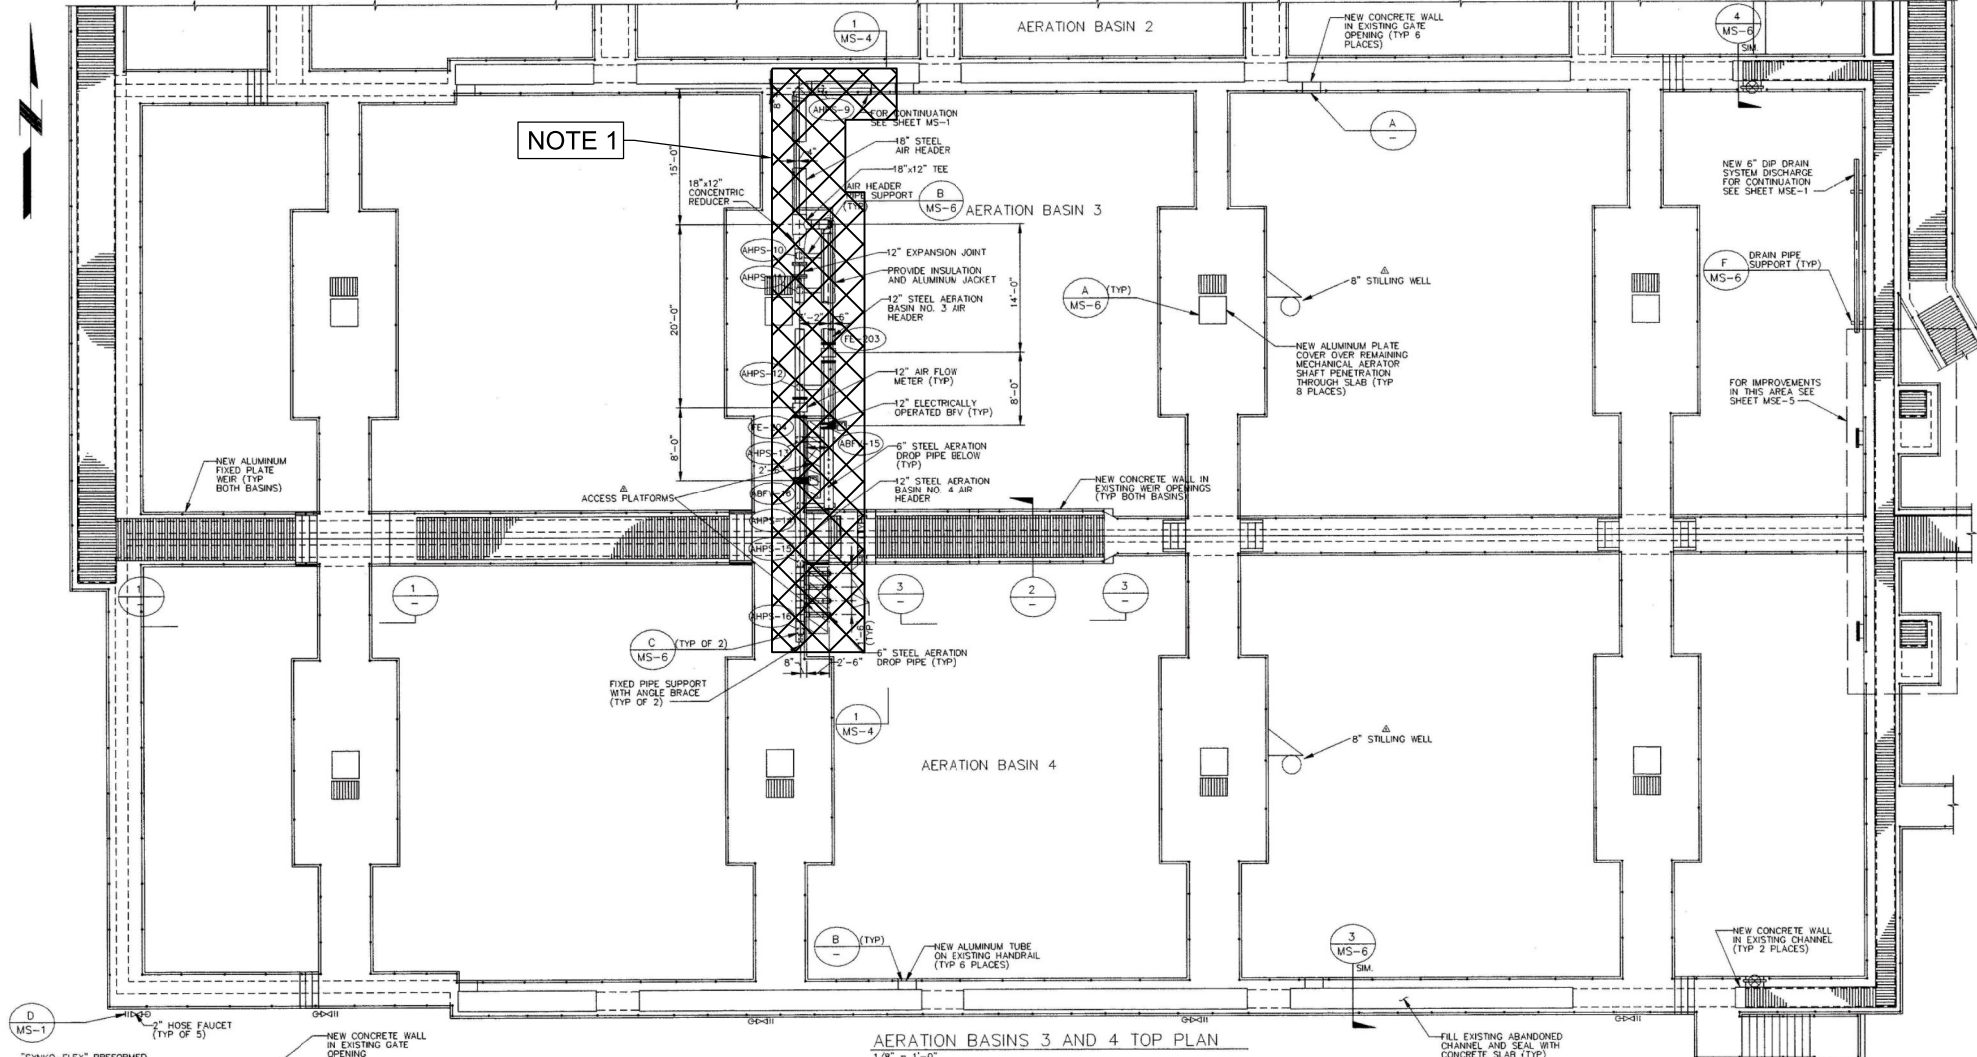


NOTES:

1. DEMOLISH AIR PIPING, VALVES, INSTRUMENTS, AND ASSOCIATED PIPE SUPPORTS DOWNSTREAM OF NEW 24"-V510. PLUG EXISTING 24" PIPE.
2. DEMOLISH AERATION HEADERS AND DIFFUSERS AND THEIR SUPPORTS IN ALL FOUR BASINS. (NOT SHOWN ON DRAWINGS)
3. REMOVE ALL CONCRETE ANCHORS AND EMBEDDED ITEMS TO 2" BELOW CONCRETE SURFACE. REFER TO DETAIL

DEMOLITION PLAN & SECTIONS

NTS

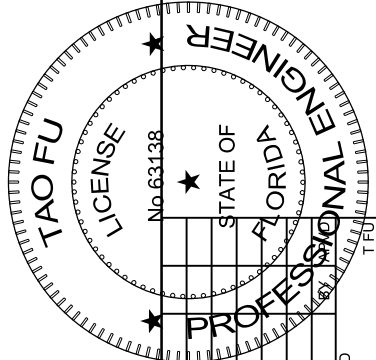

3011 SW WILLISTON RD
GAINESVILLE, FL 32608
EB0000072 AAC001992
TAO FU - PE 63138

SWWRF NITROGEN REMOVAL
AND DIGESTER MODIFICATIONS
MANATEE COUNTY UTILITIES
MANATEE COUNTY, FL

DEMOLITION
AERATION BASINS 3 & 4
UPPER PLAN AND SECTIONS



VERIFY SCALE	
BAR IS ONE INCH ON ORIGINAL DRAWING, 1" = 1'	
DATE	DECEMBER 2013
PROJ	457133
DWG	520-D-1003
SHEET	of

0330-143


ISSUED FOR BID

THIS DOCUMENT, AND THE IDEAS AND DESIGNS INCORPORATED HEREIN, IS THE PROPERTY OF CH2M HILL AND IS NOT TO BE USED, IN WHOLE OR IN PART, FOR ANY OTHER PROJECT WITHOUT THE WRITTEN AUTHORIZATION OF CH2M HILL. © CH2M HILL 2012. ALL RIGHTS RESERVED.


FOR CONTINUATION (BASINS 1 AND 2) SEE SHEET MS-2

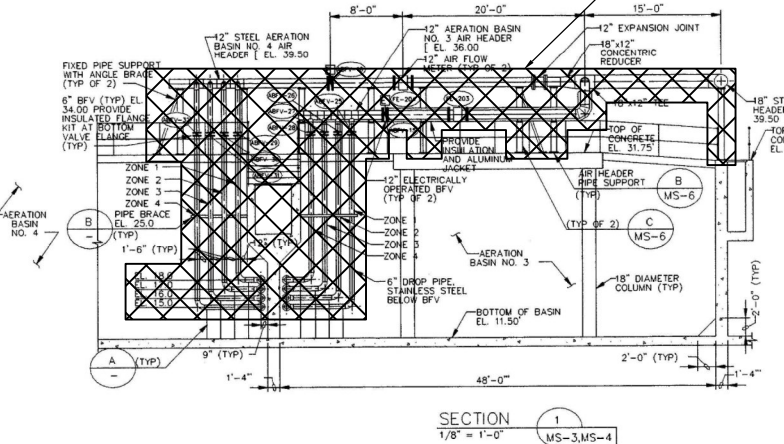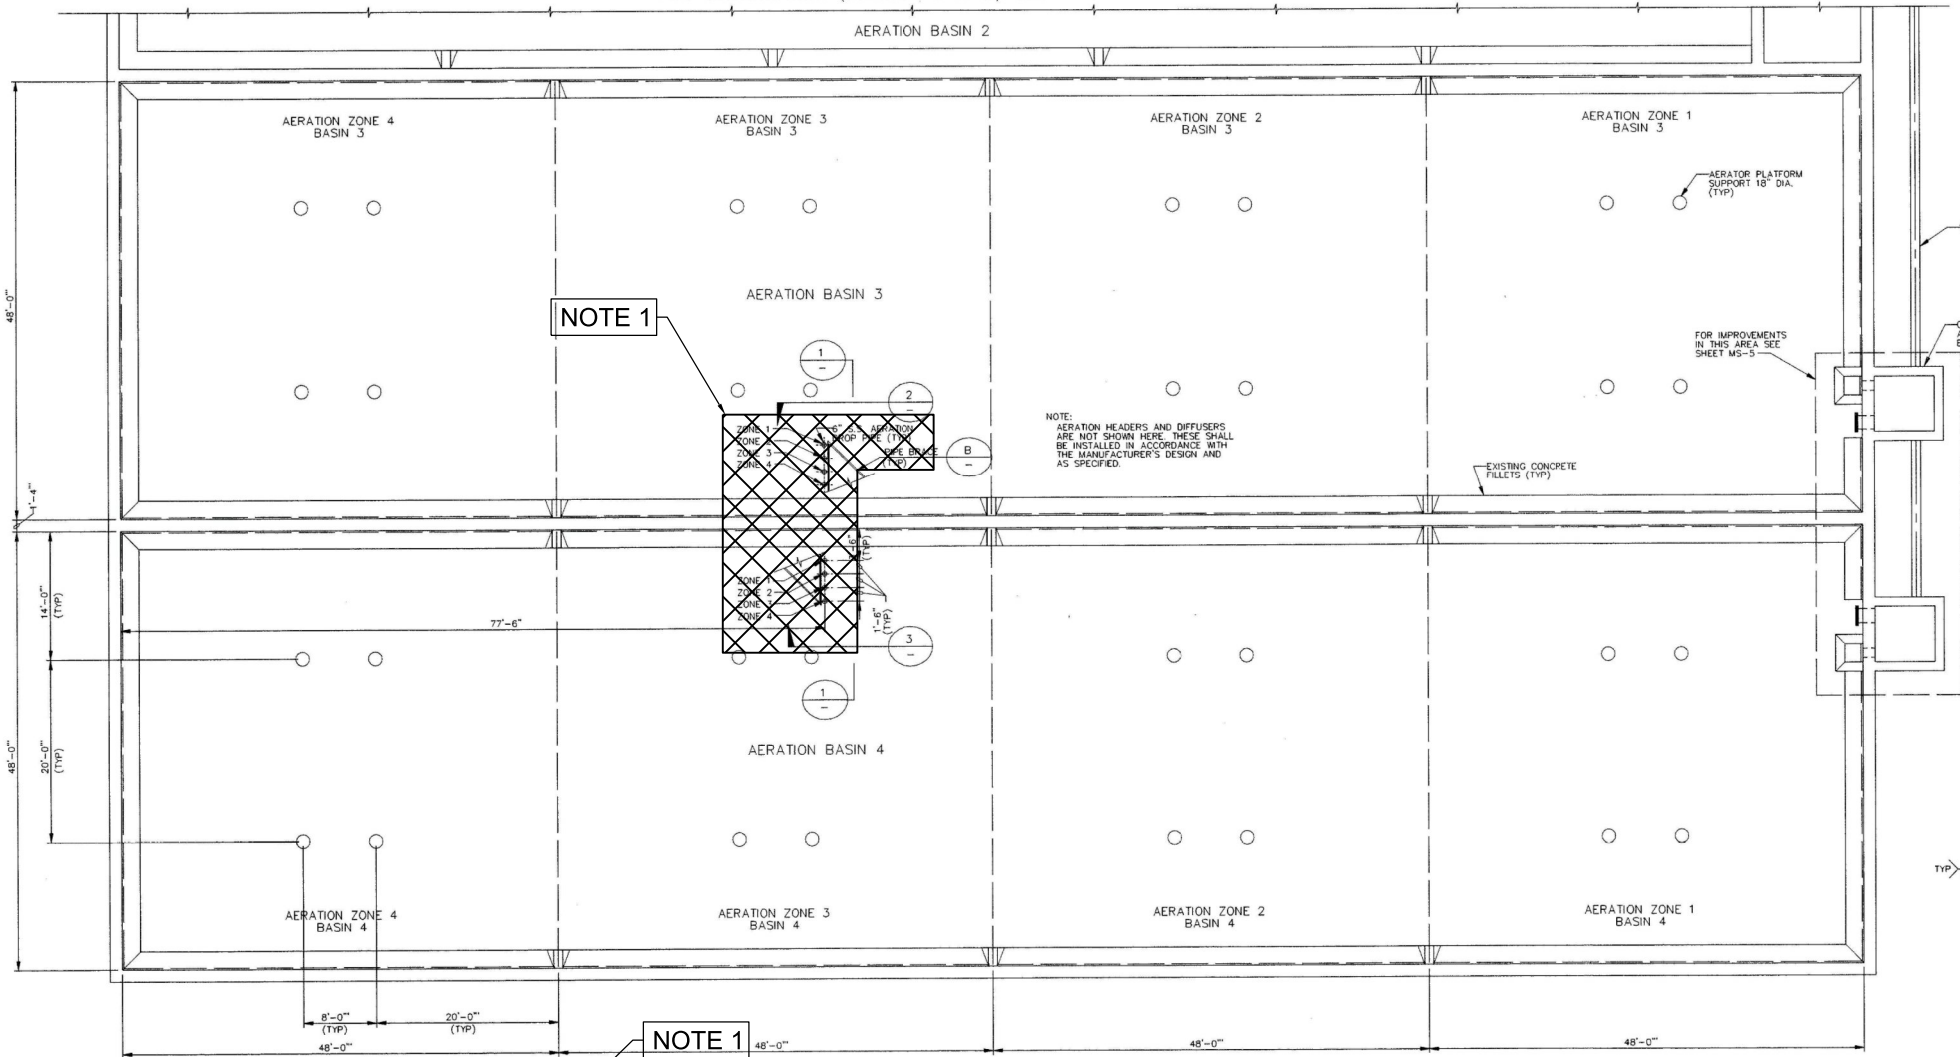



AERATION BASINS 3 AND 4
SECTIONAL PLAN
1/8" = 1'-0"

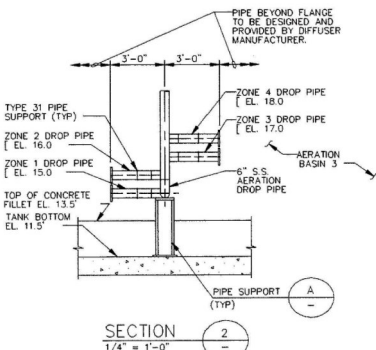

SECTION 2
1/4" = 1'-0"

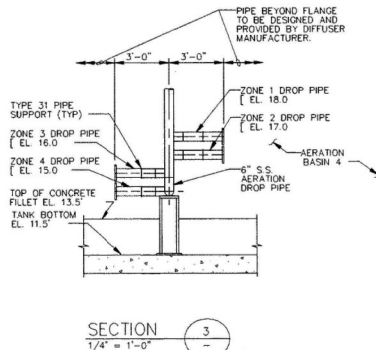


SECTION 3
1/4" = 1'-0"

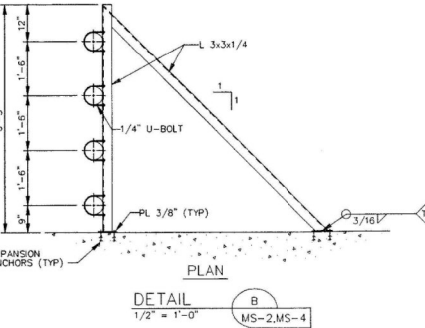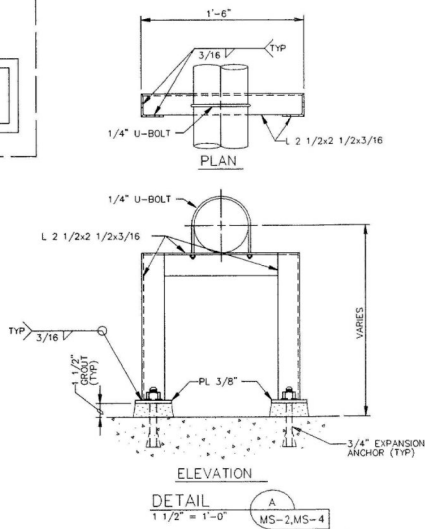

- NOTES:
1. DEMOLISH AIR PIPING, VALVES, INSTRUMENTS, AND ASSOCIATED PIPE SUPPORTS DOWNSTREAM OF NEW 24"-V510. PLUG EXISTING 24" PIPE.
 2. DEMOLISH AERATION HEADERS AND DIFFUSERS AND THEIR SUPPORTS IN ALL FOUR BASINS. (NOT SHOWN ON DRAWINGS)
 3. REMOVE ALL CONCRETE ANCHORS AND EMBEDDED ITEMS TO 2" BELOW CONCRETE SURFACE. REFER TO DETAIL (0330-143)

DEMOLITION PLAN & SECTIONS
NTS

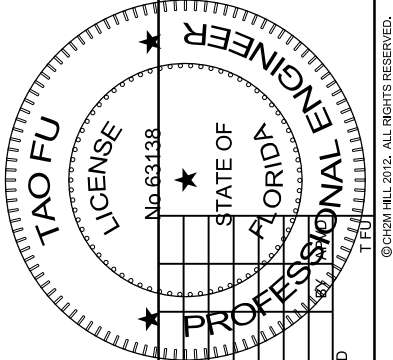


3011 SW WILLISTON RD
GAINESVILLE, FL 32608
EB0000072 - AAC001992
TAO FU - PE 63138

SWWRF NITROGEN REMOVAL
AND DIGESTER MODIFICATIONS
MANATEE COUNTY UTILITIES
MANATEE COUNTY, FL


DEMOLITION
AERATION BASINS 3 & 4
LOWER PLAN AND SECTIONS

VERIFY SCALE	
BAR IS ONE INCH ON ORIGINAL DRAWING.	
DATE	DECEMBER 2013
PROJ	457133
DWG	520-D-1004
SHEET	of

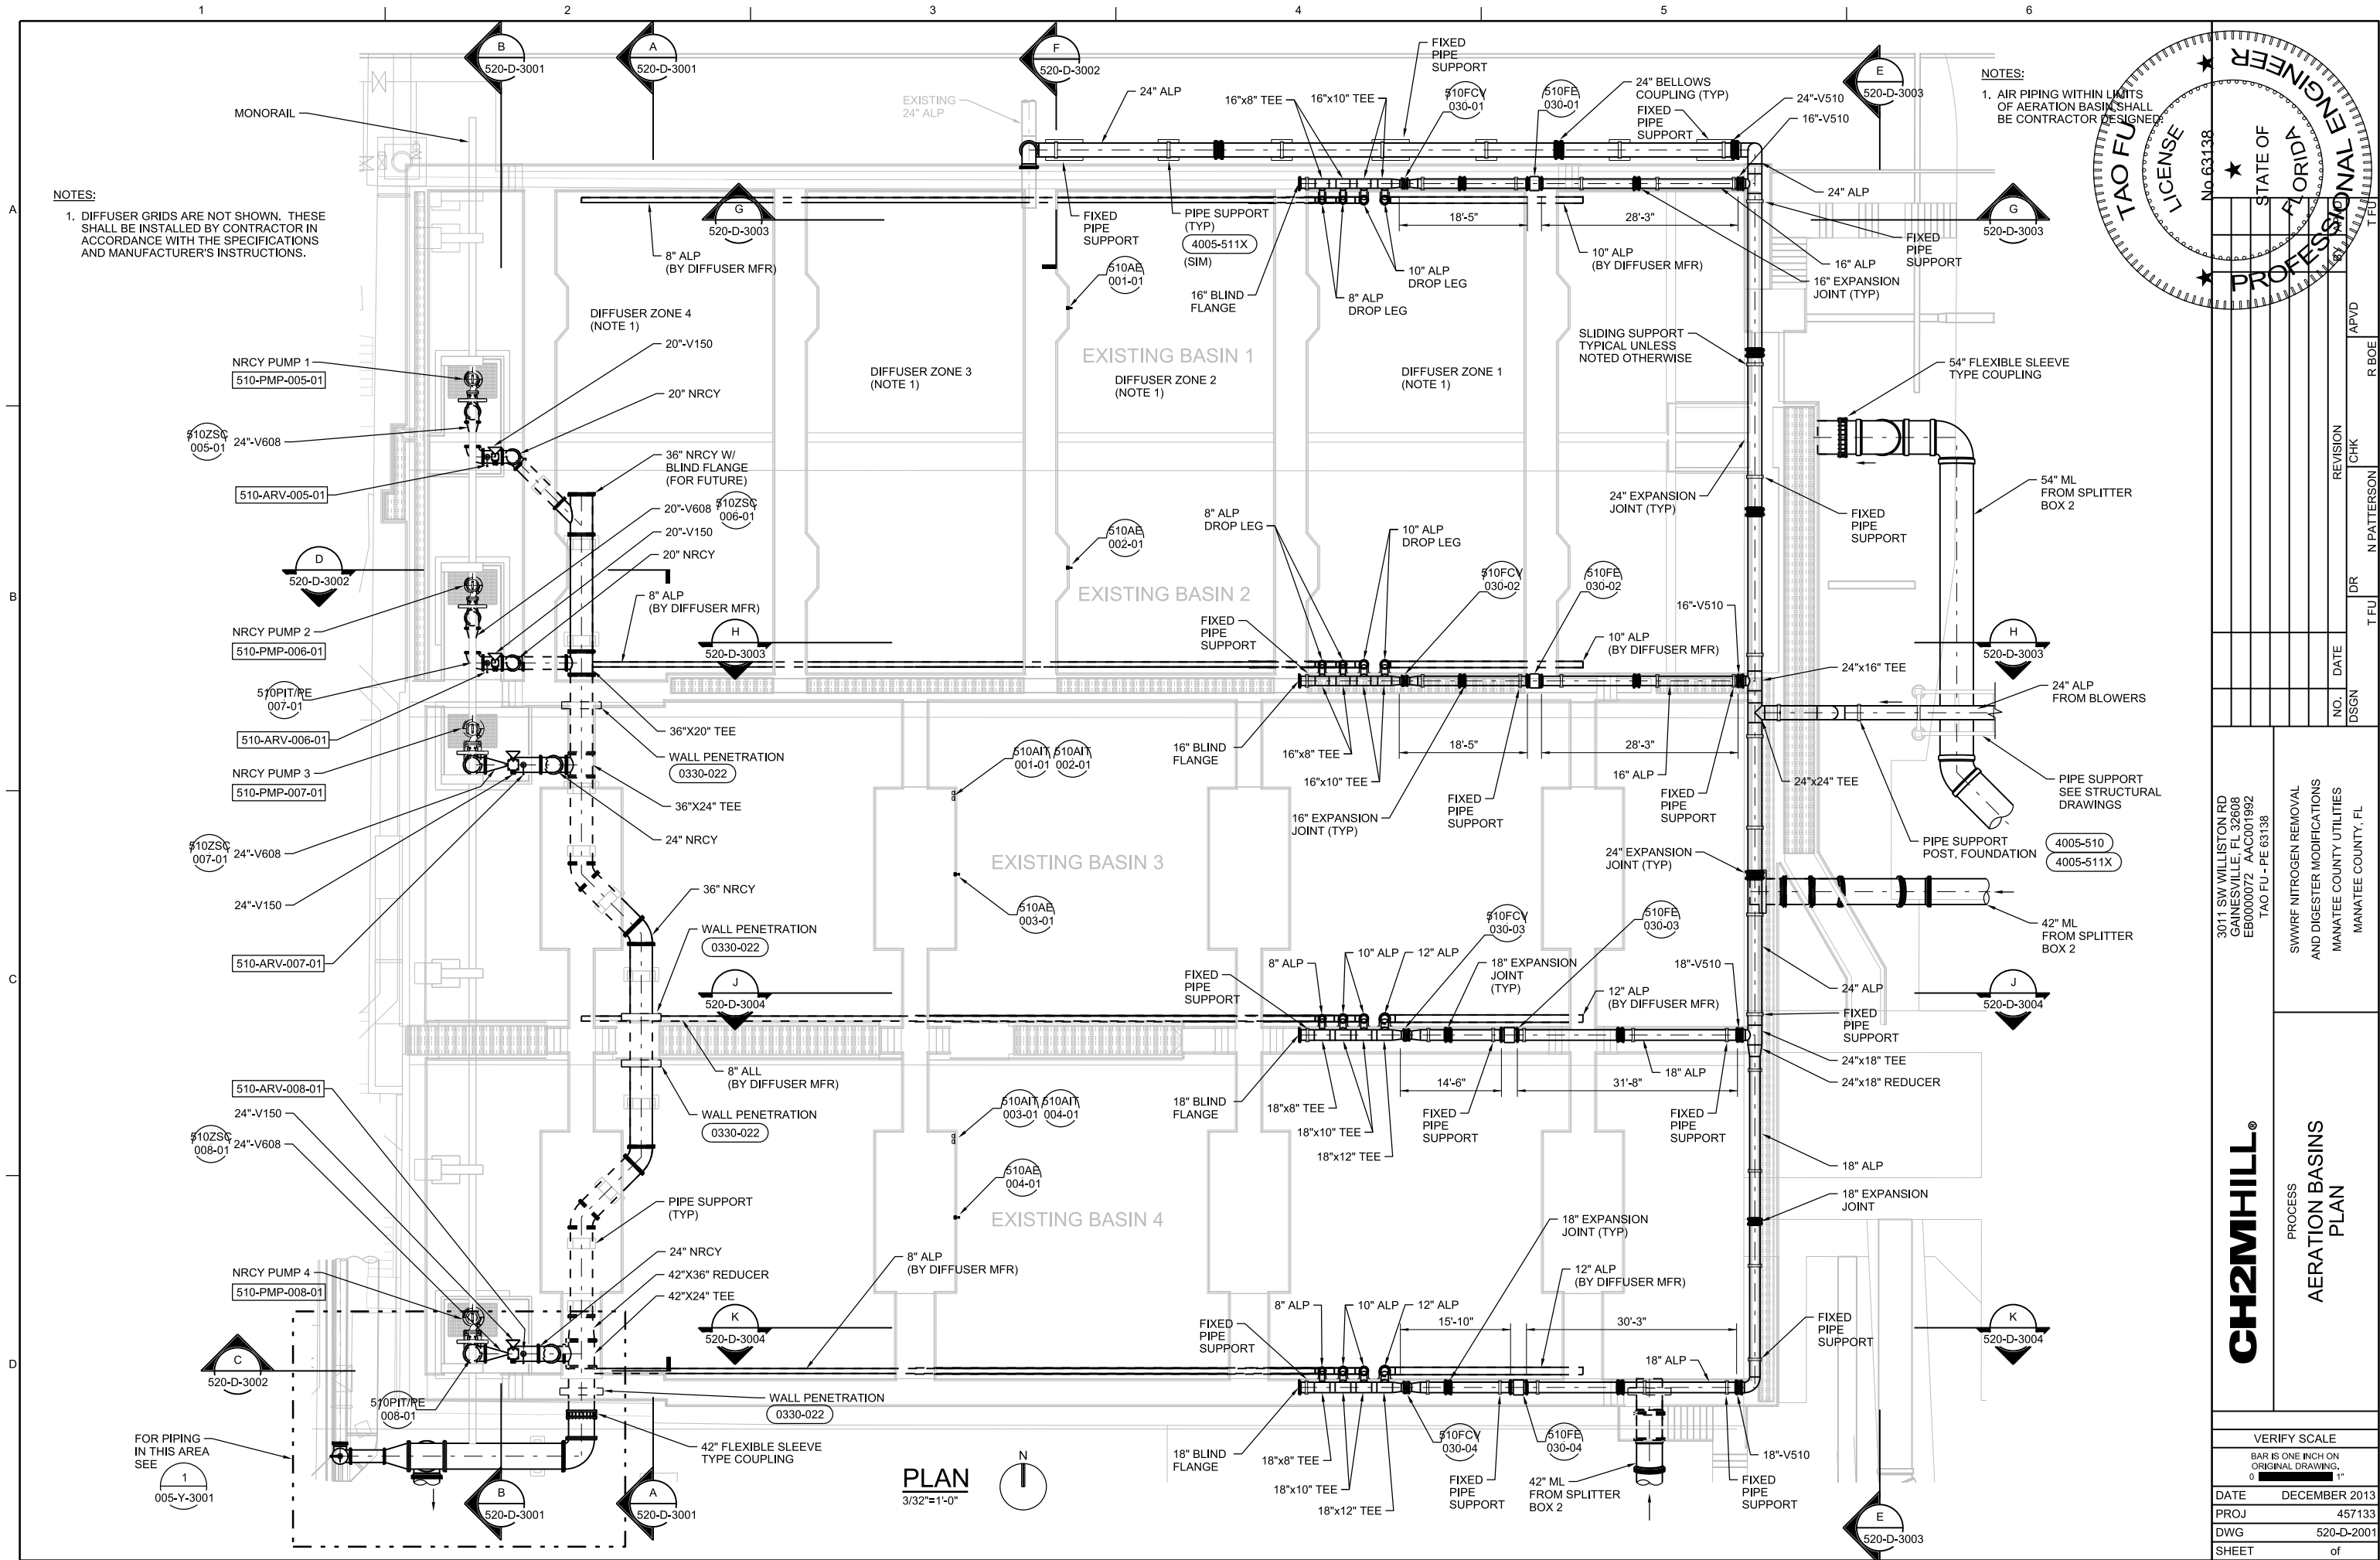

NOTES:
1. DIFFUSER GRIDS ARE NOT SHOWN. THESE SHALL BE INSTALLED BY CONTRACTOR IN ACCORDANCE WITH THE SPECIFICATIONS AND MANUFACTURER'S INSTRUCTIONS.

NOTES:
1. AIR PIPING WITHIN LIMITS OF AERATION BASIN SHALL BE CONTRACTOR DESIGNED.

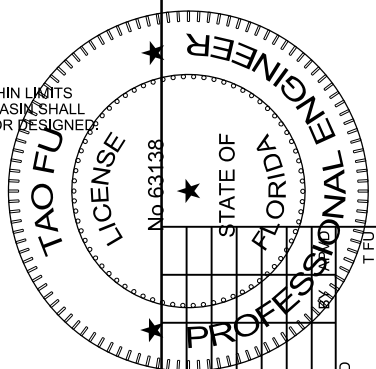


3011 SW WILLISTON RD
GAINESVILLE, FL 32608
EB0000072 AAC001992
TAO FU - PE 63138


CH2MHILL®
PROCESS
AERATION BASINS
PLAN

VERIFY SCALE	
BAR IS ONE INCH ON ORIGINAL DRAWING, 1" = 30'-0"	
DATE	DECEMBER 2013
PROJ	457133
DWG	520-D-2001
SHEET	of

ISSUED FOR BID

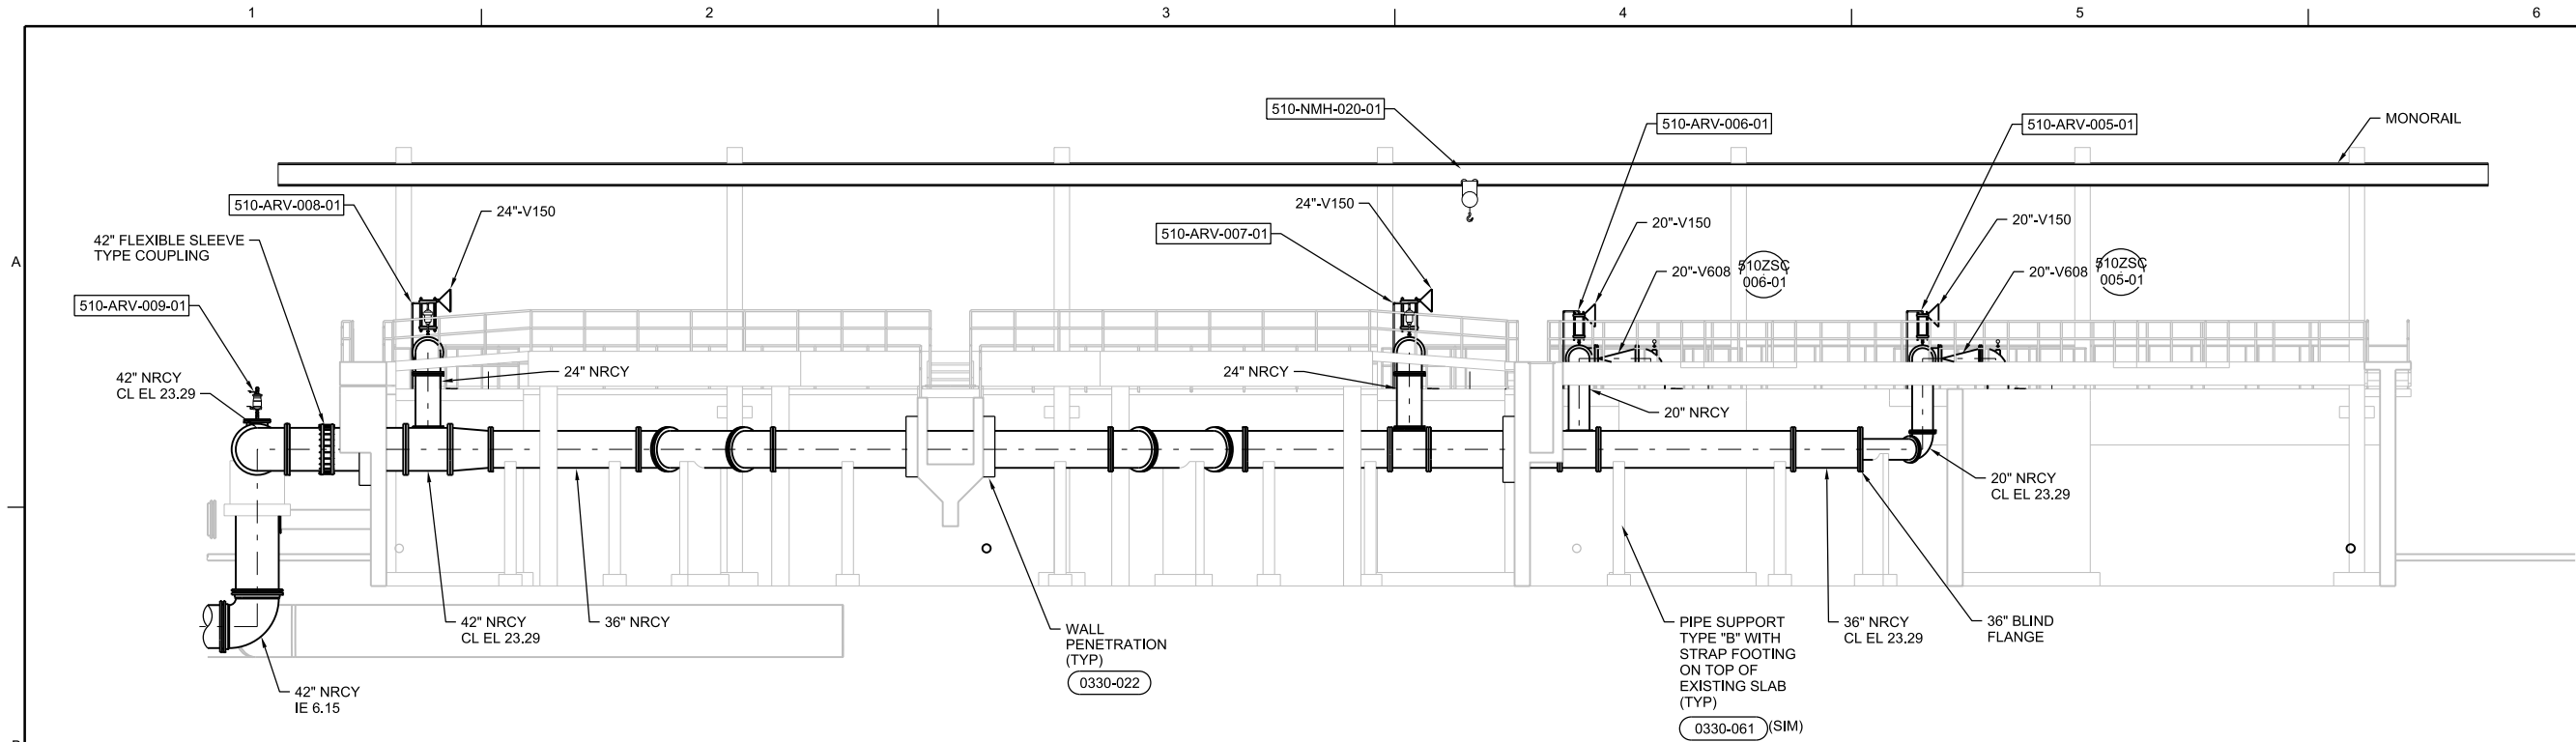


A SECTION
1/8"=1'-0"
520-D-2001

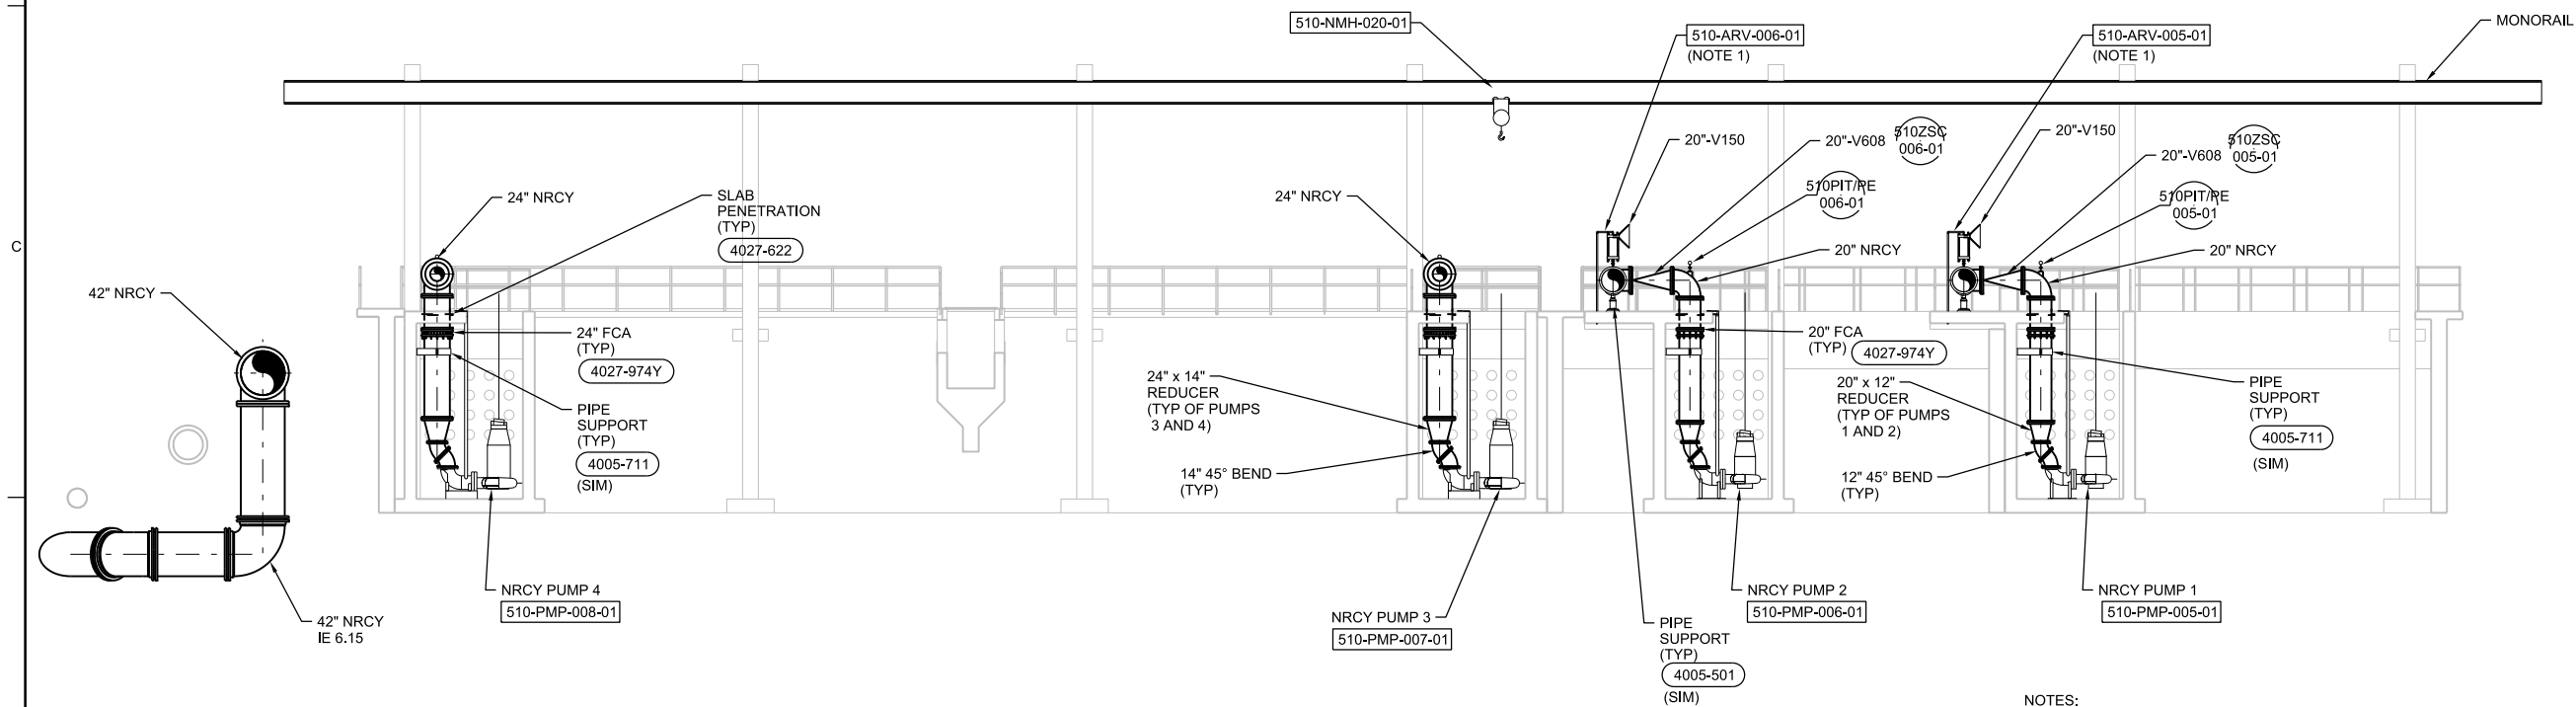

B SECTION
1/8"=1'-0"
520-D-2001

NOTES:
1. CONTRACTOR TO ROUTE ARV DISCHARGE LINE BACK INTO BASIN.

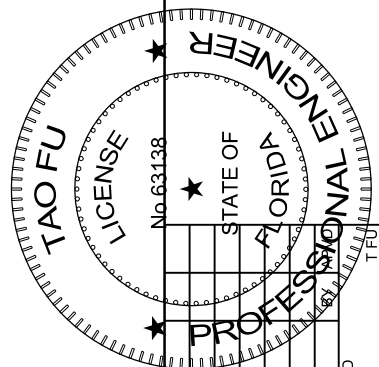


3011 SW WILLISTON RD
GAINESVILLE, FL 32608
EB0000072 AAC001992
TAO FU - PE 63138

SWWRF NITROGEN REMOVAL
AND DIGESTER MODIFICATIONS
MANATEE COUNTY UTILITIES
MANATEE COUNTY, FL

CH2MHILL®

PROCESS
AERATION BASINS
SECTIONS


VERIFY SCALE	
BAR IS ONE INCH ON ORIGINAL DRAWING.	
DATE	DECEMBER 2013
PROJ	457133
DWG	520-D-3001
SHEET	of

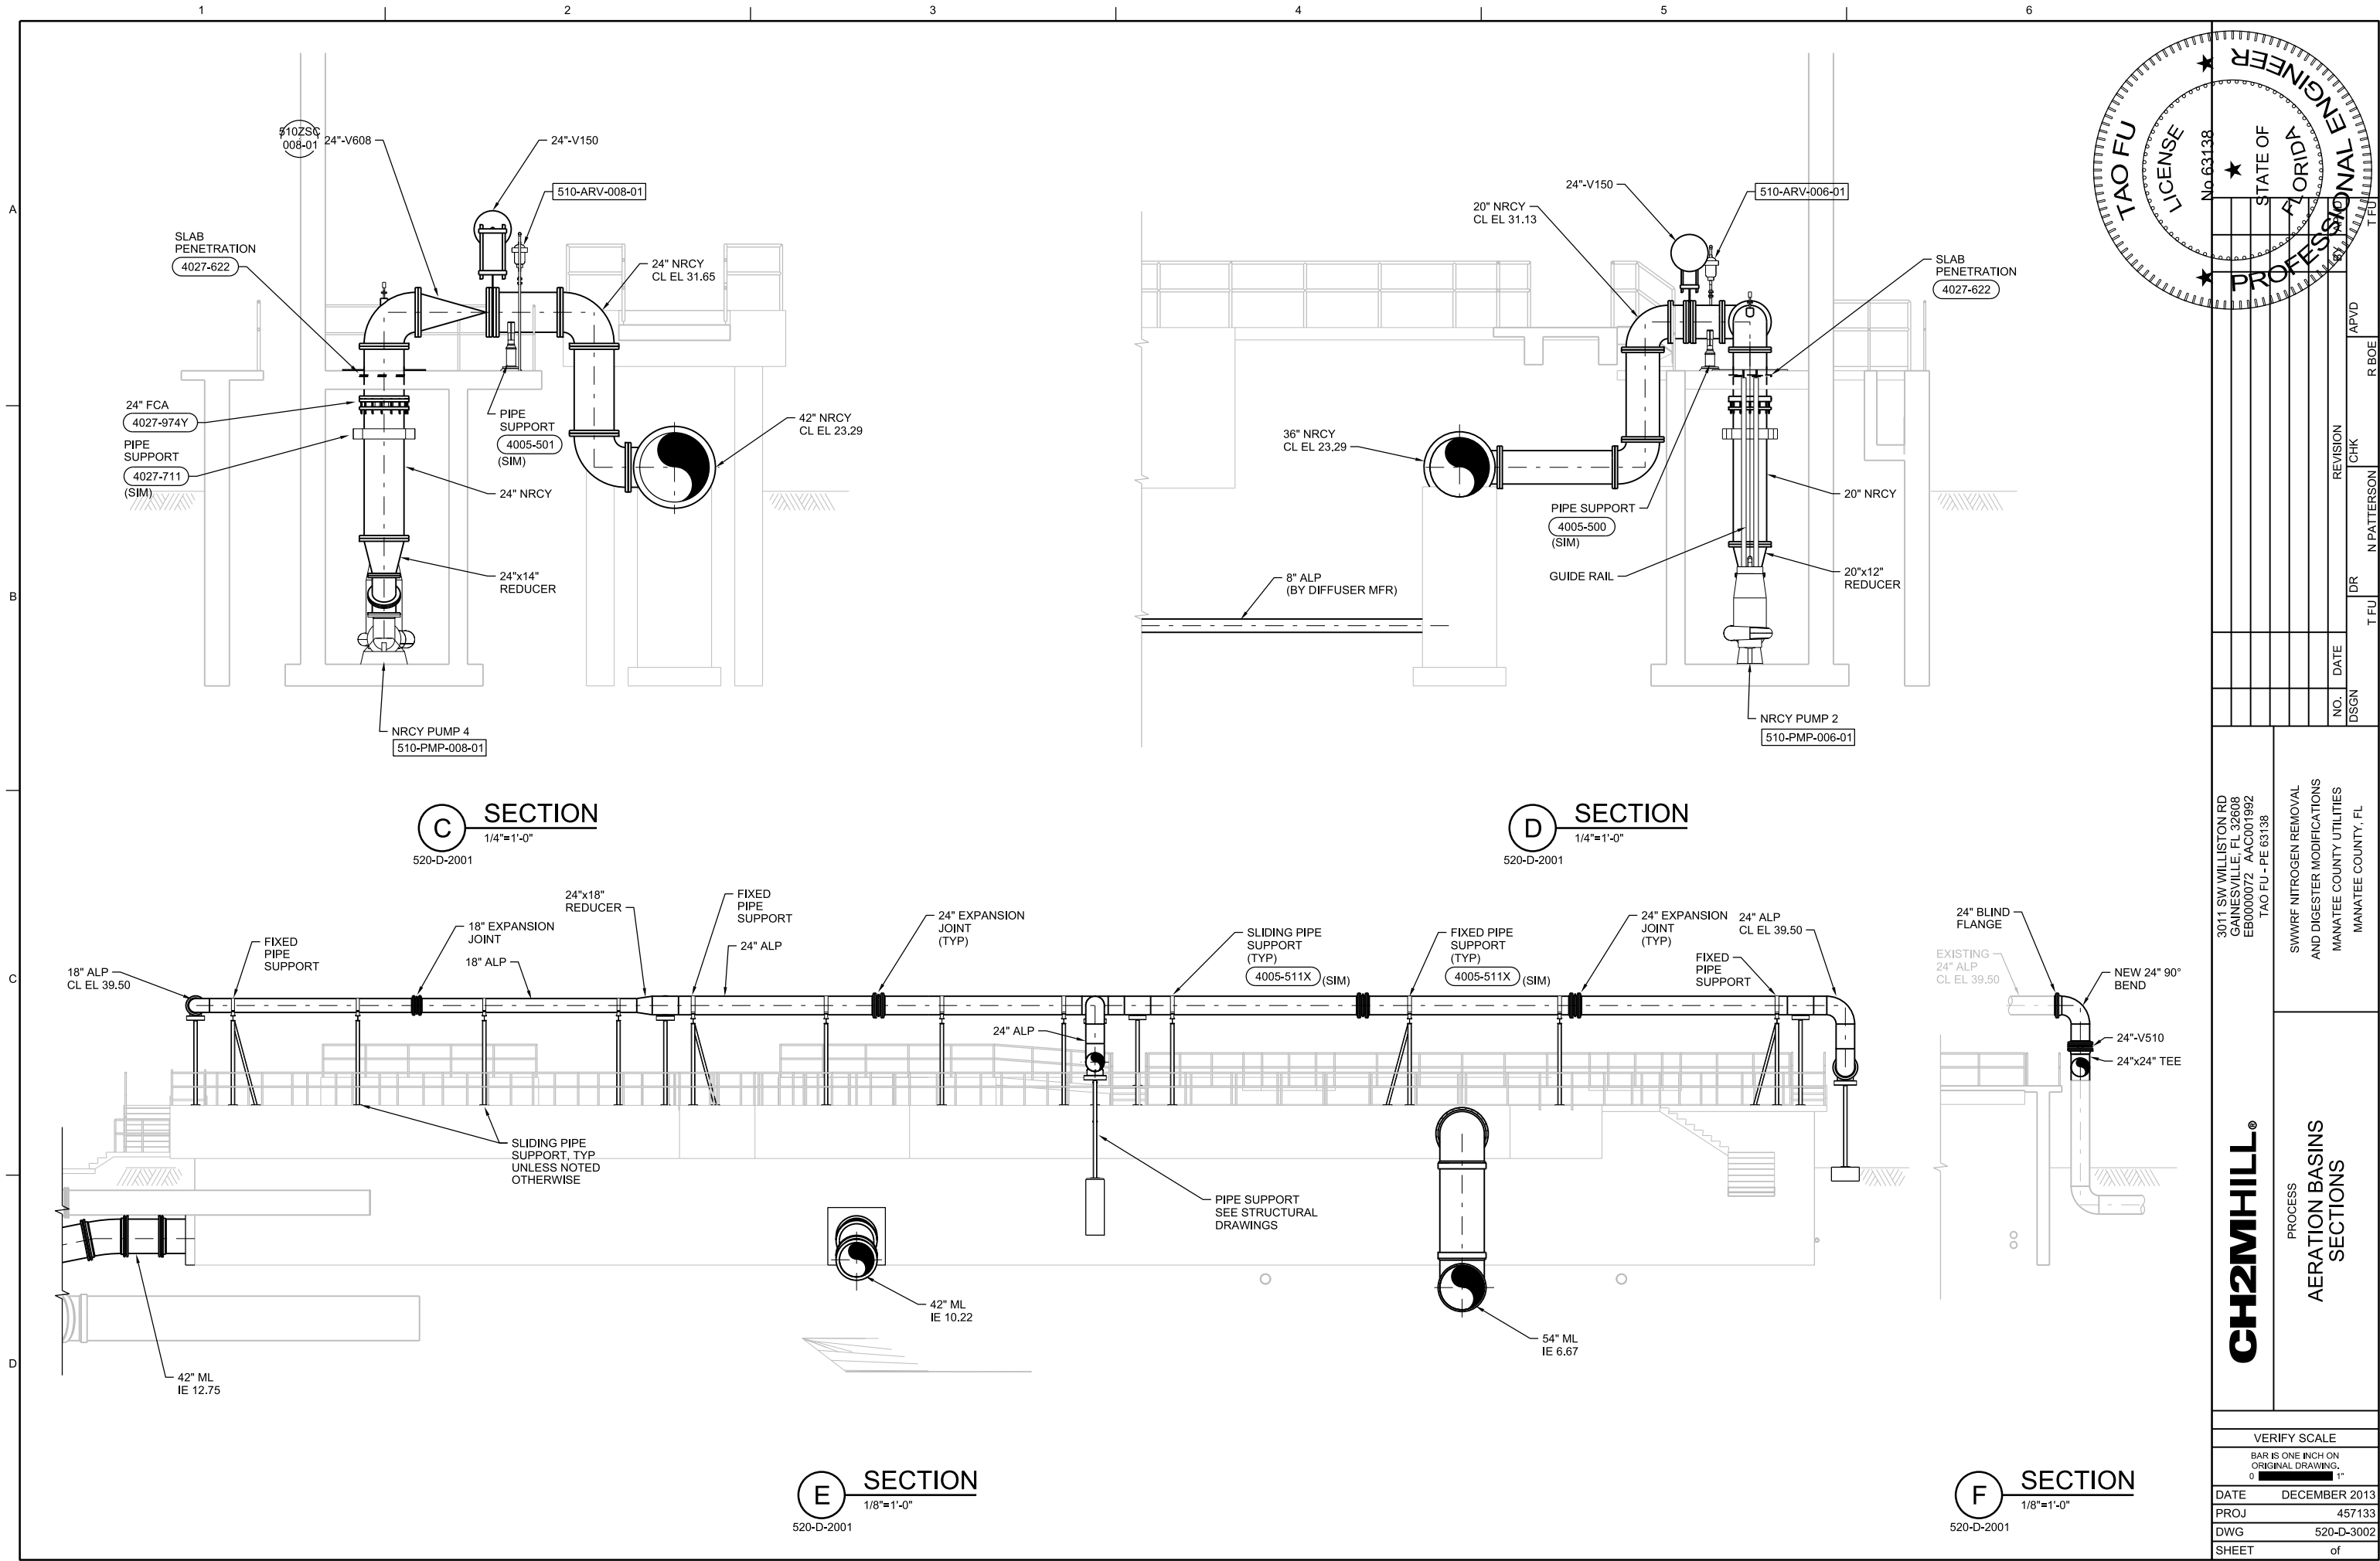


© CH2M HILL 2012. ALL RIGHTS RESERVED.

REUSE OF DOCUMENTS: THIS DOCUMENT, AND THE IDEAS AND DESIGNS INCORPORATED HEREIN, AS AN INSTRUMENT OF PROFESSIONAL SERVICE, IS THE PROPERTY OF CH2M HILL AND IS NOT TO BE USED, IN WHOLE OR IN PART, FOR ANY OTHER PROJECT WITHOUT THE WRITTEN AUTHORIZATION OF CH2M HILL.

ISSUED FOR BID

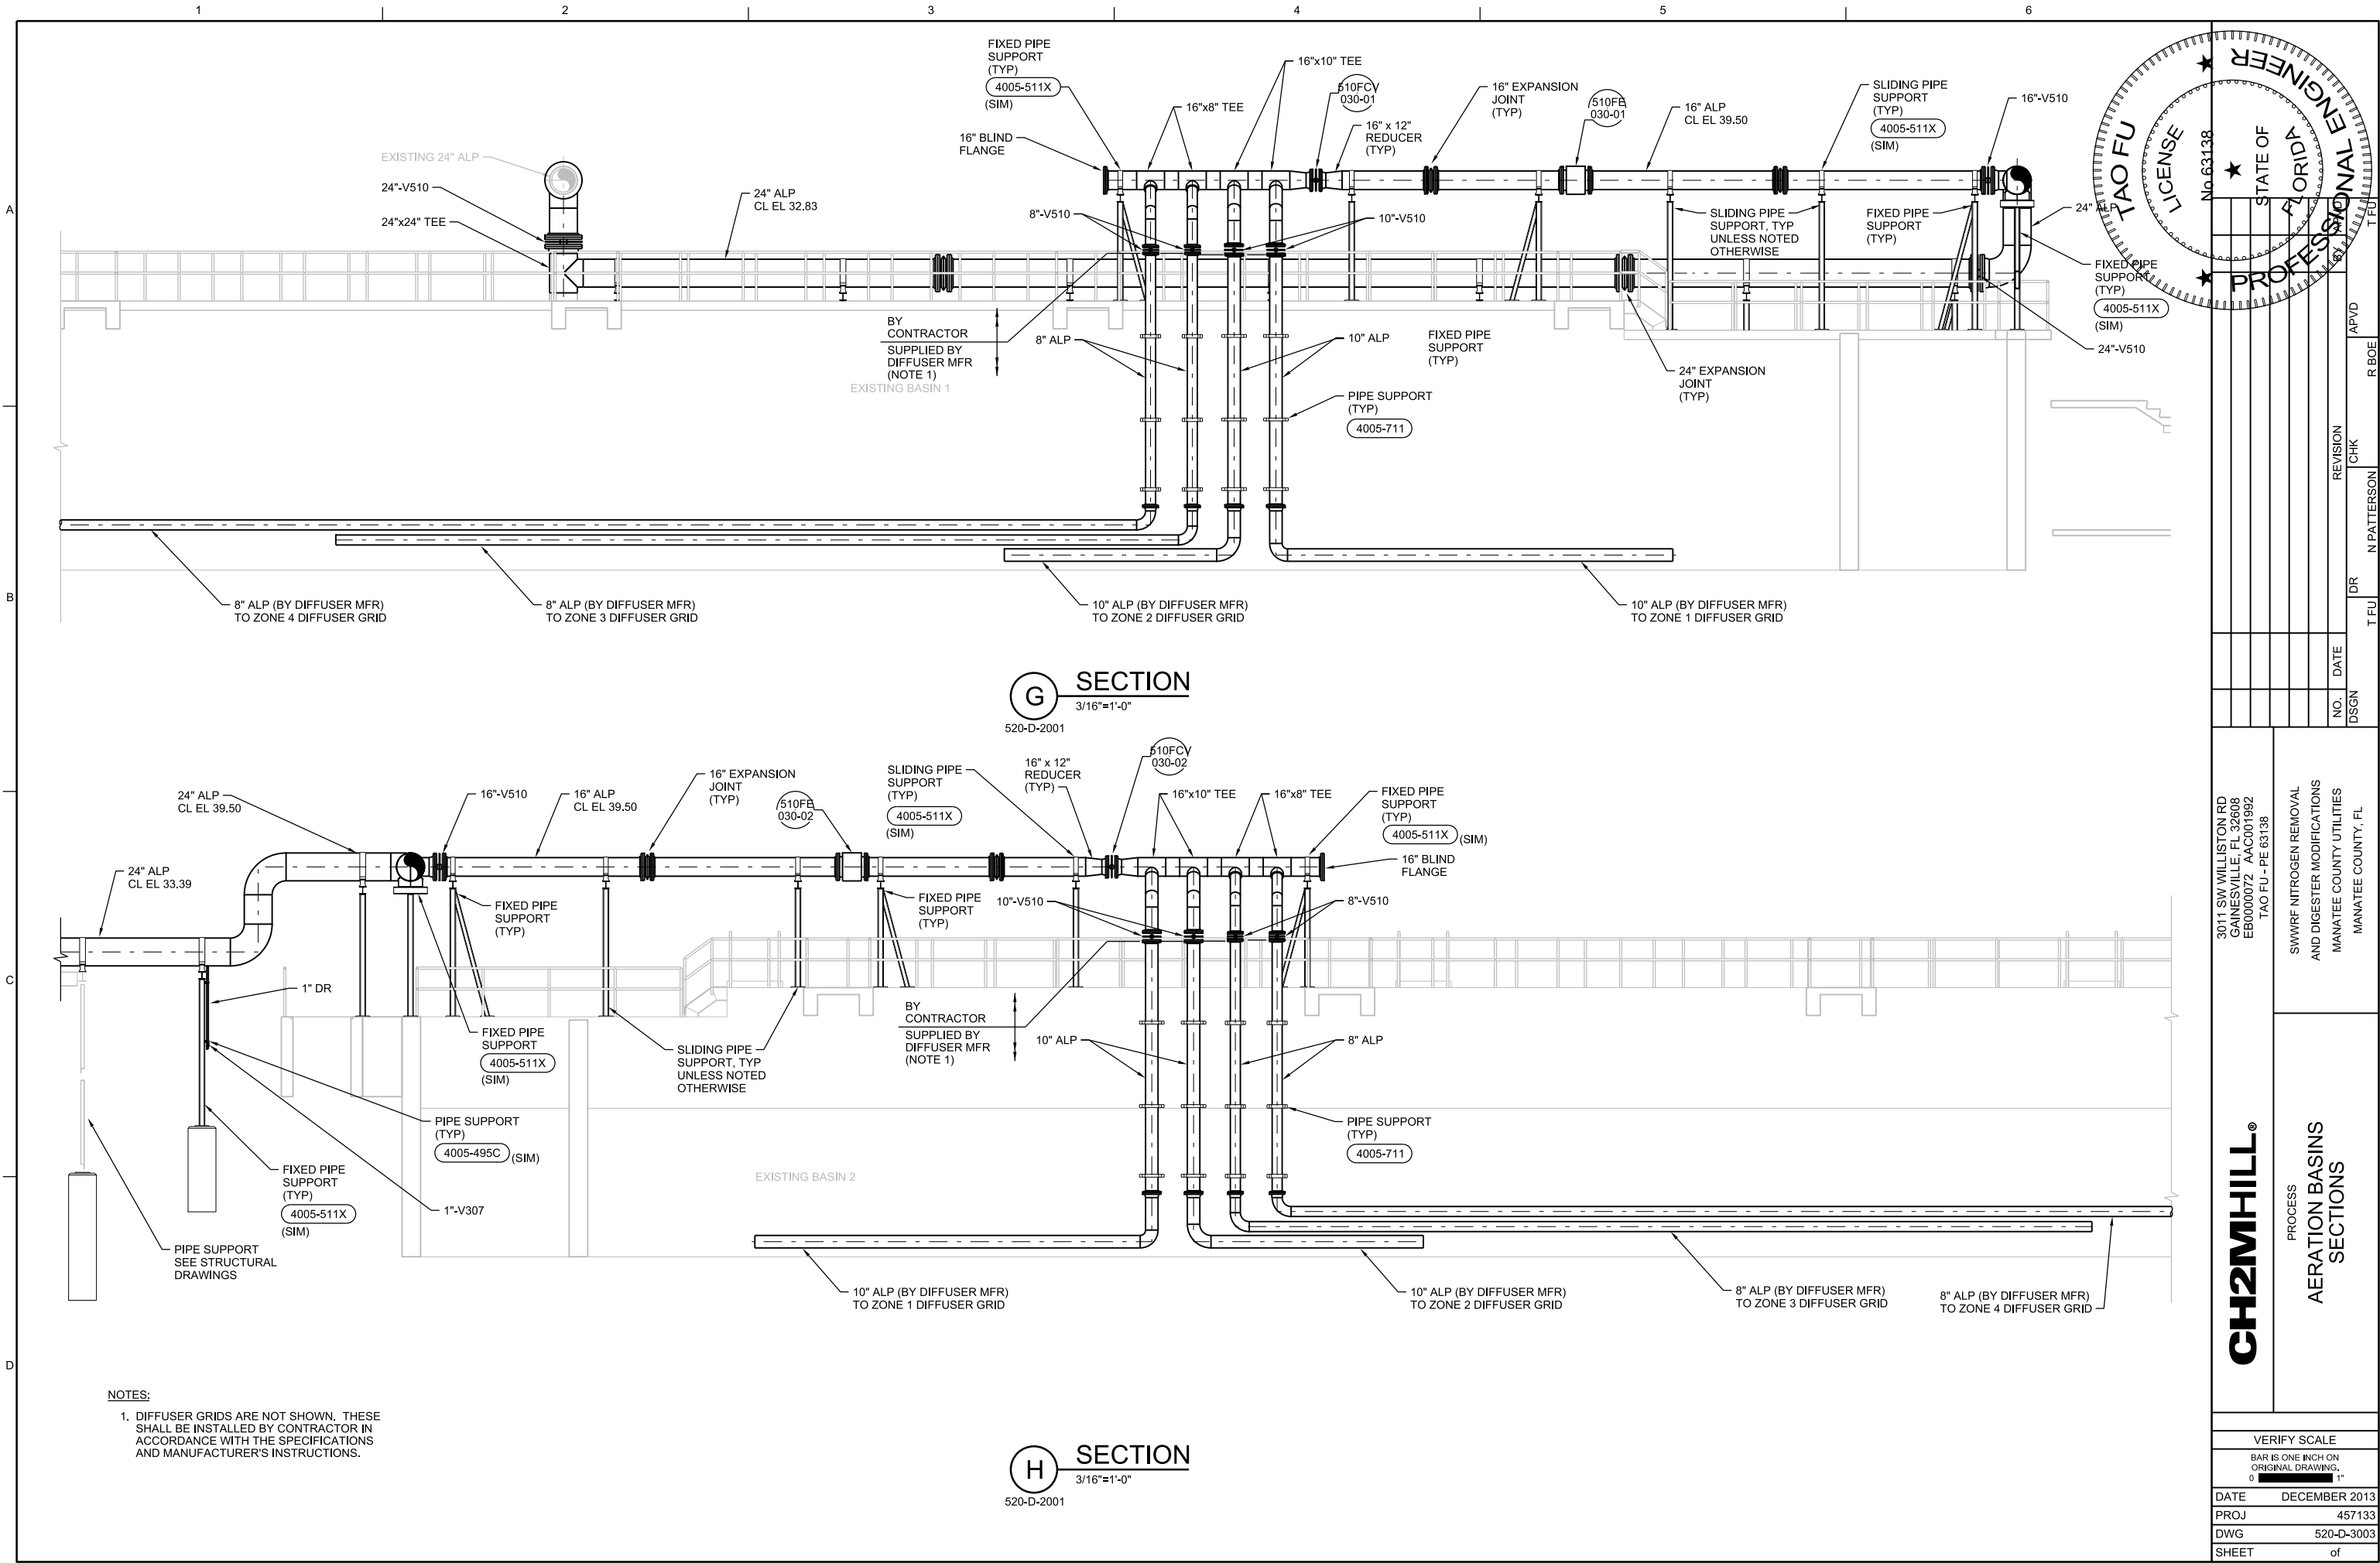

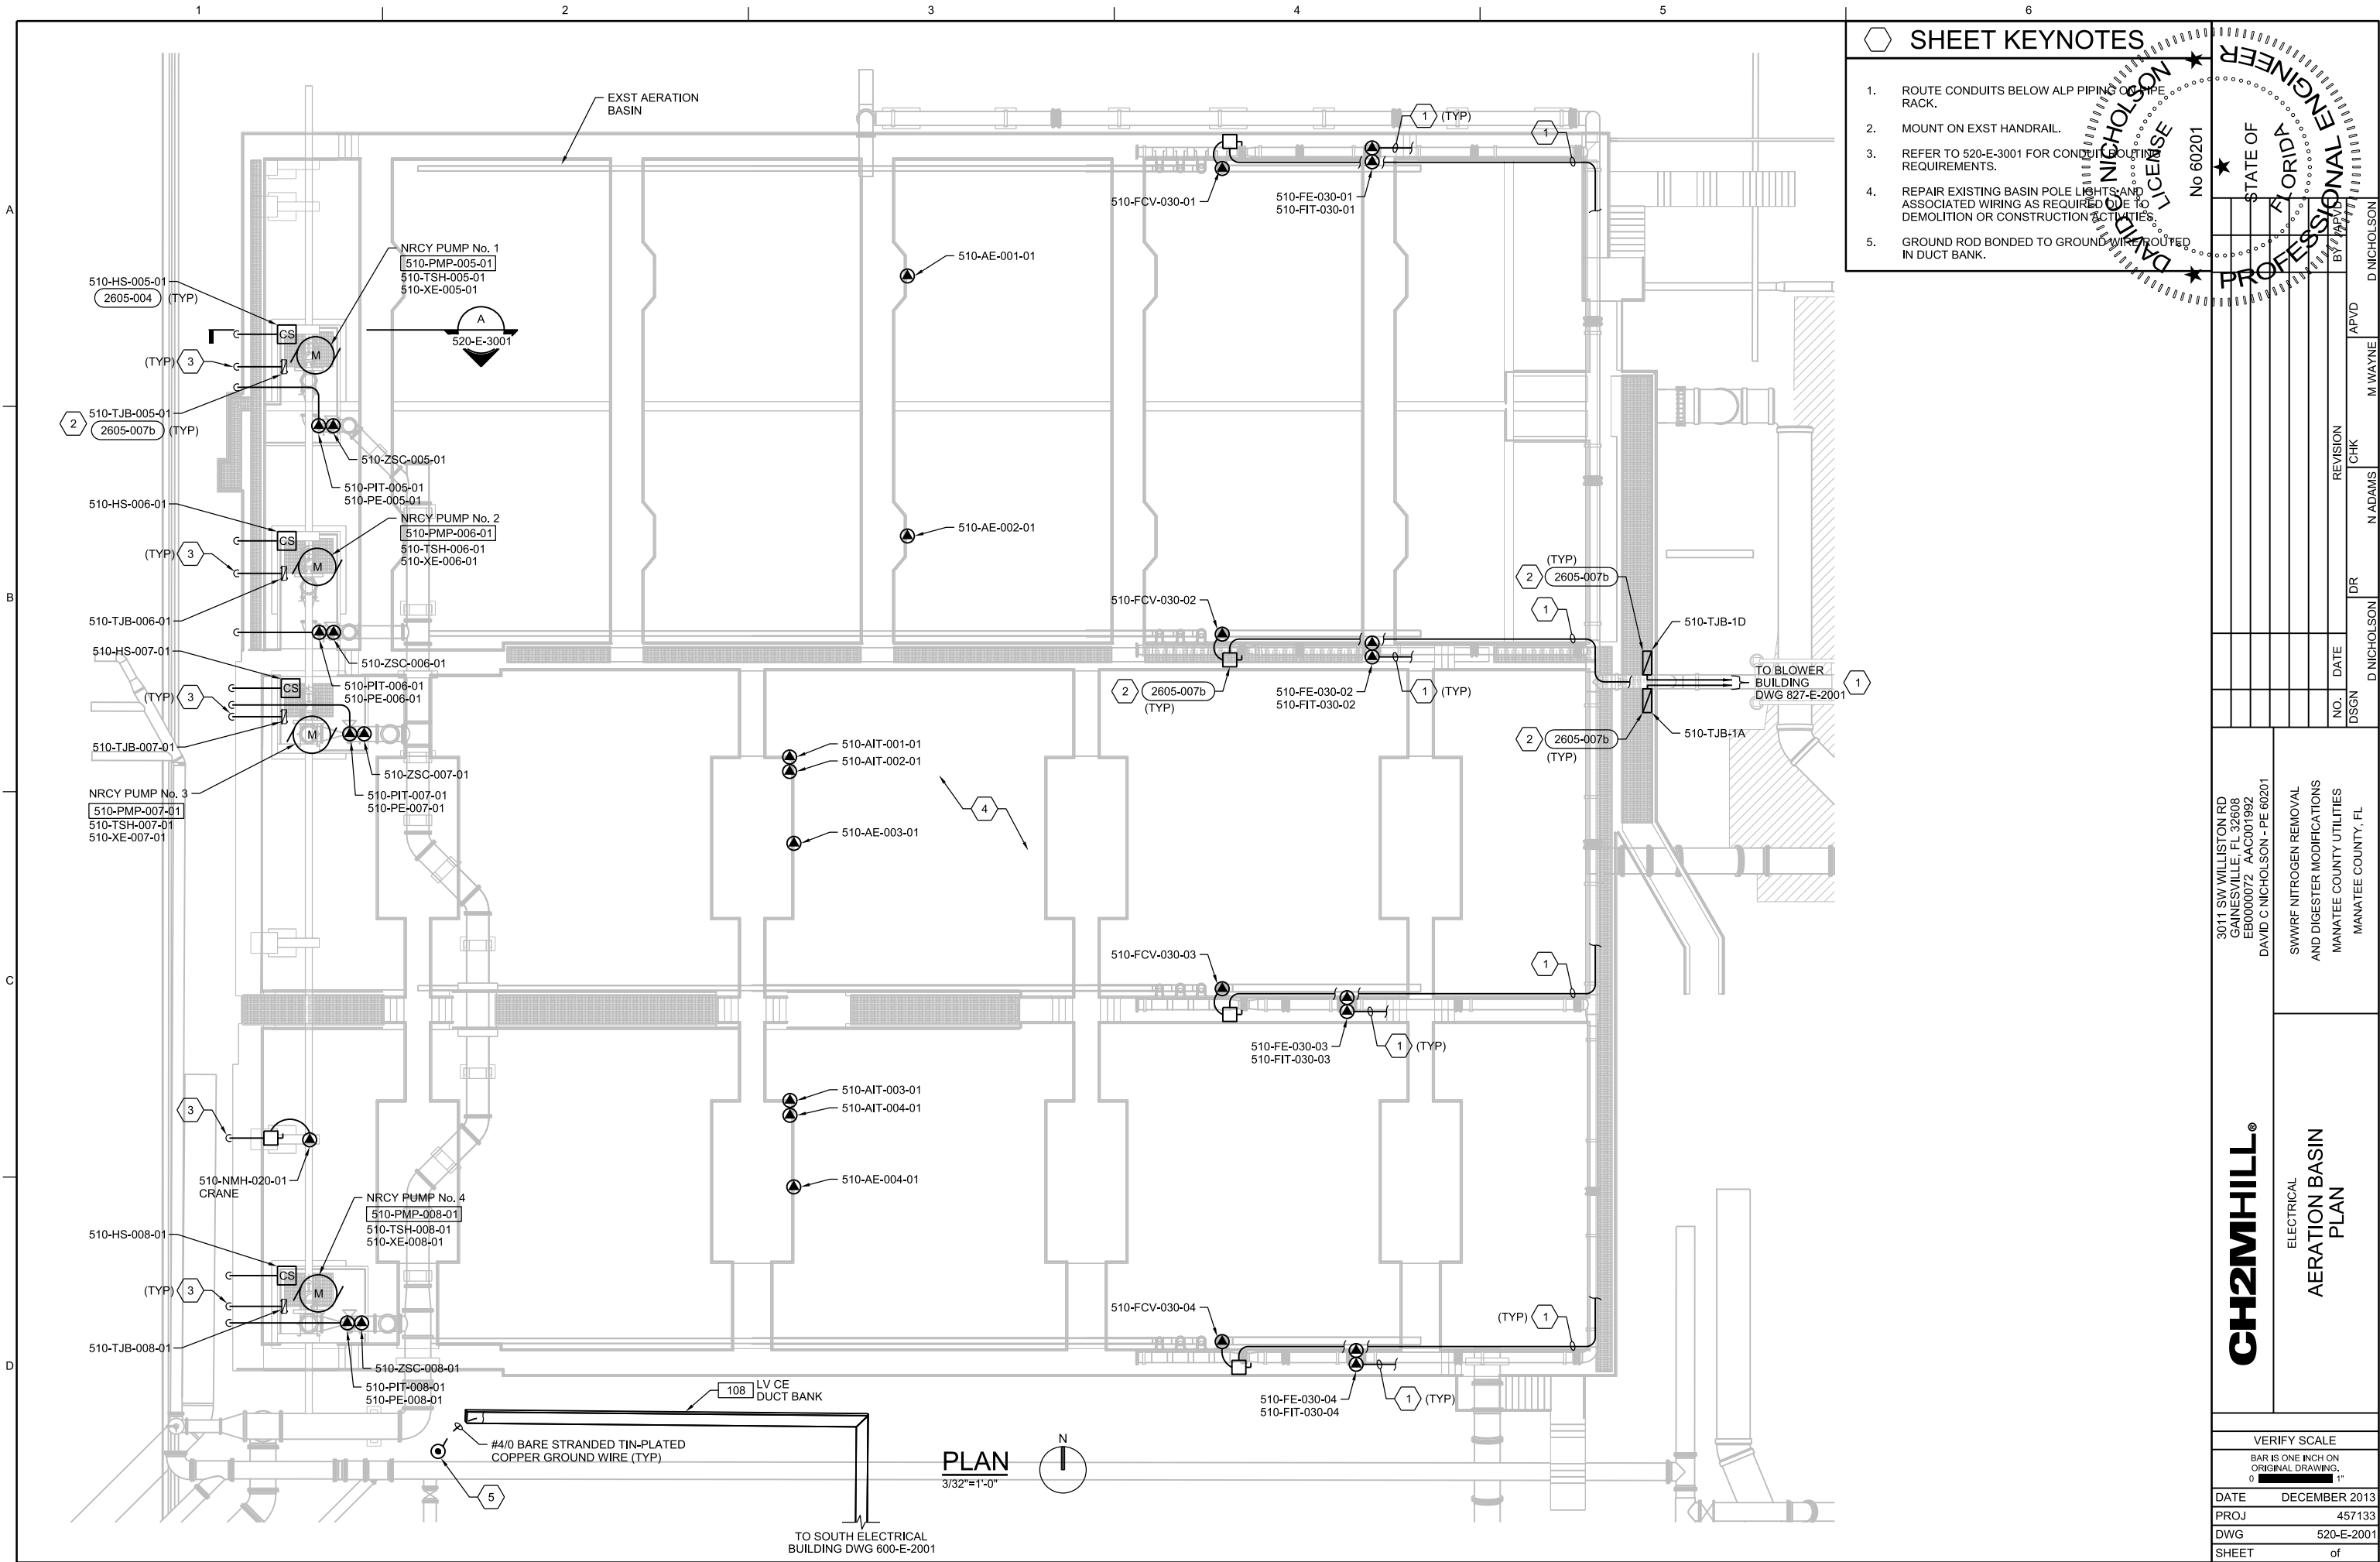

SHEET KEYNOTES

1. ROUTE CONDUITS BELOW ALP PIPING OR PIPE RACK.

2. MOUNT ON EXST HANDRAIL.

3. REFER TO 520-E-3001 FOR CONDUIT ROUTING REQUIREMENTS.

4. REPAIR EXISTING BASIN POLE LIGHTS AND ASSOCIATED WIRING AS REQUIRED DUE TO DEMOLITION OR CONSTRUCTION ACTIVITIES.

5. GROUND ROD BONDED TO GROUND WIRE ROUTED IN DUCT BANK.

DAVID C. NICHOLSON

PROFESSIONAL ENGINEER

FLORIDA

NO 60201

BY

APVD

D. NICHOLSON

STATE OF

FLORIDA

PROFESSIONAL ENGINEER

NO 60201

BY

APVD

D. NICHOLSON

3011 SW WILLISTON RD
GAINESVILLE, FL 32608
EB0000072 - AAC001982
DAVID C. NICHOLSON - PE 60201

SWWRF NITROGEN REMOVAL
AND DIGESTER MODIFICATIONS
MANATEE COUNTY UTILITIES
MANATEE COUNTY, FL

CH2MHILL®

ELECTRICAL
AERATION BASIN
PLAN


VERIFY SCALE	
BAR IS ONE INCH ON ORIGINAL DRAWING.	
DATE	DECEMBER 2013
PROJ	457133
DWG	520-E-2001
SHEET	of

FILENAME: 520-E-2001_457133.dgn

PLOT DATE: 12/13/2013


PLOT TIME: 1:59:10 PM

ISSUED FOR BID

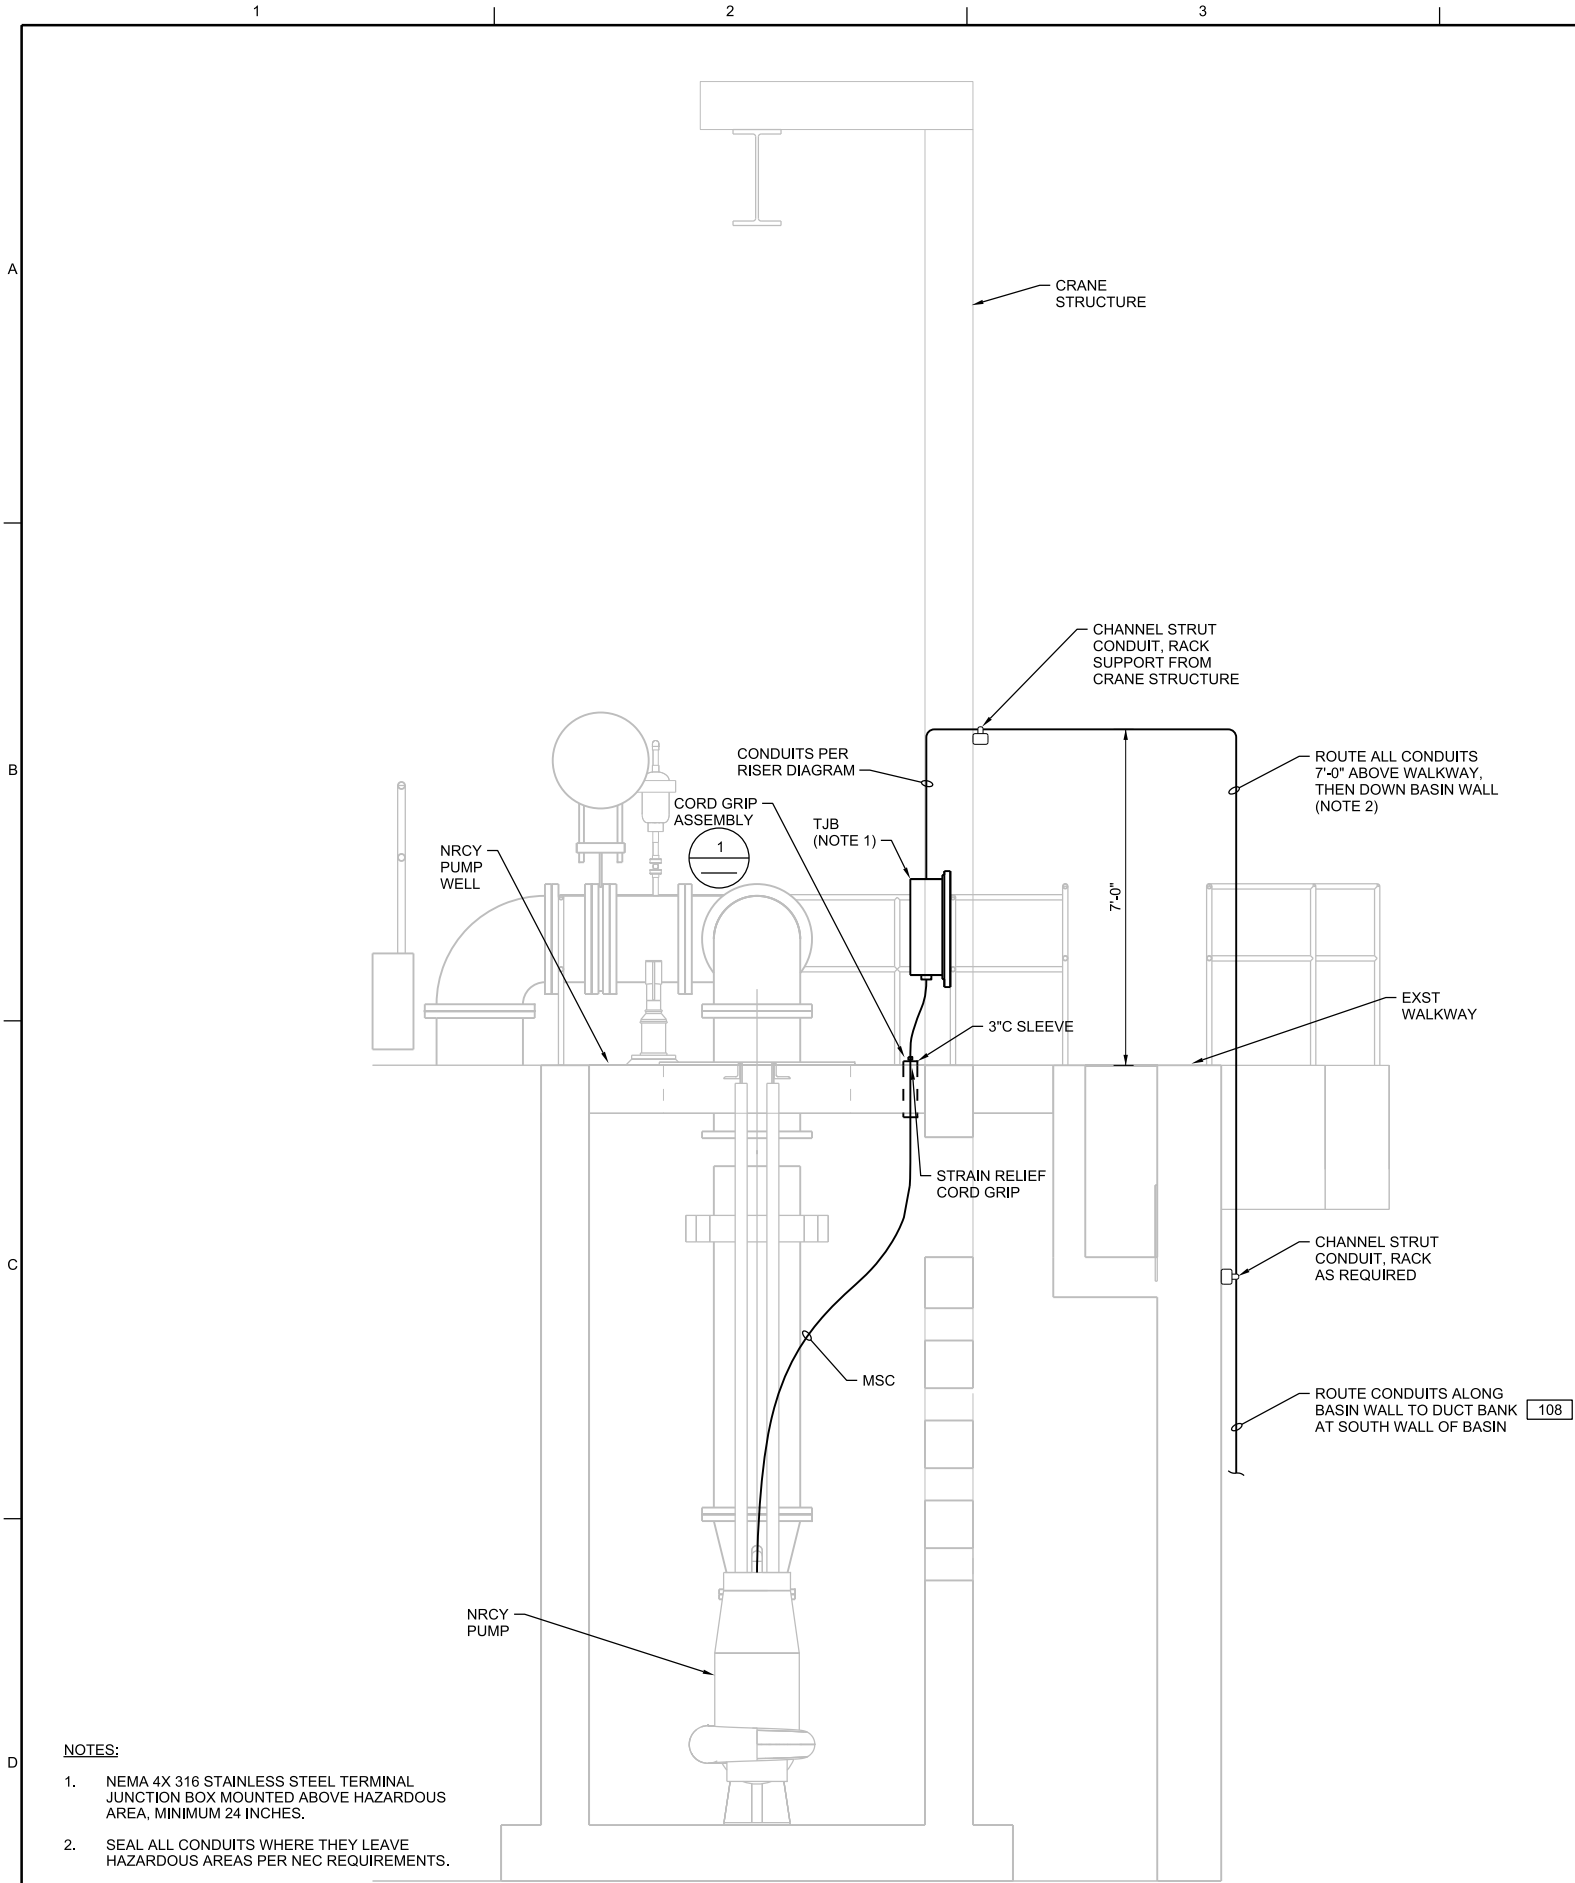

- NOTES:
- NEMA 4X 316 STAINLESS STEEL TERMINAL JUNCTION BOX MOUNTED ABOVE HAZARDOUS AREA, MINIMUM 24 INCHES.
 - SEAL ALL CONDUITS WHERE THEY LEAVE HAZARDOUS AREAS PER NEC REQUIREMENTS.

A SECTION
1/2"=1'-0"
520-E-2001

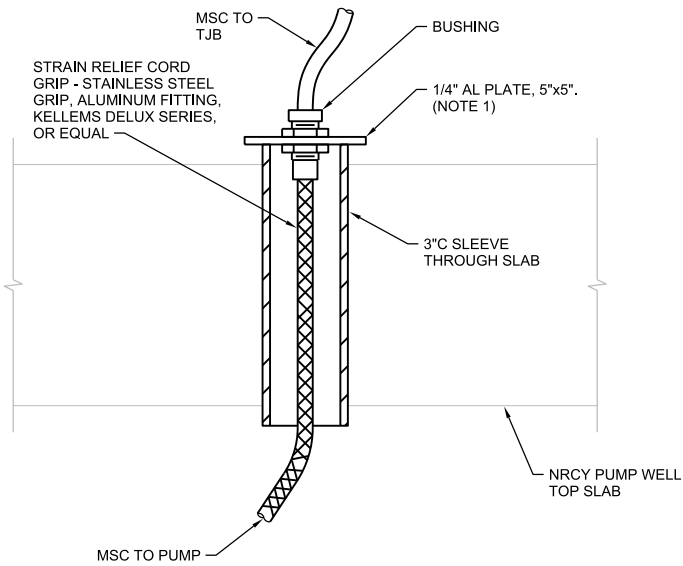

- NOTES:
- INSTALL STRAIN RELIEF CORD GRIP IN ALUMINUM PLATE. ALUMINUM PLATE TO SIT LOOSE ON TOP OF CONDUIT SLEEVE. ADJUST MSC TO RELIEVE STRAIN ON TERMINALS IN TJB.

1 CORD GRIP ASSEMBLY DETAIL
NTS

DAVID C. NICHOLSON
LICENSE
No 60201
STATE OF
FLORIDA
PROFESSIONAL ENGINEER

APVD
M WAYNE
CHK
N ADAMS
DR
D NICHOLSON
NO. DATE
REVISION
BY

3011 SW WILLISTON RD
GAINESVILLE, FL 32608
EB0000072 - AAC001992
DAVID C NICHOLSON - PE 60201


SWWRF NITROGEN REMOVAL
AND DIGESTER MODIFICATIONS
MANATEE COUNTY UTILITIES
MANATEE COUNTY, FL

CH2MHILL®
ELECTRICAL
AERATION BASIN
SECTION

VERIFY SCALE
BAR IS ONE INCH ON
ORIGINAL DRAWING.
0 1"

DATE DECEMBER 2013
PROJ 457133
DWG 520-E-3001
SHEET of

ISSUED FOR BID
© CH2M HILL 2012. ALL RIGHTS RESERVED.
THIS DOCUMENT, AND THE IDEAS AND DESIGNS INCORPORATED HEREIN, AS AN INSTRUMENT OF PROFESSIONAL SERVICE, IS THE PROPERTY OF CH2M HILL AND IS NOT TO BE USED, IN WHOLE OR IN PART, FOR ANY OTHER PROJECT WITHOUT THE WRITTEN AUTHORIZATION OF CH2M HILL.

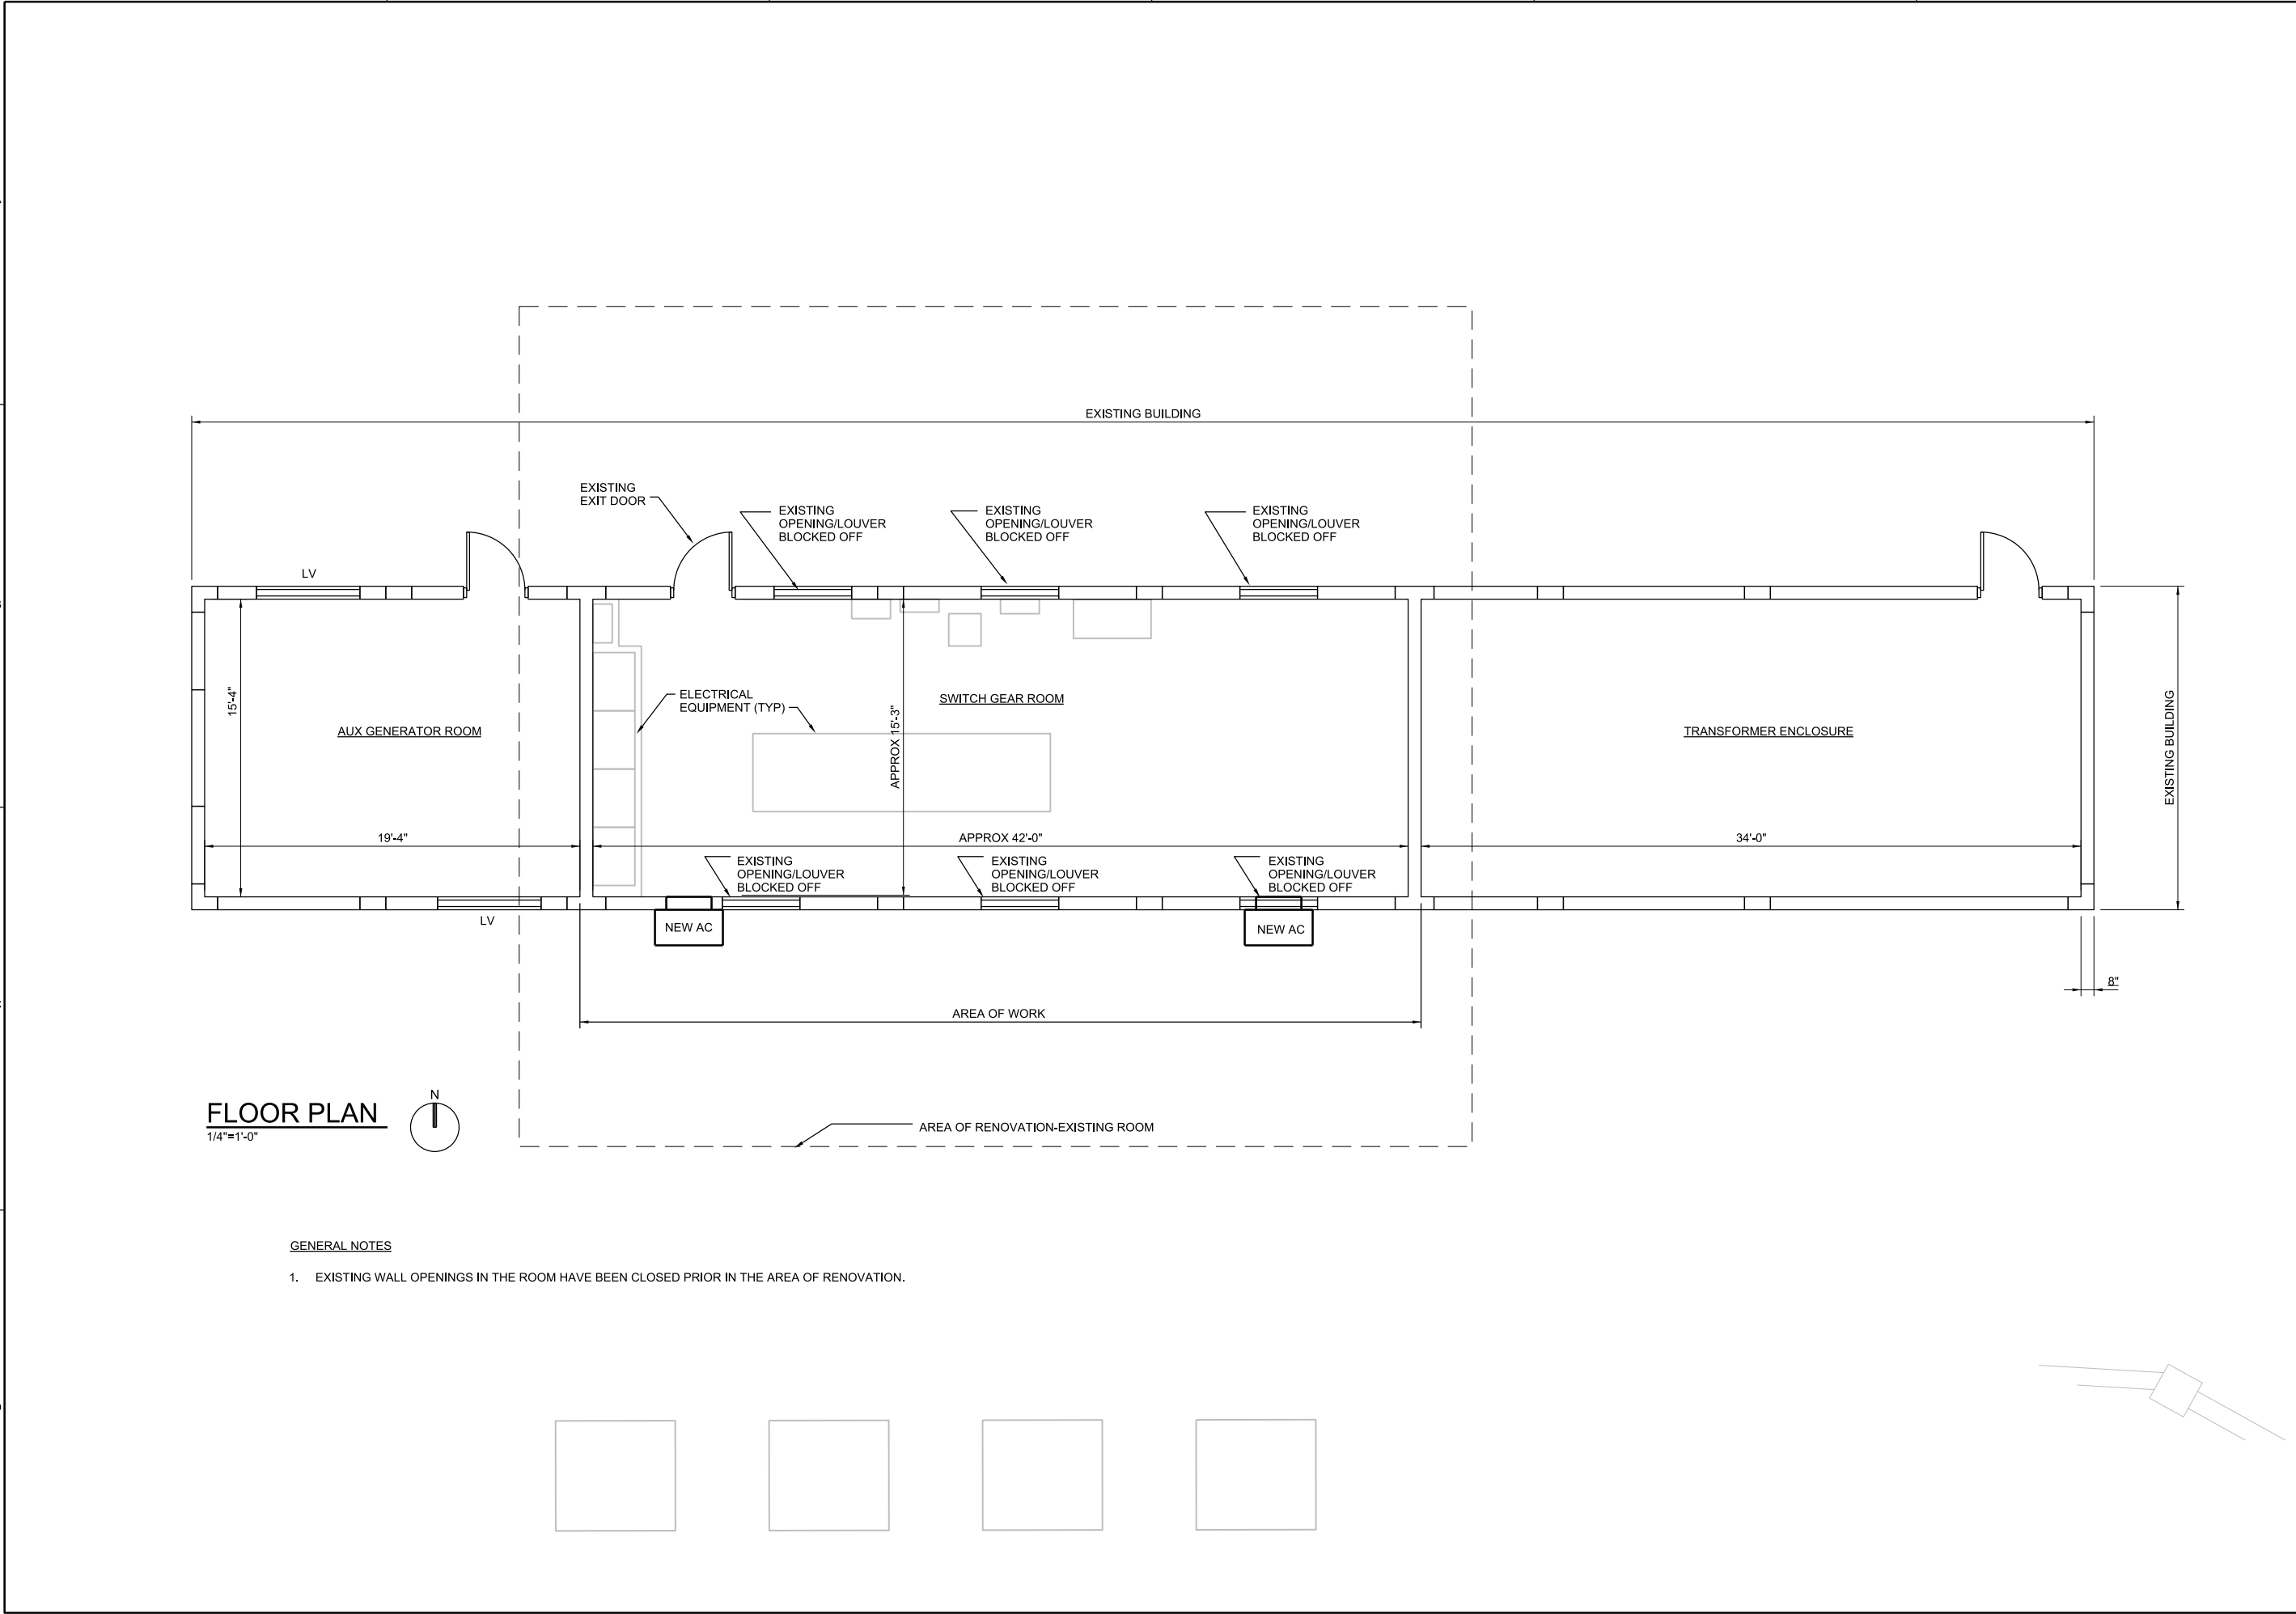

FLOOR PLAN
1/4"=1'-0"

GENERAL NOTES

1. EXISTING WALL OPENINGS IN THE ROOM HAVE BEEN CLOSED PRIOR IN THE AREA OF RENOVATION.

CH2MHILL® ARCHITECTURAL EXISTING SOUTH ELECTRICAL BUILDING FLOOR PLAN	3011 SW WILLISTON RD GAINESVILLE, FL 32608 EB0000072 - AAC001992 BETH TRAUTWEIN - AR 91388 SWWRf NITROGEN REMOVAL AND DIGESTER MODIFICATIONS MANATEE COUNTY UTILITIES MANATEE COUNTY, FL	NO. DATE DGN	DR	A COULLLIAS	A COULLLIAS	A DOLSAK	REVISION CHK	BY	APVD	B TRAUTWEIN
VERIFY SCALE BAR IS ONE INCH ON ORIGINAL DRAWING. 0 1"										
DATE APRIL 2014										
PROJ 457133										
DWG 600-A-2001										
SHEET of										

GENERAL NOTES:

1. CONTRACTOR SHALL INSPECT SITE TO BECOME FAMILIAR WITH THE SCOPE OF THE WORK. THESE DOCUMENTS DO NOT REFLECT AS-BUILT CONDITIONS. ANY DISCREPANCIES BETWEEN THESE DOCUMENTS AND THE ACTUAL CONDITIONS SHALL BE REPORTED TO THE ENGINEER FOR RESOLUTION.

2. MECHANICAL WORK SHALL COMPLY WITH ALL APPLICABLE CODES. VERIFY ALL REQUIREMENTS PRIOR TO COMMENCING WORK.

3. COORDINATE THERMOSTAT LOCATIONS WITH EXISTING CONDITIONS AND THE ARCHITECT/ENGINEER PRIOR TO INSTALLATION.

4. THE UNIT SHALL BE SECURE BY WALL MOUNTING BRACKETS WHICH SECURE THE UNIT TO THE OUTSIDE WALL SURFACE AT BOTH SIDES. A BOTTOM MOUNTING BRACKET IS PROVIDED FOR EASE INSTALLATION, BUT IS NOT REQUIRED.

5. A BEAD OF SILICONE CAULKING SHALL BE PLACED BEHIND THE SIDE MOUNTING FLANGES AND UNDER TOP FLASHING AT TIME OF INSTALLATION.

6. SECURE UNIT WITH 5/16 LAG BOLTS; USE 7/8 INCH DIAMETER FLAT WASHERS ON THE LAG BOLTS.
7. INSTALL WORK SO AS TO BE READILY ACCESSIBLE FOR OPERATION. MAINTENANCE AND REPAIR. MINOR DEVIATIONS FROM DRAWINGS MAY BE MADE TO ACCOMPLISH THIS. BUT CHANGES WHICH INVOLVE EXTRA COST SHALL NOT BE MADE WITHOUT APPROVAL.

8. DISCONNECT, REMOVE AND/OR RELOCATE EXISTING MATERIAL, EQUIPMENT AND OTHER WORK AS NOTED OR REQUIRED FOR PROPER INSTALLATION OF THE NEW SYSTEM.

9. ALL SYSTEMS SHALL BE CLEAN OF FOREIGN MATERIAL AND ROUGH SPOTS PRIOR TO BEING PLACED IN SERVICE AND BEFORE OPERATIONAL TEST ARE PERFORMED.

10. INSTALLATION OF ALL EQUIPMENTS AND THEIR ACCESSORIES SHALL BE PER MANUFACTURER'S PUBLISHED RECOMMENDATIONS.

11. ALL MATERIALS AND EQUIPMENT TO BE NEW UNLESS OTHERWISE NOTED..

SEQUENCE OF OPERATION


GENERAL:
THE UNITS WILL BE CONTROLLED VIA WALL MOUNTED THERMOSTAT

OPERATION/SETPOINTS:

FIRST STAGE COOLING SETPOINT (85 F ADJ):
ON A CALL FOR FIRST STAGE COOLING, THE BLOWER OF THE UNIT IS ENERGIZED AND THE COMPRESSOR WILL OPERATE AT LOW CAPACITY.

SECOND STAGE COOLING SETPOINT (87 F ADJ):
ON A CALL FOR SECOND STAGE COOLING, THE COMPRESSOR WILL OPERATRE AT HIGH CAPACITY.
AS THE SPACE TEMPERATURE SETPOINTS ARE SATISFIED, THE UNIT IS DE-ENERGIZED.

WHEN THE TEMPERATURE IN THE ELECTRICAL ROOM IS UNDER THE HEATING SETPOINT TEMPERATURE (60 F ADJ), THE ELECTRIC UNIT HEATER SHALL ENERGIZE. AS THE TEMPERATURE SETPOINT IS SATISFIED THE HEATER SHALL BE DE-ENERGIZED.

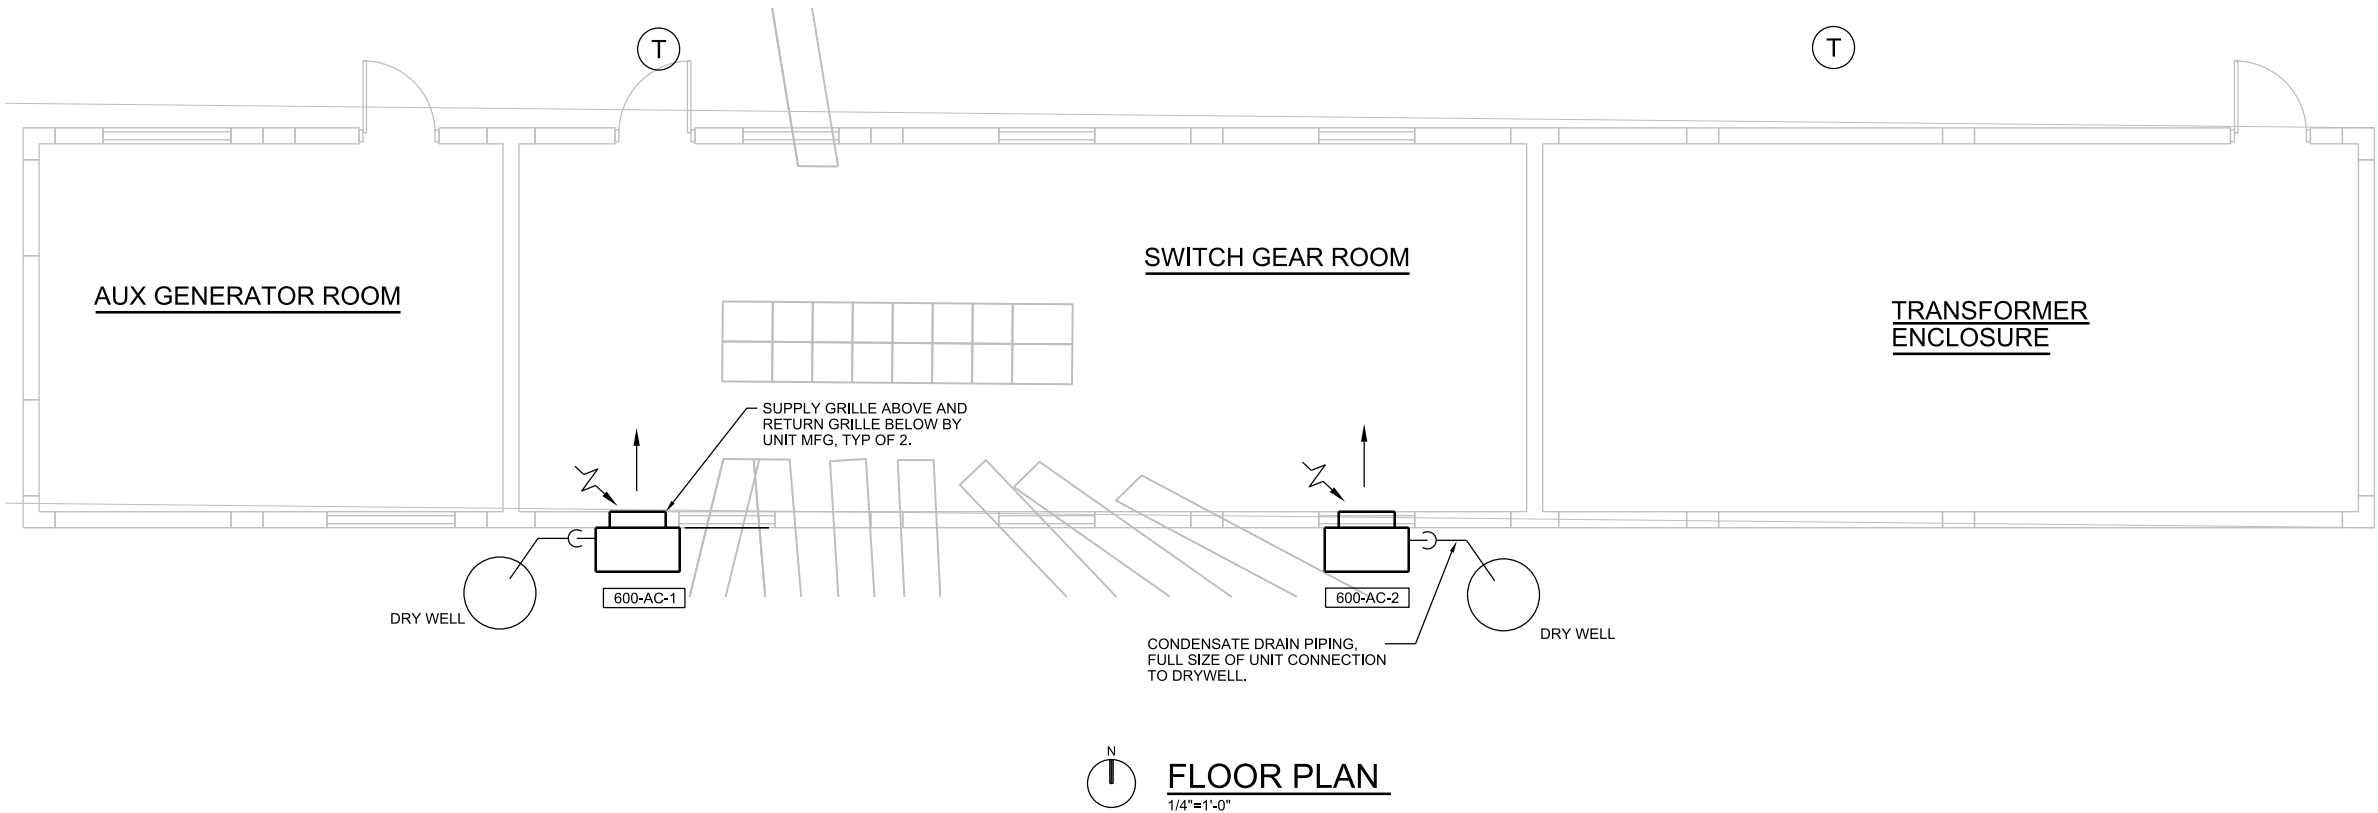

WALL MOUNT AIR CONDITIONER

23 81 00.08

SYMBOL	LOCATION	INDOOR FAN DATA						DX COOLING DATA				ELECTRIC HEATING DATA				COMPRESSOR DATA				CONDENSER FAN DATA					UNIT ELECTRICAL DATA				UNIT DIMENSIONS			MANUFACTURER	MODEL	REMARKS				
		SUPPLY AIR CFM	OUTSIDE AIR CFM	EXTERNAL STATIC P IN W.G.	HP	VOLT	PH	TOTAL BTU/H	EAT DEG. F		AMBIENT TEMP. DEG. F	KW	STEPS	VOLT	PH	NO.	STEPS	RLA (EA)	LRA (EA)	VOLT	PH	NO.	H.P. (EA)	VOLT	PH	CFM (TOTAL)	#CONN.	MCA	MOCF (FUSE)	VOLT	PH				INCHES			MAX WEIGHT LBS
									DB	WB																									H	W	D	
600-AC-1	SOUTH ELECTRICAL BUILDING	1100	0	0.25	1/2	460	3	35,400	80	49	92	6	1	460	3	1	2	3.6	38.0	460	3	1	1/3	460	3	2700	1	13.5	15	460	3	84.8	42	22.4	530	BARD	WA3S3C6BPX	A,B,C,D,E,F,G,H,I,J
600-AC-2	SOUTH ELECTRICAL BUILDING	1100	0	0.25	1/2	460	3	35,400	80	49	92	6	1	460	3	1	2	3.6	38.0	460	3	1	1/3	460	3	2700	1	13.5	15	460	3	84.8	42	22.4	530	BARD	WA3S3C6BPX	A,B,C,D,E,F,G,H,I,J

REMARKS:

- A: CONDENSER COIL SHALL HAVE DIP APPLIED ANTI-CORROSION COATING (NOT SPRAY APPLIED)

B: 2 INCH DEEP PLEATED AIR FILTER SIZED TO SUIT RETURN GRILLE

C: FACTORY INSTALLED DISCONNECT


E: COLD WEATHER KIT

F: 5 YEAR COMPRESSOR WARRANTY

G: STANDARD RETURN AIR GRILLE
- H: STANDARD SUPPLY AIR GRILLE

I: BLANK OFF PLATE TO RESTRICT ANY OSA.

J: FIELD INSTALLED HEATER PACKAGE MODEL EHWA5S-C06(6 KW)

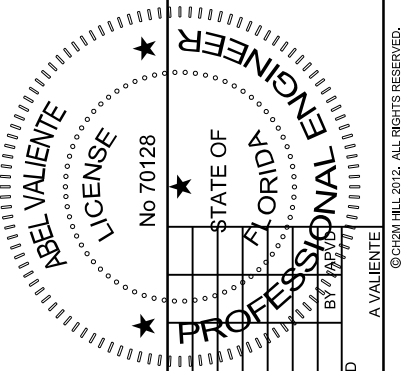

CH2MHILL®


BUILDING MECHANICAL
EXISTING SOUTH ELECTRICAL
BUILDING
FLOOR PLAN

3011 SW WILLISTON RD
GAINESVILLE, FL 32608
EB0000072 - AAC001992
ABEL VALIENTE - PE 70128

SWWRF NITROGEN REMOVAL
AND DIGESTER MODIFICATIONS
MANATEE COUNTY UTILITIES
MANATEE COUNTY, FL

VERIFY SCALE	
BAR IS ONE INCH ON ORIGINAL DRAWING, 1"	
DATE	DECEMBER 2013
PROJ	457133
DWG	600-M-2001
SHEET	of

ISSUED FOR BID

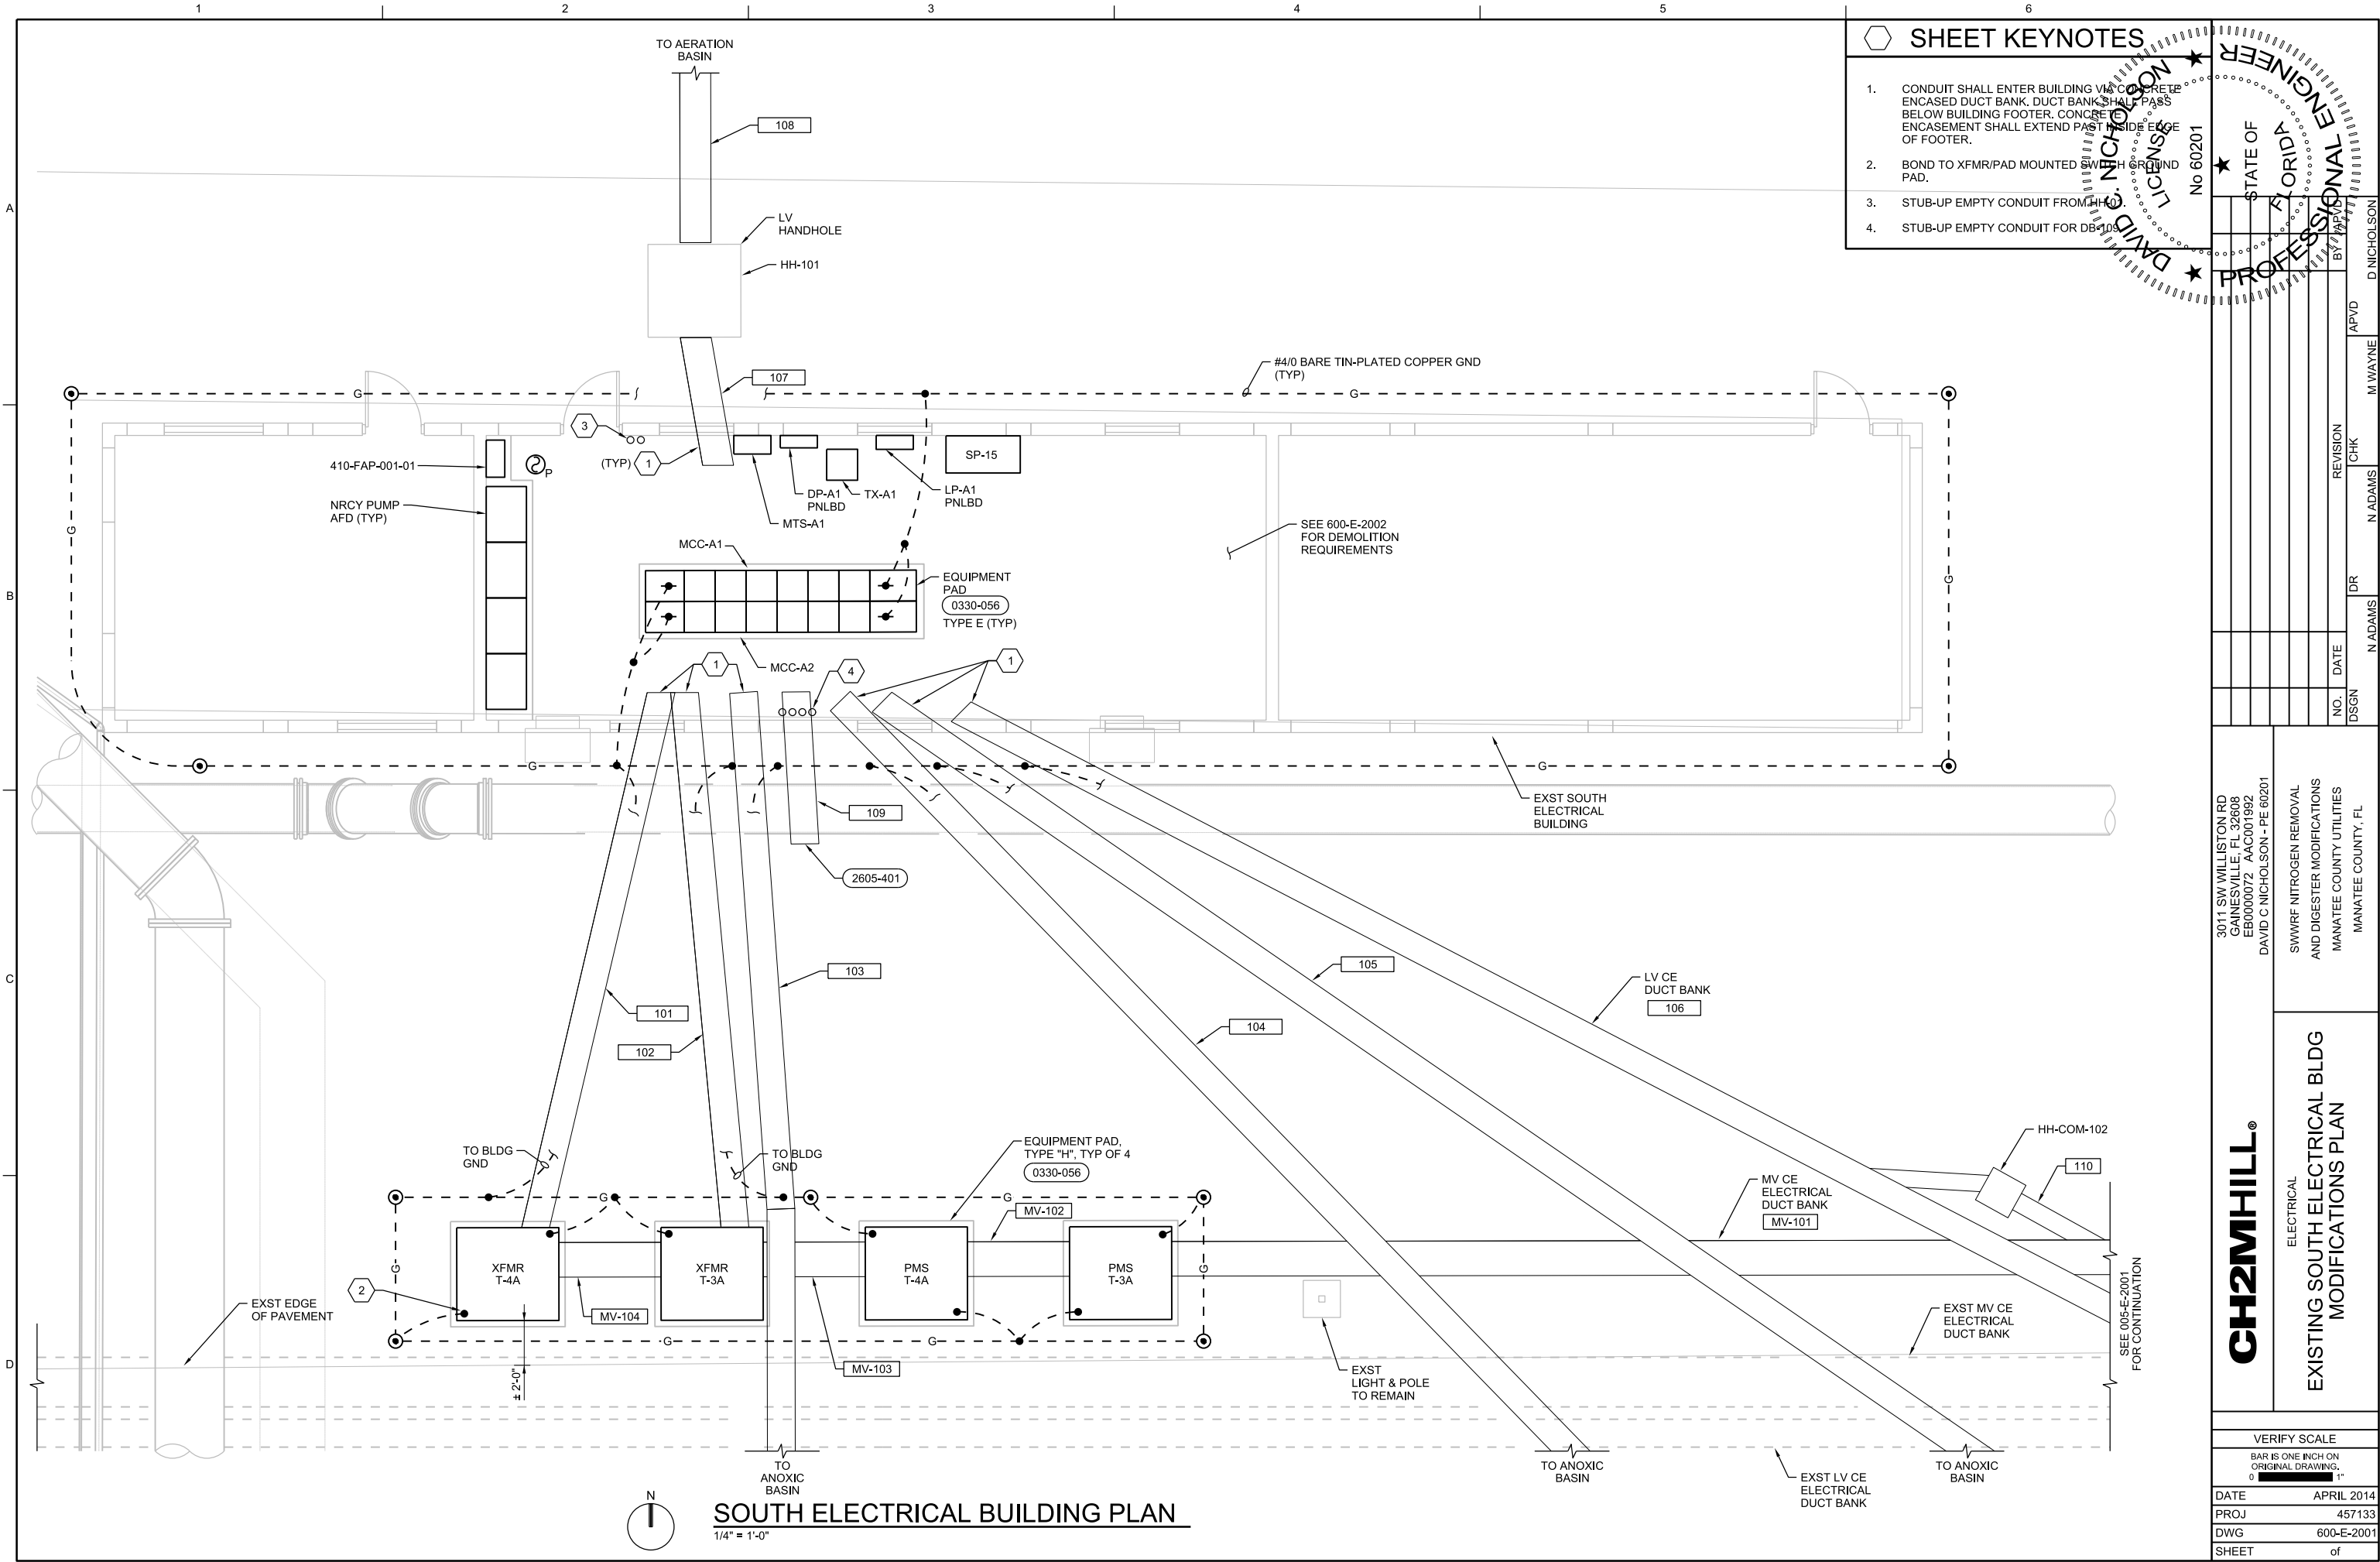

- SHEET KEYNOTES
1.

CONDUIT SHALL ENTER BUILDING VIA CONCRETE ENCASED DUCT BANK. DUCT BANK SHALL PASS BELOW BUILDING FOOTER. CONCRETE ENCASEMENT SHALL EXTEND PAST INSIDE EDGE OF FOOTER.
2.

BOND TO XFMR/PAD MOUNTED SW WITH GROUND PAD.
3.

STUB-UP EMPTY CONDUIT FROM HH-101.
4.

STUB-UP EMPTY CONDUIT FOR DB-105.

DAVID C. NICHOLSON
ELECTRICAL ENGINEER
LICENSE
No 60201

STATE OF
FLORIDA
PROFESSIONAL ENGINEER
BY
DATE

NO.	DATE	DR	CHK	REVISION

3011 SW WILLISTON RD
GAINESVILLE, FL 32608
EB0000072 - AAC001982
DAVID C. NICHOLSON - PE 60201


SWWRf NITROGEN REMOVAL
AND DIGESTER MODIFICATIONS
MANATEE COUNTY UTILITIES
MANATEE COUNTY, FL

CH2MHILL®
ELECTRICAL

EXISTING SOUTH ELECTRICAL BLDG
MODIFICATIONS PLAN

VERIFY SCALE	
BAR IS ONE INCH ON ORIGINAL DRAWING. 0  1"	
DATE	APRIL 2014
PROJ	457133
DWG	600-E-2001
SHEET	of

ISSUED FOR BID

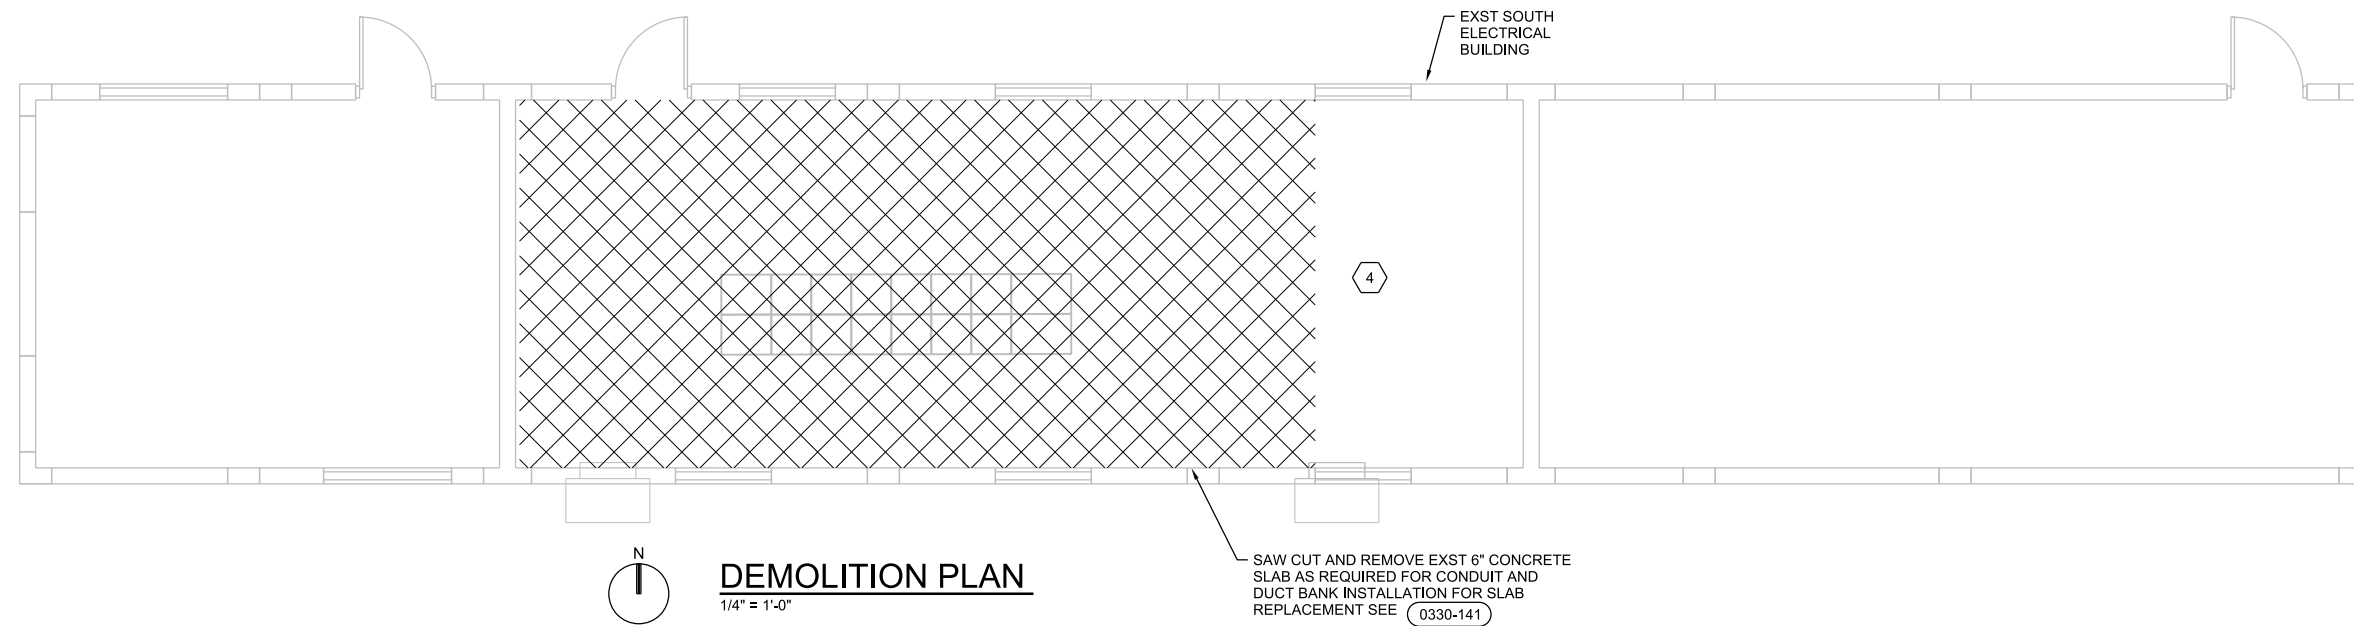

- # SHEET KEYNOTES
1. STEM MOUNT LIGHTS TO 9'-6" AFF.
 2. LIGHTS WITH EMERGENCY LIGHTING BATTER PACKS TO ILLUMINATE ON POWER FAILURE REGARDLESS OF LIGHT SWITCH POSITIONS. PROVIDE UNSWITCHED PHASE CONDUCTORS.
 3. PROVIDE [20] 2 WIRING FOR LIGHTS AND 12 RECEPTACLES, POWER FROM PANEL BOARD CIRCUIT AS INDICATED.
 4. EXISTING LIGHTING SYSTEM TO BE REMOVED COMPLETELY.
 5. EXIT LIGHT TO BE UNSWITCHED AND WIRE TO LINE SIDE OF THE NORMAL LIGHTING CIRCUIT.

The seal is circular with a double-lined border. The outer border contains the text "FLORIDA PROFESSIONAL ENGINEER" at the top and "D. NICHOLSON" at the bottom. The inner border contains the text "MECHANICAL ENGINEERING" at the top and "BY APPOINTMENT" at the bottom. In the center, it says "STATE OF FLORIDA" above a five-pointed star, and "LICENSE NO. 12569" below the star.

[illegible]

3011 SW WILLISTON RD GAINESVILLE, FL 32608 EB0000072 AAC001392	DAVID C NICHOLSON - PE 60201
SSWWRF NITROGEN REMOVAL AND DIGESTER MODIFICATIONS MANATEE COUNTY UTILITIES	MANATEE COUNTY, FL



CH2MHILL®	ELECTRICAL EXISTING SOUTH ELECTRICAL BLDG LIGHTING AND FACILITIES PLAN, AND DEMOLITION PLAN	ARCHITECT
-------------------------	---	------------------

VERIFY SCALE	
BAR IS ONE INCH ON ORIGINAL DRAWING. 0  1"	
DATE	APRIL 2014
PROJ	457133
DWG	600-E-2002
SHEET	of


4	3	2	ISSUED FOR BID		
---	---	---	----------------	--	--

SHEET KEYNOTES

1. SERVICE ENTRANCE LABELED.
2. SIZE BY MANUFACTURER.
3. REFER TO MCC FRONT ELEVATION FOR SPACE REQUIREMENTS.
4. PROVIDE PROVISIONS FOR FUTURE BUS EXPANSION.

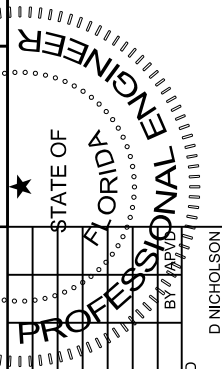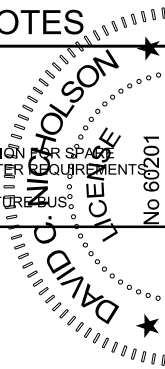


© CH2M HILL 2012. ALL RIGHTS RESERVED.

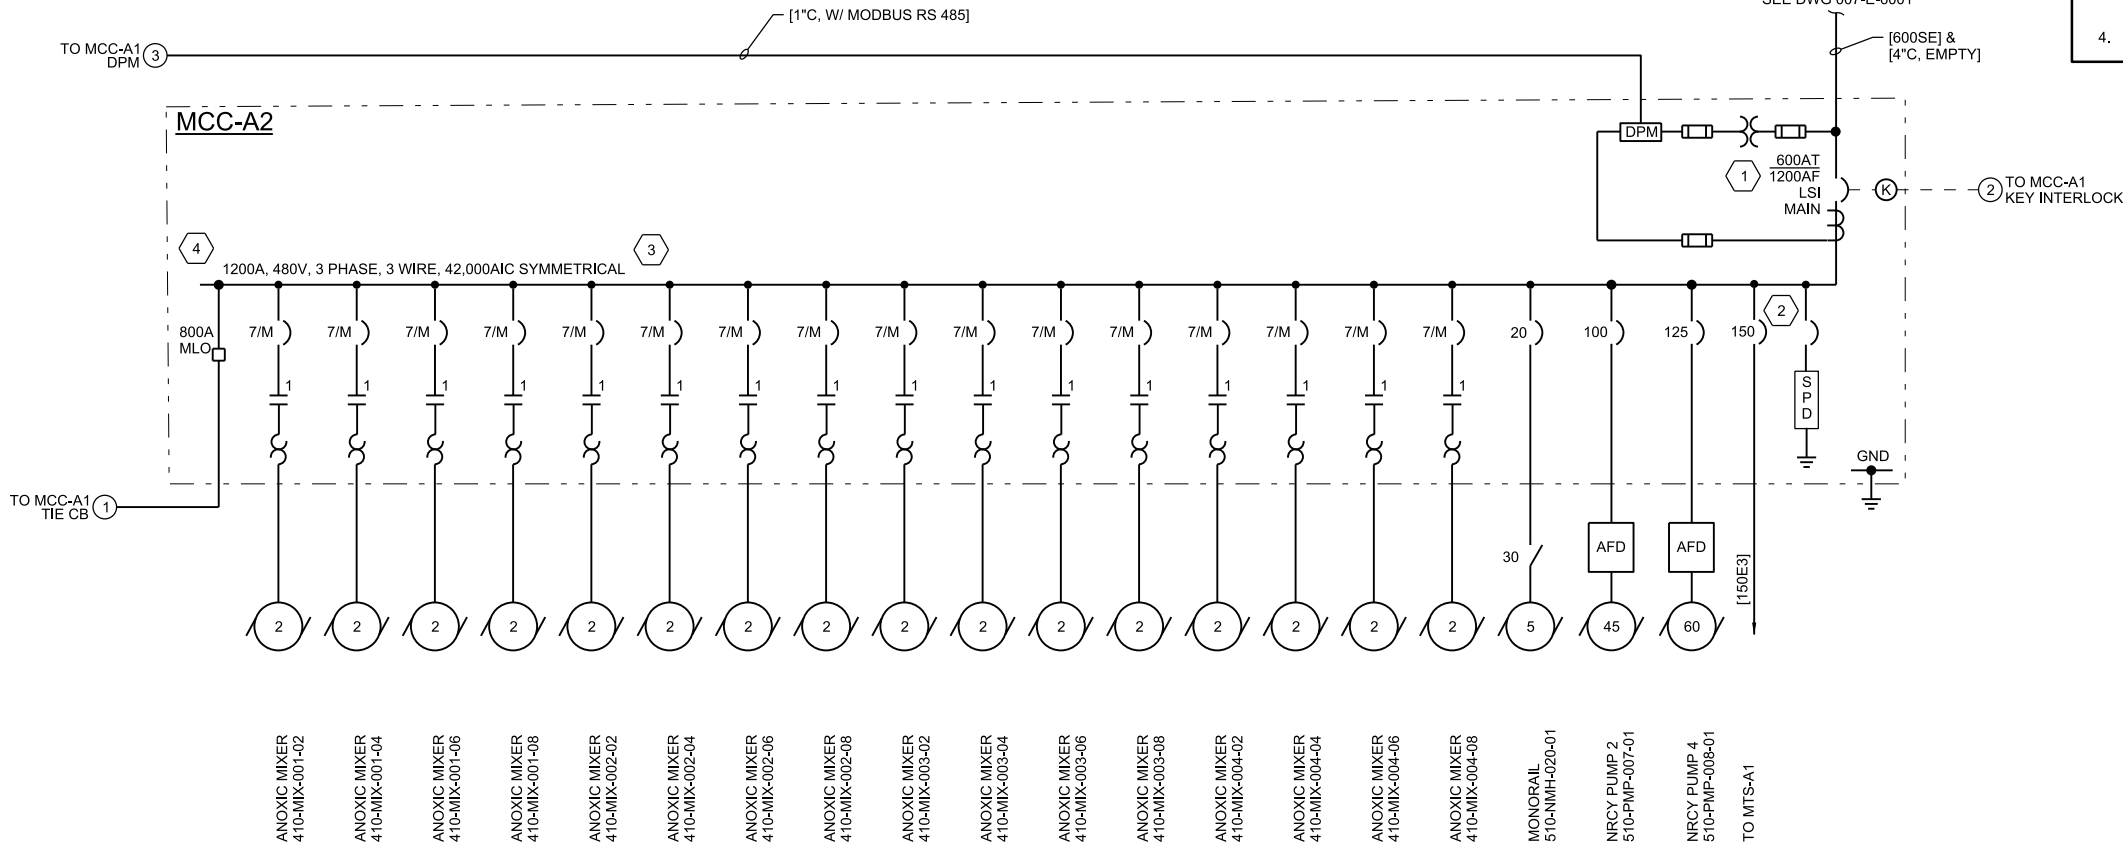

MCC-A2 ONE-LINE DIAGRAM

NTS

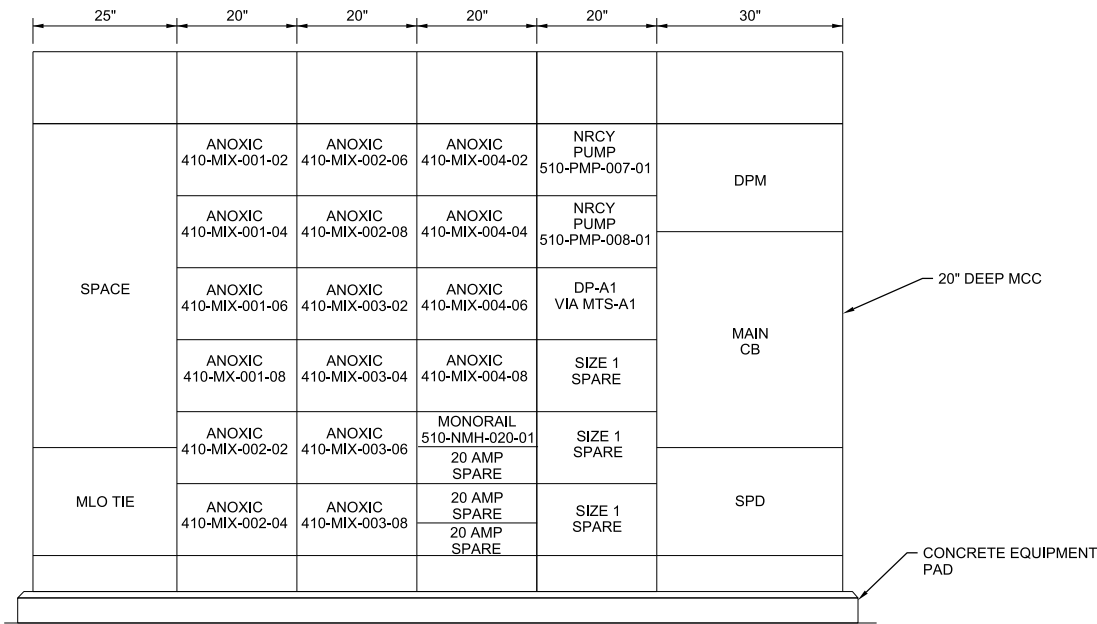

MCC-A2 FRONT ELEVATION

NTS

MCC-A2 CONNECTED LOAD	
DESCRIPTION	AMPS
410-MIX-001-02	3.4
410-MIX-001-04	3.4
410-MIX-001-06	3.4
410-MIX-001-08	3.4
410-MIX-002-02	3.4
410-MIX-002-04	3.4
410-MIX-002-06	3.4
410-MIX-002-08	3.4
410-MIX-003-02	3.4
410-MIX-003-04	3.4
410-MIX-003-06	3.4
410-MIX-003-08	3.4
410-MIX-040-02	3.4
410-MIX-004-04	3.4
410-MIX-004-06	3.4
410-MIX-004-08	3.4
510-NMH-020-01	7.6
510-PMP-007-01	60.0
510-PMP-008-01	77.0
TOTALS	199.0
TOTAL PLUS 25% OF LARGER MOTOR	218.25

3011 SW WILLISTON RD
GAINESVILLE, FL 32608
EB0000072 - AAC001982
DAVID C NICHOLSON - PE 60201


CH2MHILL®
ELECTRICAL
EXISTING SOUTH ELECTRICAL BLDG
MCC-A2 ONE LINE DIAGRAM
AND ELEVATION

SWWRf NITROGEN REMOVAL
AND DIGESTER MODIFICATIONS
MANATEE COUNTY UTILITIES
MANATEE COUNTY, FL

VERIFY SCALE	
BAR IS ONE INCH ON ORIGINAL DRAWING. 1" = 1'	
DATE	DECEMBER 2013
PROJ	457133
DWG	600-E-6002
SHEET	of

ISSUED FOR BID

ANOXIC MIXER 410-MIX-00(X)-0(Y)
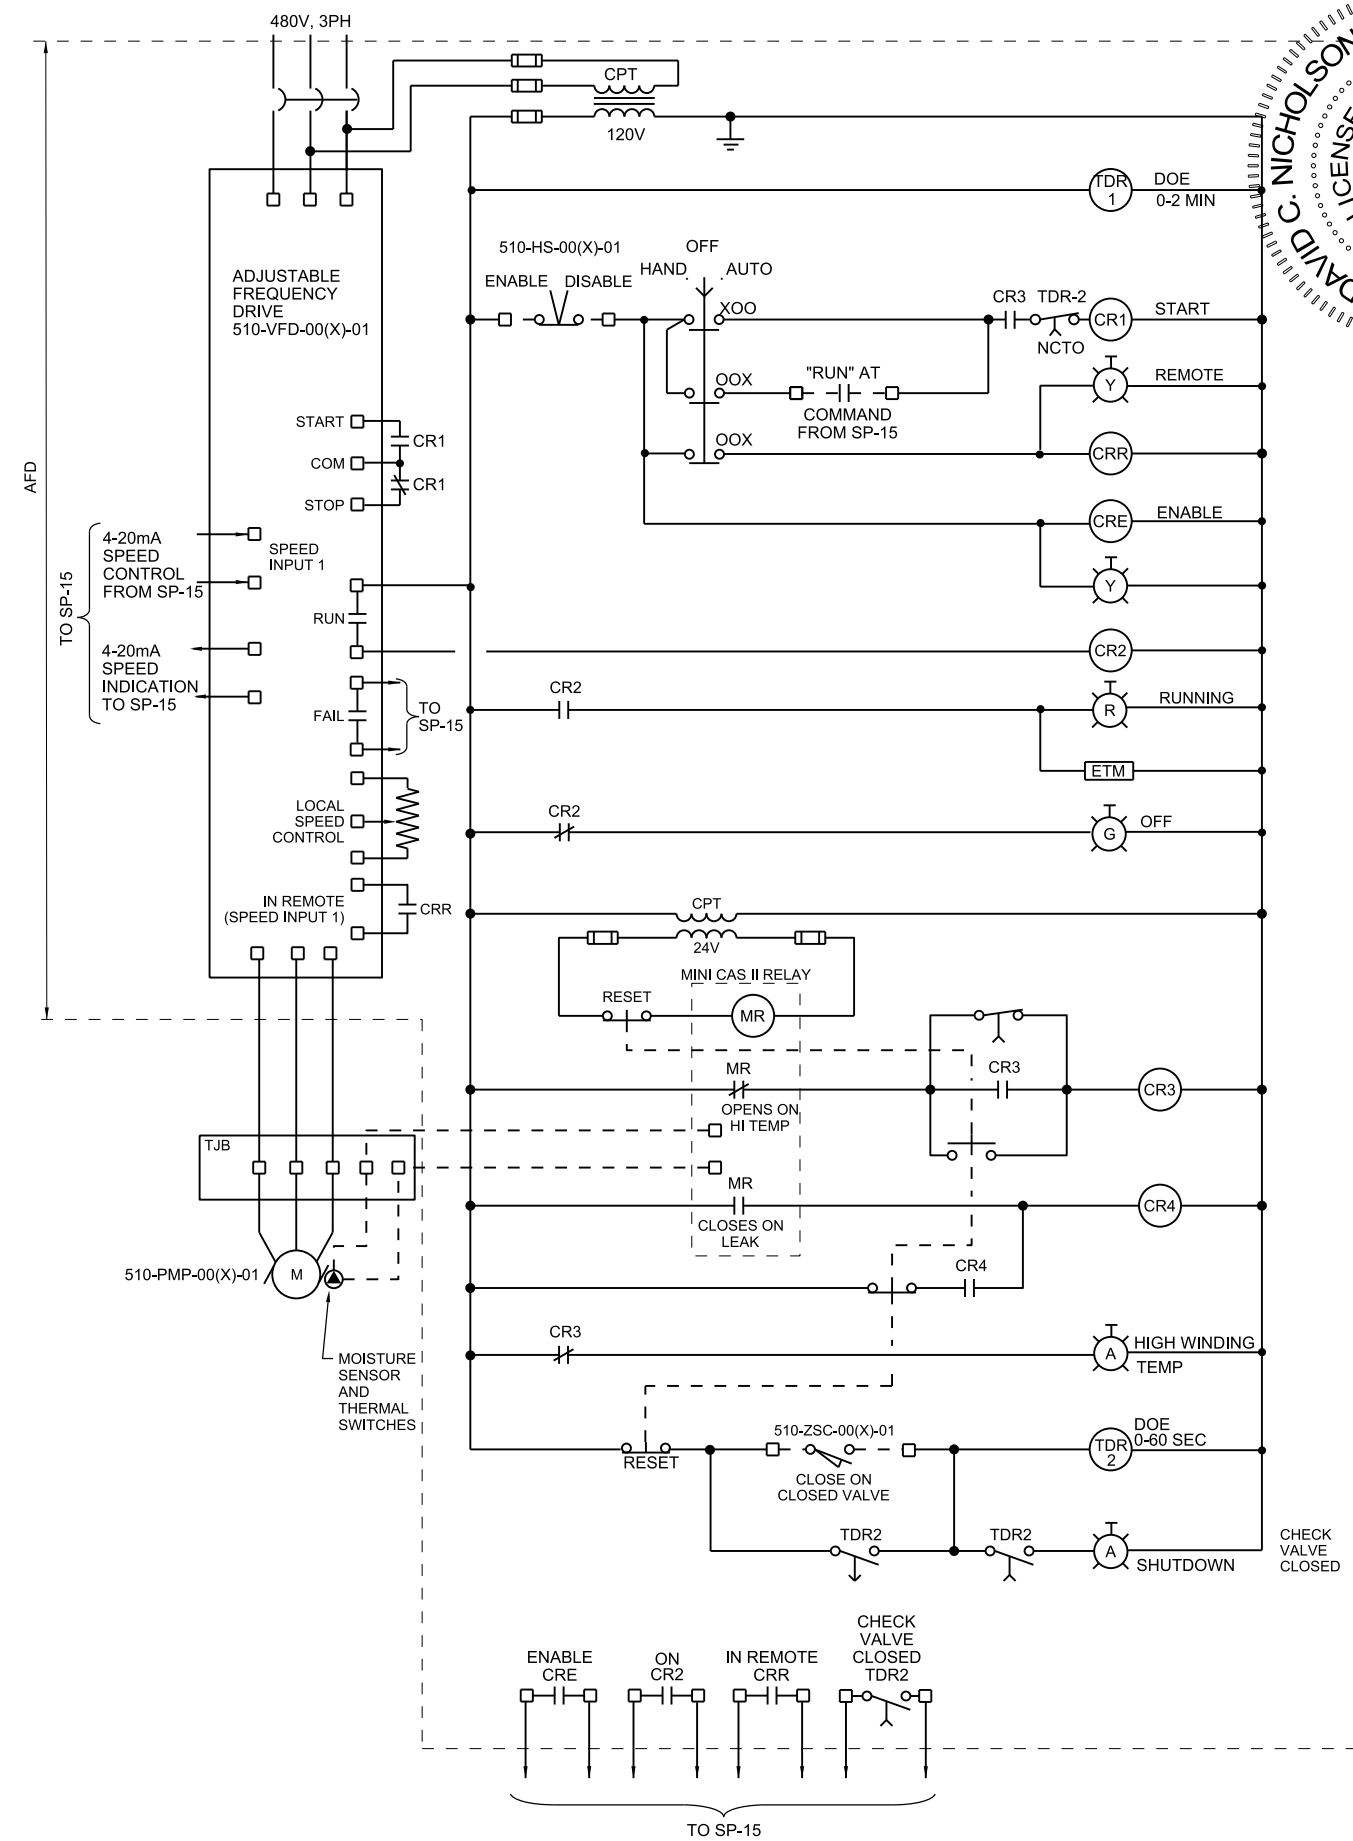
$$\begin{aligned}(X) &= 1, 2, 3, 4 \\ (Y) &= 1, 2, 3, 4, 5, 6, 7, 8\end{aligned}$$


NRCY PUMP 510-PMP-00(X)-01

$$(X) = 5, 6, 7, 8$$

CH2MHILL®

ELECTRICAL EXISTING SOUTH ELECTRICAL BLDG CONTROL & RISER DIAGRAM

VERIFY SCALE	
BAR IS ONE INCH ON ORIGINAL DRAWING.	
0	1"
DATE	DECEMBER 2013
PROJ	457133
DWG	600-E-6003
SHEET	of

ISSUED FOR BID

3011 SW WILLISTON RD
GAINESVILLE, FL 32608
EB0000072 AAC001992
DAVID C NICHOLSON - PE 60201

SWWRF NITROGEN REMOVAL
AND DIGESTER MODIFICATIONS
MANATEE COUNTY UTILITIES
MANATEE COUNTY, FL

©CH2M HILL 2012. ALL RIGHTS RESERVED.


	N ADAMS	N ADAMS	N ADAMS
REUSE OF DOCUMENTS:	THIS DOCUMENT, AND THE IDEAS AND DESIGNS INCORPORATED HEREIN, AS AN INSTRUMENT OF PROFESSIONAL SERVICE, IS THE PROPERTY OF CH2M HILL AND IS NOT TO BE USED, IN WHOLE OR IN PART, FOR ANY OTHER PROJECT WITHOUT THE WRITTEN AUTHORIZATION OF CH2M HILL.		

PANEL: DP-A1				LOCATION: SOUTH ELECTRICAL BUILDING 600			
SERVICE VOLTAGE: 480Y/277V				PHASE: 3		WIRE: 4	
TOTAL LOAD KVA: 52.2				BUS SIZE: 200		MAIN SIZE: 150	
REMARKS: INTERGRAL SPD				NEUTRAL: N/A		MOUNTING: SURFACE	
						TYPE CB	
						AIC: 42K	


LOAD IN KVA			CIRCUIT DESCRIPTION	BKR A/P	CKT NO.	CKT NO.	BKR A/P	CIRCUIT DESCRIPTION	LOAD IN KVA		
A	B	C							A	B	C
10.0			XFMR/PANELBOARD LP-A1	60/3	1	2	15/3	600-AC-1	3.7		
	10.0				3	4				3.7	
		10.0			5	6					3.7
					7	8	15/3	600-AC-2	3.7		
					9	10				3.7	
					11	12					3.7
					13	14					
					15	16					
					17	18					
					19	20					
					21	22					
					23	24					
					25	26					
					27	28					
					29	30					
					31	32					
					33	34					
					35	36					
					37	38	30/3	SPD			
					39	40					
					41	42					
10.0	10.0	10.0	TOTAL						7.4	7.4	7.4

PANEL: LP-A1				LOCATION: SOUTH ELECTRICAL BUILDING 600							
SERVICE VOLTAGE: 208Y/120V				PHASE: 3				WIRE: 4			
TOTAL LOAD KVA: 7.0				BUS SIZE: 100				MAIN SIZE: 100			
REMARKS: INTREGRAL SPD				NEUTRAL: FULL				MOUNTING: SURFACE			
								TYPE: CB			
								AIC: 22K			

LOAD IN KVA			CIRCUIT DESCRIPTION	BKR A/P	CXT NO.	CXT NO.	BKR A/P	CIRCUIT DESCRIPTION	LOAD IN KVA		
A	B	C							A	B	C
0.3			LIGHTS: SPLITTER BOX 1	20/1	1	2	20/1	LIGHTS ELECTRICAL ROOM	0.7		
	0.3		LIGHTS: SPLITTER BOX 2	20/1	3	4	20/1	RECPTS ELECRM WEST		0.7	
		0.2	RECEPT SPLITTER BOX 1	20/1	5	6	20/1	RECPTS ELECRM EAST			0.7
0.2			RECEPT SPLITTER BOX 2	20/1	7	8	20/1	SP-15	1.5		
	1.0		RECEPT SPLITTER BOX 1	30/1	9	10	20/1	410-FAP-001-01		0.5	
		1.0	RECEPT SPLITTER BOX 2	30/1	11	12					
					13	14					
					15	16					
					17	18					
					19	20					
					21	22					
					23	24					
					25	26					
					27	28					
					29	30					
					31	32					
					33	34					
					35	36					
					37	38	30/3	SPD			
					39	40					
					41	42					
0.5	1.3	1.2	TOTAL						2.2	1.2	0.7

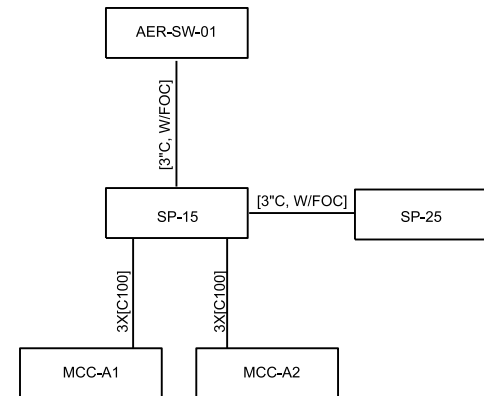

OVERALL RISER DIAGRAM

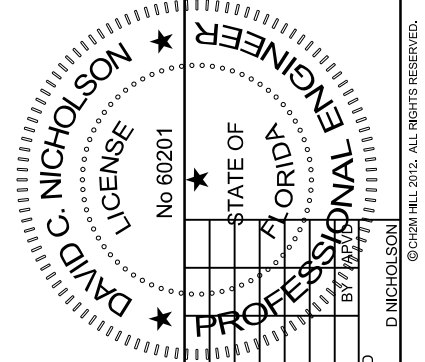[illegible]

3011 SW WILLISTON RD GAINESVILLE, FL 32608 EB0000072 AAC001992 DAVID C NICHOLSON - PE 60201	SWWRF NITROGEN REMOVAL AND DIGESTER MODIFICATIONS MANATEE COUNTY UTILITIES MANATEE COUNTY, FL	DOCUMENTS: THE DRAUGHT AND THE DEAS AND DESIGNS FOR THE CHEMICAL AND NOT TO BE RE-USED IN WHERE OF
---	---	--



CH2MHILL®


ELECTRICAL

EXISTING SOUTH ELECTRICAL BLDG PANELBOARD SCHEDULES

VERIFICATION	
VERIFY SCALE	
BAR IS ONE INCH ON ORIGINAL DRAWING.	
0	1"
DATE	DECEMBER 2013
PROJ	457133
DWG	600-E-6004
SHEET	of

3
3
4
ISSUED FOR BID

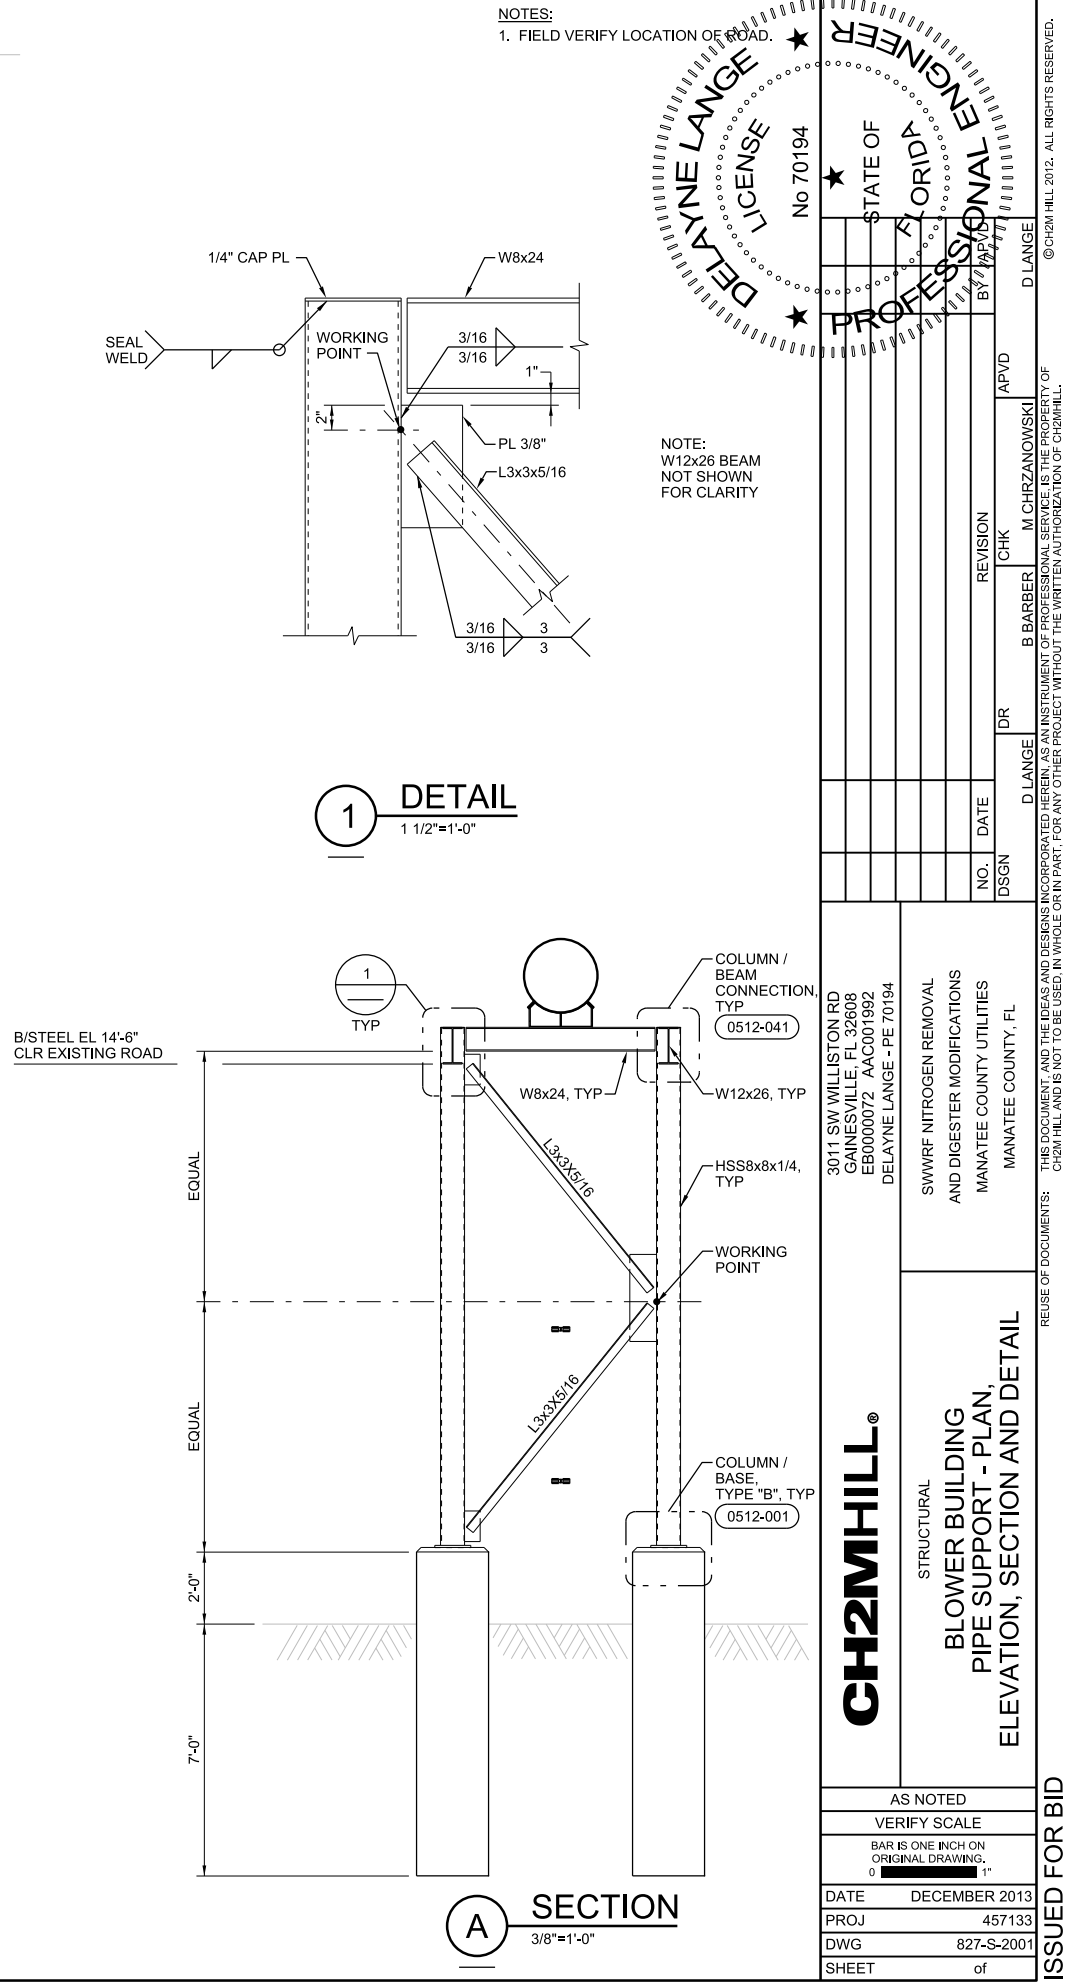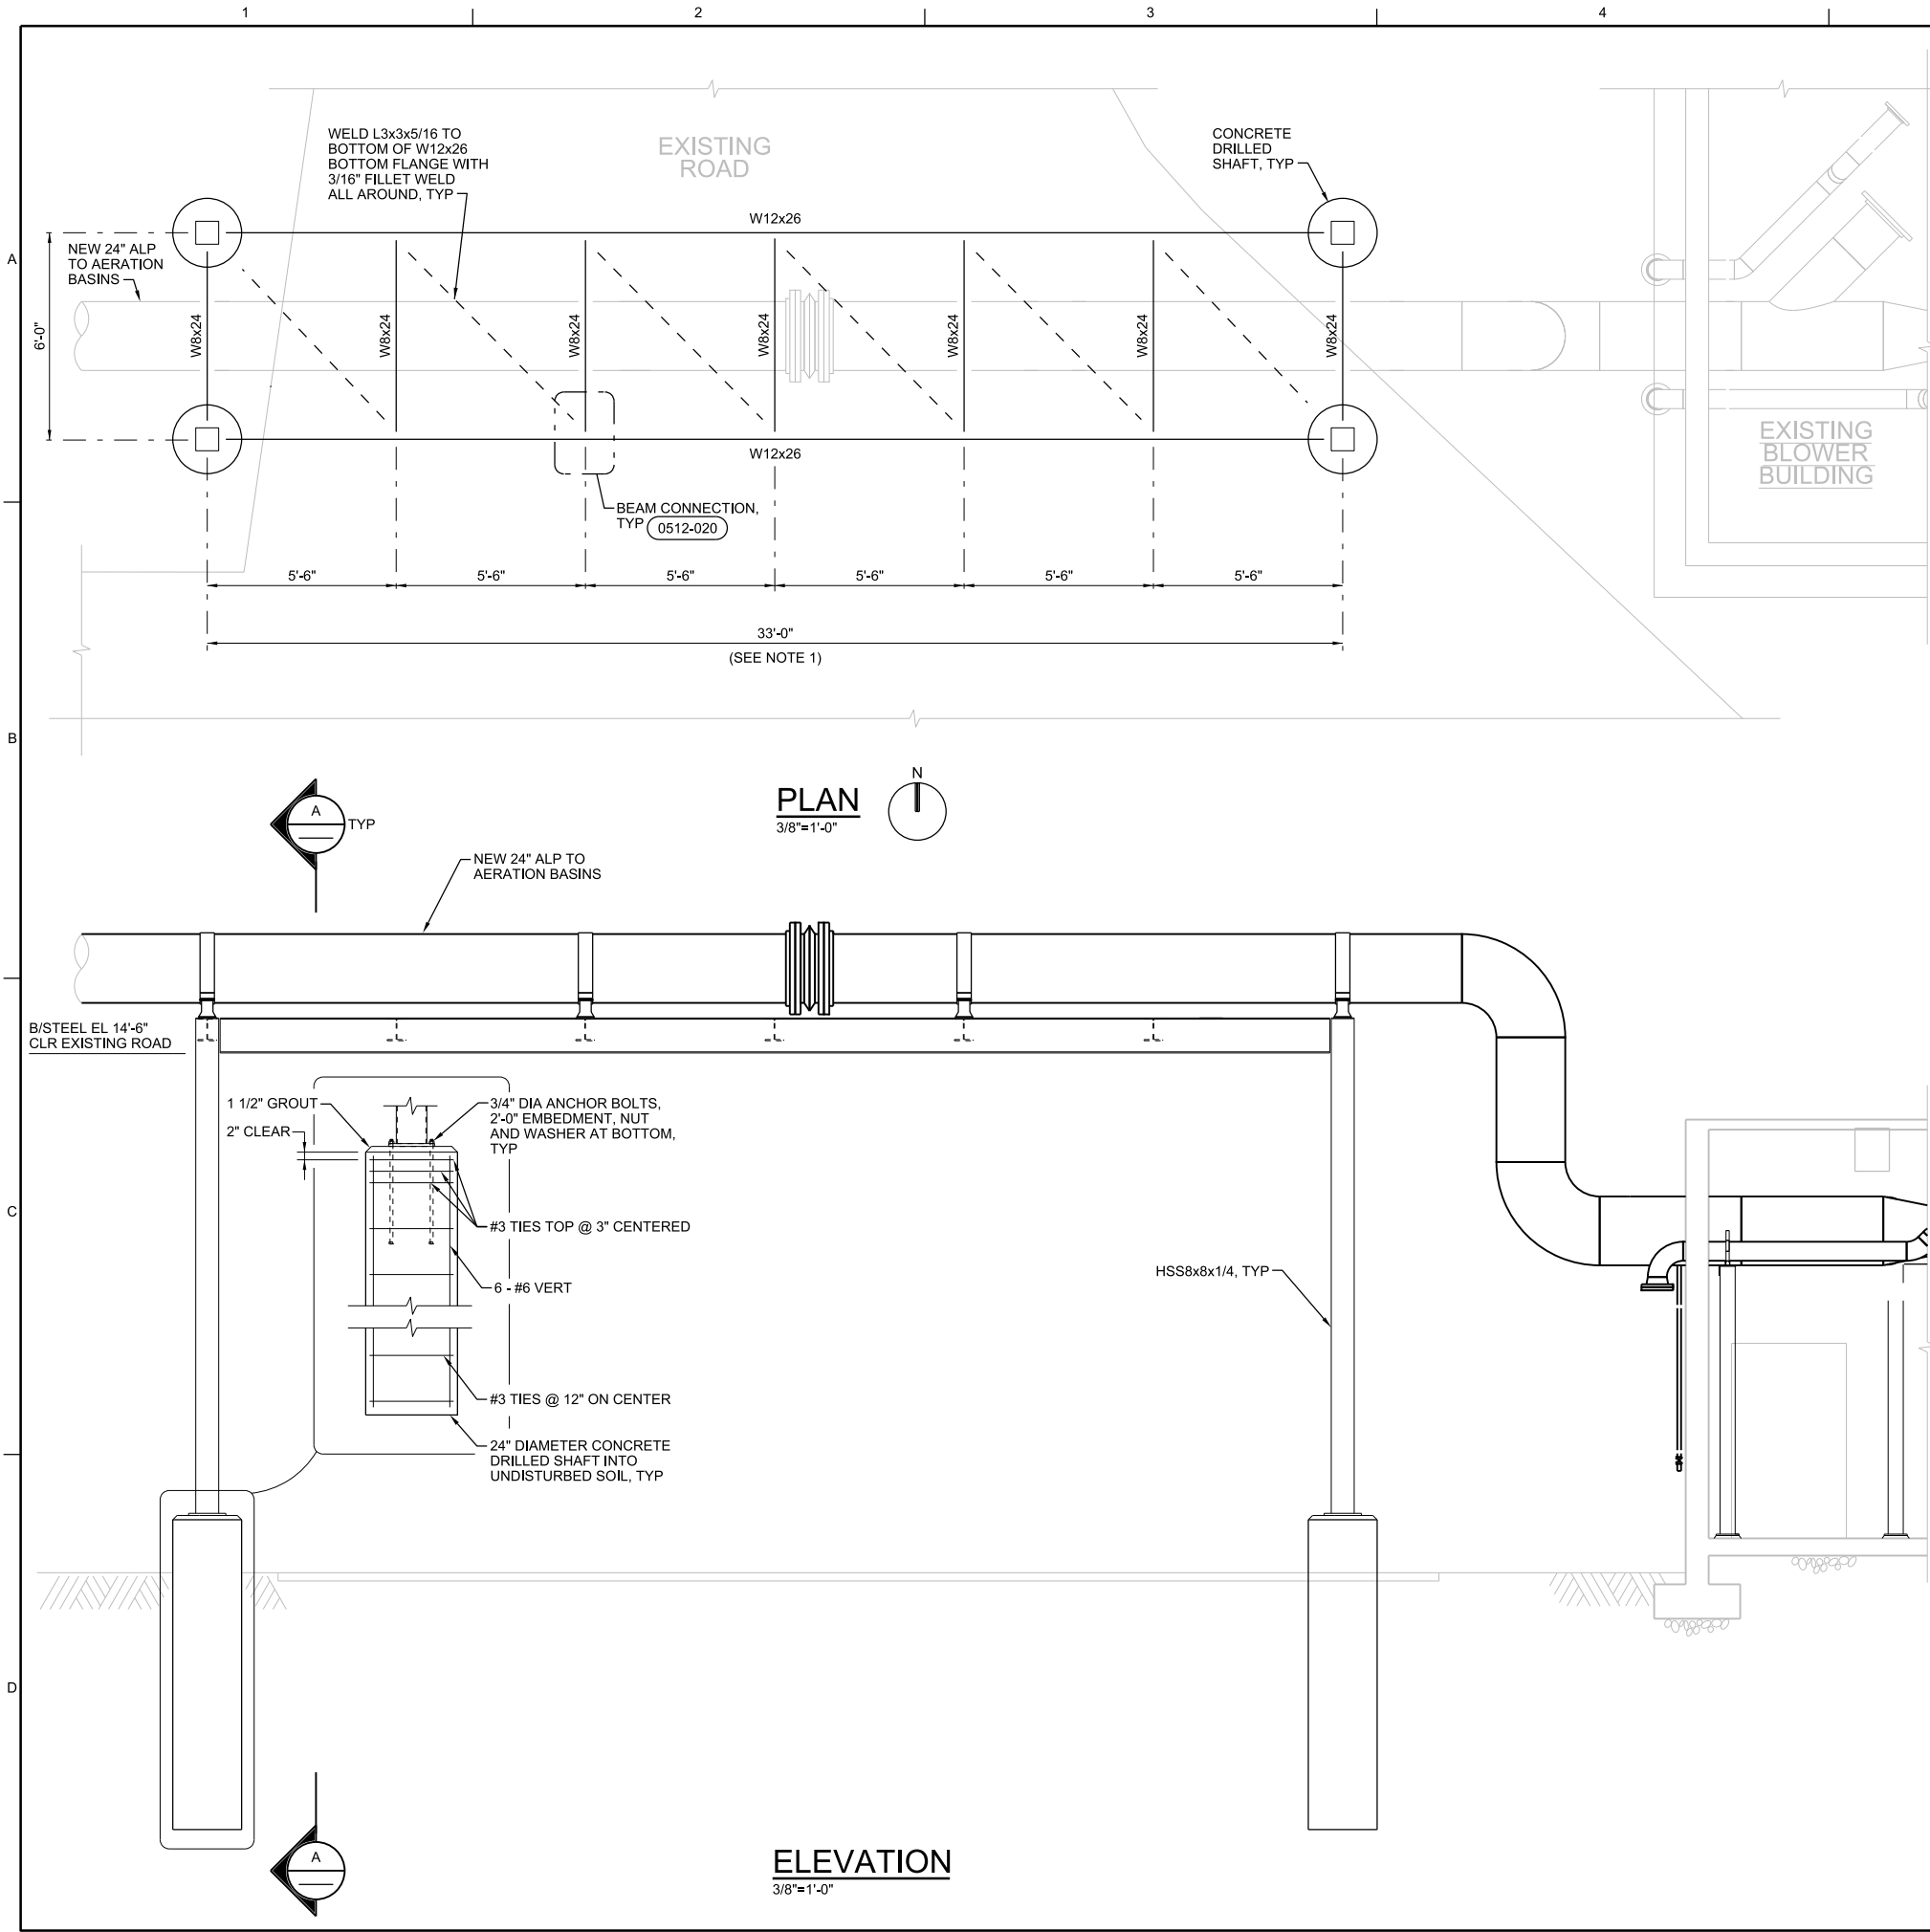

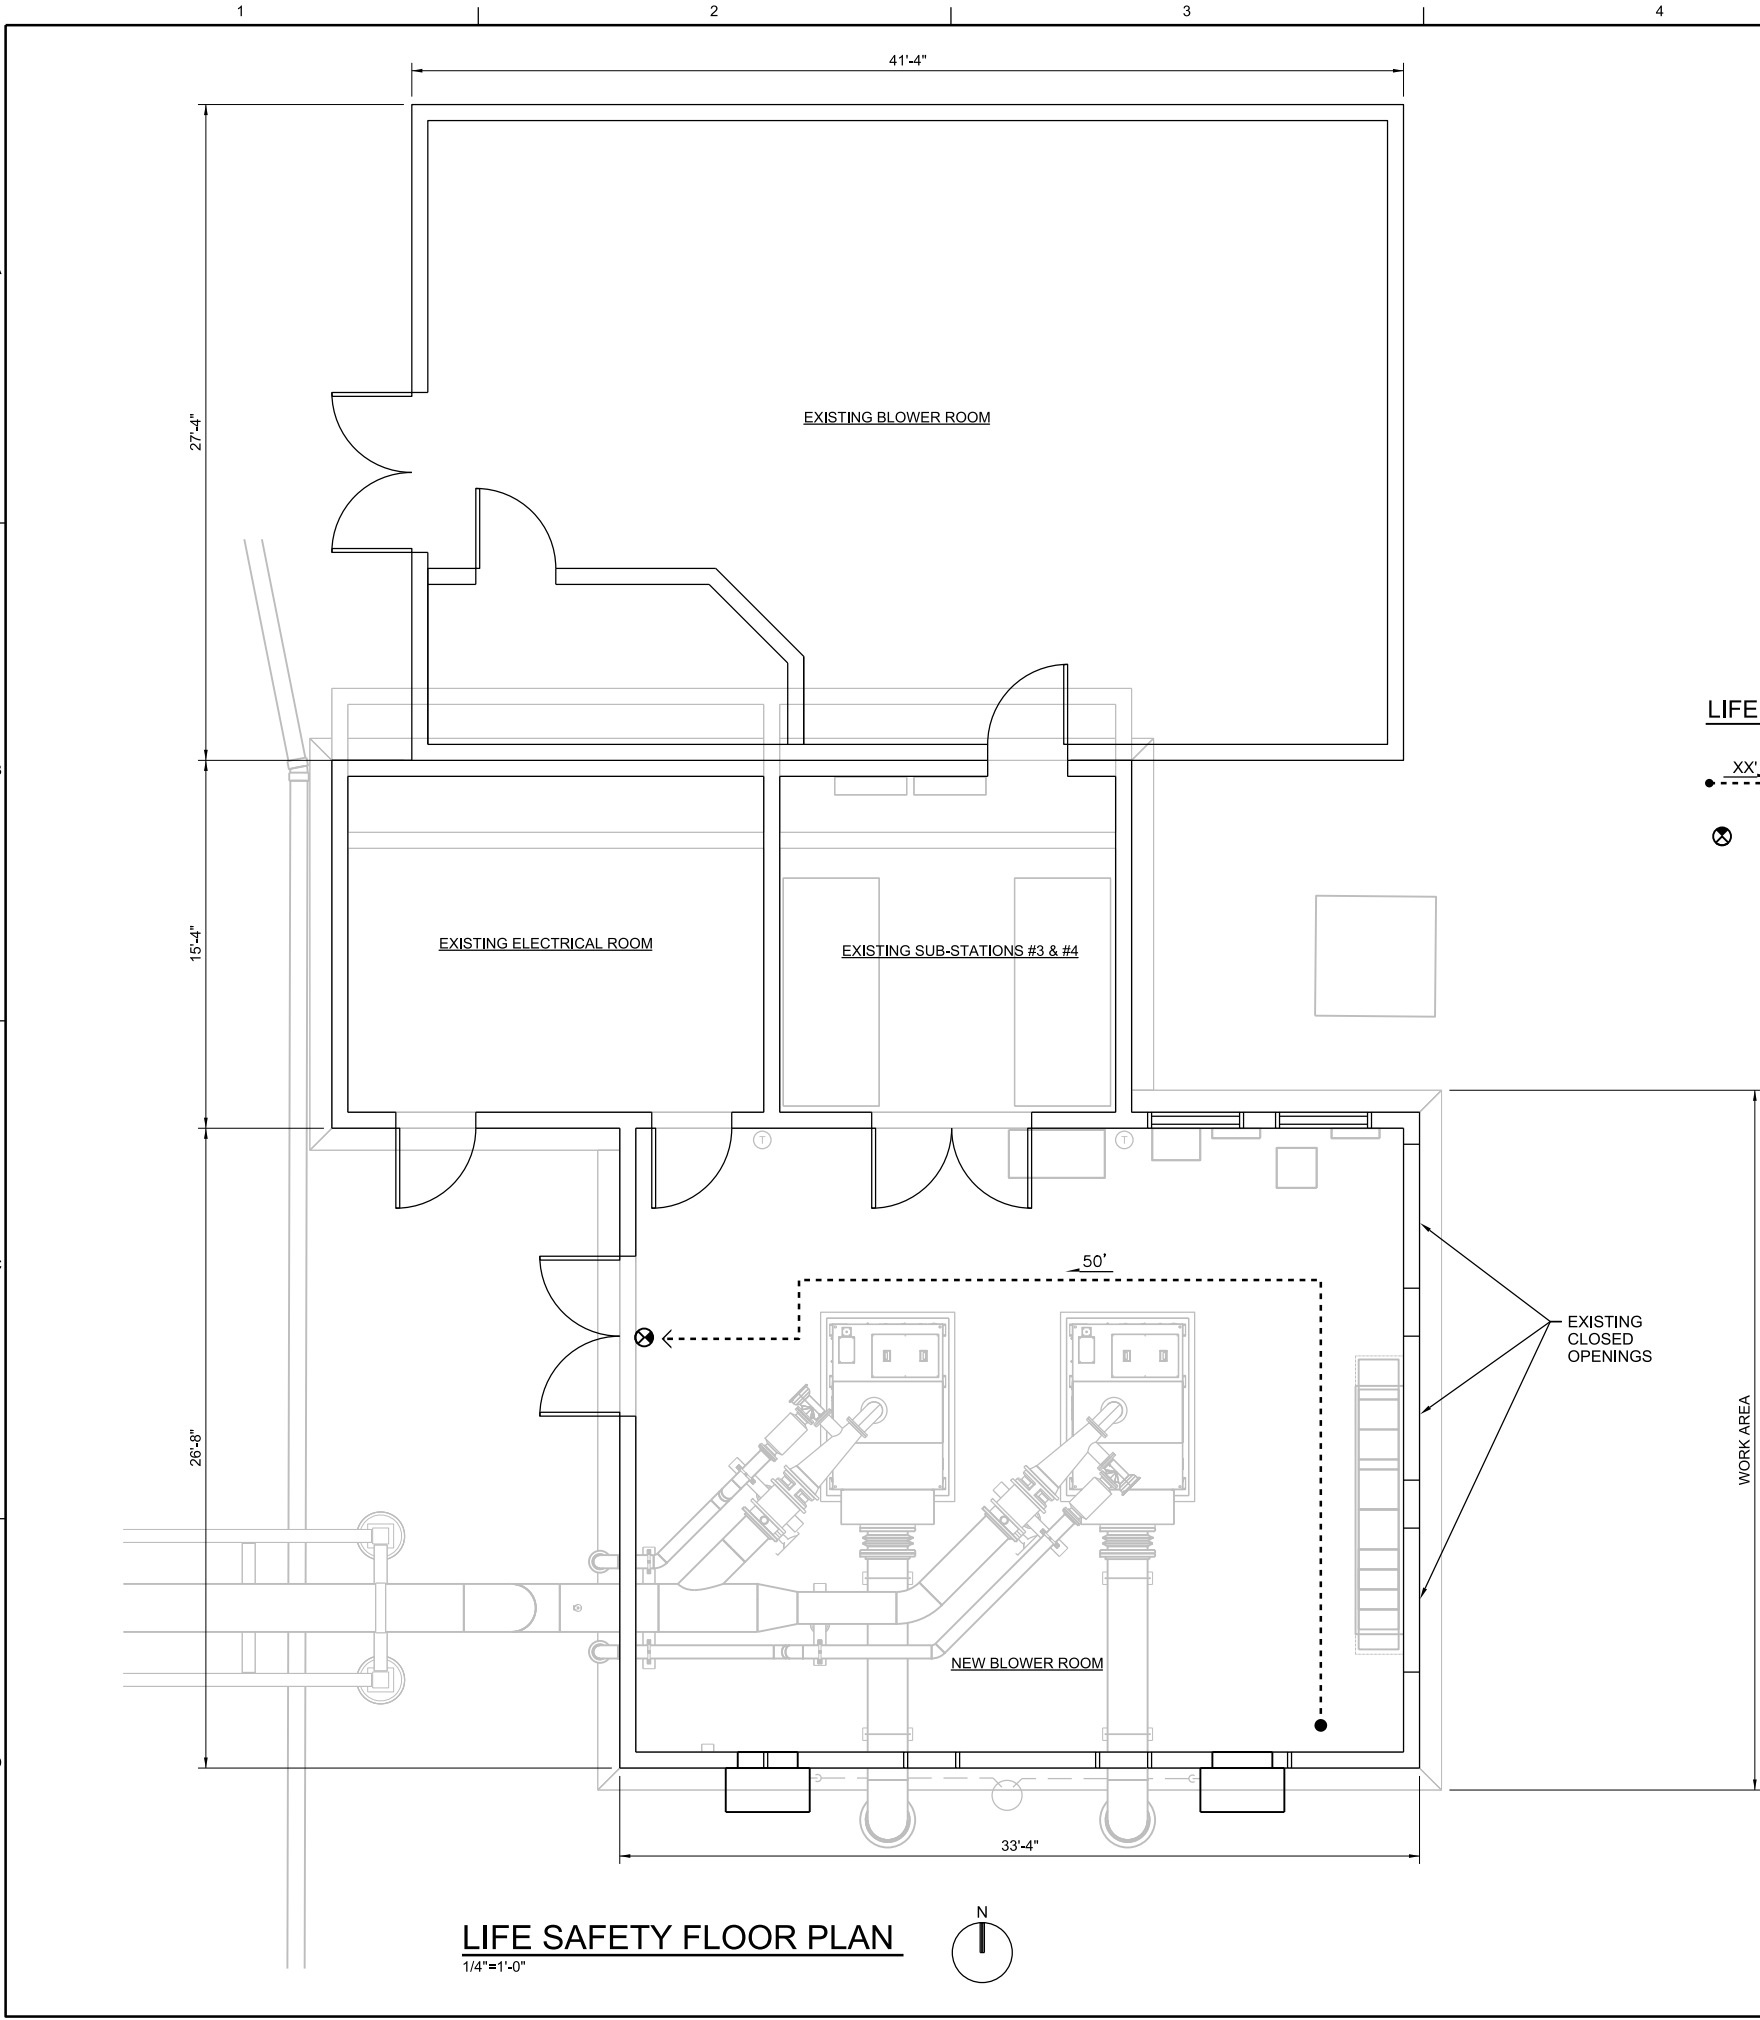

PLUMBING		
NO TOILET FACILITIES INCLUDING POTABLE DRINKING WATER ARE PROVIDED. SCALEHOUSE FACILITY IS WITHIN 500 FEET.		
FIRE SEPARATION REQUIREMENTS		
ACTUAL FIRE SEPARATION DISTANCE (TABLE 602)	20 FT OR GREATER	0 HR
DISTANCE FROM ADJACENT BUILDING OR PROPERTY LINE	20 FT OR GREATER	0 HR
FIRE PROTECTION		
SPRINKLERS	NOT PROVIDED	
FIRE EXTINGUISHERS	EXISTING	
EXIT LIGHTING	EXISTING	

APPLICABLE CODES	
2010 FLORIDA BUILDING CODE 2010 FLORIDA EXISTING BUILDING CODE 2010 FLORIDA PLUMBING CODE 2010 FLORIDA MECHANICAL CODE 2010 FLORIDA FIRE PREVENTION CODE NATIONAL ELECTRICAL CODE, 2011 EDITION	
DESCRIPTION	
THIS EXISTING ROOM IN AN EXISTING BLOWER BUILDING IS BEING PUT INTO USE AS HOUSING NEW BLOWERS.	
EXISTING BUILDING CODE	
CLASSIFICATION OF WORK	ALTERATION LEVEL 1

PROJECT CODE DATA		2012 FBC
BUILDING: EXISTING BLOWER BUILDING		
GENERAL INFORMATION		
USE AND OCCUPANCY CLASSIFICATION	ASSUMED F-1 OR UTILITY	
CONSTRUCTION CLASSIFICATION	ASSUMED TYPE VB UNPROTECTED	
AREA AND HEIGHT LIMITATIONS		
MAXIMUM ALLOWABLE AREA (TABLE 503)	5,500 SF	
ACTUAL AREA: (TOTAL EXISTING BUILDING)	2,538 SF (900 SF BLOWER RM)	
ACTUAL PER FLOOR: (TOTAL AFFECTED SF)	900 SF	
MAXIMUM ALLOWABLE STORIES:	1	
ACTUAL NUMBER OF STORIES:	1	
MAXIMUM ALLOWABLE HEIGHT:	40'-0"	
ACTUAL HEIGHT:	EXISTING TO REMAIN	

OCCUPANCY / EGRESS INFORMATION	
DESIGN OCCUPANCY (TABLE 1004.1.1)	3 PERSONS
ACTUAL NUMBER OF OCCUPANTS	3 MAXIMUM
EGRESS WIDTH BASED ON OCCUPANCY (TABLE 1005.1)	36" PROVIDED
ALLOWABLE DEAD END LENGTH (SECTION 1018.4)	20 FT
NUMBER OF EXITS (SECTION 1021.2)	2
NUMBER OF EXITS (SECTION 1015.1)	75 FT 1 MEANS OF EGRESS
ALLOWABLE COMMON PATH OF TRAVEL (SECTION 1014.3)	75 FEET
MAX TRAVEL DISTANCE ALLOWED (SECTION 1016.1)	200 FEET

REQUIRED FIRE RESISTANT RATINGS	
BUILDING ELEMENTS (TABLE 601)	VB
STRUCTURAL FRAME	0 HR
EXTERIOR BEARING WALLS	0 HR
INTERIOR BEARING WALLS	0 HR
INTERIOR NON-BEARING WALLS	0 HR
FLOOR CONSTRUCTION	0 HR
ROOF CONSTRUCTION	0 HR
SHAFT ENCLOSURE (707.4)	N/A
STAIRWAY ENCLOSURE (1019.1)	N/A
CORRIDOR (TABLE 1016.1)	N/A
OCCUPANCY SEPARATION (302.3.2)	N/A
INCIDENTAL USE AREAS (302.1.1)	N/A

3011 SW WILLISTON RD
GAINESVILLE, FL 32608
EB0000072 - AAC001992
BETH TRAUTWEIN - AR 91388

SWWRf NITROGEN REMOVAL
AND DIGESTER MODIFICATIONS
MANATEE COUNTY UTILITIES
MANATEE COUNTY, FL

ARCHITECTURAL

EXISTING BLOWER BUILDING
LIFE SAFETY PLAN

VERIFY SCALE
BAR IS ONE INCH ON
ORIGINAL DRAWING.
0 1"

DATE APRIL 2014
PROJ 457133
DWG 827-A-0001
SHEET of

NO. DATE DSGN

DR

REVISION

BY APVD

A COULLLIAS



A COULLLIAS

A DOLSAK

B TRAUTWEIN

REUSE OF DOCUMENTS: THIS DOCUMENT, AND THE IDEAS AND DESIGNS INCORPORATED HEREIN, AS AN INSTRUMENT OF PROFESSIONAL SERVICE, IS THE PROPERTY OF CH2M HILL AND IS NOT TO BE USED, IN WHOLE OR IN PART, FOR ANY OTHER PROJECT WITHOUT THE WRITTEN AUTHORIZATION OF CH2M HILL.

© CH2M HILL 2012. ALL RIGHTS RESERVED.

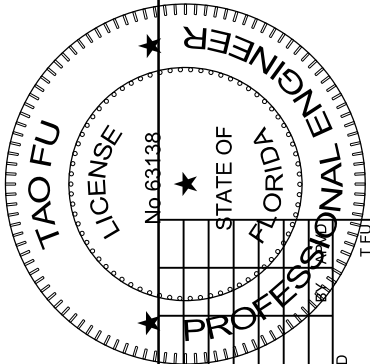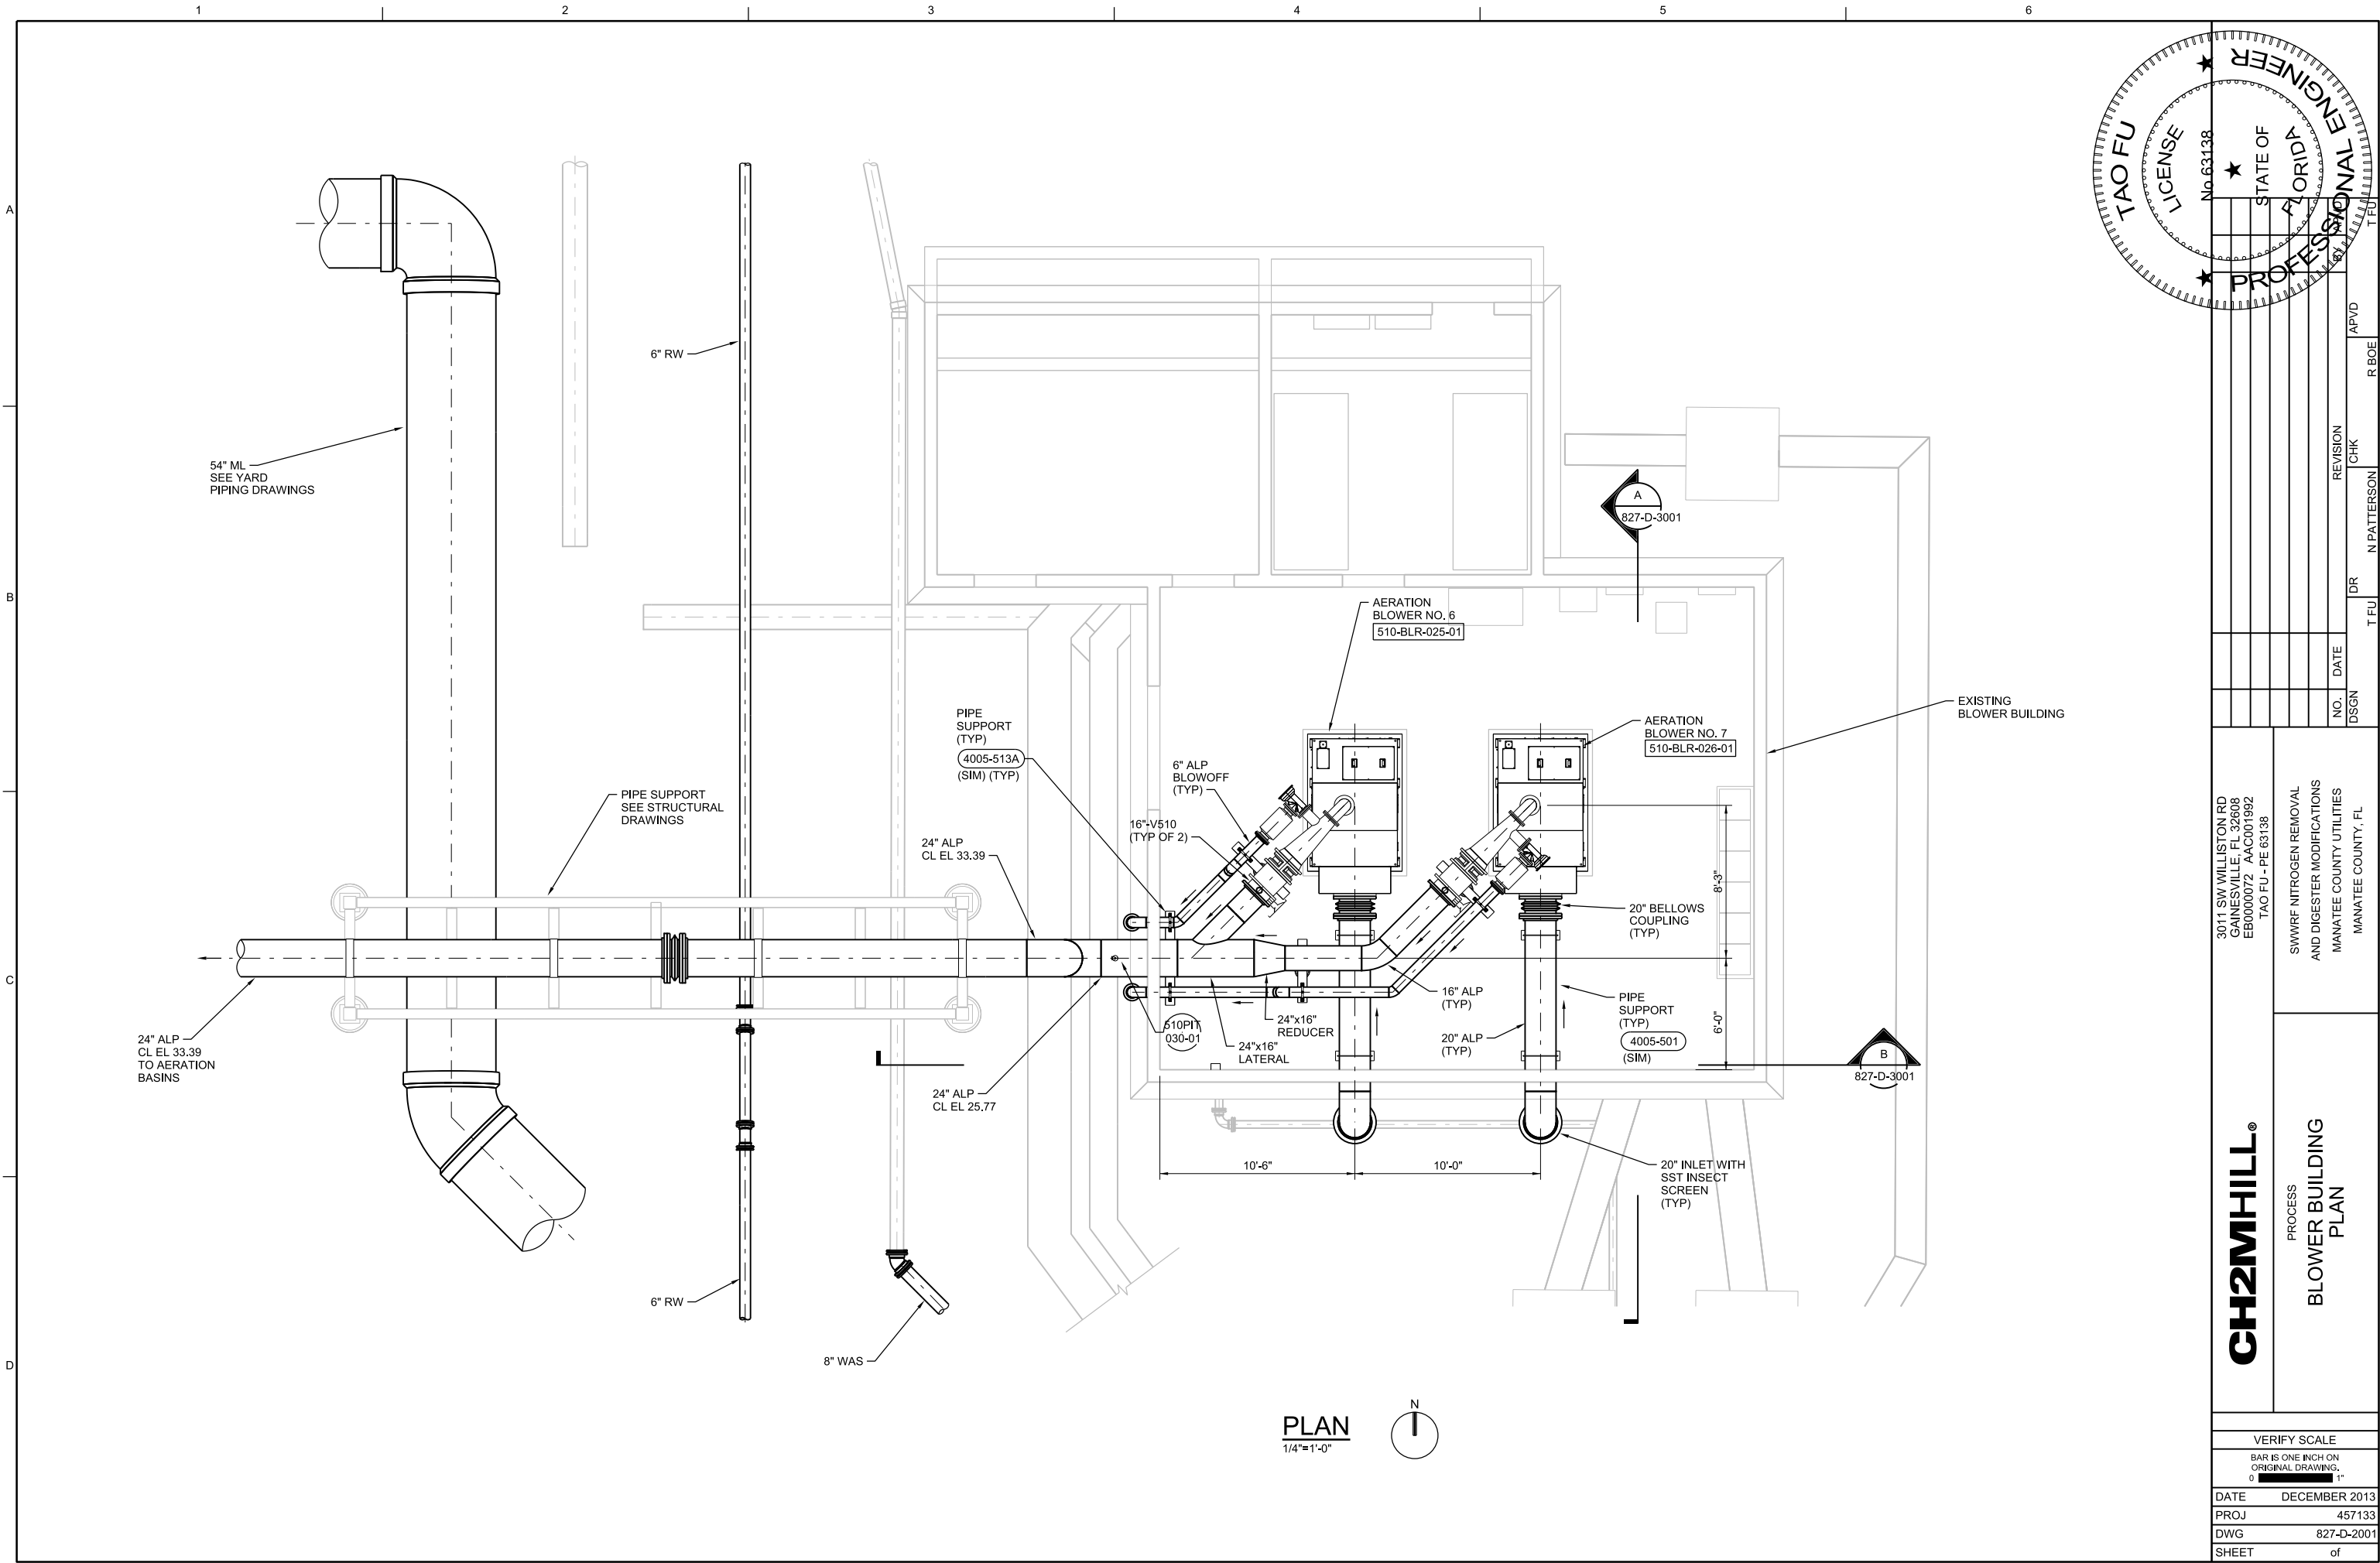

3011 SW WILLISTON RD
GAINESVILLE, FL 32608
EB0000072 - AAC001992
TAO FU - PE 63138

SWWRF NITROGEN REMOVAL
AND DIGESTER MODIFICATIONS
MANATEE COUNTY UTILITIES
MANATEE COUNTY, FL

CH2MHILL®



PROCESS
**BLOWER BUILDING
PLAN**

VERIFY SCALE	
BAR IS ONE INCH ON ORIGINAL DRAWING. 1"	
DATE	DECEMBER 2013
PROJ	457133
DWG	827-D-2001
SHEET	of

ISSUED FOR BID

REUSE OF DOCUMENTS: THIS DOCUMENT, AND THE IDEAS AND DESIGNS INCORPORATED HEREIN, AS AN INSTRUMENT OF PROFESSIONAL SERVICE, IS THE PROPERTY OF CH2M HILL AND IS NOT TO BE USED, IN WHOLE OR IN PART, FOR ANY OTHER PROJECT WITHOUT THE WRITTEN AUTHORIZATION OF CH2M HILL.

© CH2M HILL 2012. ALL RIGHTS RESERVED.

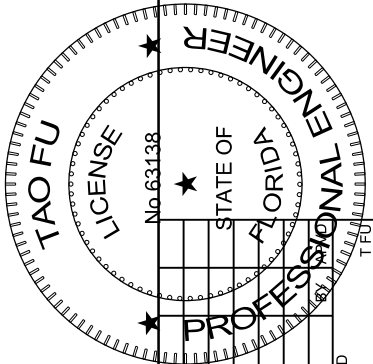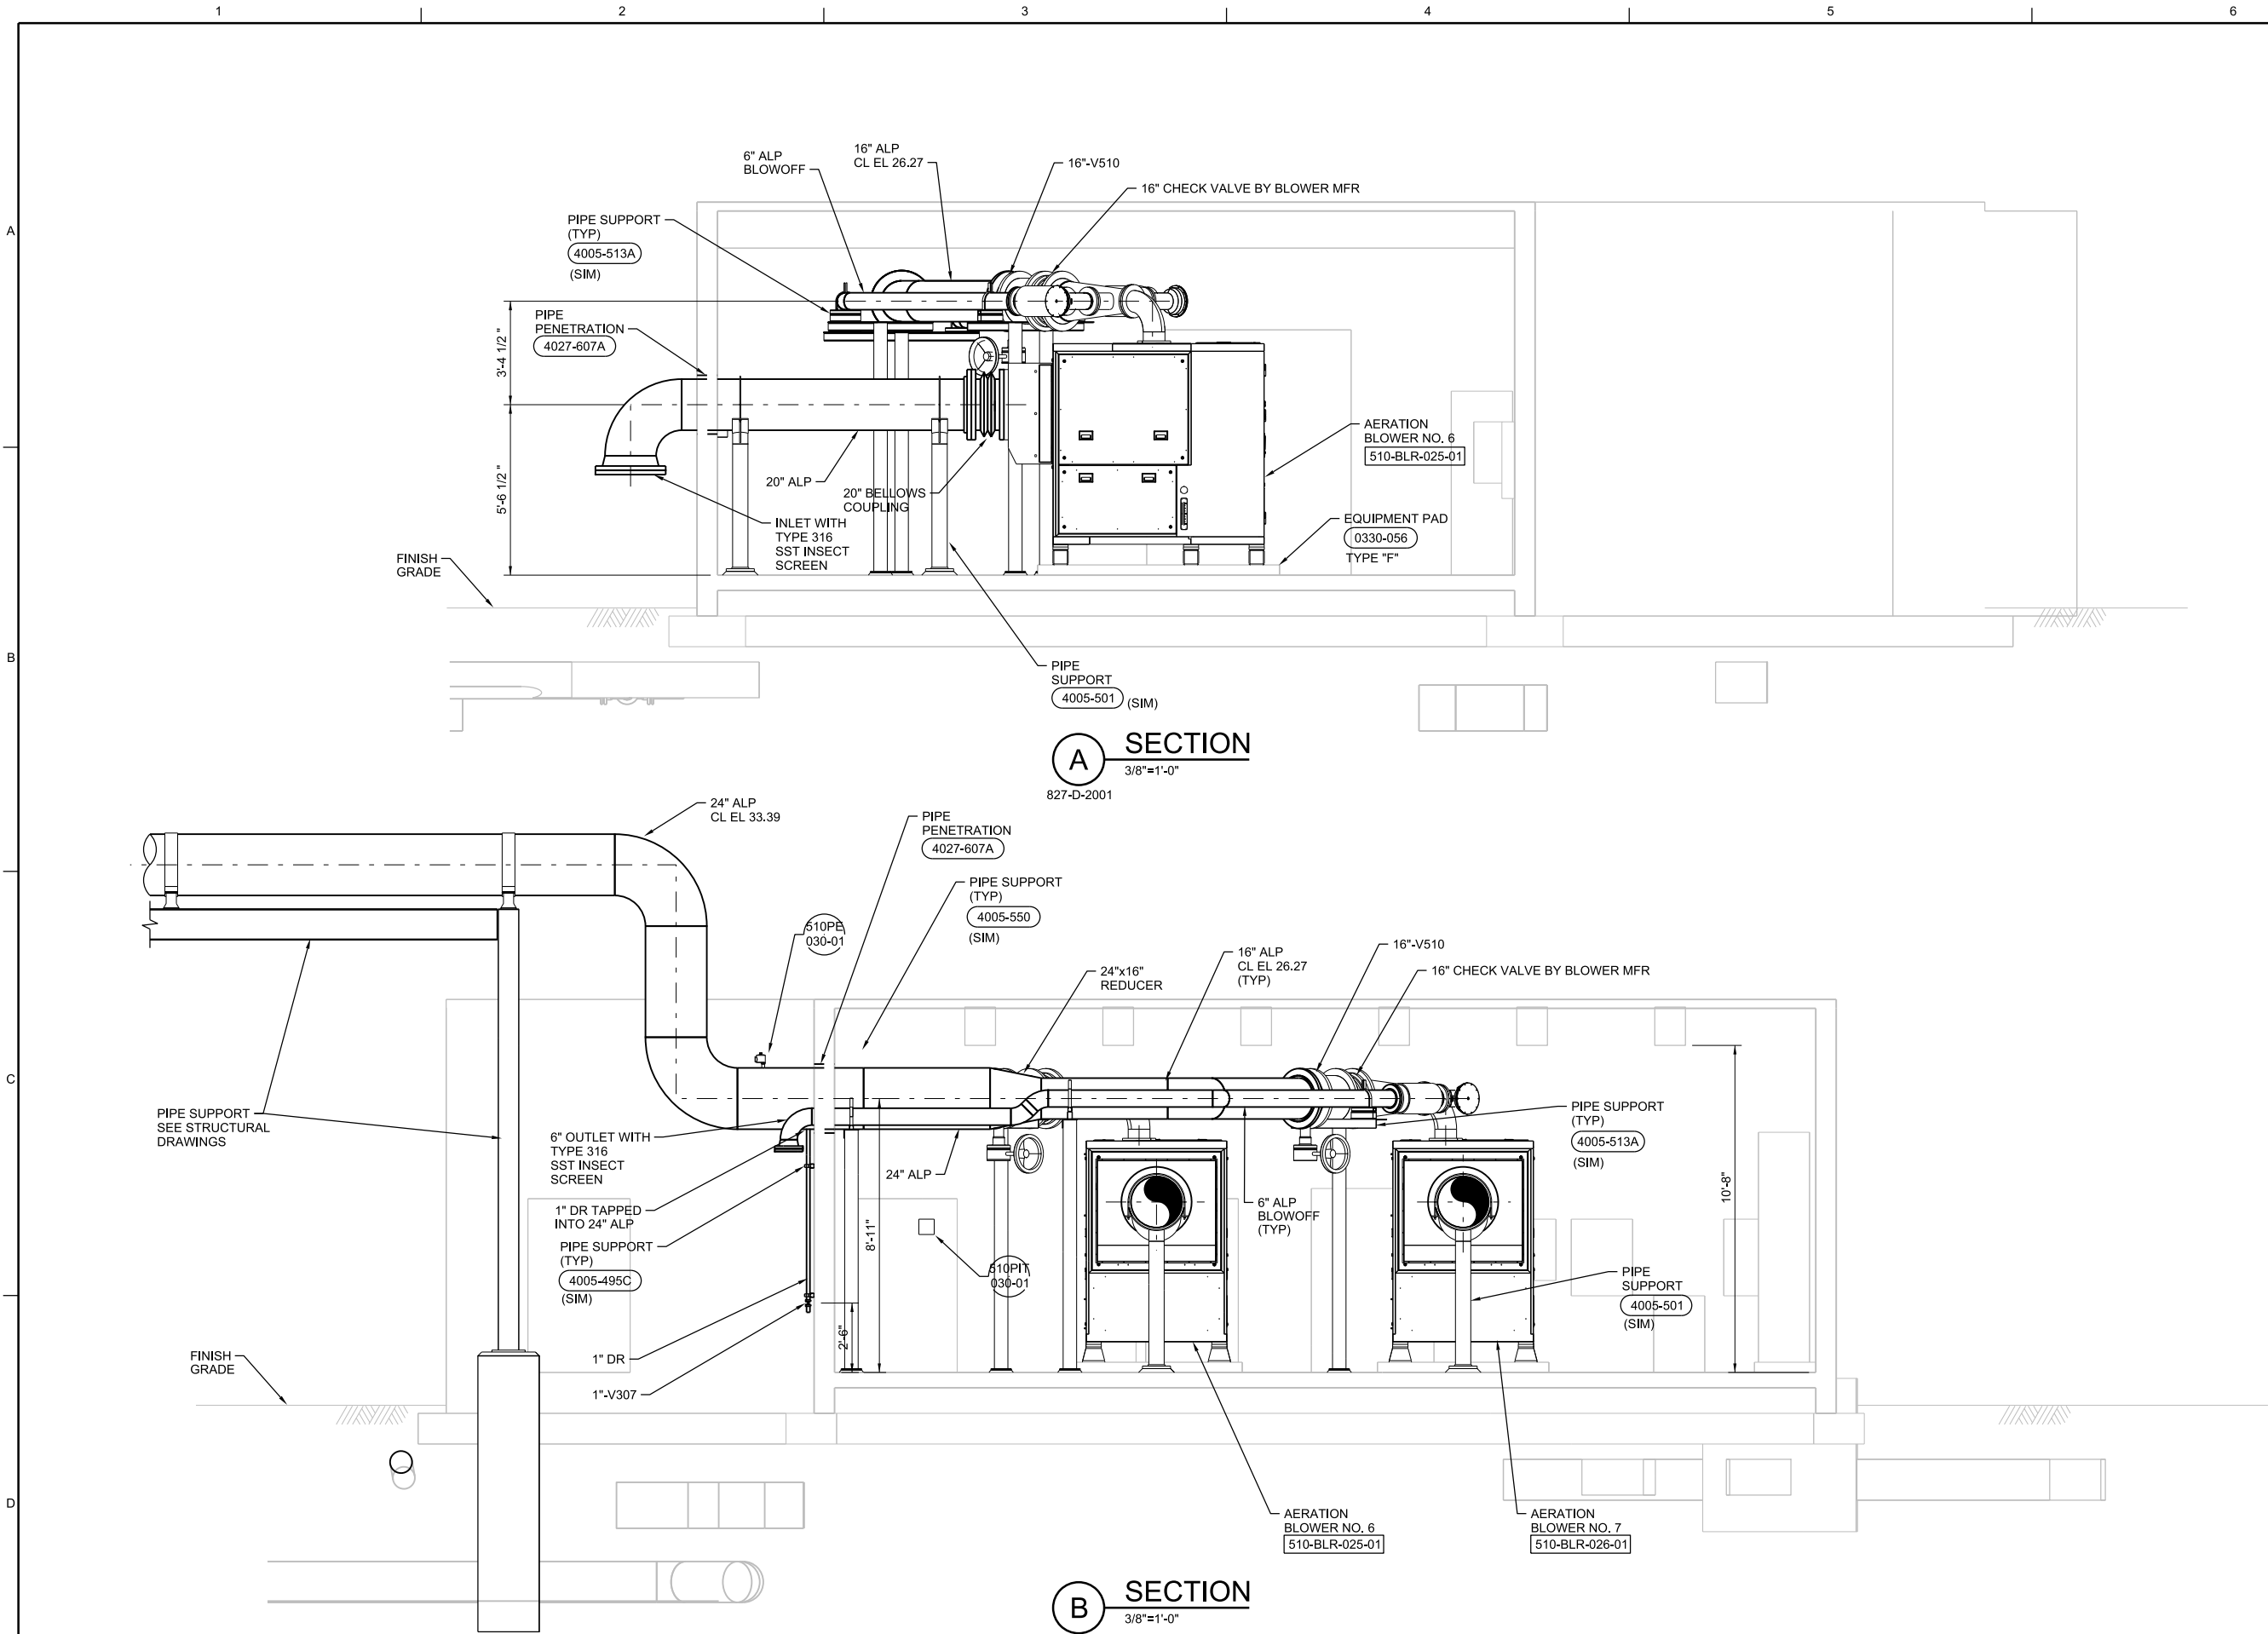

3011 SW WILLISTON RD
GAINESVILLE, FL 32608
EB0000072 AAC001992
TAO FU - PE 63138

SWWRF NITROGEN REMOVAL
AND DIGESTER MODIFICATIONS
MANATEE COUNTY UTILITIES
MANATEE COUNTY, FL

CH2MHILL®

PROCESS
BLOWER BUILDING
SECTIONS

VERIFY SCALE	
BAR IS ONE INCH ON ORIGINAL DRAWING.	
DATE	DECEMBER 2013
PROJ	457133
DWG	827-D-3001
SHEET	of


ISSUED FOR BID

A

B

C

D

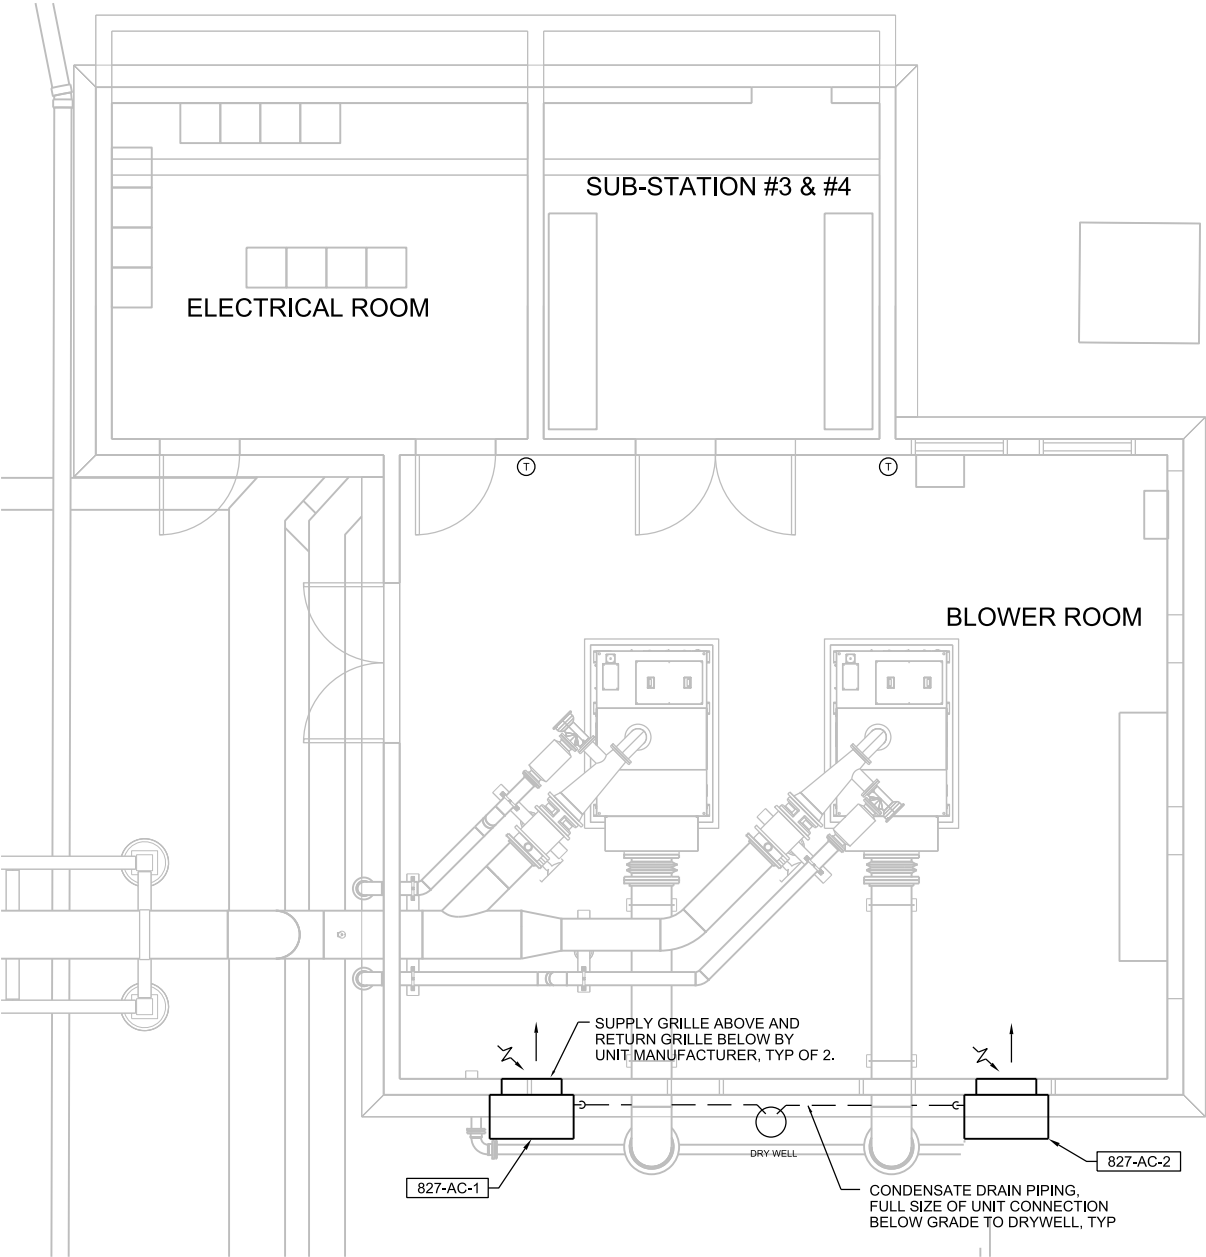

GENERAL NOTES:



1. CONTRACTOR SHALL INSPECT SITE TO BECOME FAMILIAR WITH THE SCOPE OF THE WORK. THESE DOCUMENTS DO NOT REFLECT AS-BUILT CONDITIONS. ANY DISCREPANCIES BETWEEN THESE DOCUMENTS AND THE ACTUAL CONDITIONS SHALL BE REPORTED TO THE ENGINEER FOR RESOLUTION.
2. MECHANICAL WORK SHALL COMPLY WITH ALL APPLICABLE CODES. VERIFY ALL REQUIREMENTS PRIOR TO COMMENCING WORK.
3. COORDINATE THERMOSTAT LOCATIONS WITH EXISTING CONDITIONS AND THE ARCHITECT/ENGINEER PRIOR TO INSTALLATION.
4. THE UNIT SHALL BE SECURE BY WALL MOUNTING BRACKETS WHICH SECURE THE UNIT TO THE OUTSIDE WALL SURFACE AT BOTH SIDES. A BOTTOM MOUNTING BRACKET IS PROVIDED FOR EASE INSTALLATION, BUT IS NOT REQUIRED.
5. A BEAD OF SILICONE CAULKING SHALL BE PLACED BEHIND THE SIDE MOUNTING FLANGES AND UNDER TOP FLASHING AT TIME OF INSTALLATION.
6. SECURE UNIT WITH 5/16 LAG BOLTS; USE 7/8 INCH DIAMETER FLAT WASHERS ON THE LAG BOLTS.
7. INSTALL WORK SO AS TO BE READILY ACCESSIBLE FOR OPERATION, MAINTENANCE AND REPAIR. MINOR DEVIATIONS FROM DRAWINGS MAY BE MADE TO ACCOMPLISH THIS, BUT CHANGES WHICH INVOLVE EXTRA COST SHALL NOT BE MADE WITHOUT APPROVAL.
8. DISCONNECT, REMOVE AND/OR RELOCATE EXISTING MATERIAL, EQUIPMENT AND OTHER WORK AS NOTED OR REQUIRED FOR PROPER INSTALLATION OF THE NEW SYSTEM.
9. ALL SYSTEMS SHALL BE CLEAN OF FOREIGN MATERIAL AND ROUGH SPOTS PRIOR TO BEING PLACED IN SERVICE AND BEFORE OPERATIONAL TEST ARE PERFORMED.
10. INSTALLATION OF ALL EQUIPMENTS AND THEIR ACCESSORIES SHALL BE PER MANUFACTURER'S PUBLISHED RECOMMENDATIONS.
11. ALL MATERIALS AND EQUIPMENT TO BE NEW UNLESS OTHERWISE NOTED.

SEQUENCE OF OPERATION

WHEN THE TEMPERATURE IN THE BLOWER BUILDING IS OVER THE FIRST COOLING TEMPERATURE SETPOINT (85 F ADJ), THE FIRST UNIT SUPPLY FAN SHALL ENERGIZE. UPON FURTHER RISE OF THE SPACE TEMPERATURE OVER THE SECOND COOLING SETPOINT TEMPERATURE (87 F ADJ), THE SECOND UNIT SUPPLY FAN SHALL ENERGIZE. AS THE SPACE TEMPERATURE SETPOINTS ARE SATISFIED, THE UNIT'S SUPPLY FANS SHALL DE-ENERGIZE. WHEN THE TEMPERATURE IN THE ELECTRICAL ROOM IS UNDER

THE HEATING SETPOINT TEMPERATURE (60 F ADJ), THE ELECTRIC UNIT HEATER SHALL ENERGIZE. AS THE TEMPERATURE SETPOINT IS SATISFIED THE HEATER SHALL BE DE-ENERGIZED.



WALL MOUNT AIR CONDITIONER																																	23 81 00.08							
SYMBOL	LOCATION	INDOOR FAN DATA						DX COOLING DATA				ELECTRIC HEATING DATA				COMPRESSOR DATA						CONDENSER FAN DATA						UNIT ELECTRICAL DATA						UNIT DIMENSIONS				MANUFACTURER	MODEL	REMARKS
		SUPPLY AIR CFM	OUTSIDE AIR CFM	EXTERNAL STATIC P IN W.G.	HP	VOLT	PH	TOTAL BTU/H	DB	WB	AMBIENT TEMP. DEG. F	KW	STEPS	VOLT	PH	NO.	STEPS	RLA (EA)	LRA (EA)	VOLT	PH	NO.	H.P. (EA)	VOLT	PH	CFM (TOTAL)	#CONN.	MCA	MOCP (FUSE)	VOLT	PH	INCHES			MAX WEIGHT LBS					
																																H	W	D						
827-AC-1	BLOWER BUILDING	1800	0	0.2	1/2	460	3	68,000	80	49	92	9	1	460	3	1	1	14.1	87.0	460	3	1	3/4	460	3	3500	1	23	30	460	3	94.87	42	22.25	575	BARD	W70A1-C9BXXX2J	A,B,C,D,E,F,G,H,I,J		
827-AC-2	BLOWER BUILDING	1800	0	0.2	1/2	460	3	68,000	80	49	92	9	1	460	3	1	1	14.1	87.0	460	3	1	3/4	460	3	3500	1	23	30	460	3	94.87	42	22.25	575	BARD	W70A1-C9BXXX2J	A,B,C,D,E,F,G,H,I,J		
REMARKS:																																								
A: CONDENSER COIL SHALL HAVE DIP APPLIED ANTI-CORROSION COATING (NOT SPRAY APPLIED) B: 2 INCH DEEP PLEATED AIR FILTER SIZED TO SUIT RETURN GRILLE C: FACTORY INSTALLED DISCONNECT E: COLD WEATHER KIT F: 5 YEAR COMPRESSOR WARRANTY G: STANDARD RETURN AIR GRILLE H: STANDARD SUPPLY AIR GRILLE I: BLANK OFF PLATE TO RESTRICT ANY OSA. J: FIELD INSTALLED HEATER PACKAGE MODELEHWA05A-C09 (9KW)																																								

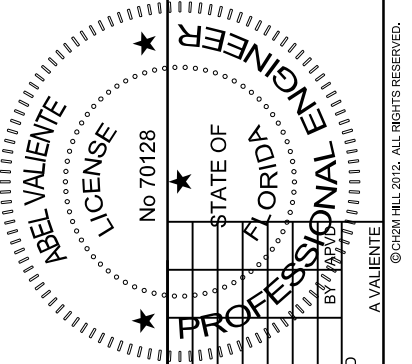 


3011 SW WILLISTON RD GAINESVILLE, FL 32608 EB0000072 - AAC001992 ABEL VALIENTE - PE 70128	SWWRf NITROGEN REMOVAL AND DIGESTER MODIFICATIONS MANATEE COUNTY UTILITIES MANATEE COUNTY, FL	23 81 00.08
DR	CHK	APVD
A VALIENTE	K RINER	G SMARR
NO.	DATE	REVISION
DGN		

3011 SW WILLISTON RD GAINESVILLE, FL 32608 EB0000072 - AAC001992 ABEL VALIENTE - PE 70128	SWWRf NITROGEN REMOVAL AND DIGESTER MODIFICATIONS MANATEE COUNTY UTILITIES MANATEE COUNTY, FL	23 81 00.08
DR	CHK	APVD
A VALIENTE	K RINER	G SMARR
NO.	DATE	REVISION
DGN		

VERIFY SCALE	DECEMBER 2013
BAR IS ONE INCH ON ORIGINAL DRAWING, 1"	457133
DATE	827-M-2001
PROJ	of
DWG	
SHEET	

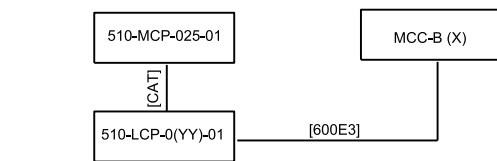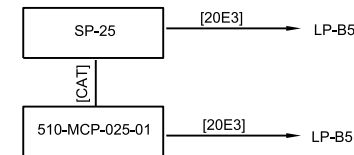
$$\begin{aligned}(X) &= 5, 6 \\ (YY) &= 25, 26\end{aligned}$$


RISER DIAGRAM

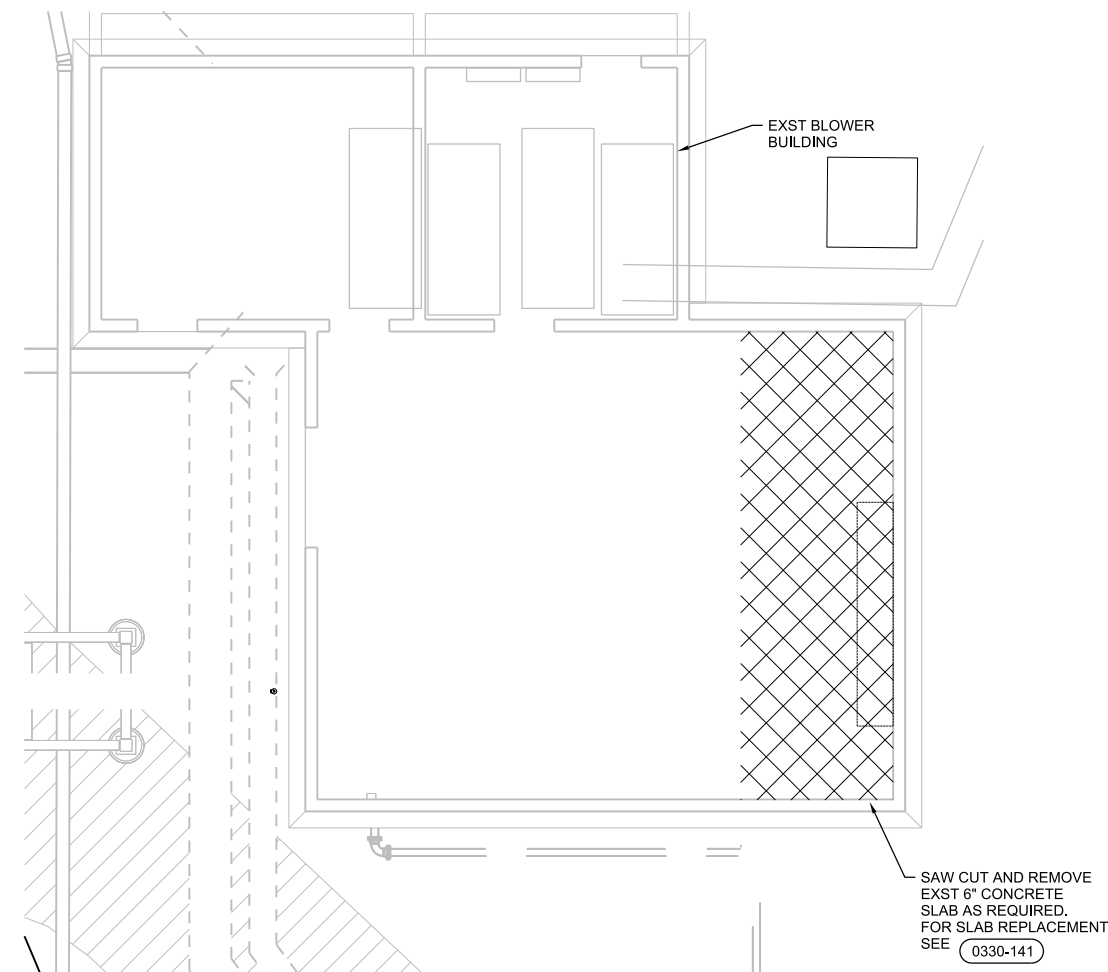
$$3/16'' = 1' - 0''$$
[illegible]

CH2MHILL®

VERIFY SCALE	
BAR IS ONE INCH ON ORIGINAL DRAWING.	
0	1"
DATE	DECEMBER 2013
PROJ	457133
DWG	827-E-2001
SHEET	of

ISSUED FOR BID

