



MANATEE COUNTY
FLORIDA

September 4, 2013

TO: All Interested Quoters

SUBJECT: **Request for Quotation # 13-2025-DS**
Three Phase Uninterrupted Power System

ADDENDUM # 4

Quoters are hereby notified that this Addendum shall be acknowledged on page 19 of the Quote Form and made a part of the above named quoting and contract documents. Quotes submitted without acknowledgement of the Addendum will be considered incomplete.

The following items are issued to add to, modify, and clarify the Quote and contract documents. These items shall have the same force and effect as the original Quoting and contract documents, and cost involved shall be included in the bid prices. Bids to be submitted on the specified bid date, shall conform to the additions and revisions listed herein.

The deadline for clarification of questions was **August 16, 2013 at 2:00pm**. This deadline had been established to maintain fair treatment of all potential Quoters. Questions received after this date and time shall not be considered.

Engineers Clarifications:

1. Provide a UPS that will fit into the UPS Room and a battery system that will fit into the IT Room next door. There is 70" of linear space for the UPS and additional space next door in the IT Closet that can work for the battery system. The width of the room is 70" the length is approx. 120". With approx. 48" of available length, the max dimension (base – length/width) may not be greater than 39".
2. Attached please find the revised E3.0 (66th Street Lab UPS Study Power Plan, rev. 1 dated 8/30/13). The attached drawing supersedes the previously submitted placement drawing, by way of this Addendum # 4 remove and replace accordingly.
3. There is physical space for the batteries in an alternate location. This could be the IT Room. Items may need to be moved slightly to meet the code requirements.

The deadline for submitting quotes has been extended to now read September 12, 2013 at 3:00 PM.

END OF ADDENDUM # 4

Sincerely,

Donna M. Stevens
Contract Specialist
Attachment (1 sheet)


Financial Management Department

Mailing Address: P. O. Box 1000 1112 Manatee Avenue West Suite 803, Bradenton, FL 34206-1000

WEB: www.myanatee.org * PHONE: 941.749.3045 * FAX: 941.749.3014

PLAN NOTES:

- 1 PROVIDE AND INSTALL A 480V-3P 125A BREAKER IN MDP AND MATCH EXISTING KAIC RATING FOR THE NEW UPS. SEE PANEL SCHEDULE ON SHEET E6.0. SEE SPECIFICATIONS SHEET E7.0. INSTALL PER MANUFACTURER'S REQUIREMENTS.
- 2 TRY TO RE-USE EXISTING DISTRIBUTION BREAKERS, CONDUCTORS, AND CONDUIT RUNS FROM THE OLD PANEL "LU".
- 3 PROVIDE A NEW SURGE SUPPRESSION DEVICE ON THE NEW PANEL WITH A 30A BREAKER. SEE SPECIFICATIONS SHEET E7.0.
- 4 PROVIDE AND INSTALL A NEW UPS SYSTEM PER MANUFACTURER'S REQUIREMENTS. FIELD LOCATE SYSTEM - ITEMS MAY BE REQUIRED TO BE MOVED TO MEET CODE REQUIREMENTS.
- 5 WIRE BATTERY CONNECTIONS PER MANUFACTURER'S REQUIREMENTS - ALL REQUIREMENTS SHALL MEET OR EXCEED NFPA 70 NEC.

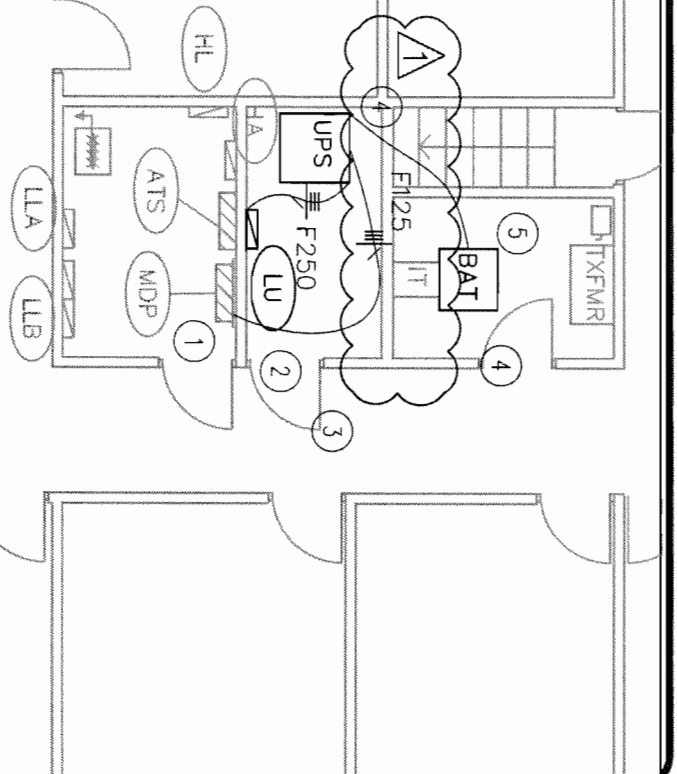

NEW POWER PLAN

1
E3.0

1/8" = 1'-0"



DATE:
05/30/13

SHEET No.:
E3.0

DRAWING TITLE:
66TH STREET LAB UPS STUDY POWER PLAN
REVISION 1, Corrected existing walls to match actual 08/30/2013



ATP ENGINEERING SOUTH, PL
BRADENTON, FLORIDA
ENGR. BUSINESS #8908
941-751-6485