

FIRST LETTER			SUCCEEDING—LETTERS		
	MEASURED OR INITIATING VARIABLE	MODIFIER	READOUT OR PASSIVE FUNCTION	OUTPUT FUNCTION	MODIFIER
A	Analysis		Alarm		
B	Burner, Combustion		Programmer		
C	Conductivity (Electrical)			Control	Closed
D	Density or Specific Gravity	Differential			
E	Voltage		Sensor (Primary Element)	Eduction	
F	Flow Rate	Ratio (Fraction)			
G	Gaging		Glass, Viewing Device		
H	Hand				High
I	Current (Electrical)		Indicate		
J	Power	Scan			
K	Time, Time Schedule			Control Station	
L	Level		Light (Pilot)		Low
M	Motor				Middle, Intermediate
N	Vibration				
O	Operation	Offset	Orifice, Restriction		Open
P	Pressure, Vacuum		Point (Test) Connection		
Q	Quantity, Event	Integrate, Totalize	Integrate		
R	Radiation		Record, Print	Regulate	
S	Speed, Frequency	Safety		Switch	
T	Temperature			Transmit	
U	Multivariable	Trend	Multifunction	Multifunction	Multifunction
V	Viscosity	Vacuum		Valve, Damper, Louver, Gate	
W	Weight, Force, Torque		Well		
X	Unclassified		Unclassified	Unclassified	Unclassified
Y				Relay, Compute, Convert	
Z	Position			Final Control Element	Drive, Actuator, Unclassified Final Control Element

MULTIPLE FUNCTION		
	OR	FIELD MOUNTED INSTRUMENT OR DEVICE
	OR	FRONT OF PANEL MOUNTED INSTRUMENT ON UCP OR MCC, VFD
	OR	REAR OF PANEL MOUNTED INSTRUMENT ON UCP OR MCC, VFD
	OR	FRONT OF PANEL MOUNTED INSTRUMENT ON MAIN PANEL
	OR	REAR OF PANEL MOUNTED INSTRUMENT ON MAIN PANEL
	OR	PLC AND/OR COMPUTER SOFTWARE COMPONENT (OPERATOR ACCESSIBLE UNDER NORMAL CONDITIONS)
	OR	PLC AND/OR COMPUTER GENERATED COMPONENT (NOT OPERATOR ACCESSIBLE UNDER NORMAL CONDITIONS)
	OR	PLC INPUT/OUTPUT

	INSTRUMENT SIGNAL
	ELECTRICAL SIGNAL
	DATA LINK
	PNEUMATIC
	CAPILLARY
	SONIC OR R.F.
	HYDRAULIC
	TELEPHONE
	NO ELECTRICAL CONNECTION
	ELECTRICAL CONNECTIONS (INDICATED BY DOTS)
	HEAT TRACED PROCESS
	LINE OR EQUIPMENT
	MATCHLINE
	PROCESS LINE OR ELECTRICAL SIGNAL CONTINUATION TO/FROM SHEET NUMBER INDICATED
	CONTINUATION ON SAME SHEET
	CONTINUATION ON FACILITIES
	NOT SHOWN ON DRAWINGS

	FLAME ARRESTOR
	PINCH VALVE
	GATE
	NEEDLE
	BUTTERFLY
	BALL OR ROTARY
	GLOBE
	PLUG OR COCK
	DIAPHRAGM
	CHECK
	DIAPHRAGM CHECK
	CONTROL VALVE POSITIONER
	PRESSURE REGULATING VALVE
	BACKPRESSURE REGULATING VALVE
	PISTON OPERATED
	S=SOLENOID OPERATED
	M=MOTOR OPERATED
	P=PNEUMATIC OPERATED
	DRAIN
	Y=WEIR GATE
	T=SLIDE SLUICE GATE
	I =STOP LOG
	BLIND FLANGE
	PULSATION DAMPENERS
	PRESSURE RELIEF OR SAFETY
	3-WAY
	4-WAY
	TELESCOPING
	REDUCER
	HOSE CONNECTION
	WAFER/CHECK VALVE
	UNION

	FLOAT SWITCH OR FLOAT
	(ARV) AIR RELEASE VALVE
	(ARVV) AIR VACUUM RELEASE VALVE
	ELECTRIC MOTOR
	ORIFICE/ANNUBAR
	AIR DIFFUSER
	LIQUID DIFFUSER
	CAPACITANCE METER
	REGULATOR/FILTER
	SUBMERSIBLE PUMP
	MAGNETIC METER (INLINE/INSERT)
	ULTRASONIC METER
	VENTURI OR FLOW TUBE
	PROPELLER OR TURBINE METER
	DOPPLER OR TRANSIT TIME FLOW METER
	ROTAMETER
	PROGRESSING CAVITY PUMP
	CENTRIFUGAL PUMP
	POSITIVE DISPLACEMENT PUMP
	DIAPHRAGM OR METERING PUMP
	EDUCTOR
	STRAINER
	DIAPHRAGM ISOLATOR
	HORN
	GRADUATED MEASURING CYLINDER
	CYLINDER HYDRAULIC OR PNEUMATIC
	LATERAL WYE
	RUPTURE DISK
	RESTRAINED FLEX CONN.
	FLEX CONN.
	FILTER AIR/WATER
	CENTRIFUGAL BLOWER
	POSITIVE DISPLACEMENT BLOWER
	VERTICAL TURBINE PUMP
	MANUAL BAR RACK
	MIXER
	SUBMERSIBLE AERATOR/MIXER (ELECTRIC MOTOR DRIVEN)

	PURGE CONNECTION
	SAMPLE POINT
	INTERLOCK
	MULTIPLY
	DIVIDE
	HIGH SELECT
	LOW SELECT
	SQUARE ROOT
	SUM (ALGEBRAIC)
	SPECIAL FUNCTION
R+B	RATIO PLUS BIAS
dL/dt	RATE OF RISE (LEVEL)

B = BLOWER OR FAN
E = ENGINE
G = GENERATOR
F = FILTER
GS = GRINDER/SCREEN
K = COMPRESSOR
H = HOIST
ME = MECHANICAL
EQUIPMENT
MX = MIXER
P = PUMP
R = HEAT EXCHANGER
T = TANK OR SUMP

HV = HAND VALVE
FCV = FLOW CONTROL VALVE (MODULATING)
PRV = PRESSURE REGULATING VALVE
LCV = LEVEL CONTROL VALVE
FV = FLOW VALVE (NON-MODULATING)
MV = MUD VALVE
TV = TELESCOPING VALVE
CV = CHECK VALVE
MOV = MOTOR OPERATED VALVE

INSTRUMENT TAG NOTATION

FIC 0 1 01 A

ISA INSTRUMENT FUNCTION

PLANT AREA

PROCESS AREA

INSTRUMENT NUMBER

INSTRUMENT QUANTITY

EFC = ELECTRIC FAIL CLOSE
AFC = AIR FAIL CLOSE
EFO = ELECTRIC FAIL OPEN
AFO = AIR FAIL OPEN
AFS = AIR FAIL STATIC
EFS = ELECTRIC FAIL STATIC

CONTROLLER NOTATION




PV = PROCESS VARIABLE INPUT
SP = SET POINT INPUT
C = CONTROL OUTPUT

PV = PROCESS VARIABLE INPUT
SP = SET POINT INPUT
C = CONTROL OUTPUT

AI	=	ANALOG INPUT
AO	=	ANALOG OUTPUT
DI	=	DISCRETE INPUT
DO	=	DISCRETE OUTPUT
D/A	=	DISCRETE TO ANALOG CONVERTOR
SSDC	=	SURGE SUPPRESSION DEVICE


HOA = HAND-OFF-AUTO
S/S = START/STOP
SEL = SELECTOR
O/C = OPEN/CLOSE
O/O = ON/OFF
LOS = LOCKOUT-START
D/S = DUTY/STANDBY
FOS = FAST-OFF-SLOW
OAC = OPEN-AUTO-CLOSE
OOCA = OPEN-OFF-CLOSE-AUTO
ROF = REVERSE-OFF-FORWARD
ROL = RAISE-OFF-LOWER
F/R = FORWARD/REVERSE
HOR = HAND-OFF-REMOTE
LOR = LOCAL-OFF-REMOTE
SAR = SILENCE-AUTO-RESET

S/D = SHUTDOWN
O/R = OVERRIDE
MCC = MOTOR CONTROL CENTER
VFD = VARIABLE FREQUENCY DRIVE
UCP = UNIT CONTROL PANEL
LCP = LOCAL CONTROL PANEL
MCP = MASTER CONTROL PANEL
ES = ELECTRICAL SUPPLY
IS = INLET SILENCER
DS = DISCHARGE SILENCER
SEQ = SEQUENCER/ALTERNATOR
SA = SURGE ARRESTOR
DO = DISSOLVED OXYGEN
ETM = ELAPSED TIME METER
TURB = TURBIDITY
US = ULTRASONIC

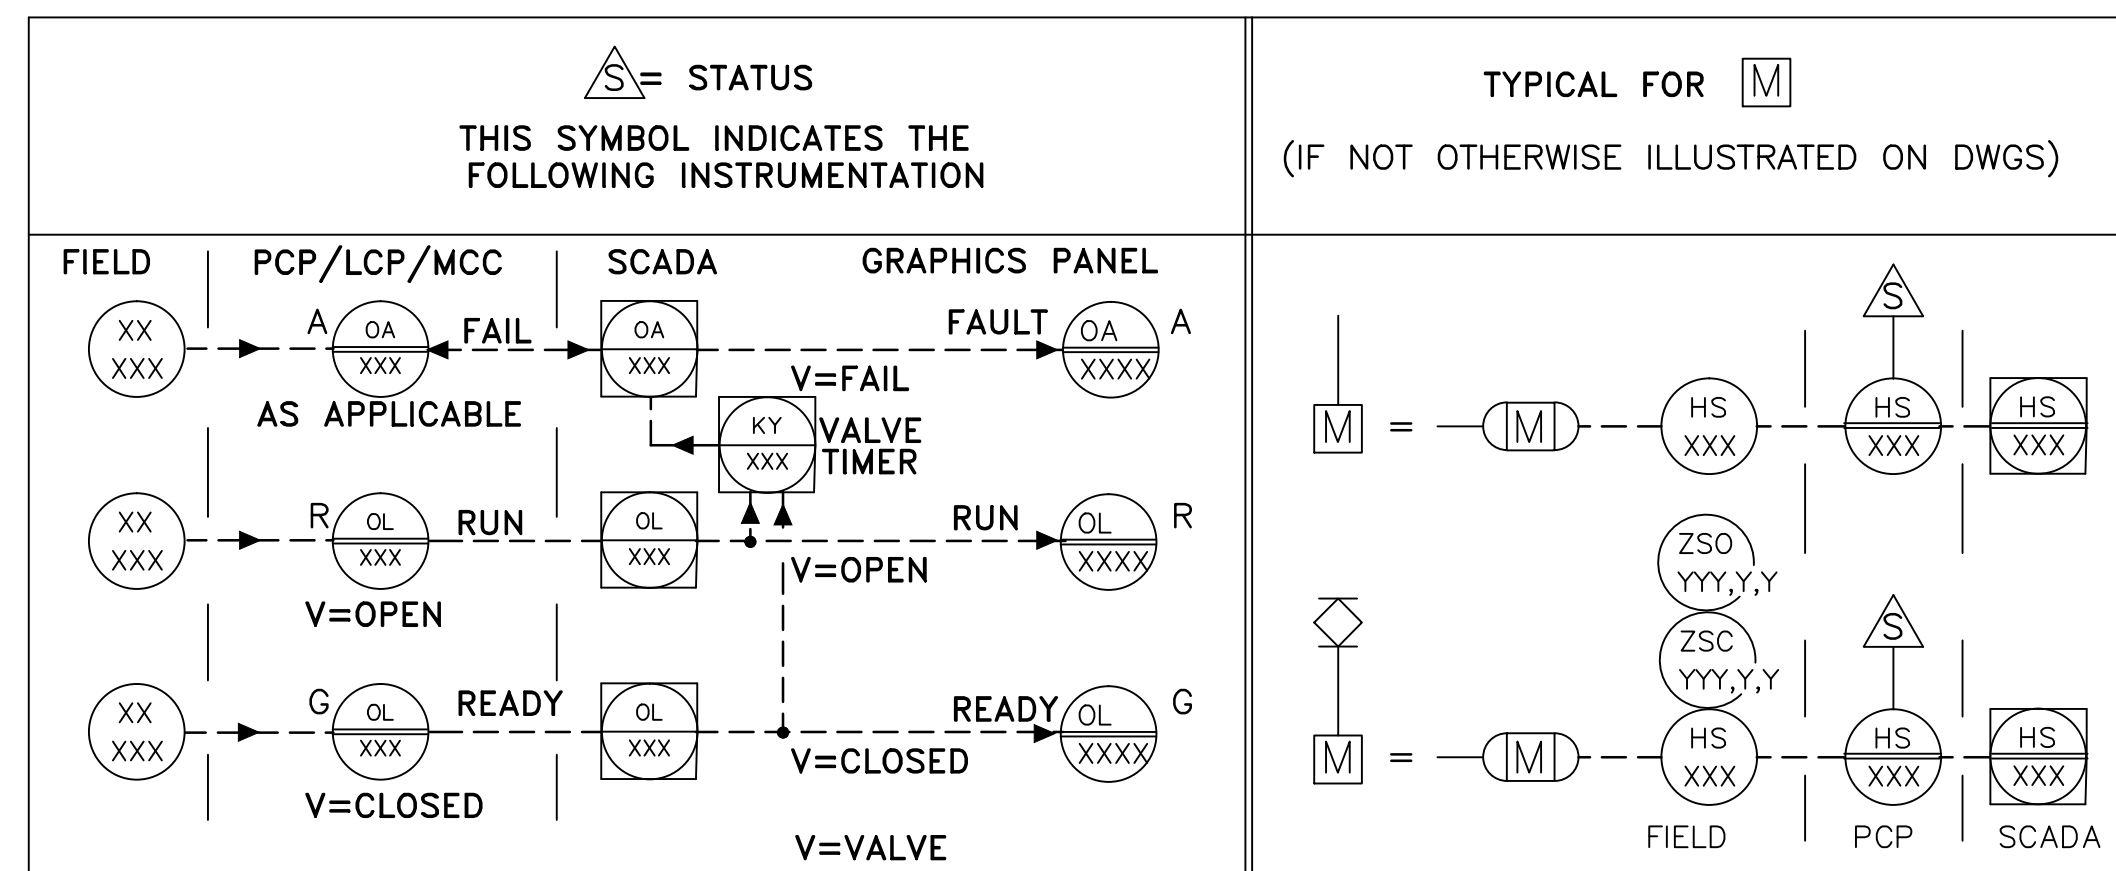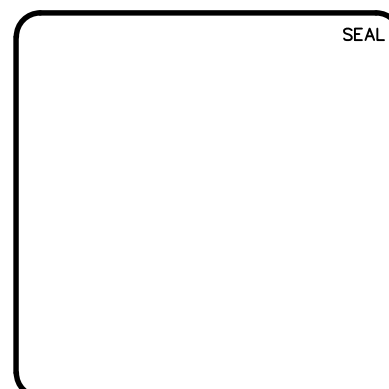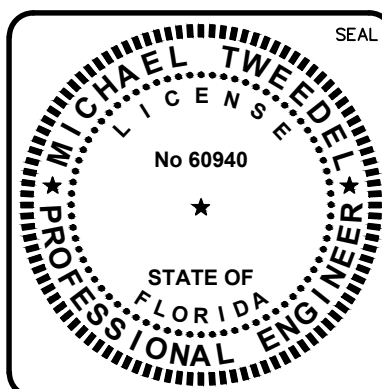
[illegible]

INSTRUMENTATION & CONTROL SYSTEM GENERAL NOTES, LEGENDS AND ABBREVIATIONS



DATE: OCTOBER 2015		SCALE	DRAWING NUMBER
MCE PROJ. #	1024-0167	HORIZONTAL: NA VERTICAL: NA	I-0.1
DRAWN	RRQ		
DESIGNED	MDT		
CHECKED	JSL		
PROJ. MGR.	PJL		
STATUS:		REVISION	

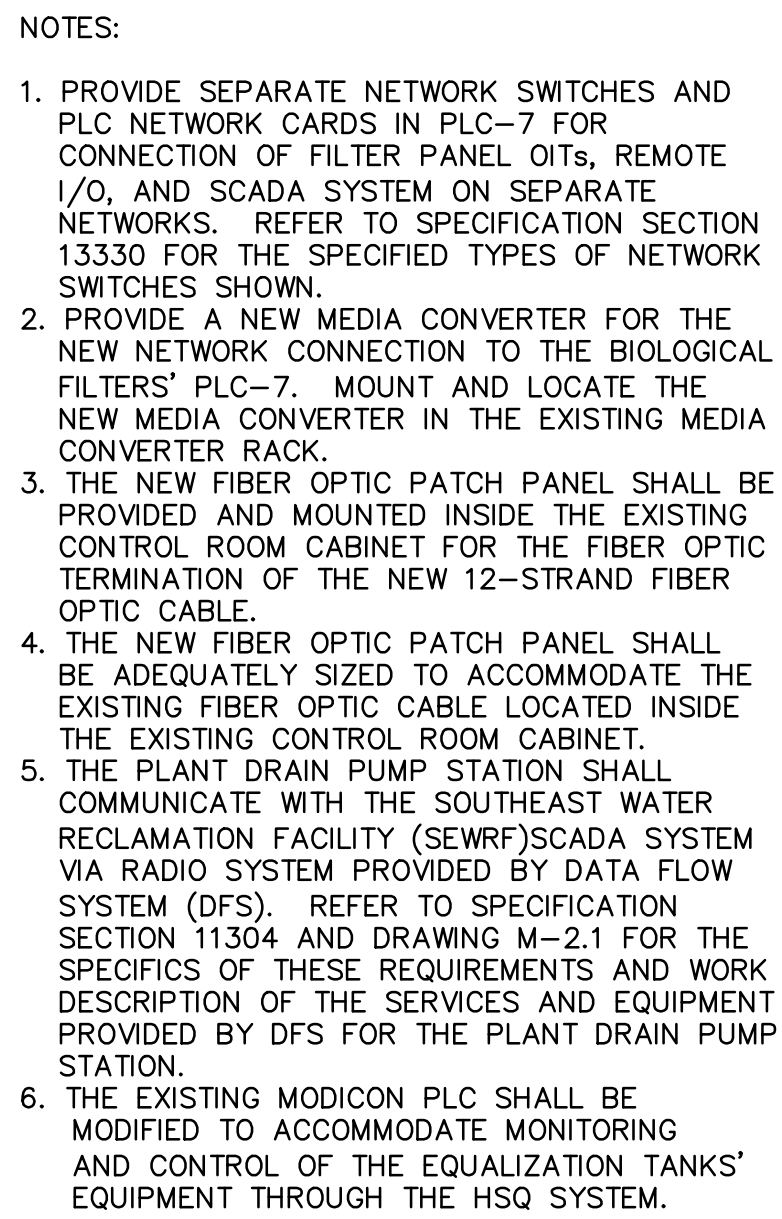

DATE: OCTOBER 2015	SCALE	DRAWING NUMBER
MCE PROJ. # 1024-0167	HORIZONTAL: NA VERTICAL: NA	I-0.2
DRAWN RRO		
DESIGNED MDT		
CHECKED JSL		
PROJ. MGR. PJL		
STATUS: _____ REVISION _____		

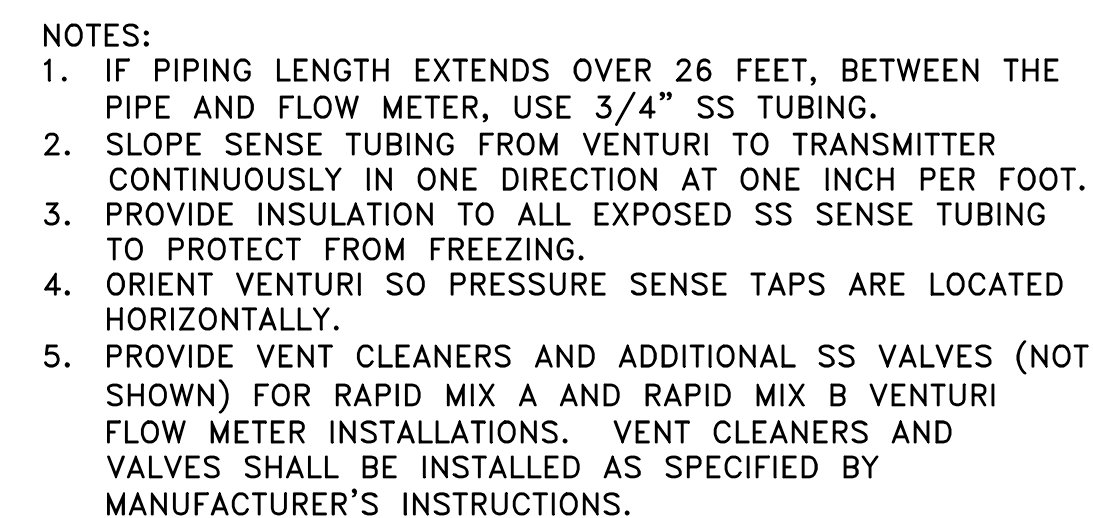





TYPICAL VENTURI FLOW METER

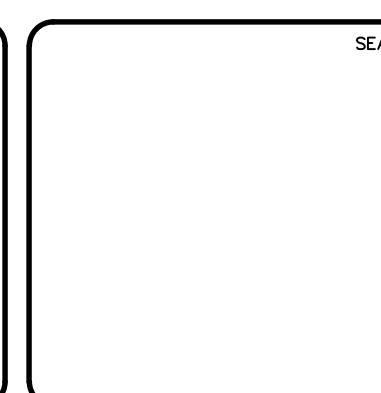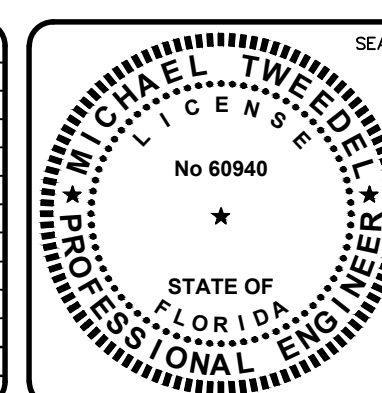[illegible]

MANATEE COUNTY
WTP BIOLOGICAL TREATMENT UNIT

INSTRUMENTATION
INSTALLATION DETAILS

DATE: OCTOBER 2015		SCALE		DRAWING NUMBER	
MCE PROJ. # 1024-0167		HORIZONTAL:		I-0.3	
DRAWN RRO		NA			
DESIGNED MDT		VERTICAL:			
CHECKED JSL		NA			
PROJ. MGR. PJL					

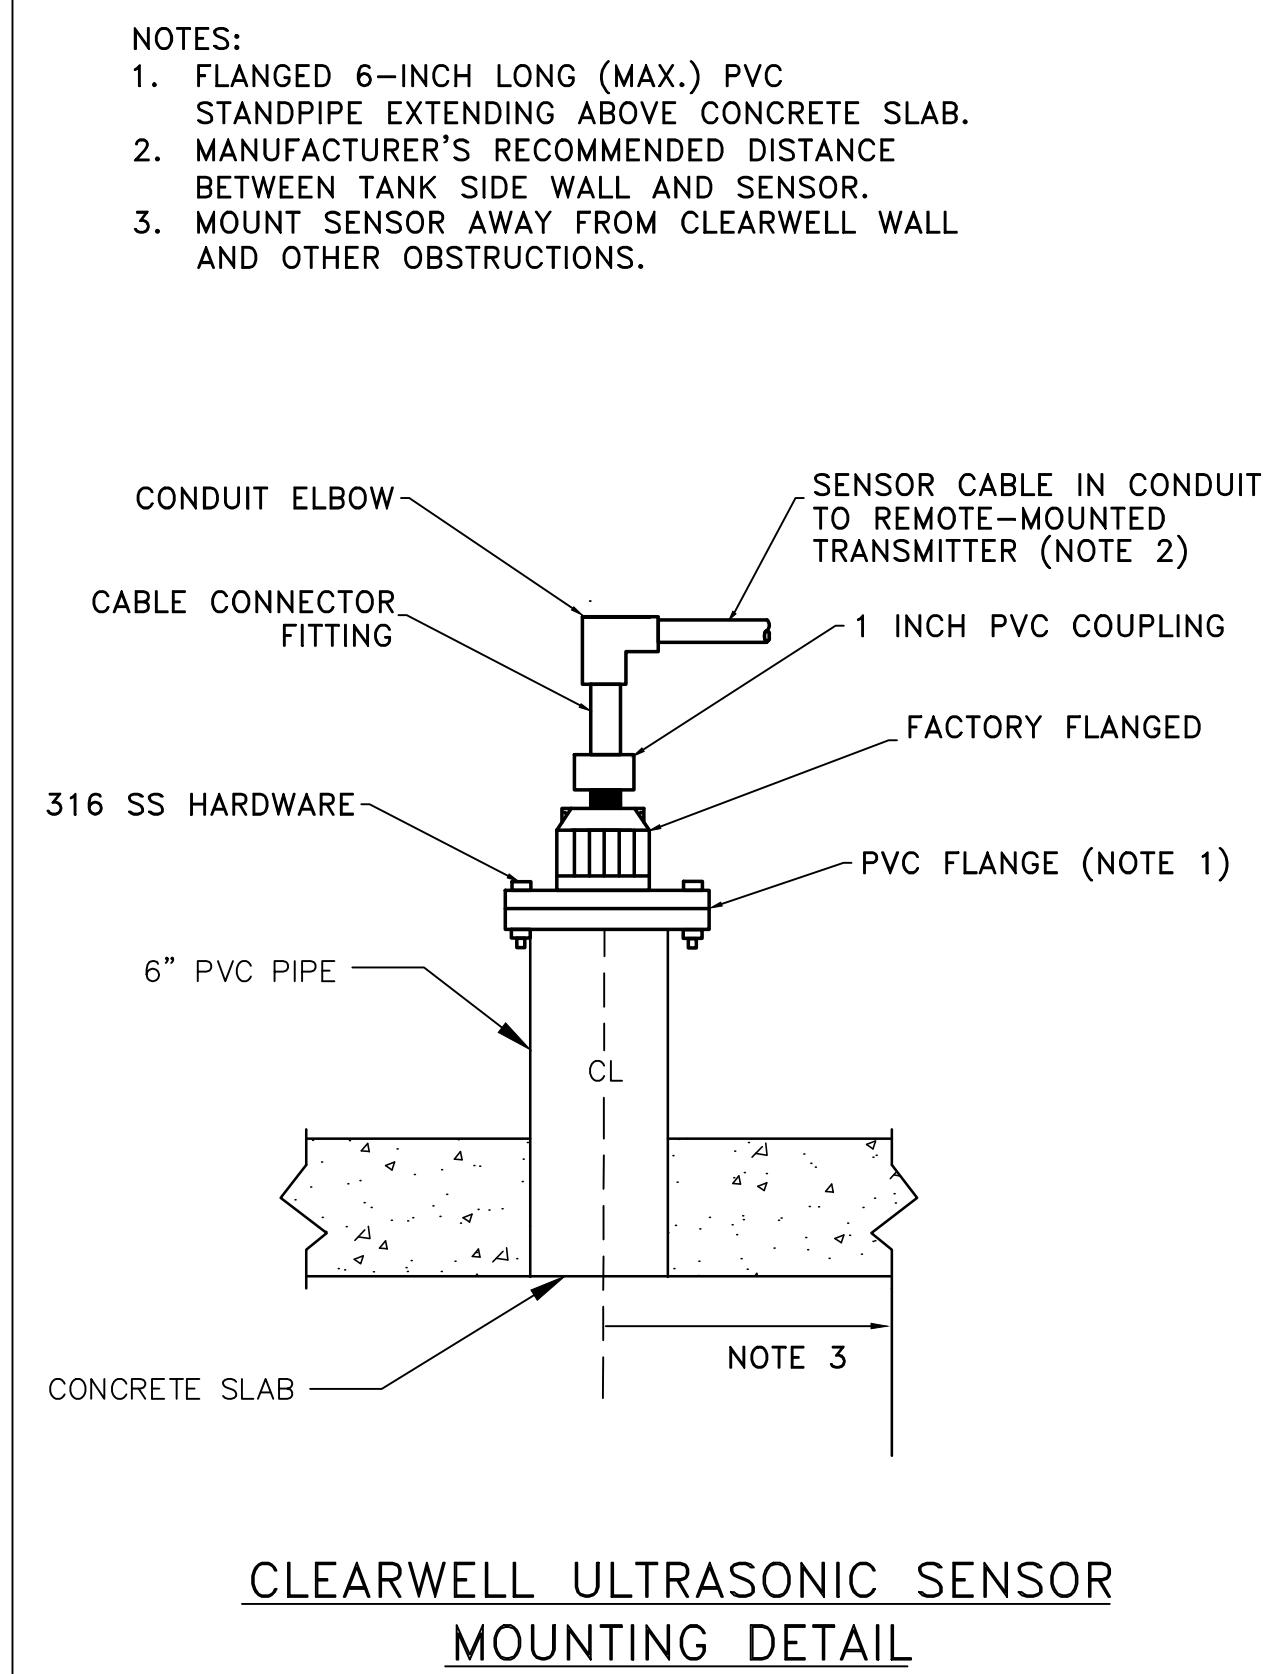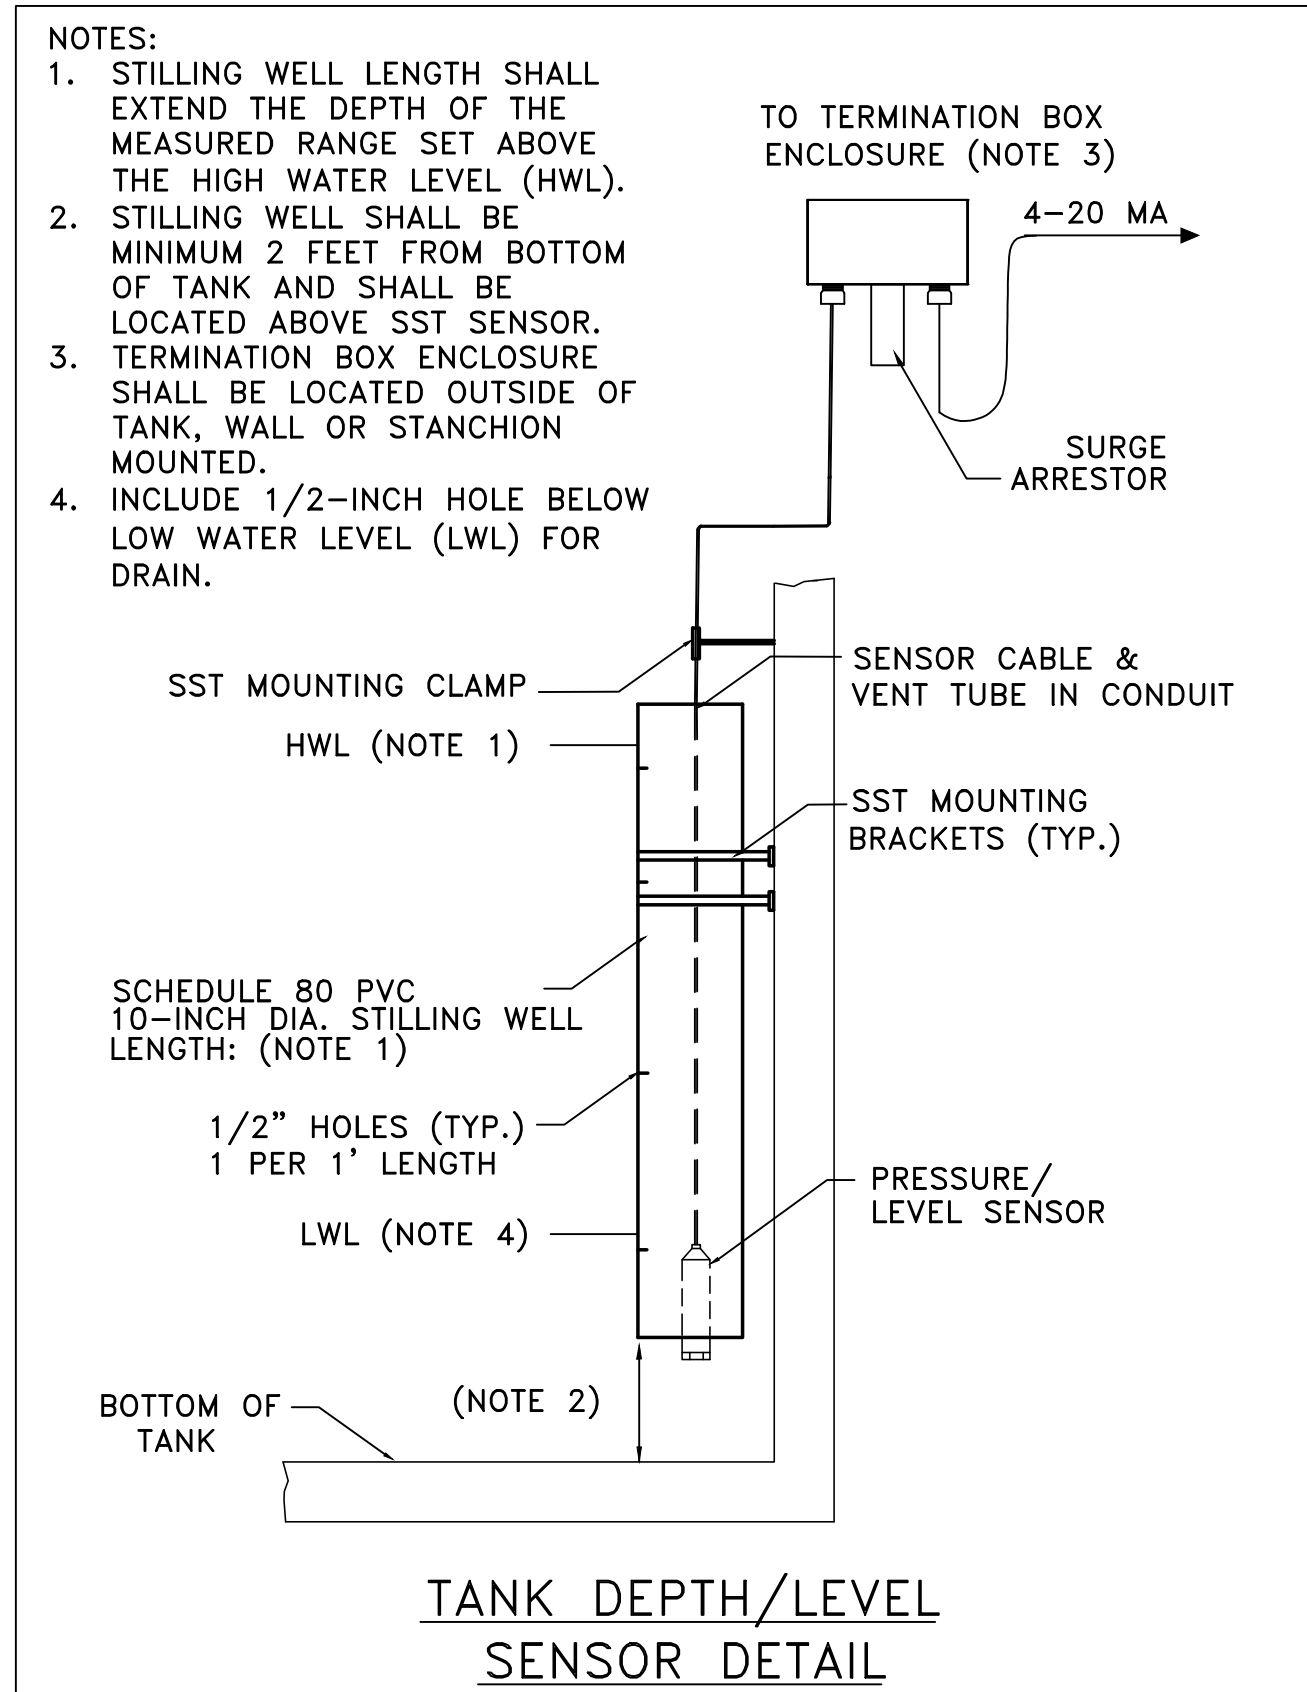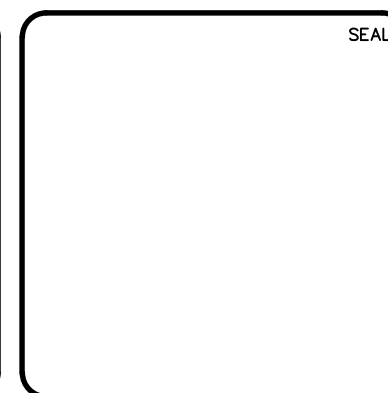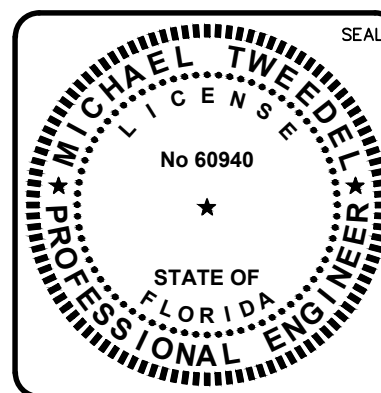[illegible]

MANATEE COUNTY
WTP BIOLOGICAL TREATMENT UNIT

INSTRUMENTATION
INSTALLATION DETAILS

DATE: OCTOBER 2015		SCALE	DRAWING NUMBER
MCE PROJ. #	1024-O167	HORIZONTAL: NA VERTICAL: NA	I-0.4
DRAWN	RRO		
DESIGNED	MDT		
CHECKED	JSL		
PROJ. MGR.	PJL		
STATUS:		REVISION	
ISSUE FOR BID			



 
1. ENCLOSURE, NEMA 12, 86"H x 112"W x 20"D, APPROXIMATE DIMENSIONS
2. LED SERVICE LIGHTS, 15-INCH
3. ENCLOSURE SUBPANEL, STEEL, PAINTED WHITE
4. PLC HARDWARE
5. MANAGED ETHERNET NETWORK FIBER SWITCH (SCADA)
6. UNMANAGED ETHERNET NETWORK FIBER SWITCH (RIO & OIT)
7. POWER SUPPLY, REDUNDANT, 24VDC @ 5A OUT
8. CONTROL RELAYS, 120VDC COIL, DPDT
9. FIBER OPTIC TERMINATION PATCH PANELS
10. GROUND CONNECTOR
11. AC LINE SURGE SUPPRESSOR
12. CONTROL RELAYS, 120VAC, COIL, DPDT
13. ANALOG SURGE SUPPRESSORS
14. TERMINALS
15. CIRCUIT BREAKERS
16. TEMPERATURE SWITCH
17. GFCI RECEPTACLE
18. DISCRETE SURGE SUPPRESSORS
19. FUSES WITH INDICATORS

NOT TO SCALE




TYPICAL OF SIX BIOLOGICAL TREATMENT UNITS,
WHERE X=UNIT NO. (X=1 THROUGH 6):



BTU NO. 1; RIO-1
BTU NO. 2; RIO-2
BTU NO. 3; RIO-3
BTU NO. 4; RIO-4
BTU NO. 5; RIO-5
BTU NO. 6; RIO-6



NOT TO SCALE

 

1. CONSOLE ENCLOSURE, NEMA 4X, 316 SST, 48"H x 36"W x 18"D, APPROXIMATE DIMENSIONS
2. OPERATOR INTERFACE TERMINAL (OIT), 15-INCH, NEMA 4X
3. LED SERVICE LIGHT, 15-INCH
4. ENCLOSURE SUBPANEL, STEEL, PAINTED WHITE
5. PLC HARDWARE
6. ETHERNET SWITCH, UNMANAGED (RIO)
7. ETHERNET SWITCH, UNMANAGED (OIT)
8. POWER SUPPLIES, REDUNDANT, 24VDC @ 5A
9. FIBER OPTIC TERMINATION PATCH PANEL
10. GROUND CONNECTOR
11. AC LINE SURGE SUPPRESSOR
12. CONTROL RELAYS, 120VAC, COIL, 1PDT
13. ANALOG SURGE SUPPRESSORS
14. TERMINALS
15. CIRCUIT BREAKERS
16. HEATER
17. TEMPERATURE SWITCH
18. DIGITAL SURGE SUPPRESSORS
19. FUSES WITH INDICATORS
20. GFCI RECEPTACLE

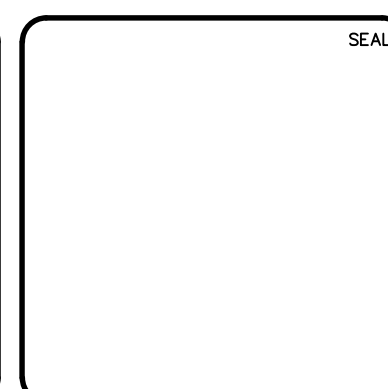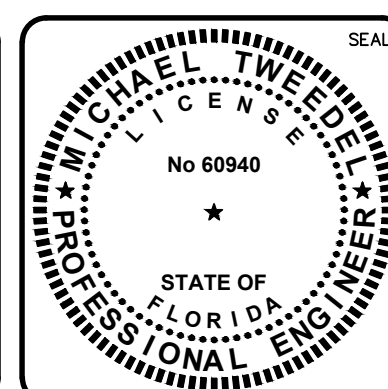[illegible]

MCKIM & CREED
1365 Hamlet Avenue
Clearwater, Florida 33756
Phone: (727)442-7196, Fax: (727)461-3827
CA Lic. No. 29588
www.mckimcreed.com



MANATEE COUNTY
WTP BIOLOGICAL TREATMENT UNIT


PANEL DETAILS PLC CONTROL PANEL AND REMOTE I/O CONSOLE

DATE: OCTOBER 2015		SCALE	DRAWING NUMBER
MCE PROJ. # 1024-0167		HORIZONTAL:	I-0.5
DRAWN	RRO	VERTICAL:	
DESIGNED	MDT	NA	
CHECKED	JSL	NA	
PROJ. MGR.	PJL		

STATUS:

ISSUE FOR BID


REVISION

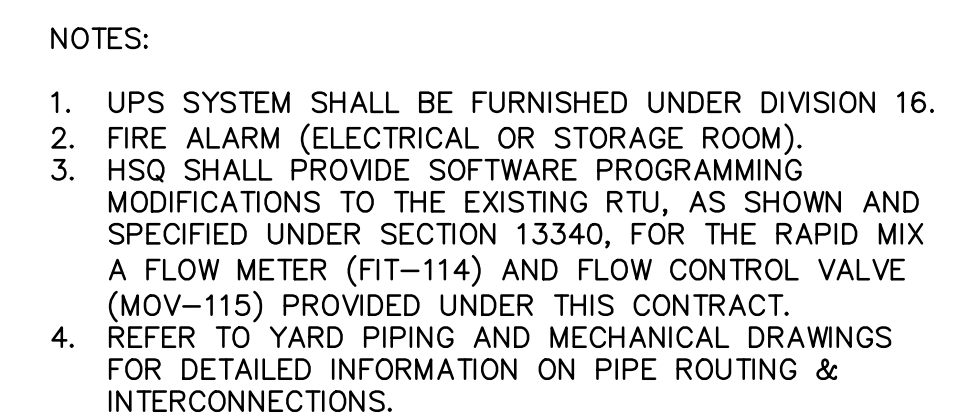

DATE: OCTOBER 2015 MCE PROJ. # 1024-0167 DRAWN RRO DESIGNED MDT CHECKED JSL PROJ. MGR. PJL	SCALE HORIZONTAL: NA VERTICAL: NA	DRAWING NUMBER I-1.1
---	---	-----------------------------


STATUS:
REVISION

ISSUE FOR BID

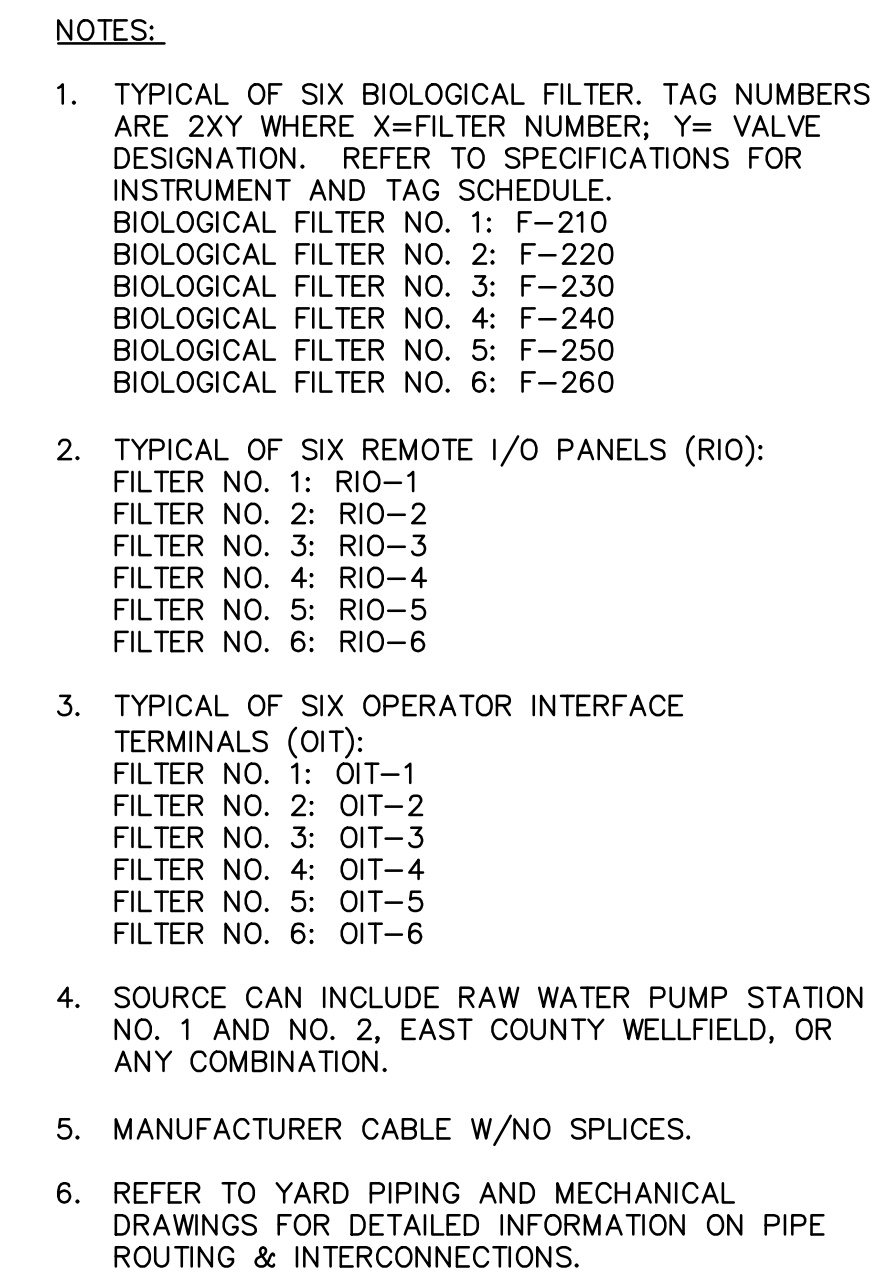


DATE: OCTOBER 2015 MCE PROJ. # 1024-0167 DRAWN RRO DESIGNED MDT CHECKED JSL PROJ. MGR. PJL	SCALE HORIZONTAL: NA VERTICAL: NA	DRAWING NUMBER I-2.1
STATUS:		REVISION

ISSUE FOR BID

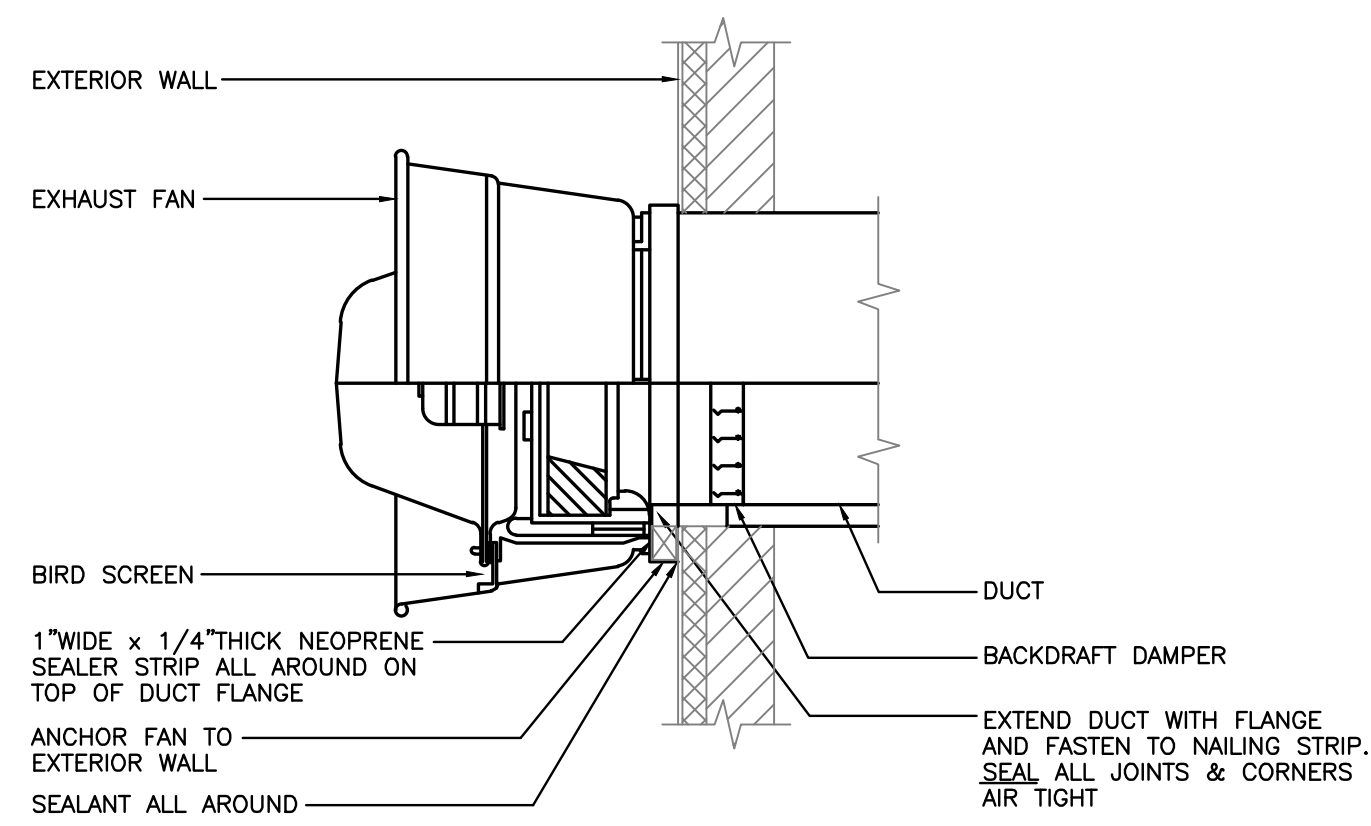

SIDEWALL EXHAUST FAN DETAIL

NO SCALE

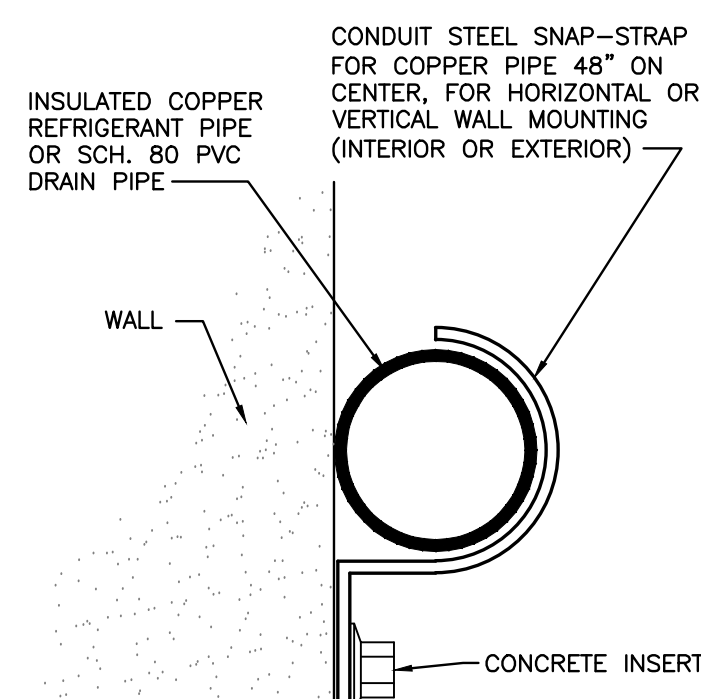


REFRIGERANT PIPING DETAIL

NO SCALE

FRENCH DRAIN DETAIL

NO SCALE

 REFRIGERANT PIPING /
CONDENSATE DRAIN DETAIL
NO SCALE



CONCRETE PAD DETAIL

NO SCALE



FAN SCHEDULE															
MARK	TYPE	AREA SERVED	CFM	E.S.P. (" W.G.)	MAX. NOISE LEVEL (SONES)	FAN WHEEL	FAN TYPE	FAN RPM	MOTOR RPM	FAN BHP	ELECTRICAL			BASIS OF DESIGN/ MODEL	REMARKS (NOTES)
											HP	VOLTS	Ø		
EF-1	SIDEWALL CENTRIFUGAL DIRECT DRIVE	STORAGE ROOM	500	0.25"	5.1	10½"	BACKWARD INCLINE	1152	1300	0.05	1/12	120	1	GREENHECK CW-095-G	1 THRU 13

FAN SCHEDULE

NOTES:

1. ALL FANS MOTORS SHALL BE NON-OVERLOADING.	7. MECHANICAL CONTRACTOR SHALL INSTALL FAN PER MANUFACTURER'S RECOMMENDATION FOR 150 MPH WINDS.
2. FURNISHED ALL FANS WITH UL LISTED STARTERS/DISCONNECT SWITCHES.	8. PROVIDE STANDARD FINISH, CLEAR ANODIZED SPUN ALUMINUM.
3. UNITS SHALL BEAR AMCA SEAL AND U.L. LABEL.	9. PROVIDE ALL ALUMINUM WHEEL, L10-100,000 HR BEARINGS, ALUMINUM BIRDSCREEN.
4. PROVIDE ALUMINUM BACKFAPOT DAMPER.	10. EXHAUST FAN SHALL CONFORM TO AMCA 210 PERFORMANCE RATING AND BEAR THE AMCA CERTIFIED RATING SEAL.
5. PROVIDE SOLID STATE SPEED CONTROL SWITCH.	11. EXHAUST FAN SHALL CONFORM TO AMCA 301 SOUND RATING AND BE TESTED TO AMCA 300.
6. PROVIDE NEMA PREMIUM EFFICIENCY MOTOR WITH RATING STAMPED ON NAMEPLATE.	12. EXHAUST FAN SHALL CONFORM TO AMCA 99 FABRICATION.
	13. BASIS OF DESIGN IS GREENCHECK; EQUALS BY COOK AND TWM QTY ARE ACCEPTABLE.
	14. INSTALL IN ACCORDANCE WITH MANUFACTURER'S INSTRUCTIONS.

REVISION

52 1200
MEDIUM VOLTAGE DRAWOUT
POWER CIRCUIT BREAKER
NUMBER INDICATES CURRENT RATING

DISCONNECT SWITCH
WITH FUSING WHERE NOTED

100 30 (FRAME SIZE)
(TRIP SIZE)
3 POLE THERMAL-MAGNETIC MOLDED CASE CIRCUIT BREAKER

100 30 2P
2 POLE THERMAL-MAGNETIC CIRCUIT BREAKER

800 800 (FRAME SIZE)
(SENSOR RATING)
DRAWOUT POWER CIRCUIT BREAKER
WITH RMS TYPE SOLID STATE TRIP
PROGRAMMER
EO DENOTES ELECTRICALLY
OPERATED

EO (600P)
DENOTES PLUG RATING
WHEN LESS THAN
SENSOR RATING IS
REQUIRED

7A MCP
AC COMBINATION
FULL VOLTAGE NON-REVERSING STARTER
(CONTINUOUS AMP RATING)
(MOTOR CIRCUIT PROTECTOR) MAGNETIC BREAKER

MAGNETIC MOTOR STARTER

OVERLOAD RELAY

7A MCP
AC COMBINATION
FULL VOLTAGE NON-REVERSING
TWO SPEED TWO WINDING STARTER

RVSS-B
ELECTRONIC REDUCED VOLTAGE
SOLID STATE STARTER -RVSS
-B DENOTES WITH FULL SPEED
BYPASS

600/5 3
CURRENT TRANSFORMER, RATIO AND QUANTITY DENOTED

POTENTIAL TRANSFORMER

TRANSFORMER- SIZE AS NOTED ON THE
THE DRAWINGS

SHIELDED ISOLATION
TRANSFORMER

DELTA/WYE TRANSFORMER
CONNECTION W/GROUND

LA
LIGHTNING ARRESTOR

CL 2
FUSE- VOLTAGE AS REQUIRED AND SIZE NOTED ON THE DRAWINGS.
CL DENOTES CURRENT LIMITING TYPE. NUMBER INDICATES QUANTITY
WHEN LESS THAN 3.

A AS
AMMETER - AMMETER SWITCH

V VS
VOLTMETER - VOLTMETER SWITCH

LIGHTING, APPLIANCE OR
INSTRUMENT PANELBOARD

POWER PANELBOARD

	CP — CONTROL PANEL
	MOTOR CONTROL CENTER
	VARIABLE FREQUENCY DRIVE — VFD —B WHEN INDICATED DENOTES WITH STARTING AND FULL SPEED BYPASS
	SELECTOR SWITCH
	INDICATING LIGHT
	DISCONNECT SWITCH — 480V 3POLE UNFUSED OR FUSED F DENOTES FUSING, ONLY WHERE INDICATED FIRST NUMBER DENOTES SWITCH AMP RATING SECOND NUMBER DENOTES FUSE SIZE WHEN PROVIDED.
	60/40
	JUNCTION BOX; SIZE AS REQUIRED BY N.E.C.
	TERMINAL BOX; SIZE AS REQUIRED BY N.E.C. AND TO ACCOMMODATE ALL TERMINATIONS ON TERMINAL BLOCKS. TERMINATIONS TO INCLUDE SPARE WIRING.
	PULL BOX; SIZE AS REQUIRED BY N.E.C.
	MOTOR STARTER/CONTROLLER (NON-COMBINATION — COMBINATION — MANUAL) RV DENOTES REDUCED VOLTAGE
	ELECTRIC MOTOR (NUMBER INDICATES HORSEPOWER).
	ELECTRIC NON-MOTOR LOAD (NUMBER INDICATES KVA).
	MOTORIZED VALVE WITH CONTROLLER BY VENDOR
	MOTORIZED VALVE
	ZONE INTERLOCK
	METER FUNCTIONS
	LIMIT SWITCH CLOSED
	PRESSURE TRANSMITTER (I DENOTES INDICATING TYPE, AND PE DENOTES PRESSURE ELEMENT)
	LEVEL TRANSMITTER (LE DENOTES LEVEL ELEMENT)
	FLOW TRANSMITTER (FE DENOTES FLOW ELEMENT)
	TEMPERATURE SWITCH (TSH DENOTES TEMPERATURE SWITCH HIGH AND TSL DENOTES TEMPERATURE SWITCH LOW)
	LEVEL SWITCH (LSH DENOTES LEVEL SWITCH HIGH AND LSL DENOTES LEVEL SWITCH LOW. LE DENOTES LEVEL ELEMENT)
	STROKE POSITIONER




1-3 	FLUORESCENT LIGHTING FIXTURE — SURFACE OR PENDANT MOUNTED. FIRST NUMERAL DENOTES LIGHTING PANEL (LP1), SECOND NUMBER DENOTES BRANCH CIRCUIT NUMBER. LOWER CASE LETTER DENOTES SWITCHED CIRCUIT.
	FLUORESCENT LIGHTING FIXTURE WITH BATTERY PACK SURFACE OR PENDANT.
	PENDANT OR CEILING MOUNTED LIGHTING FIXTURE.
	WALL MOUNTED LIGHTING FIXTURE.
	POLE OR STANCHION MOUNTED LIGHTING FIXTURE.
	TWO (2) POLE OR STANCHION MOUNTED LIGHTING FIXTURES
GF 	POLE MOUNTED FIXTURE WITH GF RECEPTACLE
	EXIT SIGN WALL MOUNTED (SINGLE FACE WITH INDICATING ARROWS) WITH BATTERY PACK ARROW INDICATES DIRECTION OF EXIT DOOR

OL

THERMALLY ACTUATED MOTOR OVERLOAD RELAY,
LATCHES OPEN ON OVERLOAD


A	AMPERES
AC	ALTERNATING CURRENT
AMB	AMBER
BKR	BREAKER
BLU	BLUE
C, CND	CONDUIT
CA	CONDUIT, ANALOG
CB	CIRCUIT BREAKER
CBV	CABLE BY VENDOR, INSTALLED BY CONTRACTOR
CLG	CEILING
CTRL	CONTROL
CP	CONTROL PANEL
CPB	CONTROL PULL BOX (—X DISCRETE, —XA ANALOG)
CS	CONTROL STATION
DC	DIRECT CURRENT
DWG	DRAWING
EC	EMPTY CONDUIT
EHH	ELECTRICAL HANDHOLE
EL, ELEV	ELEVATION
EMH	ELECTRICAL MANHOLE
EMT	ELECTRICAL METALLIC TUBING
EXIST	EXISTING
FDR	FEEDER
FIXT	FIXTURE
FS	FLOW SWITCH
FT	FEET OR FOOT
FUT	FUTURE
FVNR	FULL VOLTAGE NON—REVERSING
GALV	GALVANIZED
GEC	GROUNDING ELECTRODE CONDUCTOR
G, GND	GROUND
GF, GFI	GROUND FAULT INTERRUPTER
GFCI	GROUND FAULT CIRCUIT INTERRUPTER
GRN	GREEN
HH	HAND HOLE
HOA	HAND/OFF/AUTO
HOR	HAND/OFF/REMOTE
HTR	HEATER
IN, "	INCHES
JB	JUNCTION BOX
KAIC	THOUSAND AMPERES INTERRUPTING CURRENT
KCMIL	THOUSAND CIRCULAR MILS
KVA	THOUSAND VOLT AMPERES
KW	KILOWATTS
LA	LIGHTNING ARRESTOR
LCP	LOCAL CONTROL PANEL

9. MOUNTING HEIGHTS INDICATED ARE TO THE CENTER OF THE DEVICE U.O.N.

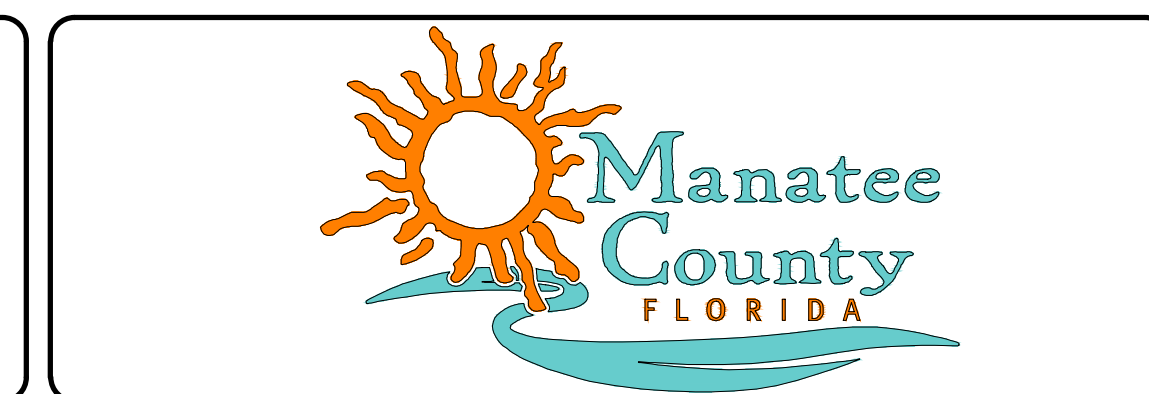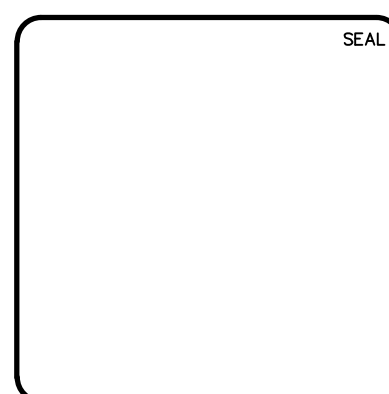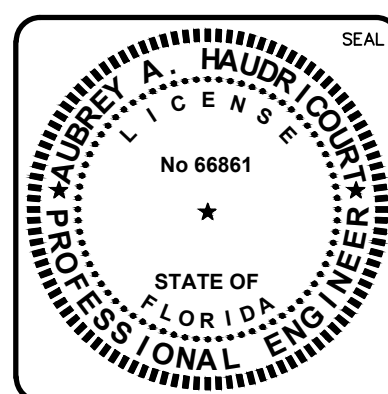[illegible]



INDEX & ABBREVIATIONS

DATE: OCTOBER 2015		SCALE	DRAWING NUMBER
MCE PROJ. #	1024—0167	HORIZONTAL:	E-0.1
DRAWN	LS	AS SHOWN	
DESIGNED	AH	VERTICAL:	
CHECKED	JSL	NA	
PROJ. MGR.	PJL		
STATUS:		REVISION	

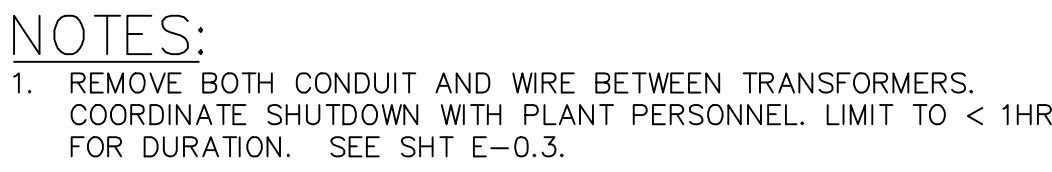


DATE: OCTOBER 2015	SCALE:	DRAWING NUMBER:
MCE PROJ. # 1024-0167	HORIZONTAL: AS SHOWN VERTICAL: NA	E-0.2
DRAWN AAH		
DESIGNED AAH		
CHECKED JSL		
PROJ. MGR. PJL		
STATUS:		

 1. ALL MCC & SWITCHBOARD BREAKERS TO BE 100% RATED WITH ADJUSTABLE ELECTRONIC TRIP.
2. CONDUIT NUMBERING NOT IN SUCCESSION
3. ALL MCC CIRCUIT BREAKERS SHALL HAVE ELECTRONIC TRIP MECHANISMS.

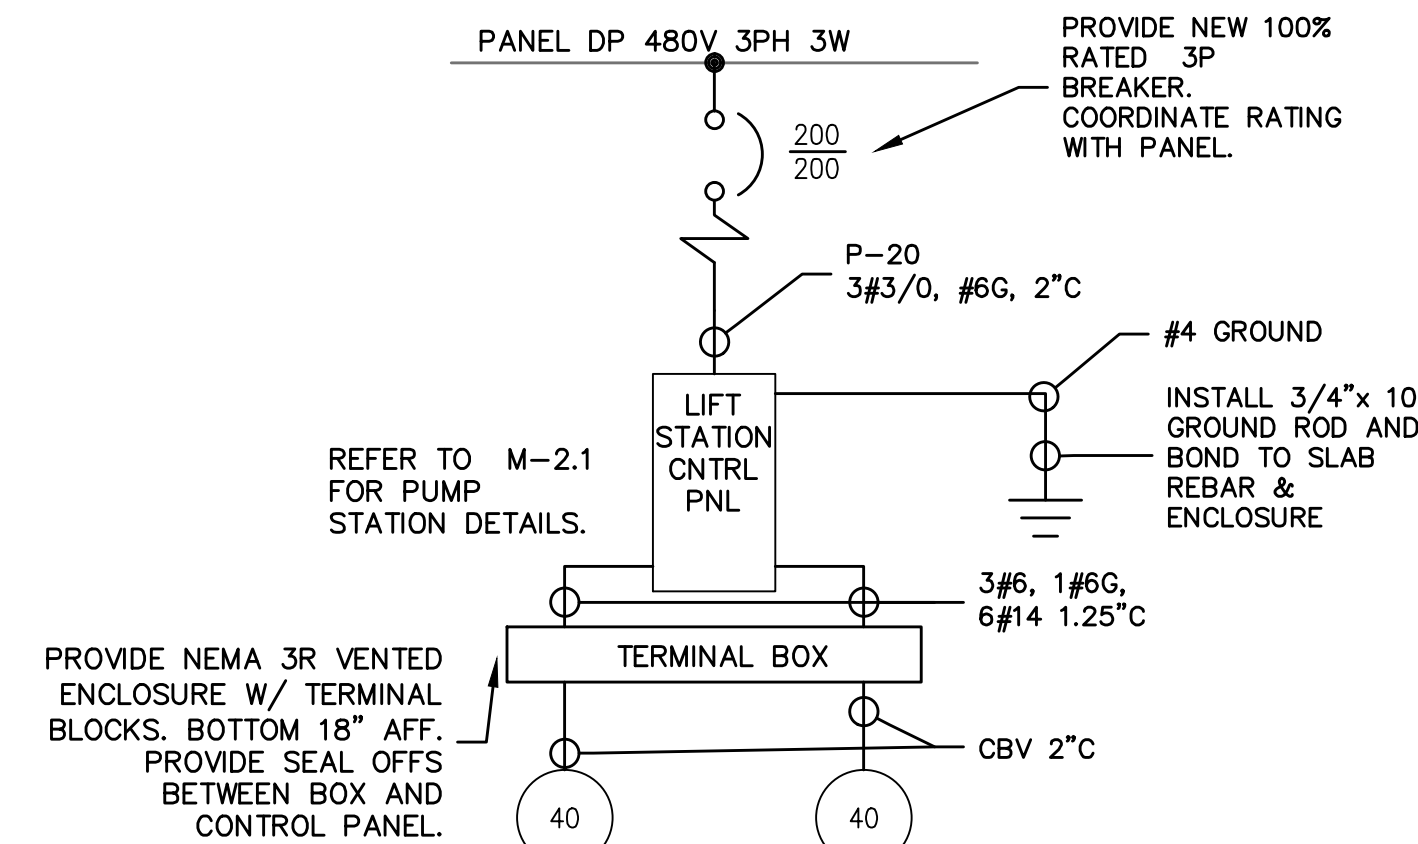


EQ TANK/ BACKWASH POND

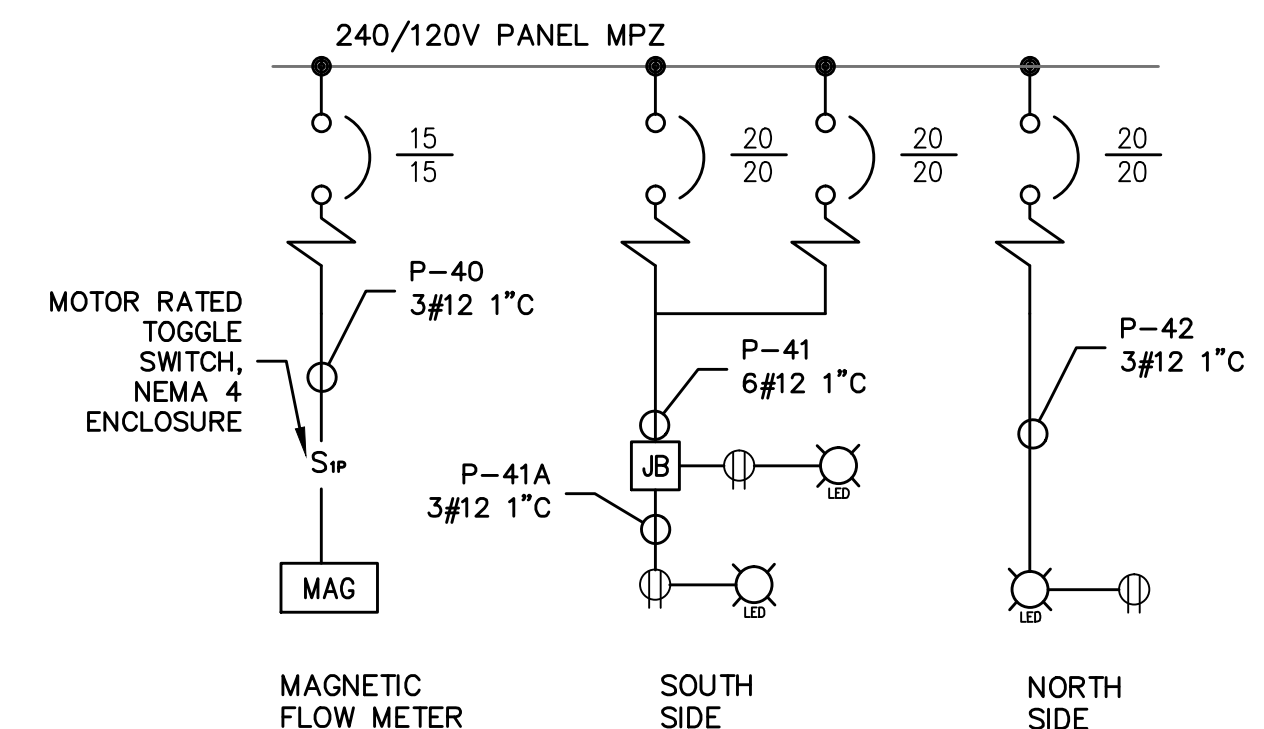

EXISTING FILTER BUILDING


MCC-B 480V 1200A 3Ø, 3W 65kAIC (EXISTING FILTER BLDG)

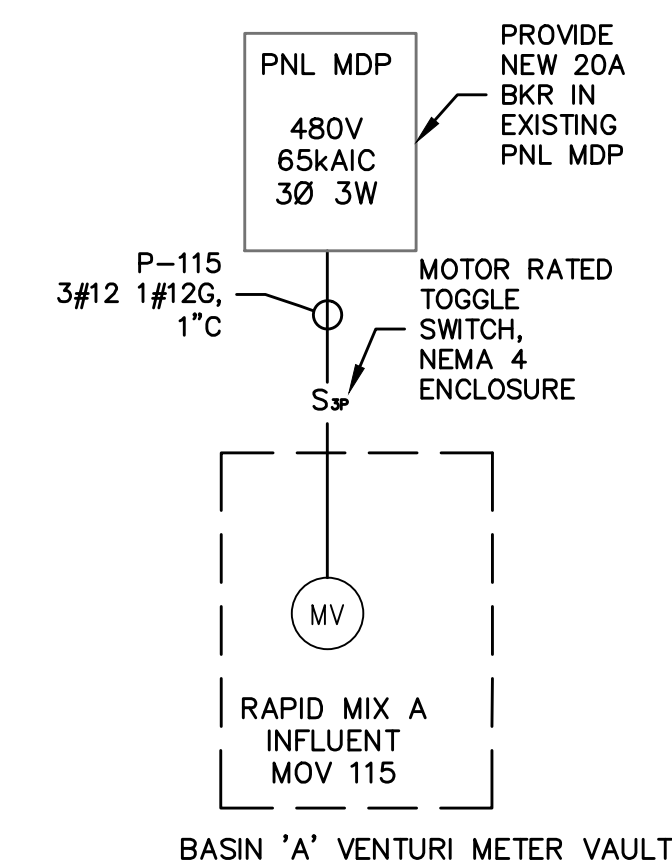





SWBD FEEDER LOAD TABLE				
LOAD	CONNECTED (A)	RUNNING	REMARKS	
BACKWASH PUMP NO.1	361	306.9	⊗ .85	
BACKWASH PUMP NO.2	361	—	STANDBY	
BLOWER NO.1	240	204.0	⊗ .85	
BLOWER NO.2	240	—	STANDBY	
	0	0		
	0	0		
MCC—7	89	76		
MCC—8	114	81		
TOTAL (AMPS)	1405.0	667.9		

BIO-FILTER MCC LOAD TABLE				
LOAD	CONNECTED	RUNNING	REMARKS	
XFMR (LP-7)	47.9	40.7	⊕ .85	
PP-7A	24.4	20.7	⊕ .85	
PP-7B	16.9	14.4	⊕ .85	
SUBTOTAL MCC-7	89.2	75.8		
HVAC ODU-1	40.0	34.0	⊕ .85	
MPC-1	29.1	24.7	⊕ .85	
PP-8A	24.4	12.2	VALVE PNL ⊕ 50%	
PP-8B	20.6	10.3	VALVE PNL ⊕ 50%	
SUBTOTAL MCC 8	114.1	81.2		
TOTAL (AMPS)	203.3	157.1		

LIME SILO BUILDING

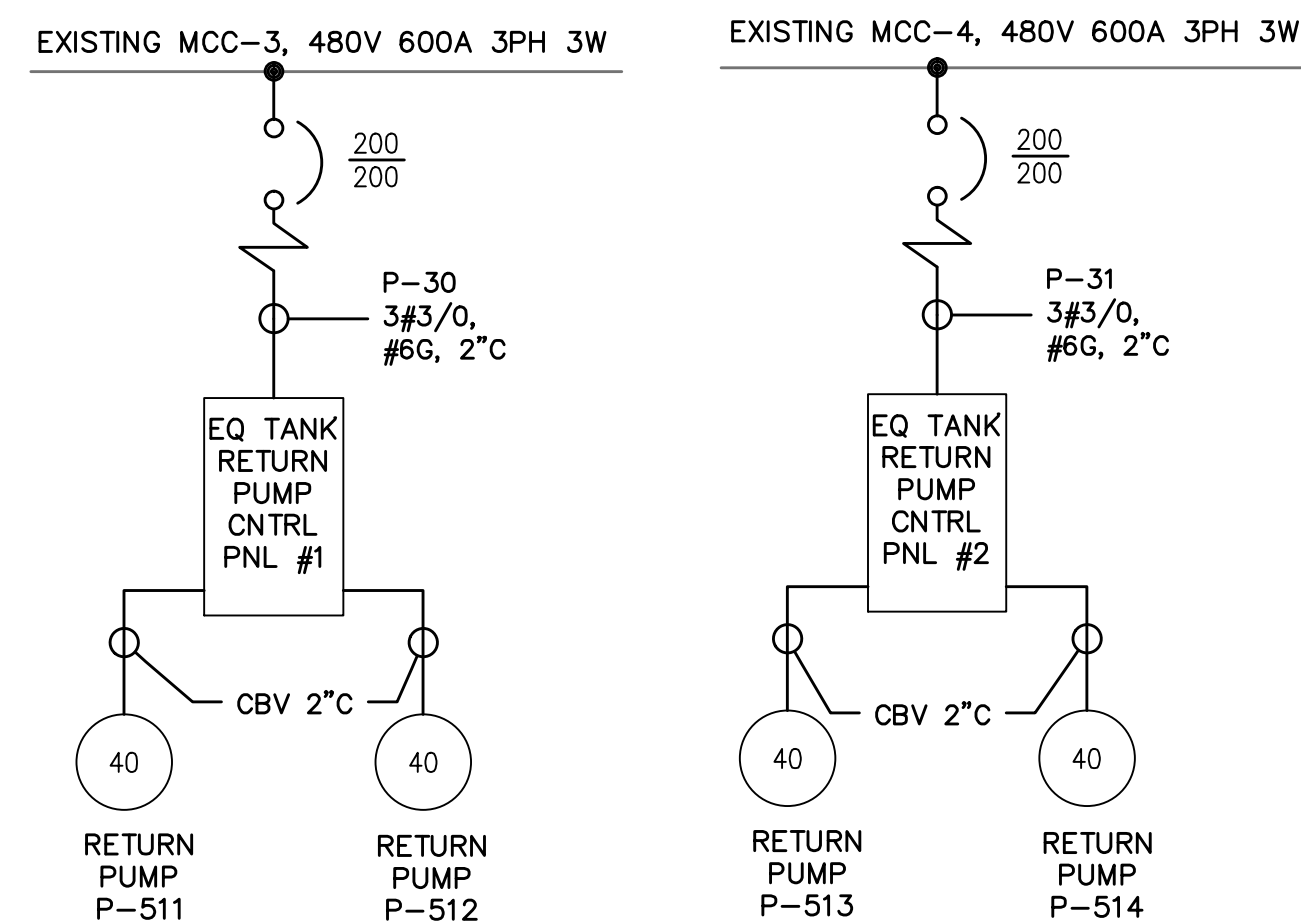

EQ TANK/ BACKWASH POND

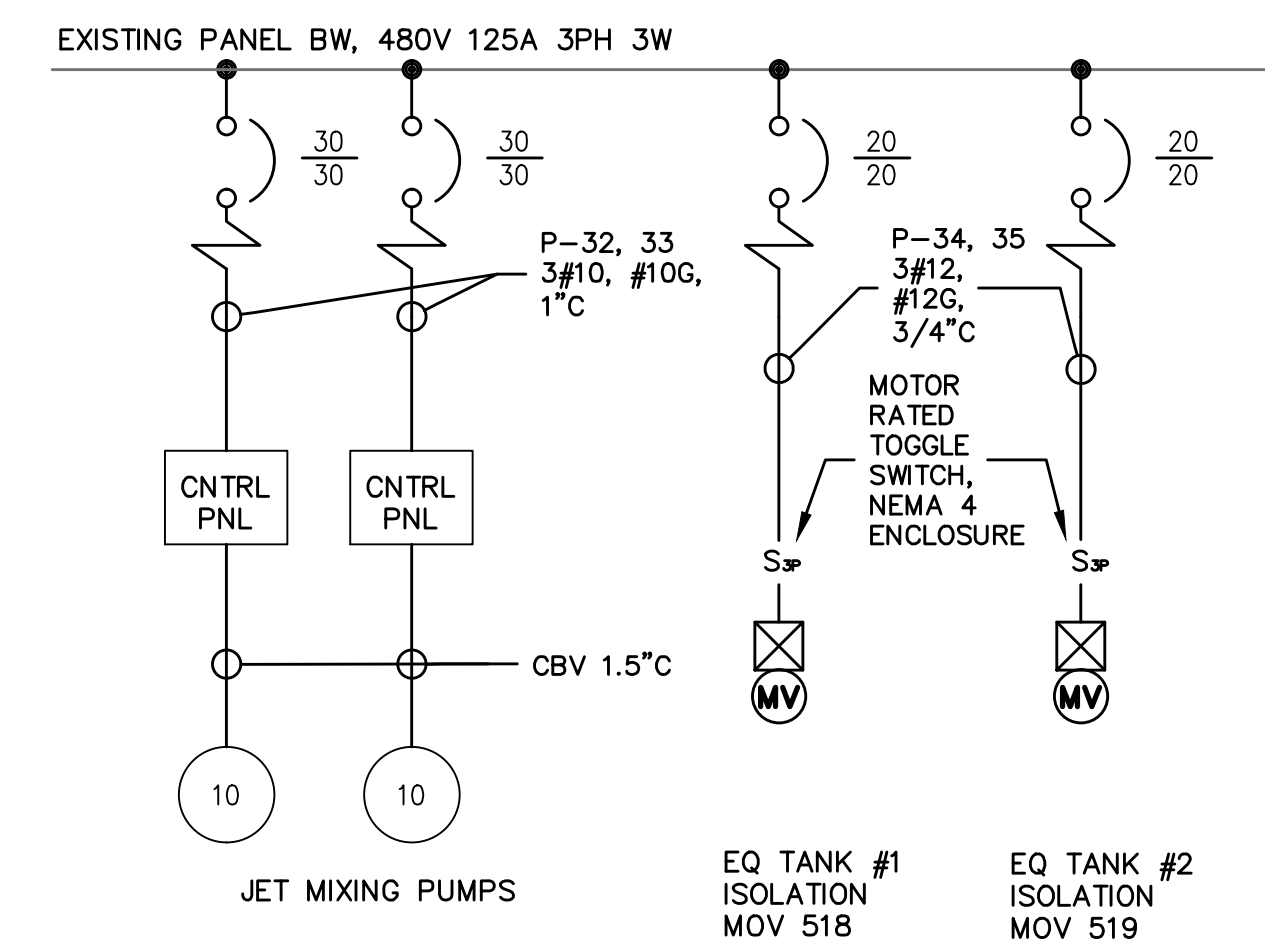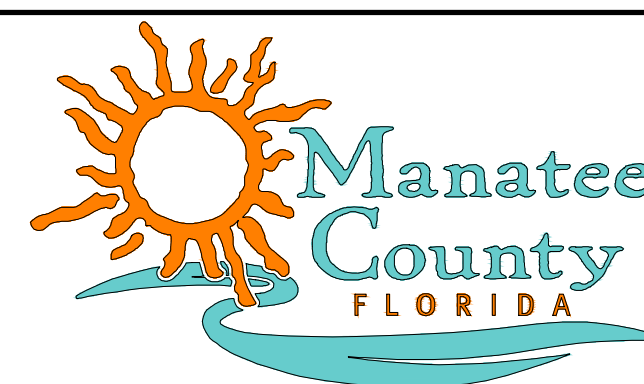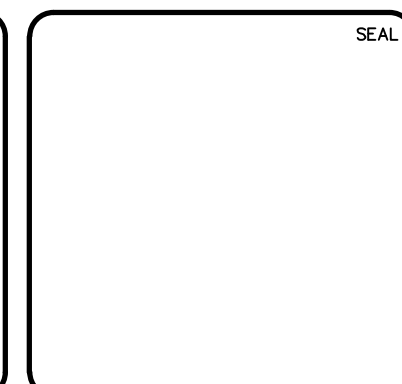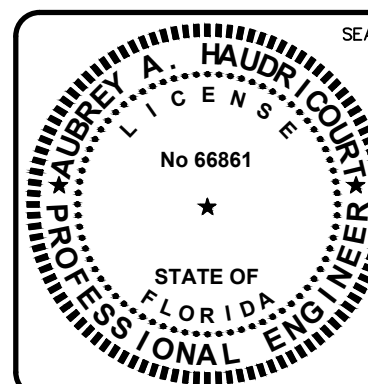[illegible]

MANATEE COUNTY WTP BIOLOGICAL TREATMENT UNIT
SWITCHGEAR AND MCC-7 & 8 ONE LINE

DATE: OCTOBER 2015	SCALE	DRAWING NUMBER
MCE PROJ. # 1024-0167	HORIZONTAL: AS SHOWN VERTICAL: NA	E-0.8
DRAWN AAH		
DESIGNED AAH		
CHECKED JSL		
PROJ. MGR. PUL		
STATUS:		REVISION

20' 0 20' 40'


SCALE: 1"=20' (Horiz.)

 NORTH



NOTES:

1. CONTRACTOR TO REPLACE EXISTING A-FRAME BOX SUPPORTS OF CONDUIT WITH NEW FRP UV RATED SUPPORT SYSTEM (APPROX. 60 SUPPORTS SEE PHOTO THIS SHEET) PROVIDE ALL ANCHORING AND ROOF PROTECTION. PROVIDE ANY ROOF PATCHING AS NECESSARY WHERE SUPPORTS ARE REMOVED OR RE-INSTALLED. PROTECT ROOF WORK AREA DURING CONSTRUCTION ACTIVITIES ON THE ROOF.

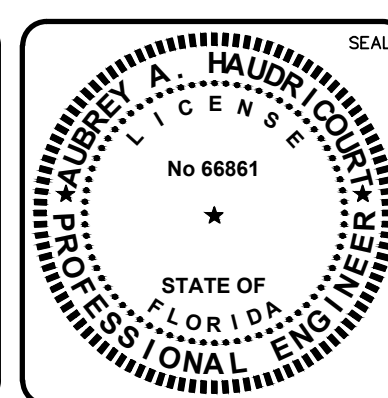[illegible]



McKIM & CREED
 1365 Hamlet Avenue
 Clearwater, Florida 33756
 Phone: (727)442-7196, Fax: (727)461-3827
 CA Lic. No. 29588
www.mckimcreed.com



MANATEE COUNTY
WTP BIOLOGICAL TREATMENT UNIT

ELECTRICAL SITE PLAN 2

DATE:	OCTOBER 2015	SCALE	DRAWING NUMBER
MCE PROJ. #	1024-0167	HORIZONTAL:	E-1.2
DRAWN	AAH	1" = 20'	
DESIGNED	AAH	VERTICAL:	
CHECKED	JSL	NA	
PROJ. MGR.	PJL		

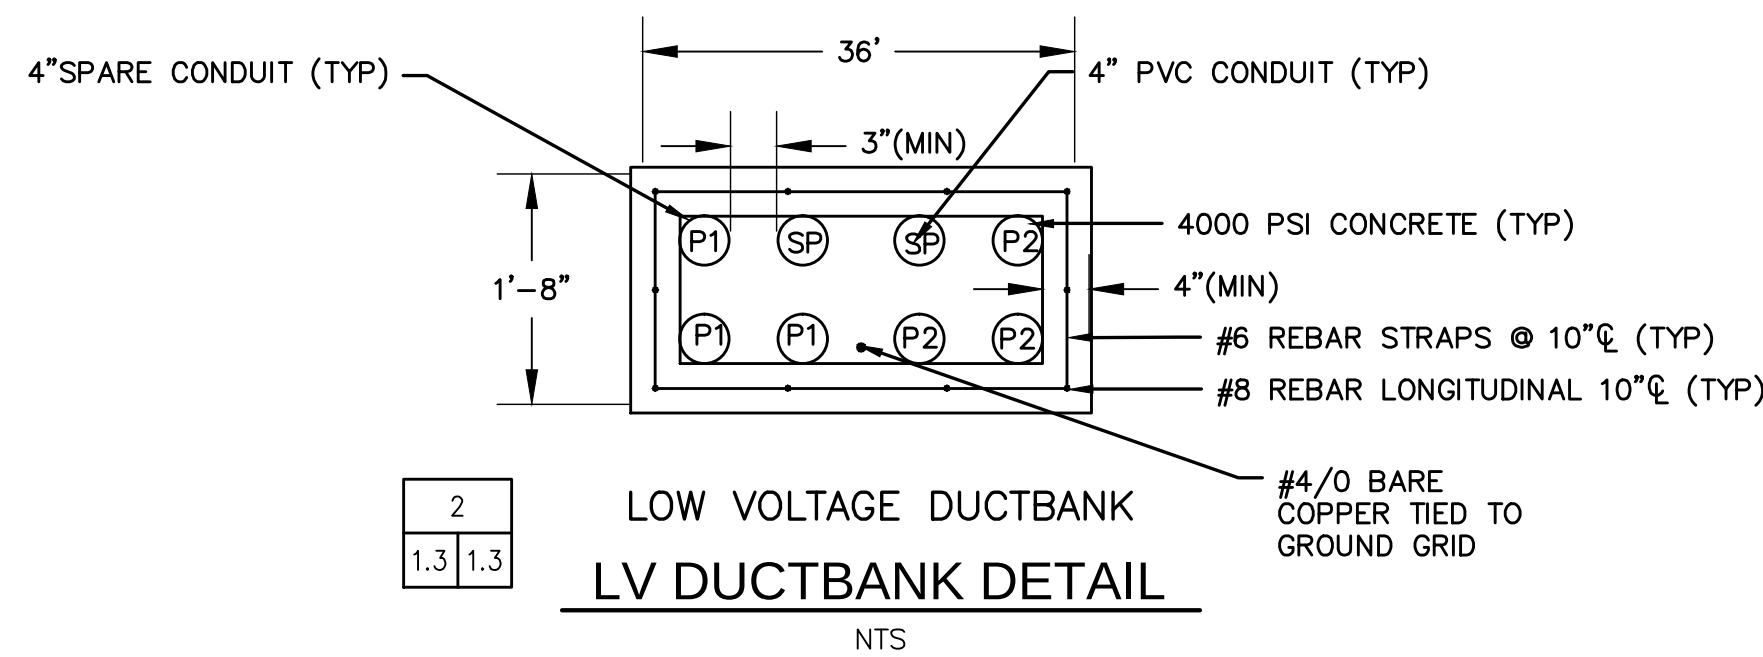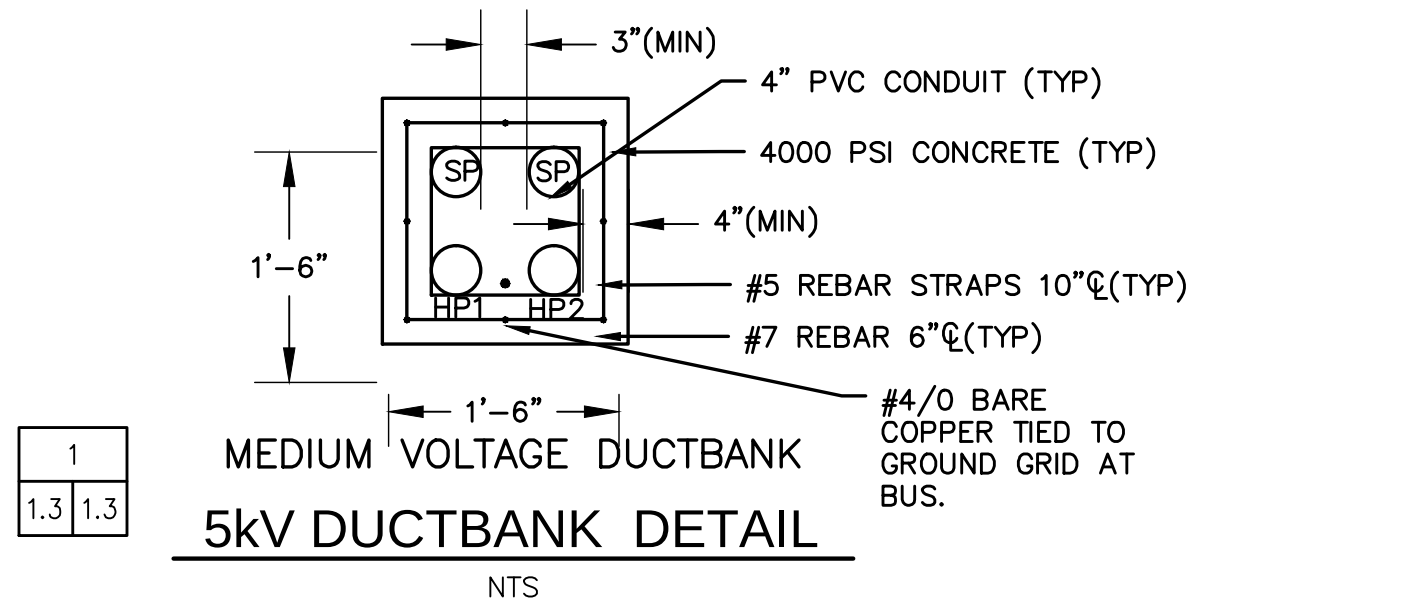

NOTES:

- CONTRACTOR TO REMOVE CONTROL & POWER WIRE CIRCUITS AND CUT CONDUIT FLUSH IN BREAKER SPACE F7 (107B) TO GT-1. (PROVIDE TEMP POWER & CONTROL AS NEEDED) THIS IS TO CLEAR THE SPACE FOR THE NEW MV POWER BREAKER. CONTRACTOR TO REPULL IN NEW OVERHEAD CONDUIT (1-1", 1-1.25") CONTROL & POWER CIRCUITS FOR GT-1 TO GENERATOR SWITCHGEAR. CONTRACTOR TO EMPLOY THE SERVICE OF THE COUNTY'S EMERSON (ASCO) REPRESENTATIVE TO TERMINATE AND TEST GENERATOR CONTROL CIRCUITS FOR GT-1.
- FEEDER P4: CONTRACTOR TO SURFACE MOUNT TO WALL 4" CONDUIT. PROVIDE JUNCTION BOXES AS NECESSARY TO TURN AND RUN UNDER PIPE SUPPORTS ALONG WALKWAY, THEN TURN AND RUN ON ROOF TOP UTILIZING SUPPORTS FOR EXISTING FEEDER CONDUITS TO TRANSFORMER 3 & 4 AREA. PROVIDE ANY NEW SUPPORTS AS NECESSARY.
- CONTRACTOR TO INTERCEPT EXISTING CONDUIT, EXTEND INTO PULLBOXES AND NEW VENTURI AND VALVE ACTUATOR AND RE-PULL NEW WIRE TO CONTROL ROOM CONSOLE FOR SIGNALS. FOR POWER, BRING NEW CONDUIT IN TO DISTRIBUTION PANELS MDP. INSTALL NEW 3P 20A BREAKER FOR VALVE. PROVIDE CONDUIT, WIRE AND JUNCTION BOXES AS NECESSARY.


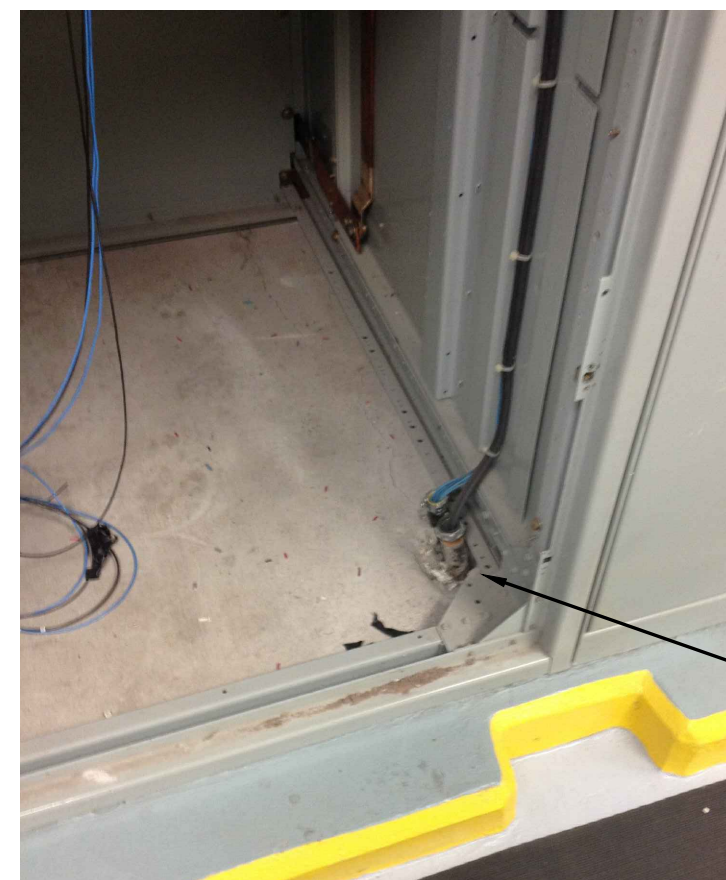




PHOTO 1
E-1.3 E-1.3 PARTIAL PHOTOGRAPH
NTS
FEEDER SECTION 107B
NTS

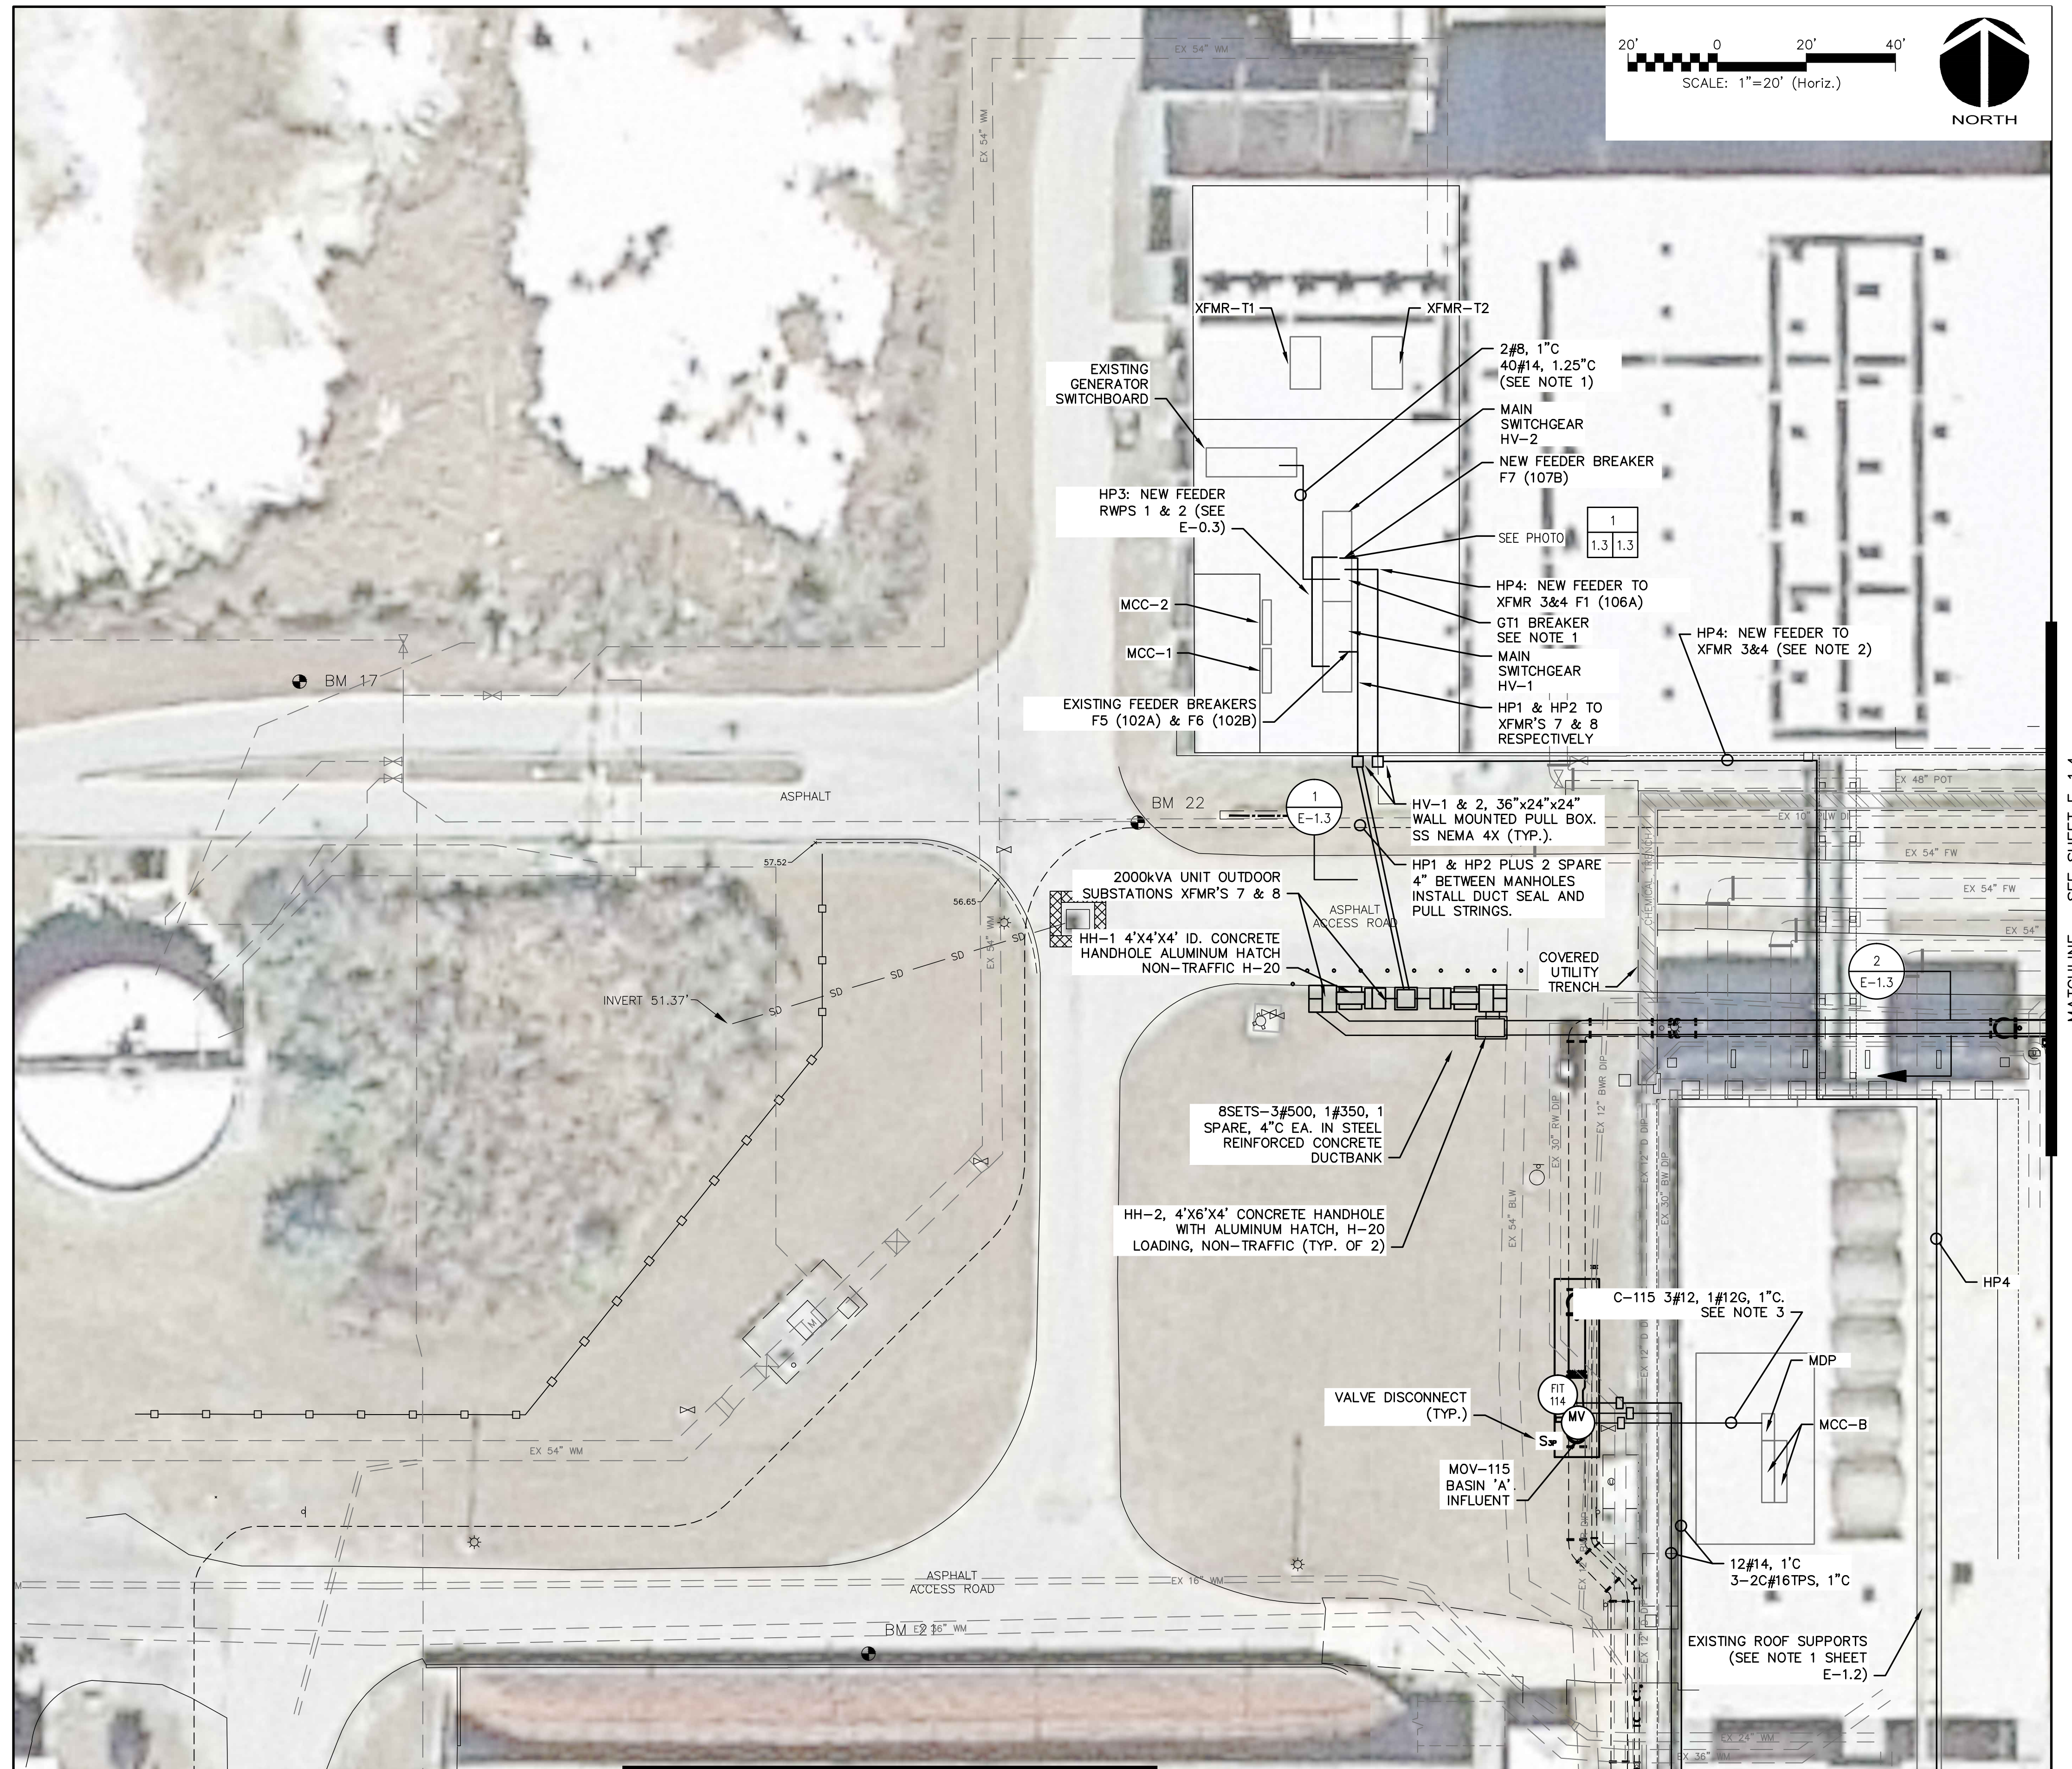

MATCHLINE - SEE SHEET E-1.1

MATCHLINE - SEE SHEET E-1.4

REV. NO.	DESCRIPTIONS	DATE

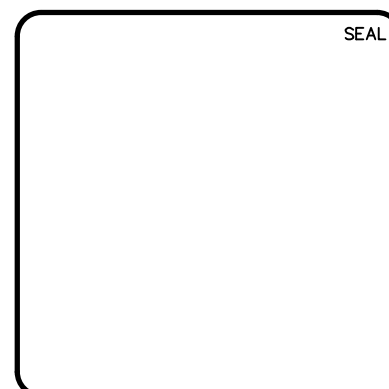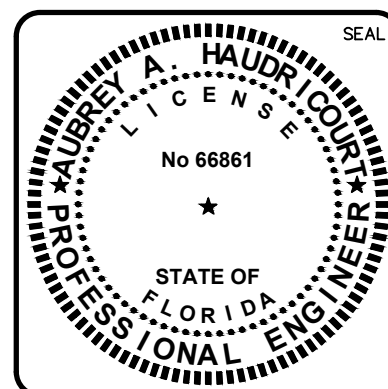

MCKIM & CREED
1365 Hamlet Avenue
Clearwater, Florida 33756
Phone: (727)442-7196, Fax: (727)461-3827
CA Lic. No. 29588
www.mckimcreed.com



MANATEE COUNTY
WTP BIOLOGICAL TREATMENT UNIT

ELECTRICAL SITE PLAN 3


DATE: OCTOBER 2015	SCALE: 1" = 20'	DRAWING NUMBER: E-1.3
MCE PROJ. # 1024-0167	HORIZONTAL: 1" = 20'	REVISION: ISSUE FOR BID
DRAWN: AAH	VERTICAL: NA	
DESIGNED: AAH		
CHECKED: JSL		
PROJ. MGR. P.J.		

20' 0 20' 40'

SCALE: 1"=20' (Horiz.)



NORTH

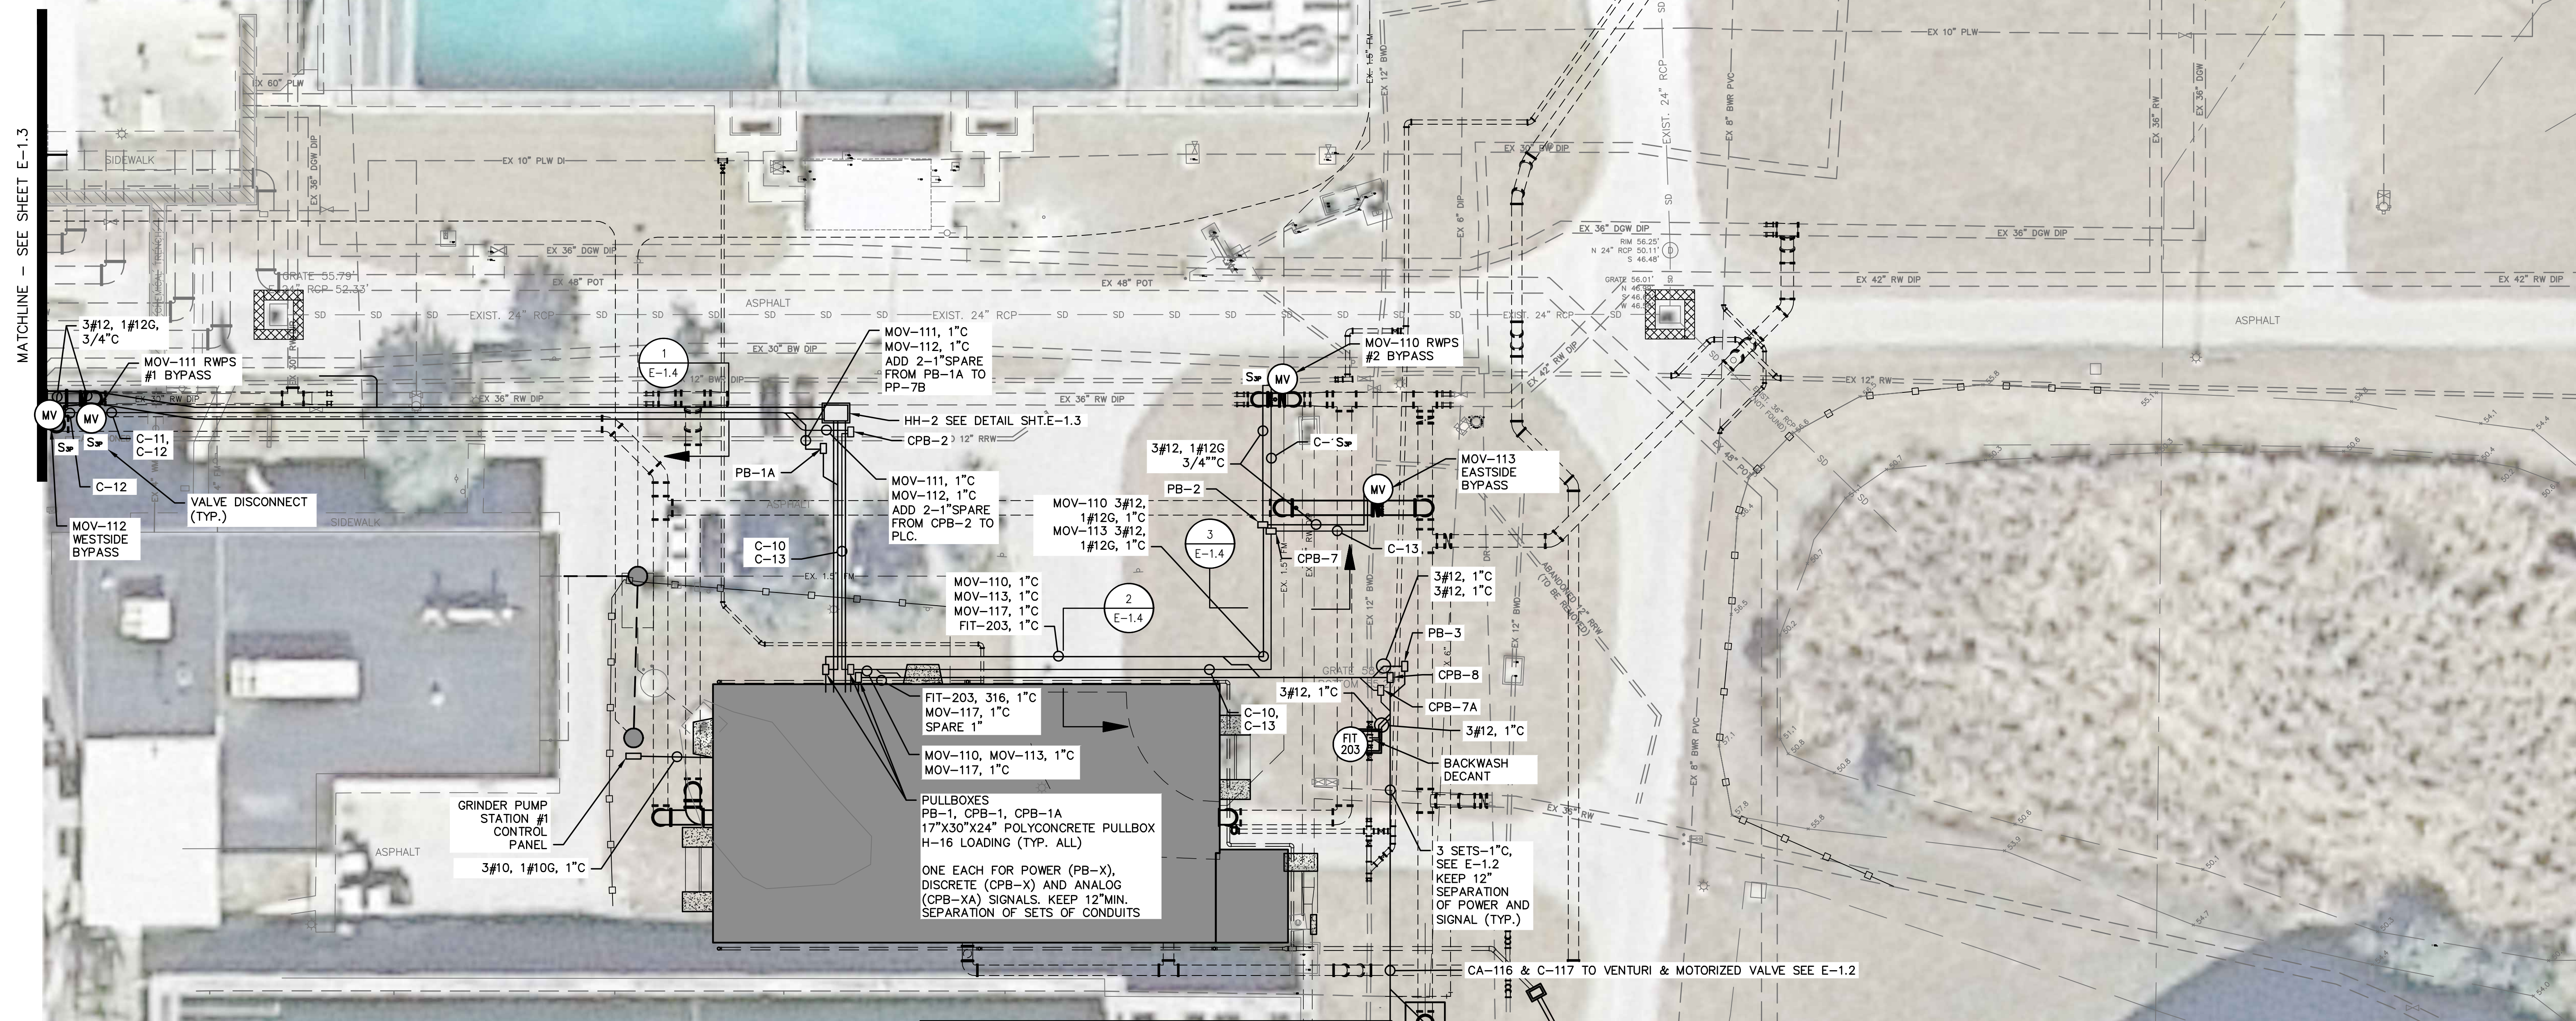

McKIM & CREED
 1365 Hamlet Avenue
 Clearwater, Florida 33756
 Phone: (727)442-7196, Fax: (727)461-3827
 CA Lic. No. 29588
www.mckimcreed.com






ELECTRICAL SITE PLAN 4

DATE:	OCTOBER 2015	SCALE	DRAWING NUMBER
MCE PROJ. #	1024-0167	HORIZONTAL:	E-1.4
DRAWN	AAH	1" = 20'	
DESIGNED	AAH	VERTICAL:	
CHECKED	JSL	NA	
PROJ. MGR.	PUL		



[illegible]

Path: \\1024\0167\80-drawings\Electrical\E-1.4 10240167 E-Site Plan 4.dwg, 9/30/2015 11:21:29 AM, Brian Naught

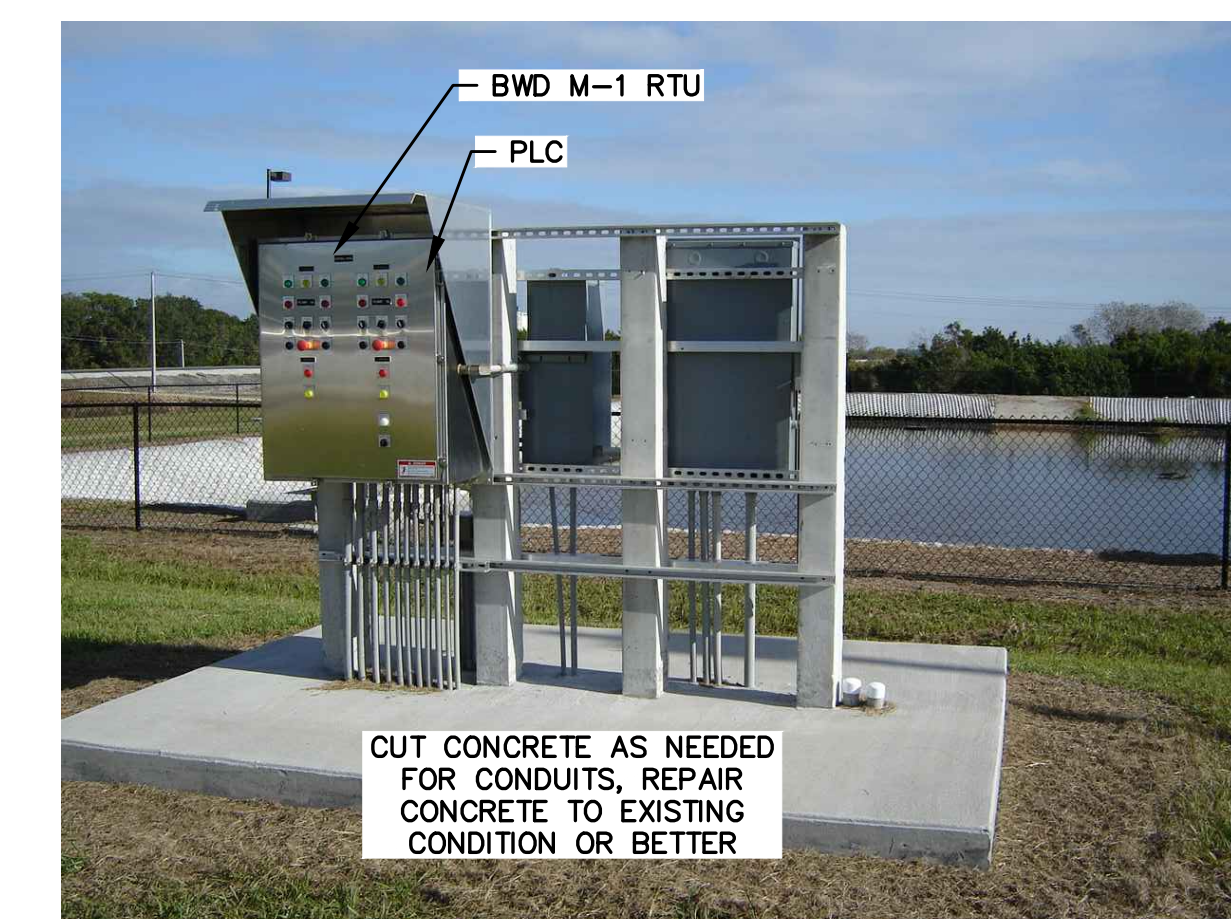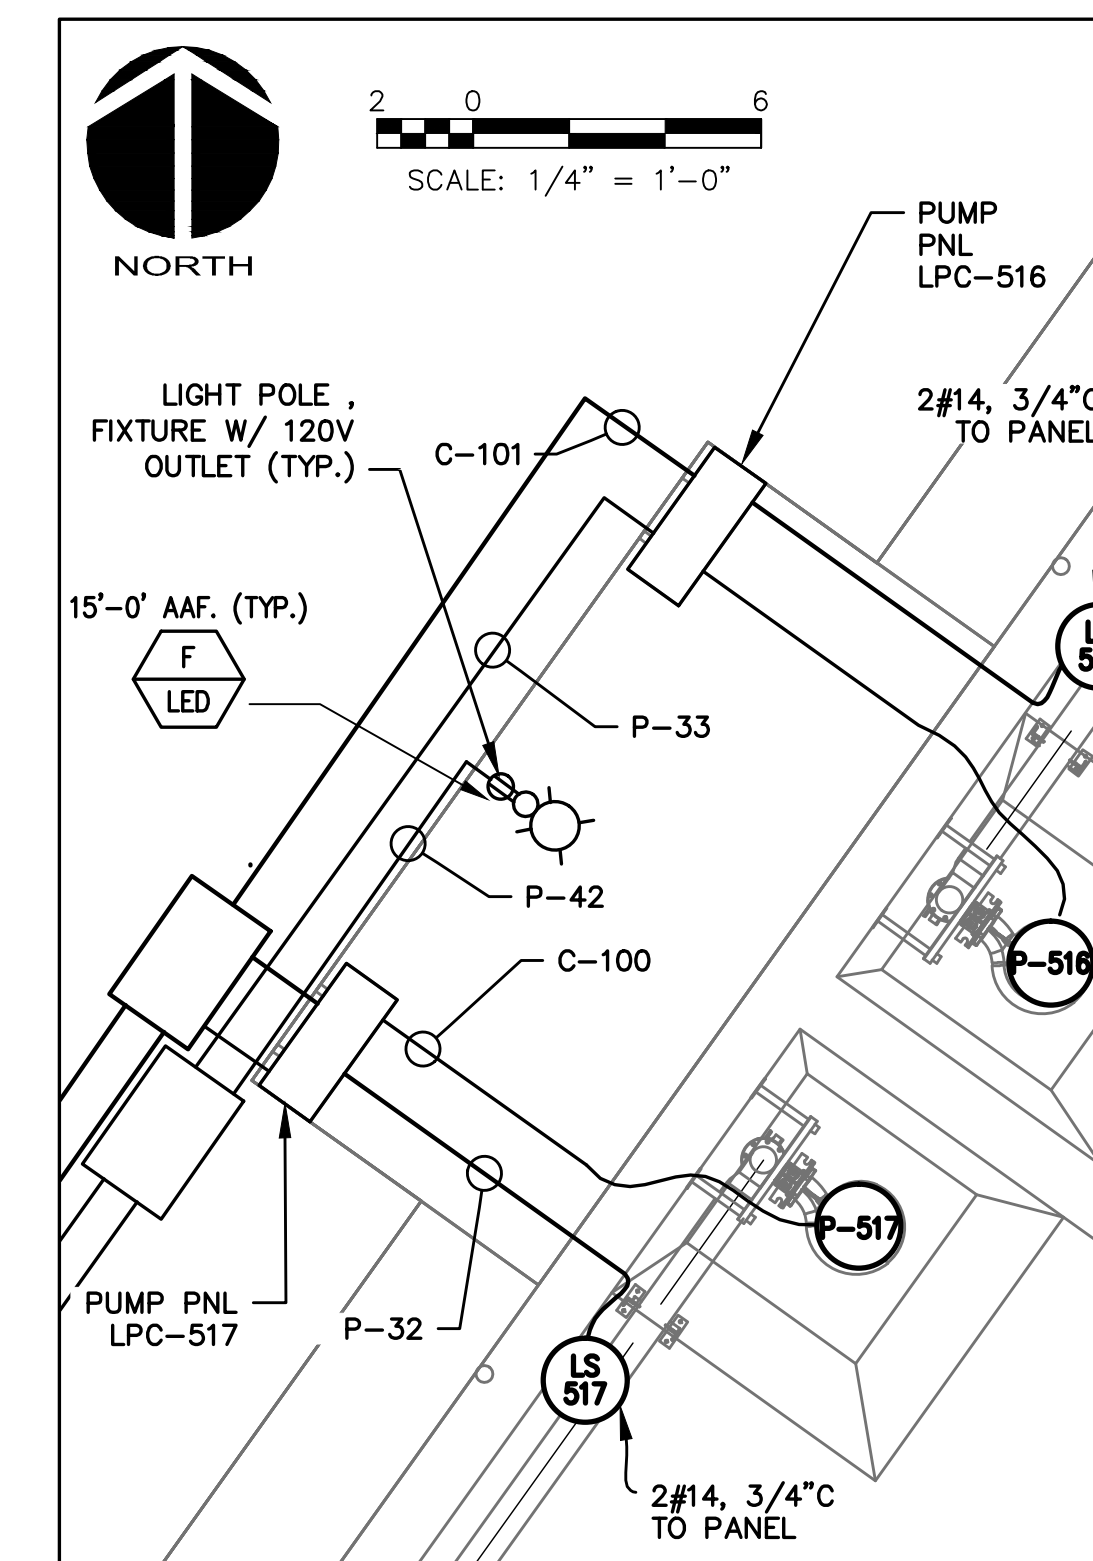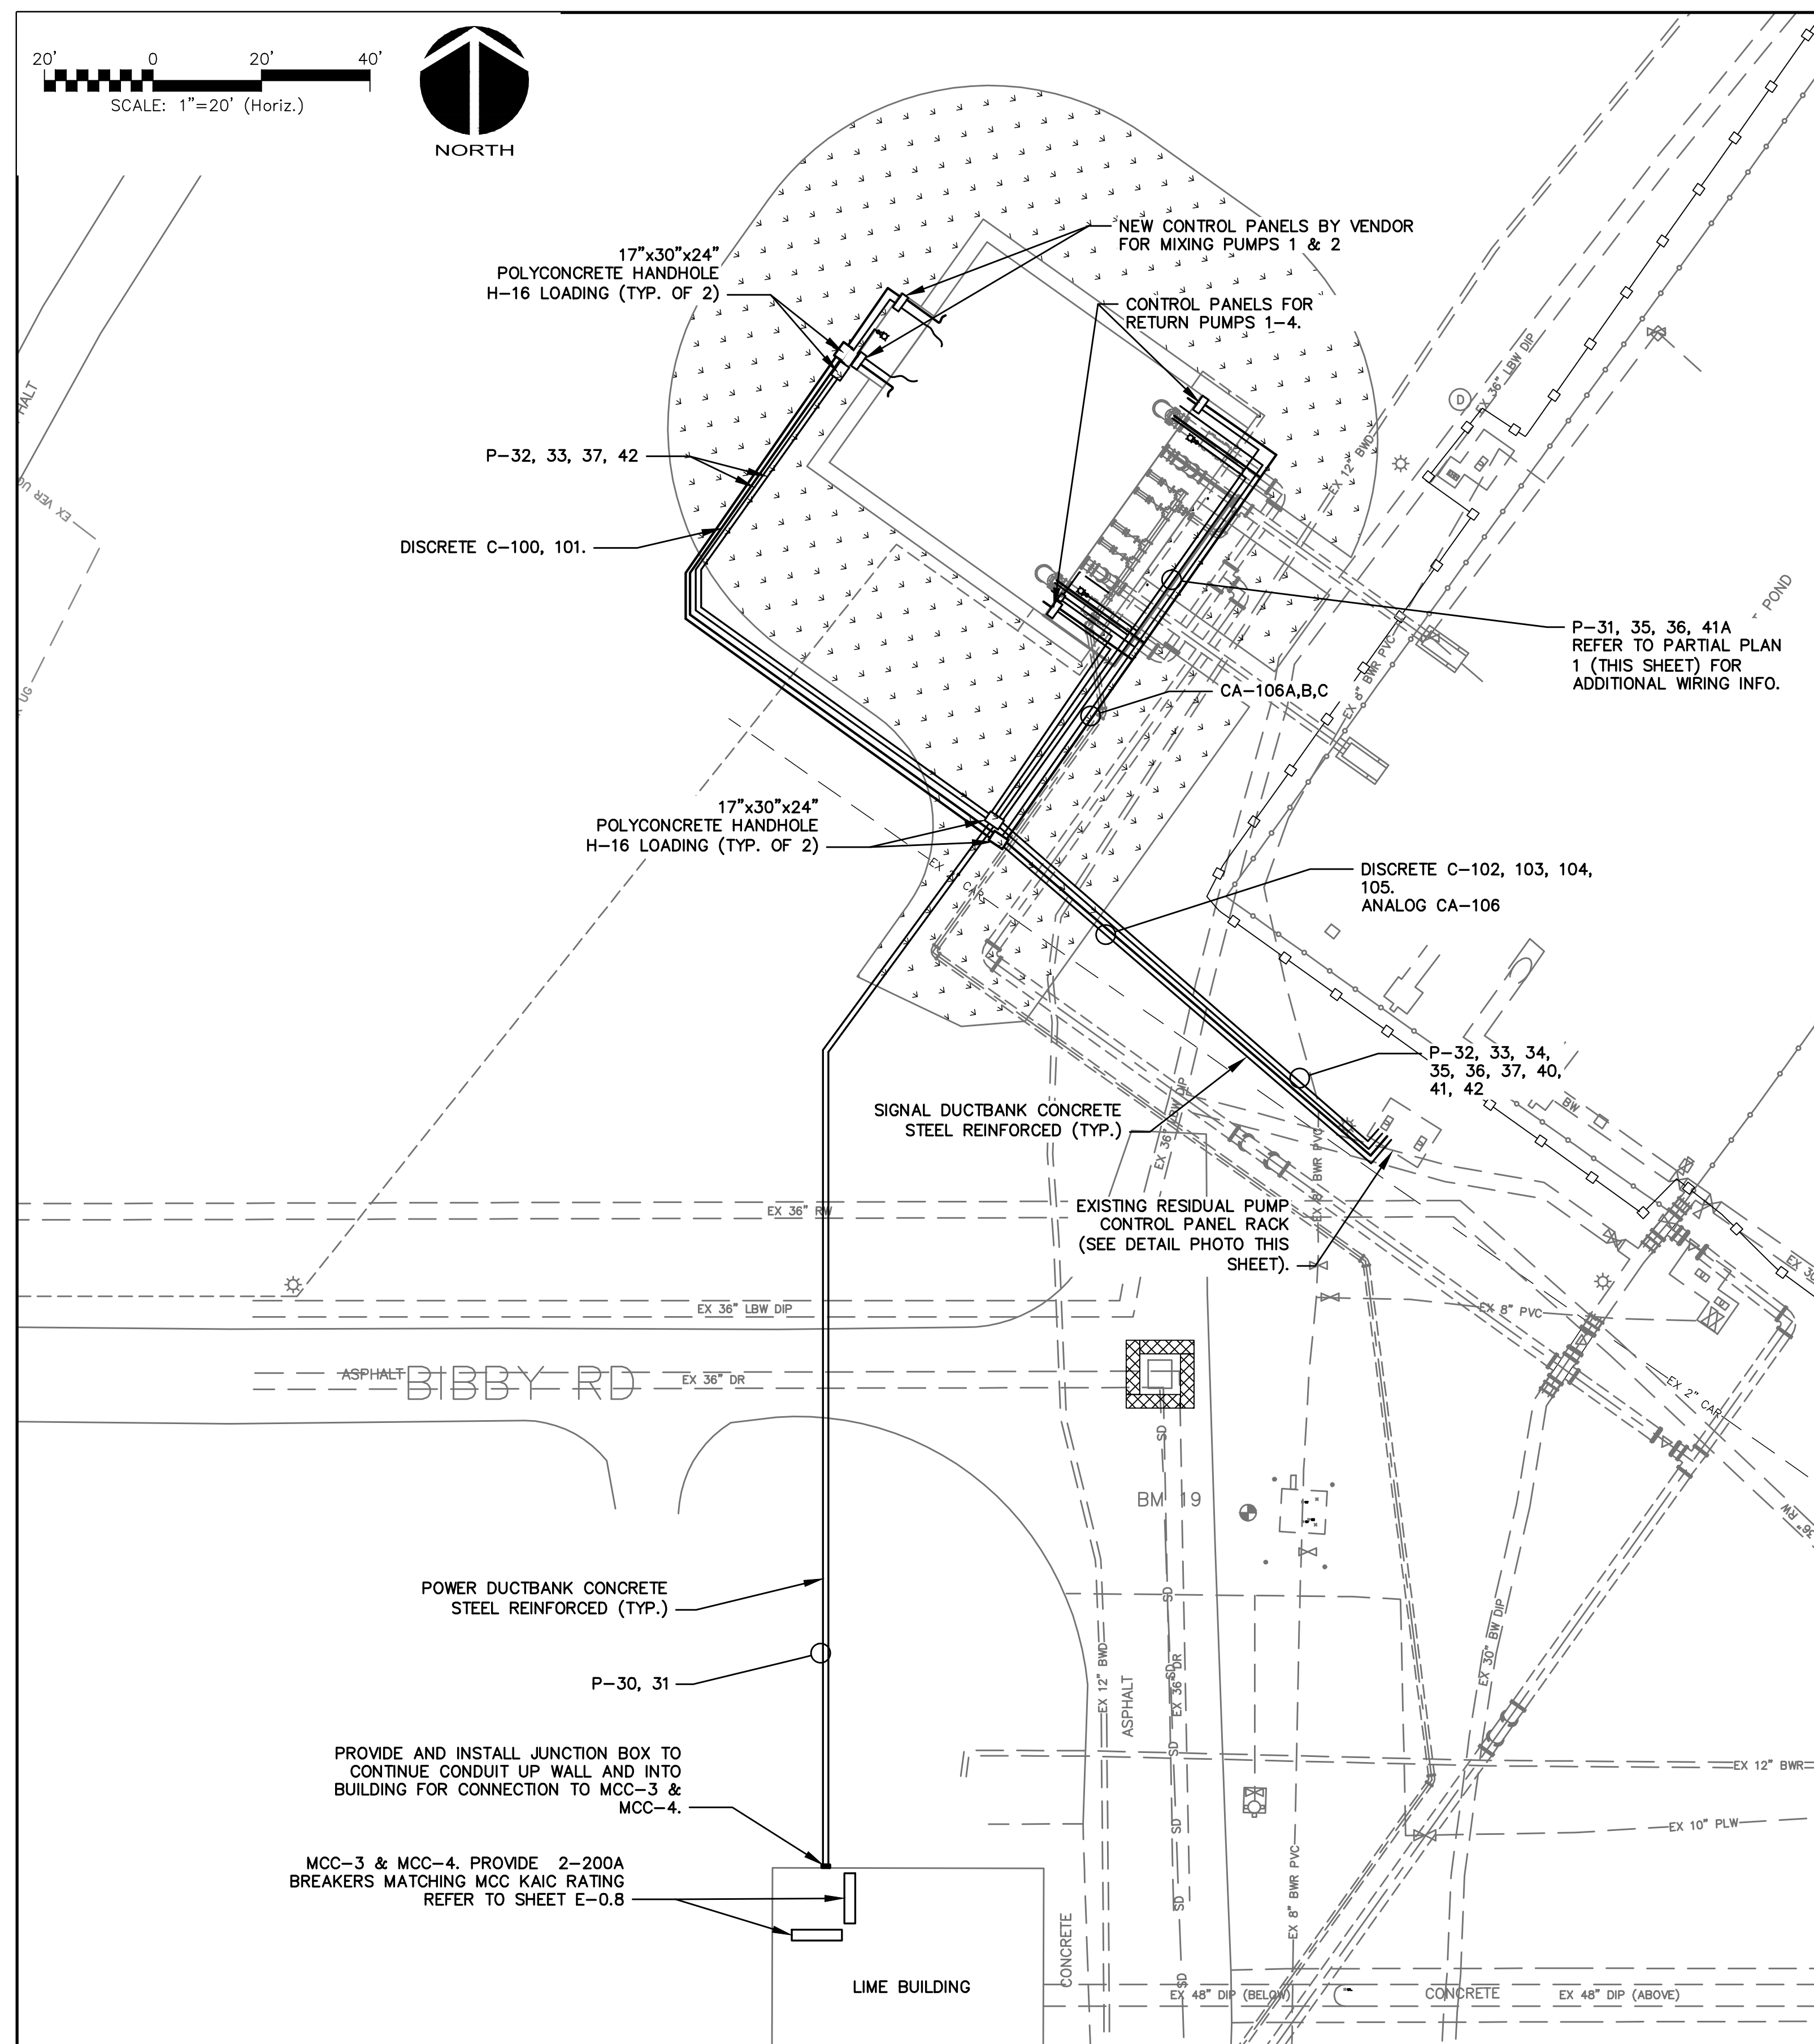

NOTES:

1. PROVIDE TWO NEW FULLY RATED 200A BREAKERS IN EXISTING BW 480V PANEL. MATCH KAIC RATING
2. PROVIDE NEW BREAKERS AS REQUIRED MATCH KAIC RATING OF PANEL MPZ.
3. REFER TO SHEET E-3.1 FOR MORE CONTROL WIRING INFORMATION.

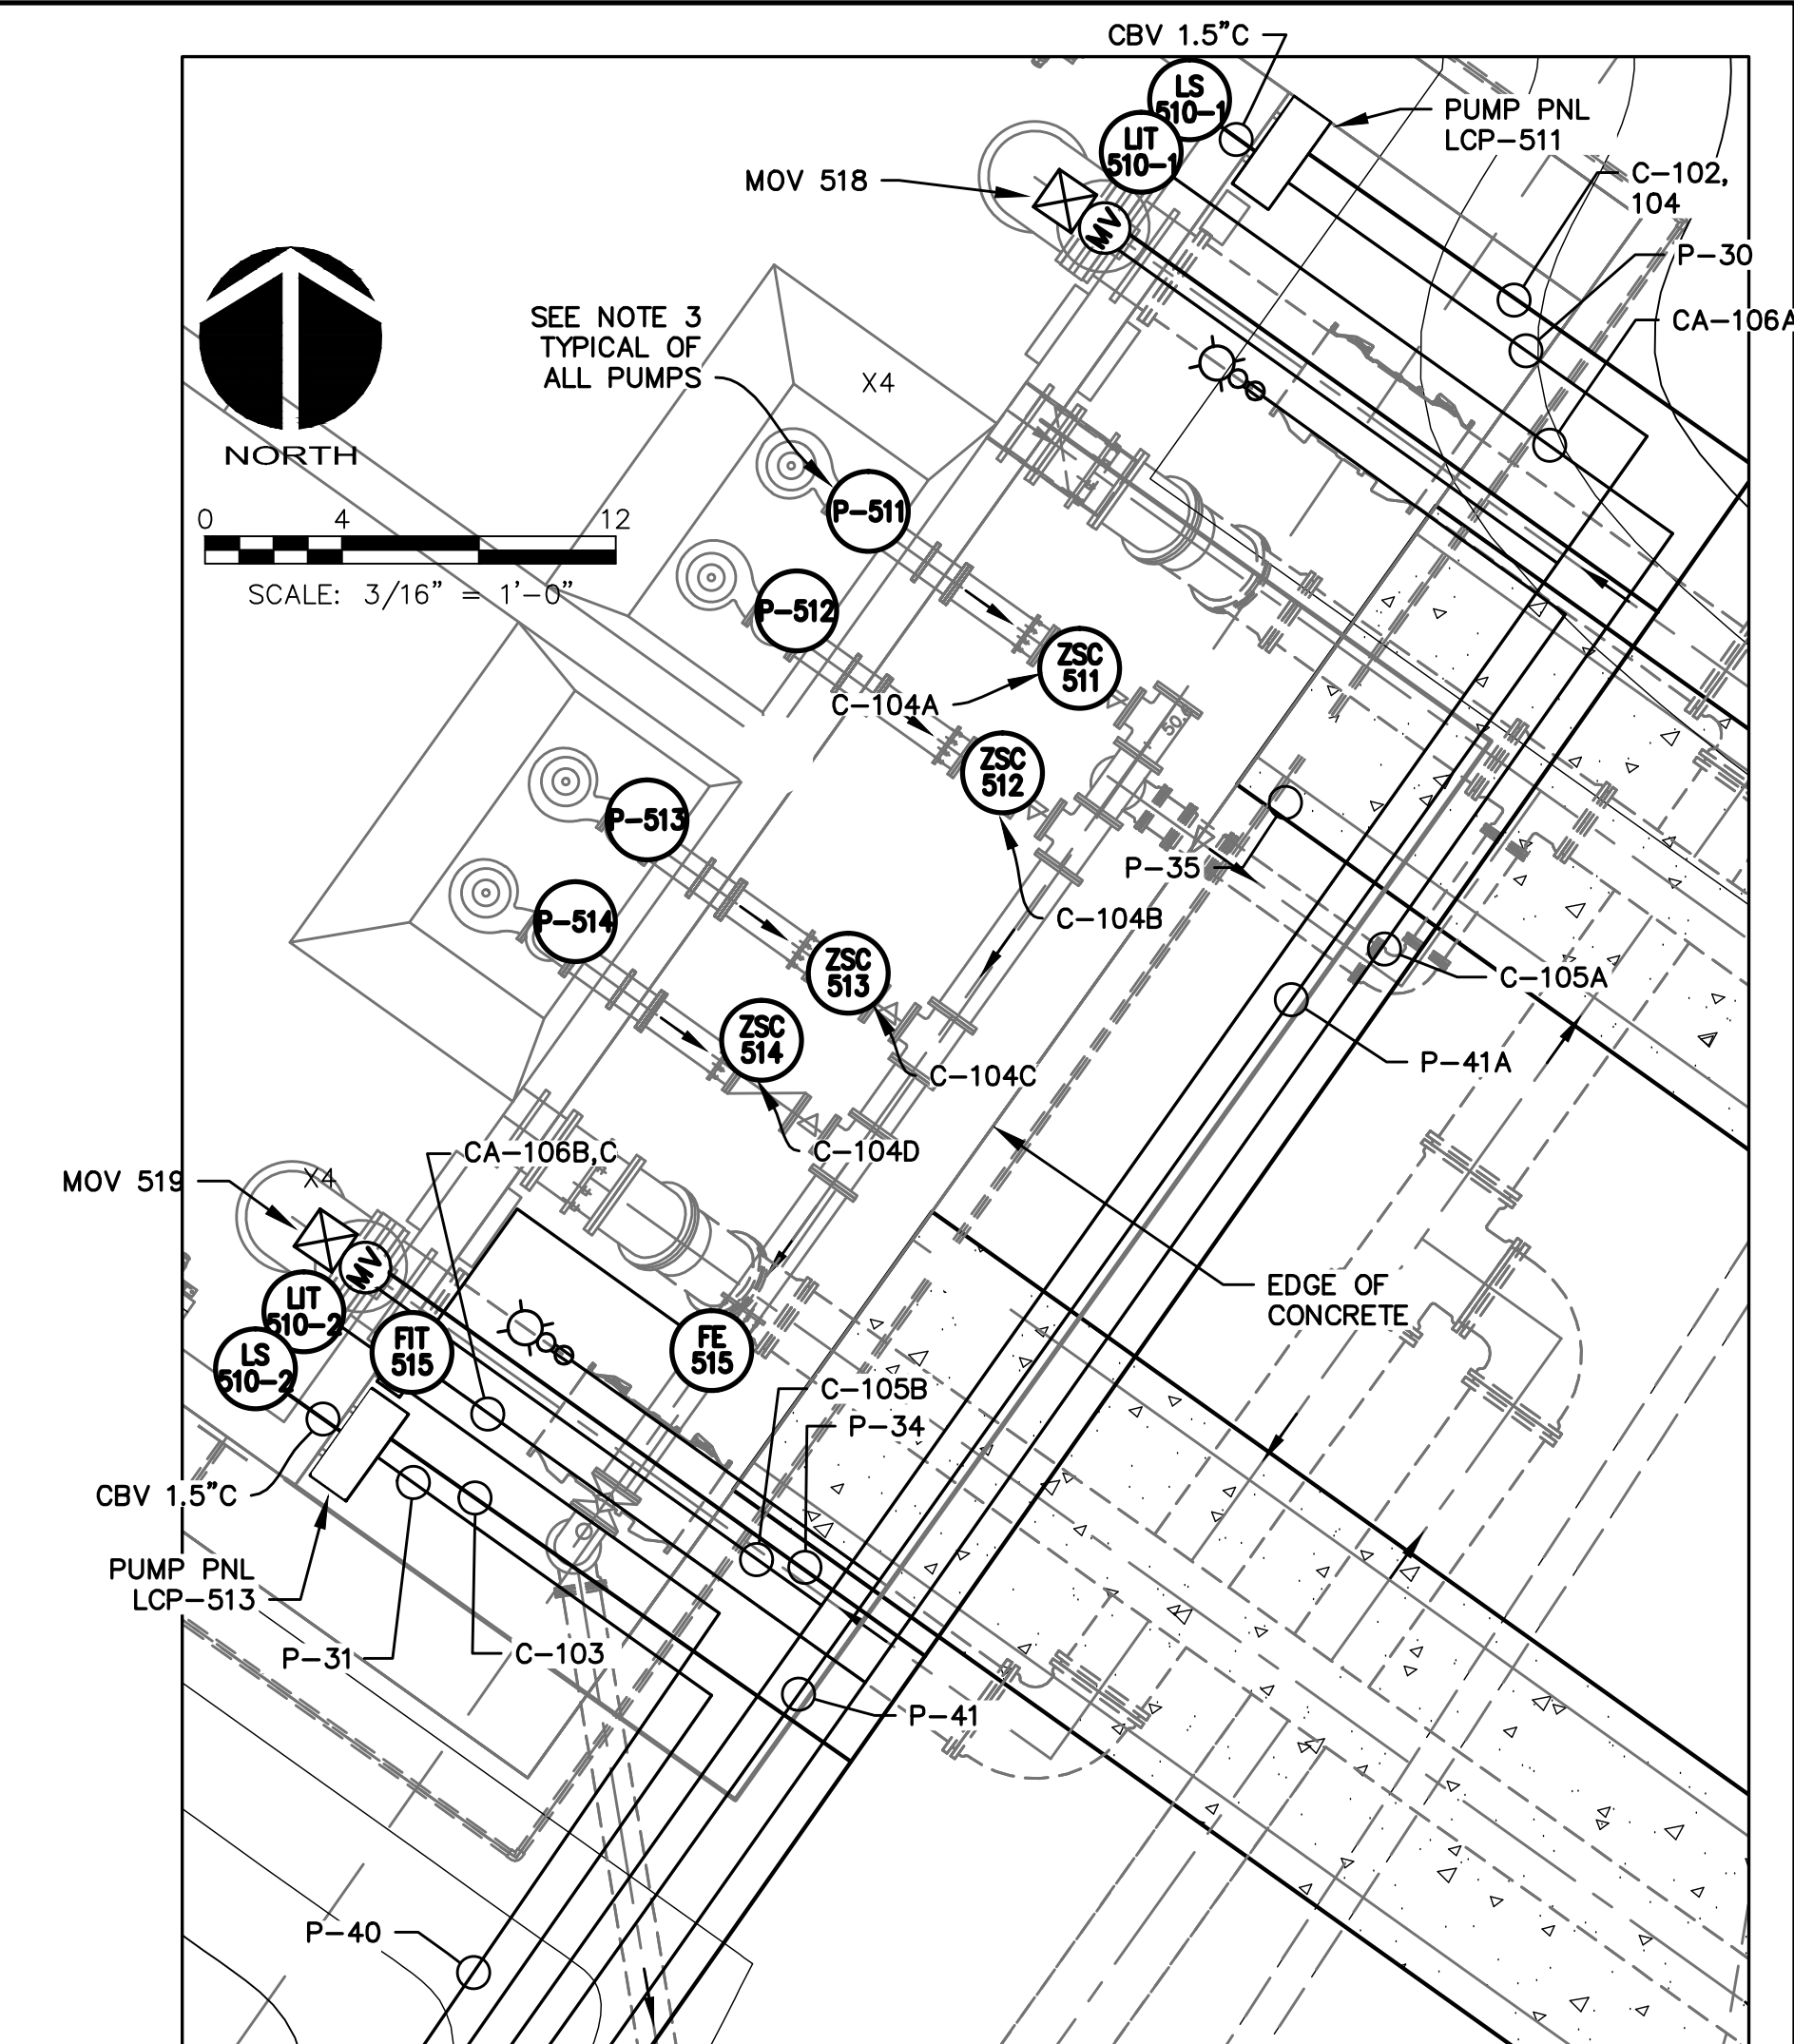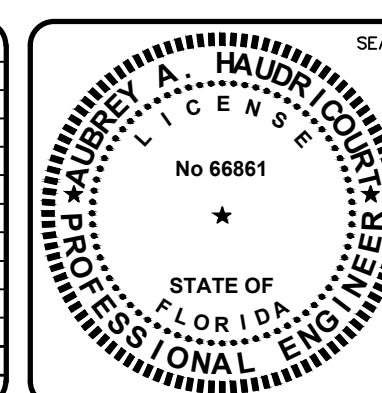[illegible]


SE

 **McKIM & CREED**
1365 Hamlet Avenue
Clearwater, Florida 33756
Phone: (727)442-7196, Fax: (727)461-3821
CA Lic. No. 29588
www.mckimcreed.com





MANATEE COUNTY WTP BIOLOGICAL TREATMENT UNIT
ELECTRICAL EQUALIZATION TANK SITE PLAN

DATE: OCTOBER 2015	SCALE:	DRAWING NUMBER:
MCE PROJ. # 1024-0167	HORIZONTAL:	E-1.5
DRAWN AAH	1" = 20'	
DESIGNED AAH	VERTICAL:	
CHECKED JSL	NA	
PROJ. MGR. PJL		

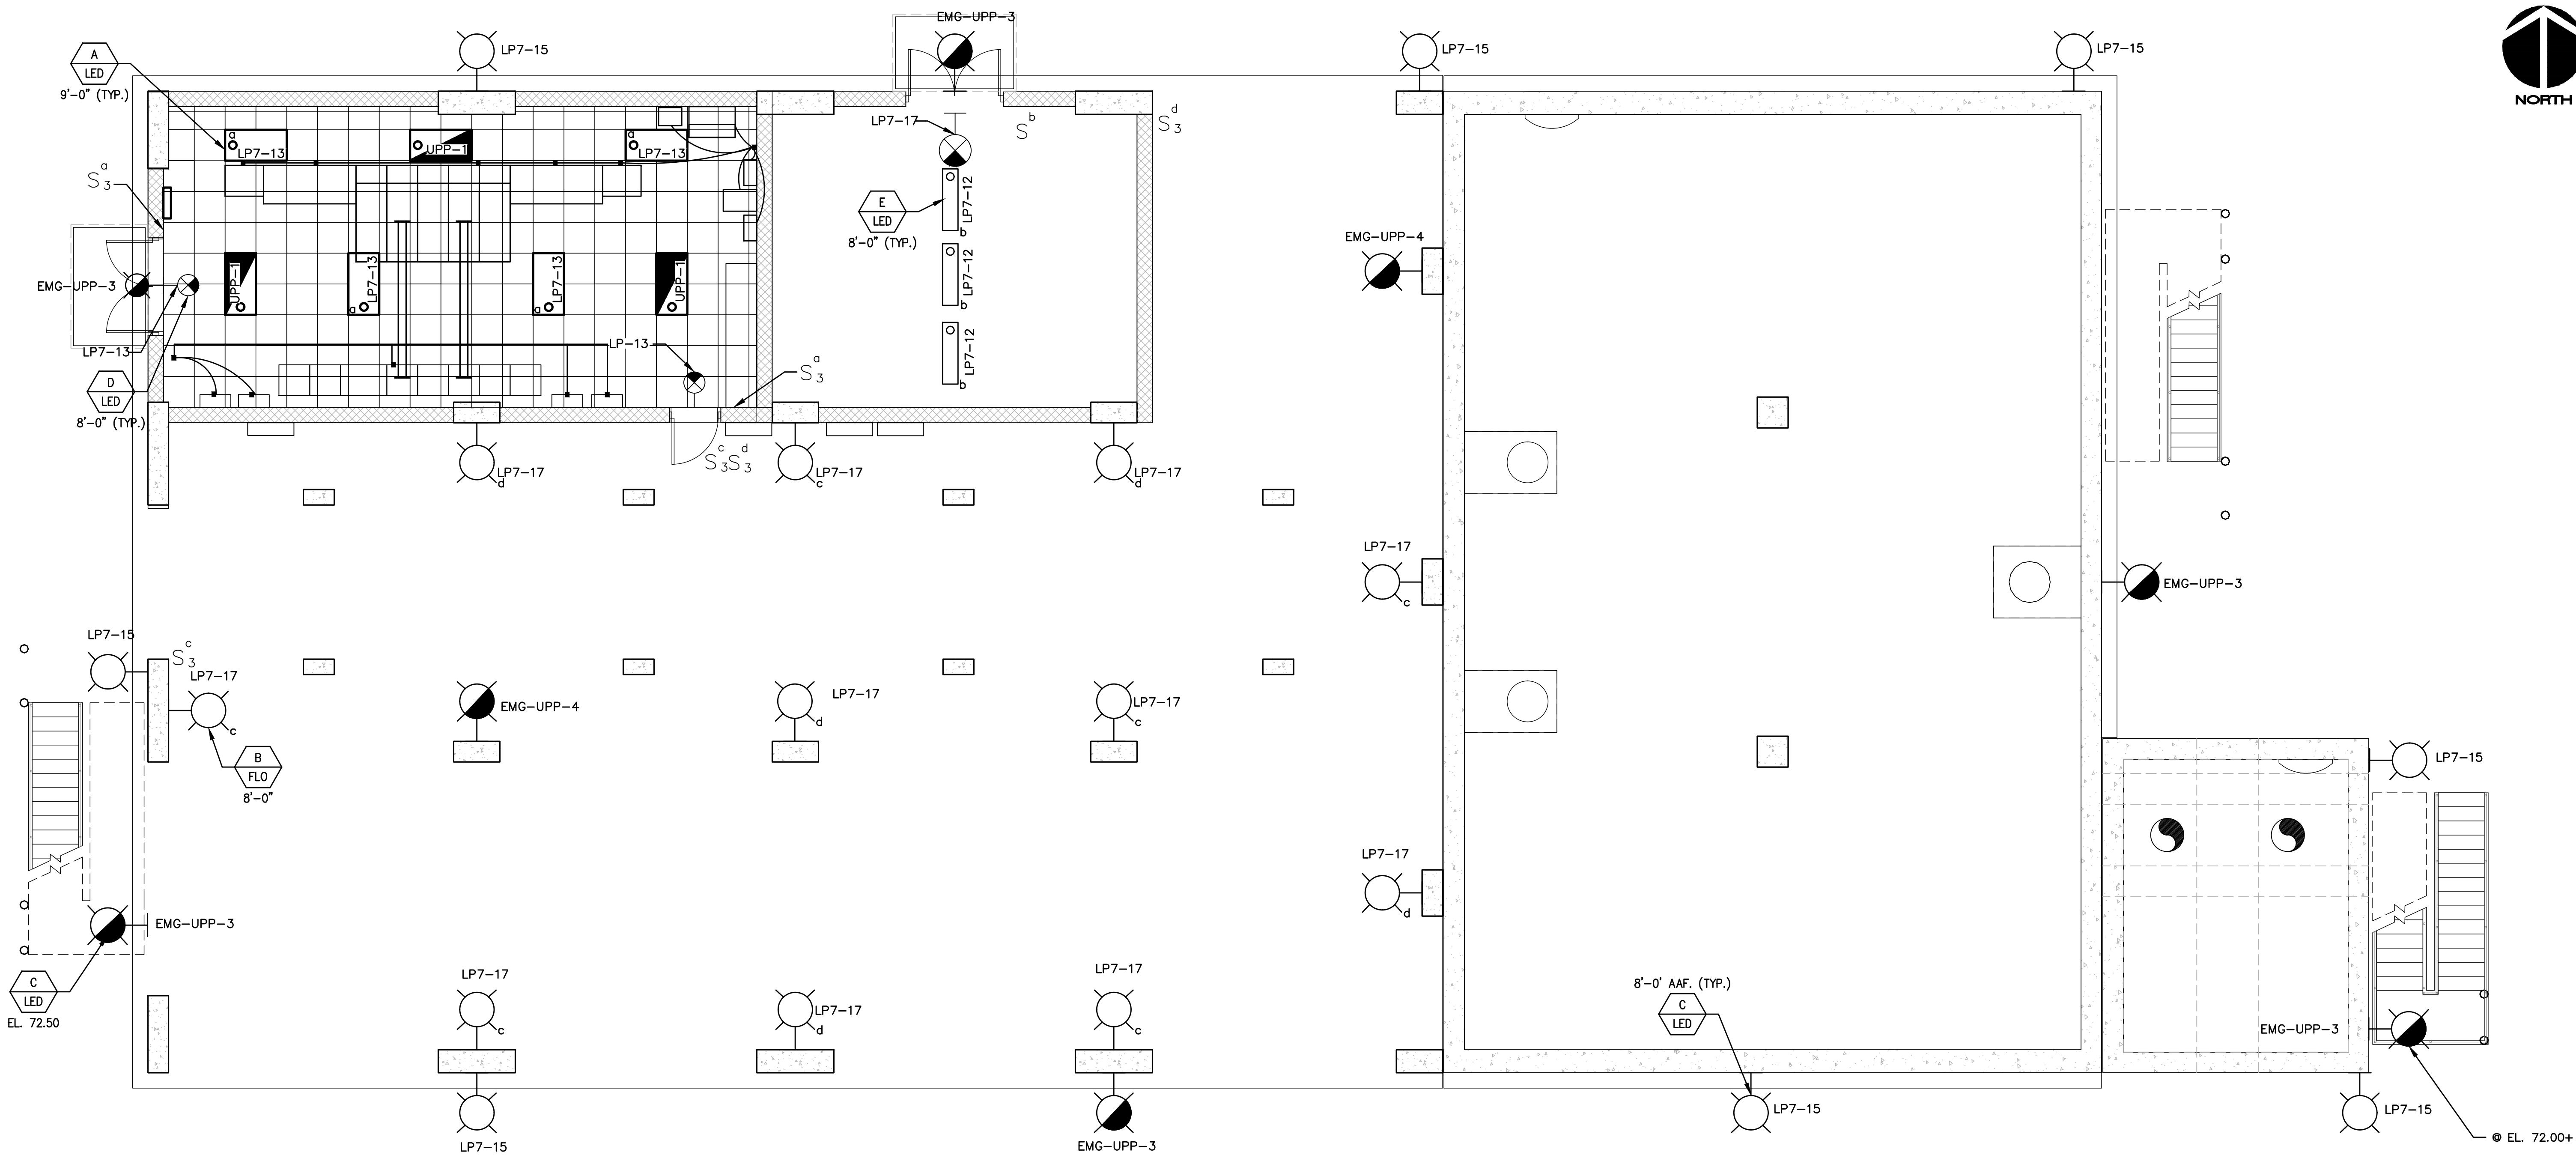

LIGHTING SCHEDULE			
LETTER	DESCRIPTION	LAMPS	REMARKS
A	2'X4' RECESSED HIGH PERFORMANCE TRANSMITTANCE DIFFUSER, ONE PIECE ROLLED CONSTRUCTION, CONCAVE RIBBED REFRACTOR, HINGED DOOR OPTICAL ASSEMBLY FOR INSTALLATION IN T-BAR SYSTEM, SUITABLE FOR DAMP LOCATIONS. POWDER-PAINT WHITE FINISH	LED, L90/60,000HRS, 4000K, 120V. 25W INPUT	LITHONIA LIGHTING SERIES ALL OR APPROVED EQUAL
B	DIECAST ALUMINUM WALL MOUNT WATER PROOF OUTDOOR FIXTURE, W/ ONE PIECE POLYCARBONATE LENS, FULLY GASKETED. DARK BRONZE FINISH.	30-LED, L90/100,000HRS, 700mA, 67W. 4000K, 120V	LITHONIA LIGHTING MOD. TWP OR APPROVED EQUAL
C	DIECAST ALUMINUM WALL MOUNTED FIXTURE W/ DEBIS SCREEN ALLOWING FOR AIR FLOW. COMPLETELY SEAL WEATHERPROOF HOUSING. ACRYLIC LENS TM2 DISTRIBUTION. DARK BRONZE FINISH. PHOTOELECTRIC CELL, BUTTON TYPE.	30-LED, L90/100,000HRS, 700MA, 67W. 4000K, 120V	LITHONIA LIGHTING MOD. CSXW LED OR APPROVED EQUAL

C2	DIECAST ALUMINUM WALL MOUNTED FIXTURE W/ DEBUS SCREEN ALLOWING FOR AIR FLOW. COMPLETELY SEAL WEATHERPROOF HOUSING. ACRYLIC LENS TM2 DISTRIBUTION. DARK BRONZE FINISH.	30-LED, L90/100,000HRS, 1000MA, 104W. 4000K, 120V	LITHONIA LIGHTING MOD. CSXW LED OR APPROVED EQUAL
D	REAR MOUNT EMERGENCY EXIT SIGN. INJECTION-MOLDED, FLAME-RETARDANT, HIGH-IMPACT, THERMOPLASTIC HOUSING. BATTERY BACKUP. TEST SWITCH FOR MANUAL ACTIVATION OF 30-SECOND DIAGNOSTIC TESTING. SELF DIAGNOSTIC TESTING EVERY 30 DAYS.	RED LENS <1W, 120V	LITHONIA LIGHTING MOD. LQM OR APPROVED EQUAL
E	4' PENDANT SUSPENDED LED LUMINAIRE, SUITABLE FOR WET, DAMP AND/OR COLD LOCATIONS. ONE-PIECE FIBERGLASS HOUSING, GASKETED, FROSTED SPREAD DISTRIBUTION LENS.	LED L80/60,000HRS, 39W, 350mA. 4100K	LITHONIA LIGHTING MOD. FEM LED OR APPROVED EQUAL.
F	LED OUTDOOR POLE MOUNTED AREA LIGHT. EPA 1.2sqft. fixture TO MATCH EXISTING SHAPE AND COLOR. TYPE 3 DISTRIBUTION. PROVIDE POLE AND BASE TO MATCH EXISTING. 140MPH WIND LOAD.	LED BULBS L90/>80,000HRS. 109WATTS, 530mA, 3000K	LITHONIA LIGHTING MOD. KADT LED OR APPROVED EQUAL.

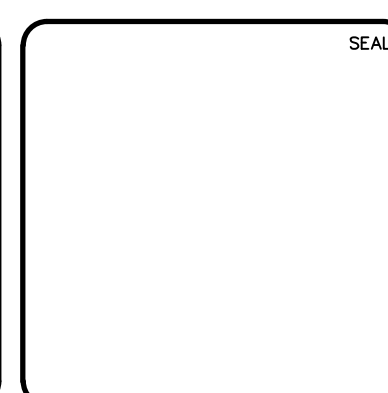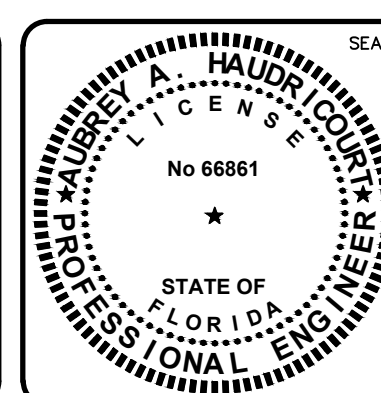[illegible]


MANATEE COUNTY
WTP BIOLOGICAL TREATMENT UNIT

BUILDING LIGHTING PLAN,
FIRST FLOOR (EL. 73.83)

DATE: OCTOBER 2015		DRAWING NUMBER	
MCE PROJ. # 1024-0167		SCALE	
DRAWN AAH		HORIZONTAL:	
DESIGNED AAH		AS SHOWN	
CHECKED JSL		VERTICAL:	
PROJ. MGR. PJL		NA	
STATUS:		REVISION	


$$3/16" = 1' - 0"$$

A circular professional engineer seal for Aubrey A. Haudrourt. The outer ring contains the text "AUBREY A. HAUDROUT" at the top and "PROFESSIONAL ENGINEER" at the bottom, separated by stars. Inside the ring, the word "LICENSE" is at the top and "STATE OF FLORIDA" is at the bottom. In the center, the license number "No 66861" is displayed above a five-pointed star.

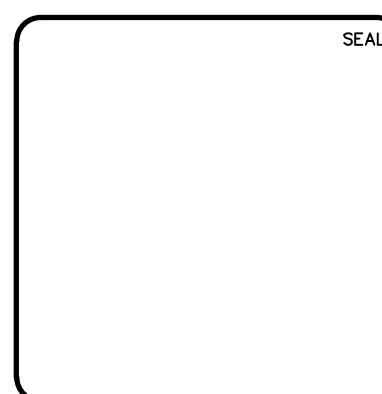

1365 Hamlet Avenue
Clearwater, Florida 33756
Phone: (727)442-7196, Fax: (727)461-3827
CA Lic. No. 29588



DATE:	OCTOBER 2015
MCE PROJ. #	1024-0167
DRAWN	AAH
DESIGNED	AAH
CHECKED	JSJ
PROJ. MGR.	PJL

SCALE
HORIZONTAL:
AS SHOWN
VERTICAL:
NA

DRAWING NUMBER


E-2.6

STATUS:	REVISION
ISSUE FOR BID	






NOTES:

1. PROVIDE LIGHTNING PROTECTION SYSTEM PER SPECIFICATIONS
2. BOND LIGHTNING PROTECTION SYSTEM TO BUILDING GROUND GRID.
3. INSTALL AERIAL LEADS AND DOWN LEADS IN PVC CONDUIT.

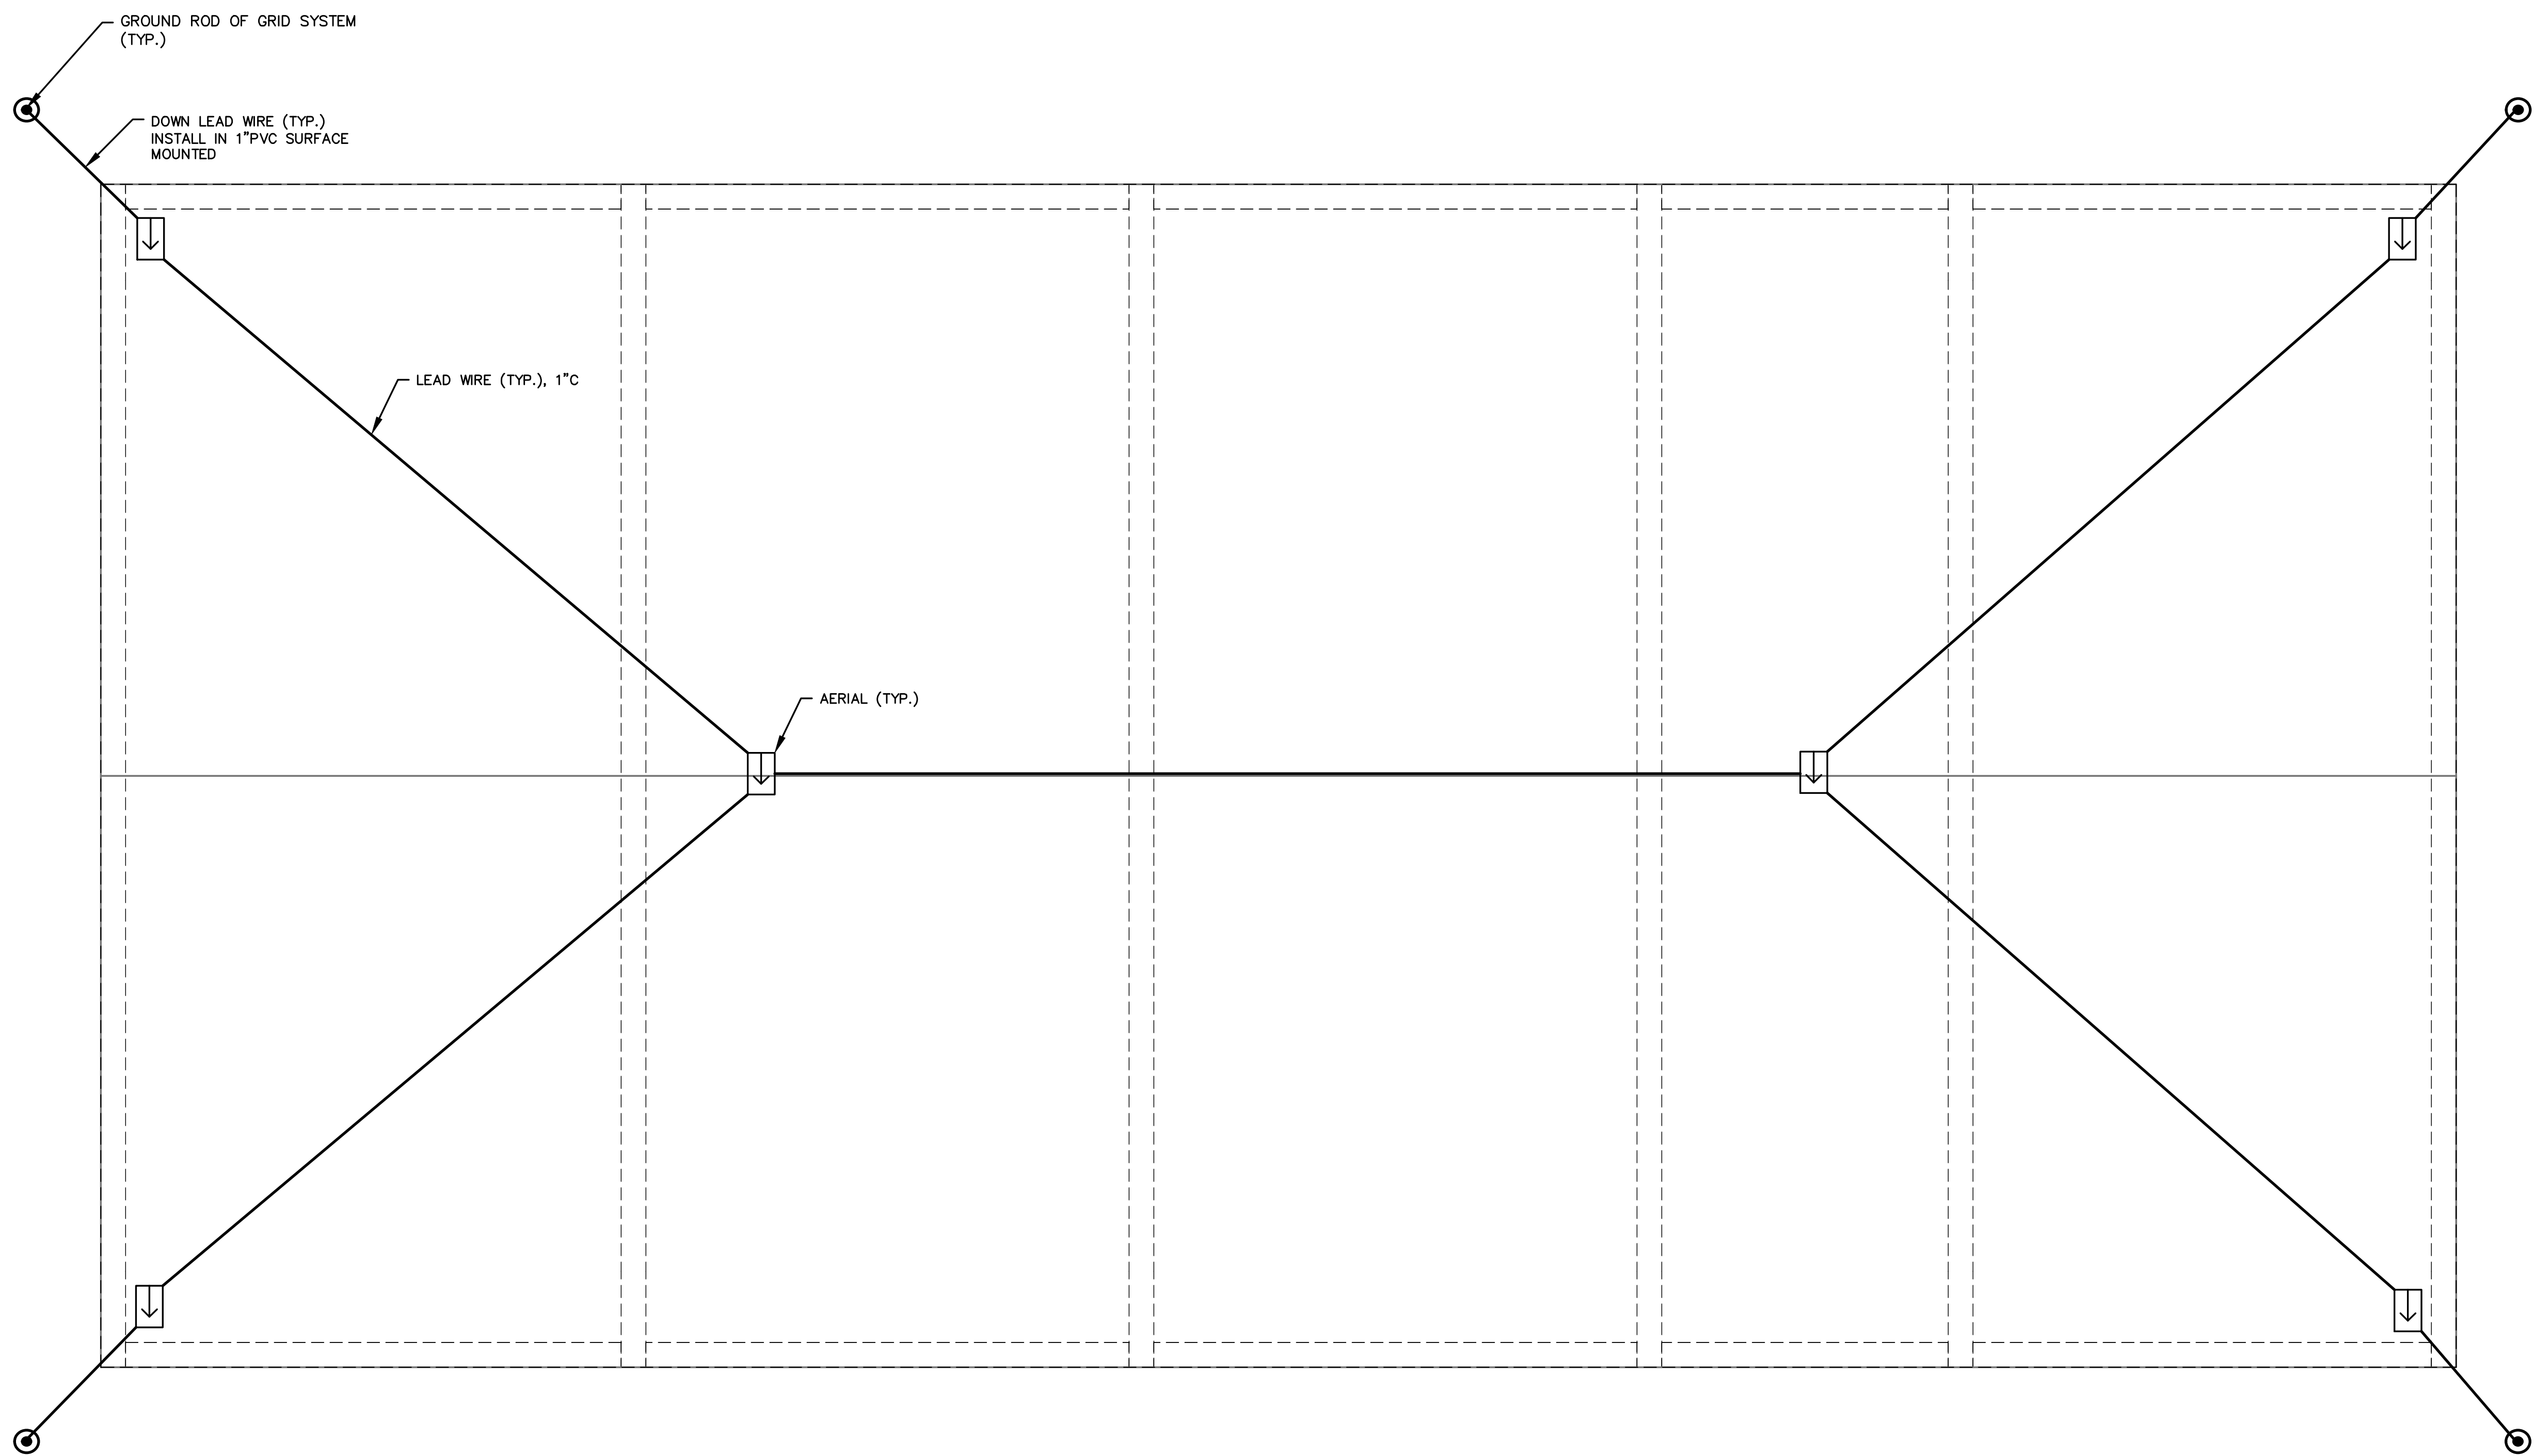

LIGHTNING SYSTEM PLAN

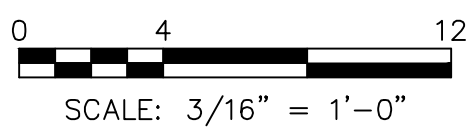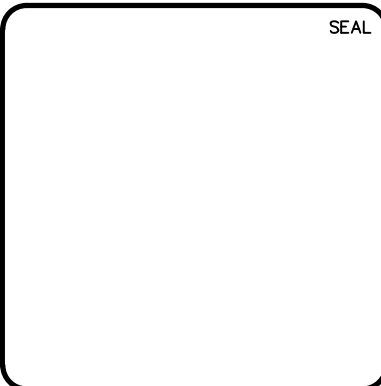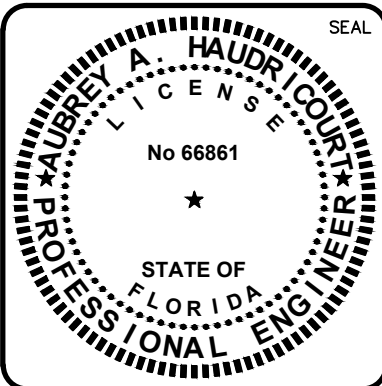[illegible]

MCKIM & CREED
1365 Hamlet Avenue
Clearwater, Florida 33756
Phone: (727)442-7196, Fax: (727)461-3827
CA Lic. No. 29588
www.mckimcreed.com



MANATEE COUNTY
WTP BIOLOGICAL TREATMENT UNIT

LIGHTNING PLAN,
ROOF (EL. 105.33)

DATE:	OCTOBER 2015
MCE PROJ. #	1024-0167
DRAWN	AAH
DESIGNED	AAH
CHECKED	JSL
PROJ. MGR.	PJL


 
STATUS

SCALE
HORIZONTAL:
AS SHOWN
VERTICAL:
NA

RAWING NUMBER
E-2.7

REVISION




ISSUE FOR BID

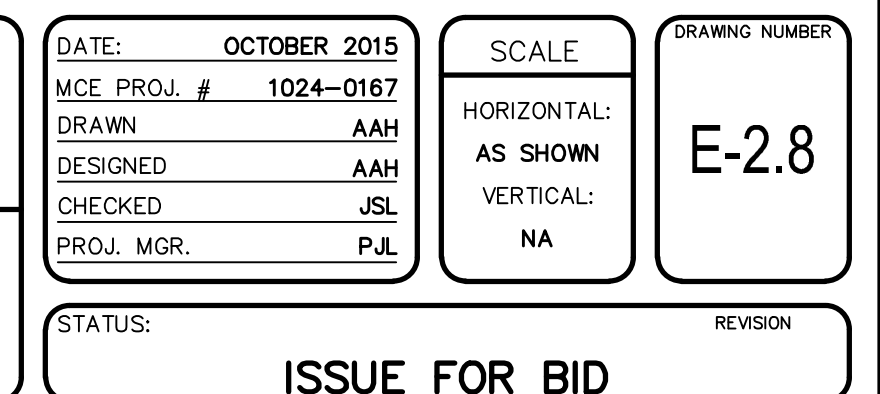



NOTES:

1. REFER TO I-SHEETS FOR MORE INFORMATION
2. PROVIDE TERMINAL BLOCKS IN ALL CABINETS WITH 25% SPARE.
3. PROVIDE 20% SPARE WIRE BETWEEN TERMINAL CABINETS AND PLC7. LAND SPARES ON TERMINAL BLOCKS IN BOTH CABINETS
4. REFER TO SITE PLANS FOR CONTROL PULL BOX (CPB) LOCATIONS.
5. PROVIDE GROUND WIRES AS REQUIRED FOR ALL INSTRUMENTATION.

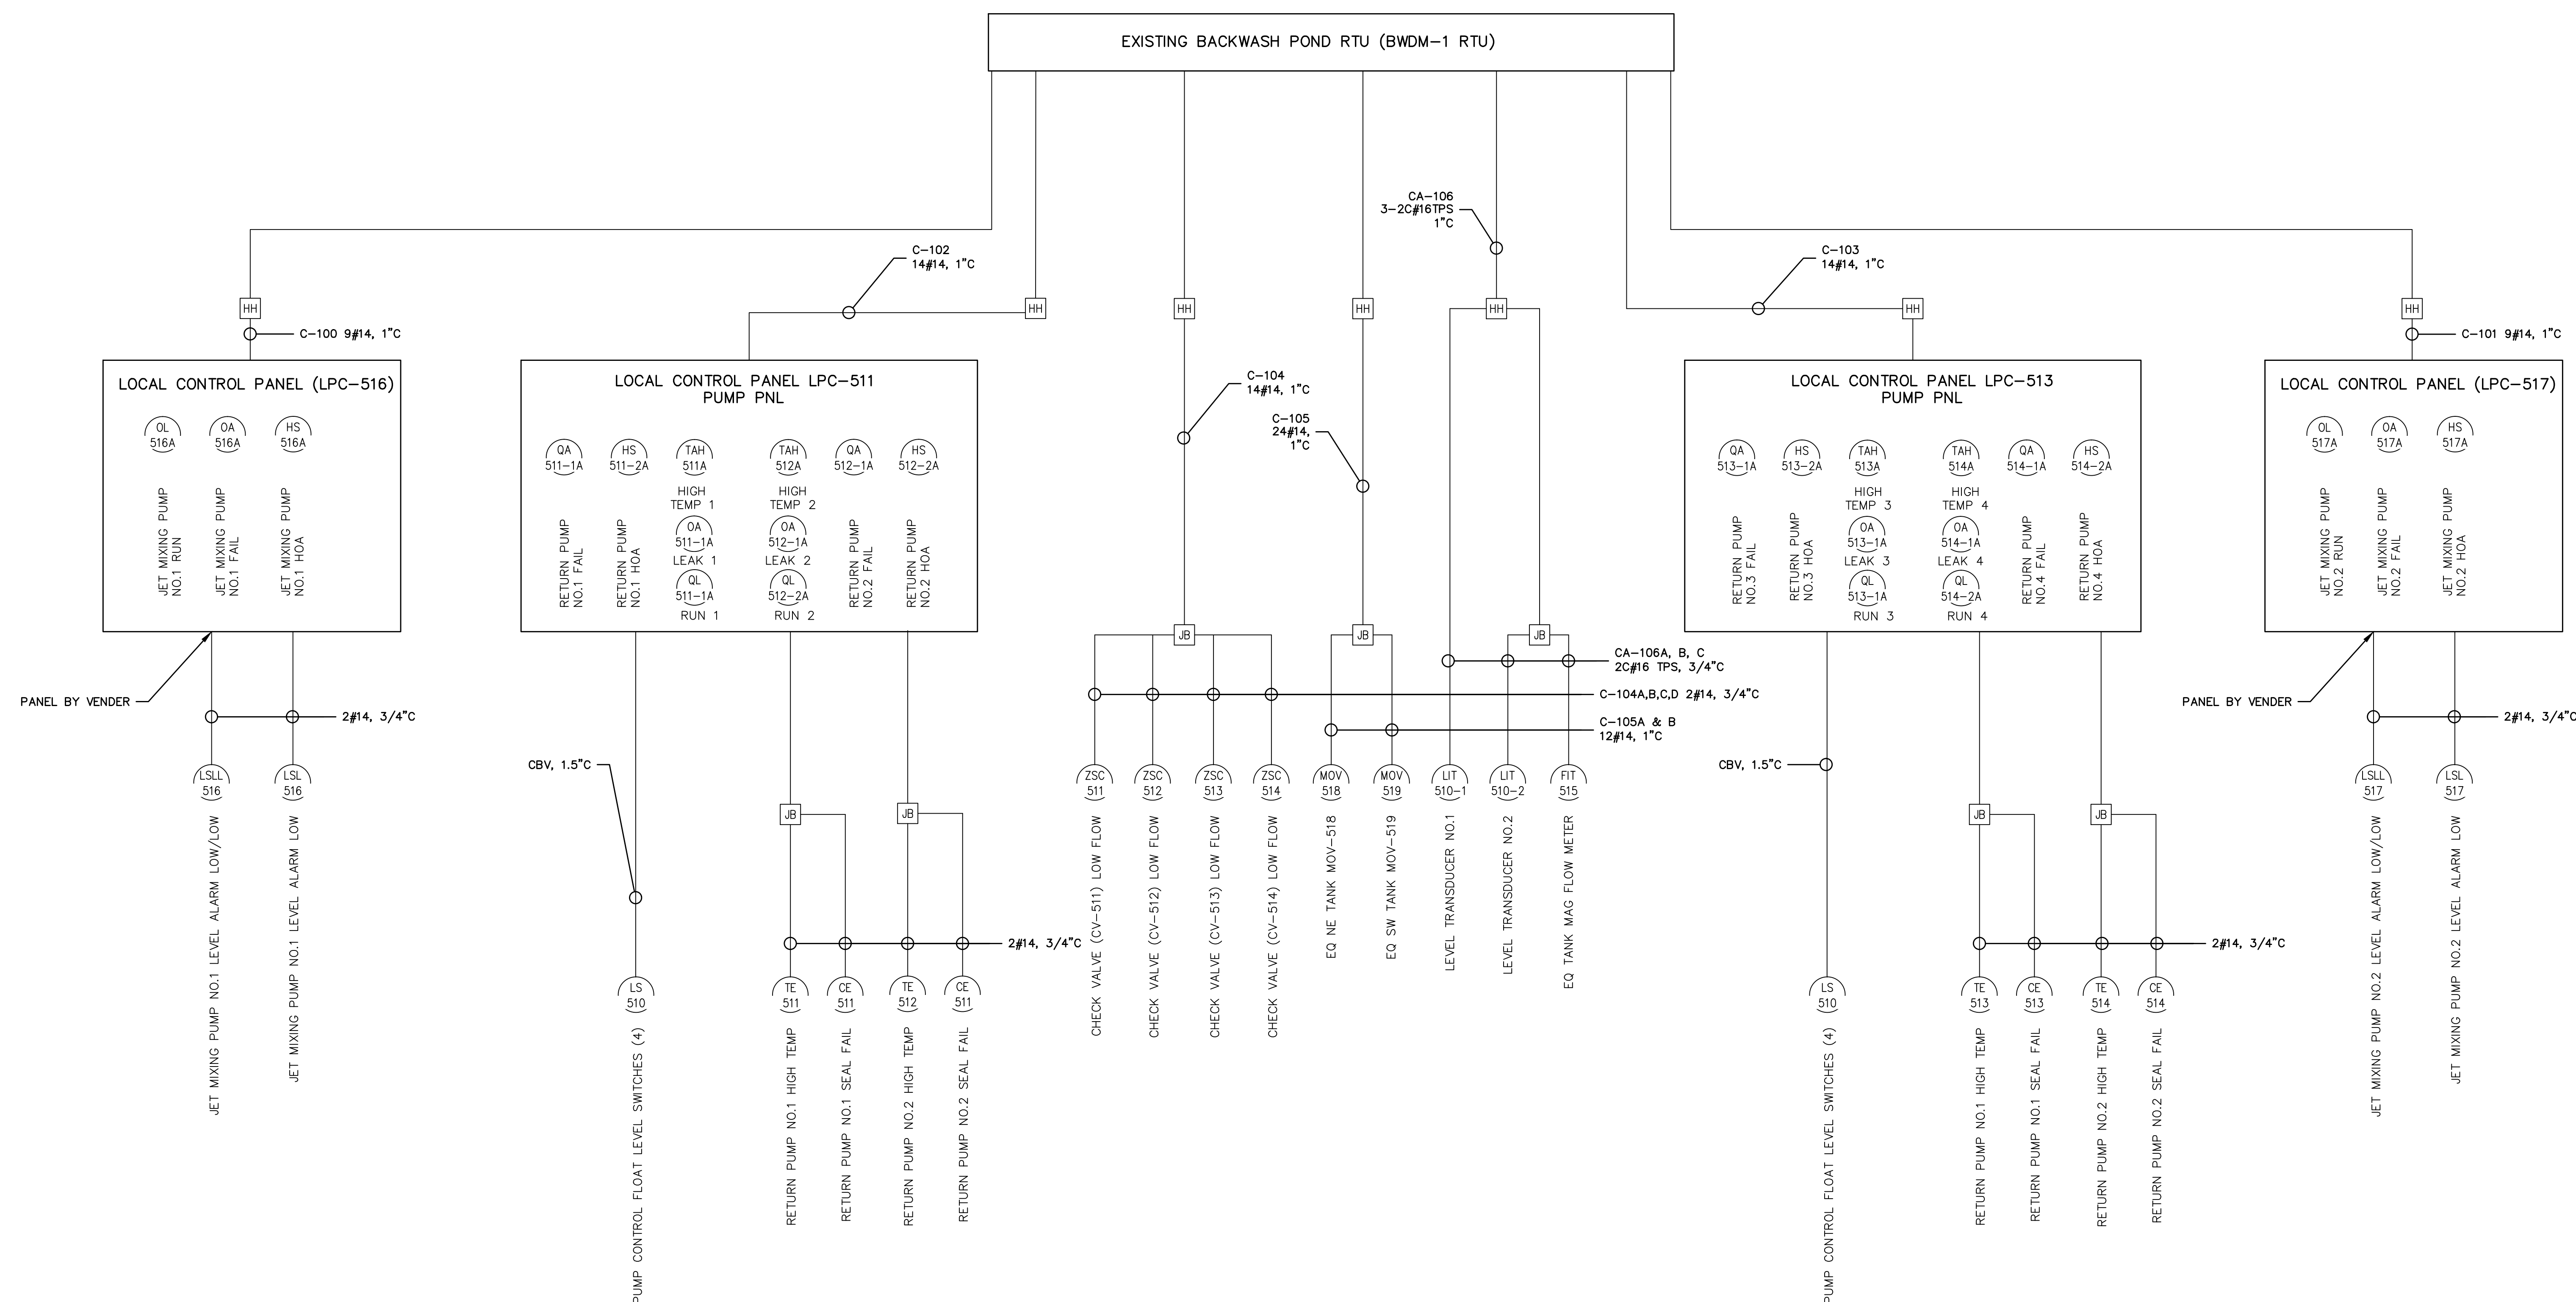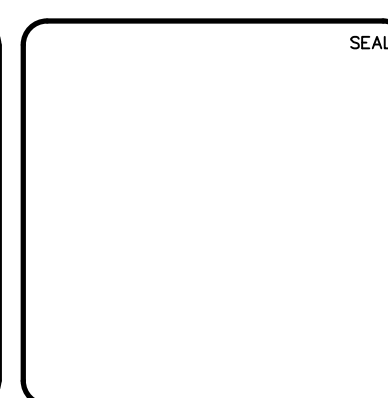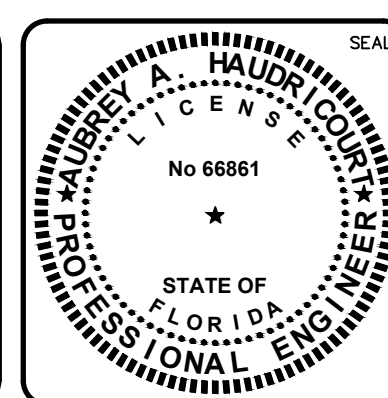[illegible]

MCKIM & CREED

1365 Hamlet Avenue
Clearwater, Florida 33756
Phone: (727)442-7196, Fax: (727)461-3827
CA Lic. No. 29588

www.mckimcreed.com



MANATEE COUNTY
WTP BIOLOGICAL TREATMENT UNIT

INTERCONNECT DIAGRAM II

DATE:	OCTOBER 2015	SCALE	DRAWING NUMBER
MCE PROJ. #	1024-0167		
DRAWN	LLS	HORIZONTAL:	E-3.1
DESIGNED	AAH		
CHECKED	JSL	VERTICAL:	
PROJ. MGR.	PJL		

STATUS:

REVISION

ISSUE FOR BID

CKT NO.	TRIP AMPS	DESCRIPTION OF LOAD	LOAD KVA	AMPS	POLES	KVA PER PHASE			POLES	AMPS	LOAD KVA	DESCRIPTION OF LOAD	TRIP AMPS	CKT NO.						
						A	B	C												
1	30	EMG-UPS	2.1	20.2	2	2.1			1			SPARE	20	2						
			2.1				5.1													
5	20	SPARE			1			3.0	2	28.8	3	UPS-UPP	40	4						
											3									
7	20 GFI	RECEPTICALS 1st FLOOR PROCESS	1.8	15.0	1	3.6			1	15.0	1.8	RECEPTICALS 1st FLOOR PROCESS	20 GFI	8						
9	20 GFI	RECEPTICALS 1 & 2 FLOOR PROCESS	1.8	15.0	1		3.6		1	15.0	1.8	RECEPTICALS 3RD FLOOR PROCESS	20 GFI	10						
11	20 GFI	RECEPTICALS 3RD FLOOR PROCESS	1.8	15.0	1			1.9	1	0.7	0.08	LIGHTING STORAGE RM.	20	12						
13	20	LIGHTING ELEC RM.	0.4	3.3	1	0.4			1	0.0	0	LIGHTING 1ST. FL. PROCESS EL. 73.85	20	14						
15	20	LIGHTING EXT. EL. 73.83	0.832	6.9	1		0.8		1	0.0	0	SPARE	20	16						
17	20	LIGHTING 1ST. FL. PROCESS EL. 73.83	1.25	10.4	1			1.5	1	1.7	0.208	LIGHTING EXT. EL. 91.33	20	18						
19	20	SPARE	0	0.0	1	0.1			1	0.5	0.06	FIT-203	20	20						
21	20	SPARE	0	0.0	1		0.0		1	0.0	0	SPARE	20	22						
23	20	SPARE	0	0.0	1			0.5	1	4.2	0.5	EF-1	20	24						
25	20	FIRE ALARM CONTROL PANEL (FACP)	0.5	4.2	1	0.5			1			SPARE	20	26						
27	20	SPARE	0	0.0	2		0.0		1			SPARE	20	28						
								0.5	1	4.2	0.5	LIGHTING EL. 100.33	20	30						
31	20	LIGHTING EL. 100.33	0.5	4.2	1	0.5			1					32						
33					1		0.0		1					34						
35					1			0.0	1					36						
37					1	0.0			1					38						
39					1		0.0		1					40						
41					1			0.0	1					42						
PANEL LP-7 LOCATION BIO FILTER E-ROOM BUILDING NOTES:			TOTAL KVA			7.2	9.5	7.3	SERVICE CHARACTERISTICS											
			GRAND CONNECTED TOTAL KVA			24.0														
					VOLTS: 208Y/120												A MLO			
					PHASE: 3												150	A MCB		
					WIRE: 4															
										10k MIN AIC SYMM, FULLY RATED ASSEMBLY										

PANELBOARD SCHEDULE LP-7

CKT NO.	TRIP AMPS	DESCRIPTION OF LOAD	LOAD KVA	AMPS	POLES	KVA PER PHASE		POLES	AMPS	LOAD KVA	DESCRIPTION OF LOAD	TRIP AMPS	CKT NO.
						A	B						
1	20	PLC	0.592	4.9	1	1.2		1	5.3	0.63	BTU CONTROL CONSOLE RIO-1	20	2
3	20	BTU CONTROL CONSOLE RIO-2	0.63	5.3	1		1.3	1	5.3	0.63	BTU CONTROL CONSOLE RIO-3	20	4
5	20	BTU CONTROL CONSOLE RIO-4	0.63	5.3	1	1.3		1	5.3	0.63	BTU CONTROL CONSOLE RIO-5	20	6
7	20	BTU CONTROL CONSOLE RIO-6	0.63	5.3	1		0.6	1				20	8
9	20				1	0.0		1				20	10
11	20				1		0.0	1				20	12
13	20				1	0.0		1				20	14
15	20				1		0.0	1				20	16
17	20				1	0.0		1				20	18
PANEL UPS-UPP LOCATION BIO FILTER E-ROOM BUILDING NOTES: 6kVA			TOTAL KVA			2.5	1.9	SERVICE CHARACTERISTICS					
			GRAND CONNECTED TOTAL KVA			4.4							
			VOLTS: 240/120						A MLO				
			PHASE: 1						40		A MCB		
			WIRE: 3										
10k MIN AIC SYMM, FULLY RATED ASSEMBLY													

PANELBOARD SCHEDULE UPS-UPP

CKT NO.	TRIP AMPS	DESCRIPTION OF LOAD	LOAD KVA	AMPS	POLES	KVA PER PHASE		POLES	AMPS	LOAD KVA	DESCRIPTION OF LOAD	TRIP AMPS	CKT NO.
						A	B						
1	20	CONTROL PANEL NO. 1 BW POND	1.2	10.0	1	1.8		1	5.0	0.6	EQUALIZATION TANK MAGMETER FIT-S15	20	2
3	20	SUMP PUMP (1) BW POND	0.4	3.3	1		1.0	2	5.0	0.6	LIGHTING BW POND	20	4
5	20	FLOWMETER TRANSMITTER BW POND	0.1	0.8	1	0.7				0.6			
7	20	RECEPTICALS EQ TANK	0.18	1.5	1		0.6	1	3.8	0.45	LIGHTING EQUALIZATION TANK AREA	20	8
9					1	0.0		1					10
PANEL MPZ LOCATION BACKWASH POND BUILDING NOTES:			TOTAL KVA			2.5	1.6	SERVICE CHARACTERISTICS					
			GRAND CONNECTED TOTAL KVA			4.1							
			VOLTS: 240/120						A MLO				
			PHASE: 1						40 A MCB				
			WIRE: 3										
10k MIN AIC SYMM, FULLY RATED ASSEMBLY													

PANELBOARD SCHEDULE MPZ (EXISTING)

CKT NO	TRIP AMPS	DESCRIPTION OF LOAD	LOAD KVA	AMPS	POLES	KVA PER PHASE		POLES	AMPS	LOAD KVA	DESCRIPTION OF LOAD	TRIP AMPS	CKT NO
						A	B						
1	20	EMERGENCY LIGHTING E-ROOM	0.75	6.3	1	1.0		1	2.1	0.25	EMERGENCY LIGHTING STORAGE ROOM	20	2
3	20	EMERGENCY LIGHTING EXT EL 73.83	0.624	5.2	1		0.8	1	1.7	0.208	EMERGENCY LIGHTING PROCESS EL 73.83	20	4
5	20	EMERGENCY LIGHTING EXT EL.91.33	0.416	3.5	1	0.6		1	1.7	0.208	EMERGENCY LIGHTING EXT EL 100.33	20	6
7	20	EMERGENCY LIGHTING PROCESS EL 100.33	0.208	1.7	1		0.2	1				20	8
9	20				1	0.0		1				20	10
11	20				1		0.0	1				20	12
13	20				1	0.0		1				20	14
15	20				1		0.0	1				20	16
17	20				1	0.0		1				20	18
PANEL EMG-UPP LOCATION BIO FILTER E-ROOM BUILDING NOTES: 4.2kVA W/ NORMALLY OFF BUS			TOTAL KVA			1.6	1.0	SERVICE CHARACTERISTICS					
			GRAND CONNECTED TOTAL KVA			2.7							
			VOLTS: 240/120						A MLO				
			PHASE: 1						30		A MCB		
			WIRE: 3										
10k MIN AIC SYMM, FULLY RATED ASSEMBLY													

PANELBOARD SCHEDULE EMG-UPP

CKT NO.	TRIP AMPS	DESCRIPTION OF LOAD	LOAD KVA	AMPS	POLES	KVA PER PHASE		POLES	AMPS	LOAD KVA	DESCRIPTION OF LOAD	TRIP AMPS	CKT NO.
						A	B						
1	40	GRINDER PUMP STATION #2	3	25.0	2	3.4		2	3.3	0.4	AIR HANDLER IDU-1	20	2
			3				3.4			0.4			
5	20	AIR HANDLER IDU-2	0.4	3.3	2	0.8		2	3.3	0.4	AIR HANDLER IDU-3	20	6
			0.4				0.8			0.4			
9	20				1	0.0		1				20	10
11	20				1		0.0	1				20	12
13	20				1	0.0		1				20	14
15	20				1		0.0	1				20	16
17	20				1	0.0		1				20	18
PANEL MPC-1 LOCATION BTU E-ROOM BUILDING NOTES:			TOTAL KVA		4.2	4.2	SERVICE CHARACTERISTICS						
			GRAND CONNECTED TOTAL KVA		8.4								
			VOLTS: 240/120						A MLO				
			PHASE: 1						50 A MCB				
			WIRE: 3										
10k MIN AIC SYMM, FULLY RATED ASSEMBLY													

PANELBOARD SCHEDULE MPC-1

CKT NO.	TRIP AMPS	DESCRIPTION OF LOAD	LOAD KVA	AMPS	POLES	KVA PER PHASE			POLES	AMPS	LOAD KVA	DESCRIPTION OF LOAD	TRIP AMPS	CKT NO.
						A	B	C						
1	70	RESIDUALS PUMP #1A	9.4 9.4 9.4	33.9	3	9.4			3			T.V.S.S.	30	2
7	70	RESIDUALS PUMP #1B	9.4 9.4 9.4	33.9	3	9.7			3	1.1	0.3 0.3 0.3	MOTORIZED VALVE MOV #518 EQUALIZATION TANK SUPPLY NORTH	20	8
13	40	MPZ	2.5 1.6	8.5	2	2.8			3	1.1	0.3 0.3 0.3	MOTORIZED VALVE MOV #519 EQUALIZATION TANK SUPPLY SOUTH	20	14
17		SPARE			1			0.3						
19	70	JET MIXING PUMP NO. 1	3.33 3.33 3.33	12.0	3	3.3			3			SPARE	20	20
25	70	JET MIXING PUMP NO. 2	3.33 3.33 3.33	12.0	3	3.3			3			SPARE	20	26
PANEL BW LOCATION BACKWASH POND BUILDING			TOTAL KVA			28.6	27.7	26.1	SERVICE CHARACTERISTICS VOLTS: 480Y/277 PHASE: 3 WIRE: 4 10k MIN AIC SYMM, FULLY RATED ASSEMBLY					
			GRAND CONNECTED TOTAL KVA			82.3								
NOTES: RESIDUAL PUMPS ARE DUTY/STANDBY , MAXIMUM LOAD IS ONE PUMP EACH TANK.														


CKT NO.	TRIP AMPS	DESCRIPTION OF LOAD	LOAD KVA	AMPS	POLES	KVA PER PHASE			POLES	AMPS	LOAD KVA	DESCRIPTION OF LOAD	TRIP AMPS	CKT NO.
						A	B	C						
1	20	MOTORIZED VALVE MOV-201 WEST BTU RAW WATER	0.3	1.1	3	0.3			3			SPARE	20	2
			0.3				0.3							
			0.3					0.3						
7	20	MOTORIZED VALVE MOV-205 COMMON FILTER DRAIN	0.3	1.1	3	0.6			3	1.1	0.3	MOTORIZED VALVE MOV-211-1 FILTER EFFLUENT NO.1	20	8
			0.3				0.6				0.3			
			0.3					0.6			0.3			
13	20	MOTORIZED VALVE MOV-211-2 BACKWASH SUPPLY NO.1	0.3	1.1	3	0.6			3	1.1	0.3	MOTORIZED VALVE MOV-211-3 BACKWASH TO WASTE NO.1	20	14
			0.3				0.6				0.3			
			0.3					0.6			0.3			
19	20	MOTORIZED VALVE MOV-211-4 FILTER TO WASTE NO.1	0.3	1.1	3	0.6			3	1.1	0.3	MOTORIZED VALVE MOV-211-5 AIR SCOUR SUPPLY NO.1	20	20
			0.3				0.6				0.3			
			0.3					0.6			0.3			
25	20	MOTORIZED VALVE MOV-221-1 FILTER EFFLUENT NO.2	0.3	1.1	3	0.6			3	1.1	0.3	MOTORIZED VALVE MOV-221-2 BACKWASH SUPPLY NO.2	20	26
			0.3				0.6				0.3			
			0.3					0.6			0.3			
31	20	MOTORIZED VALVE MOV-221-3 BACKWASH TO WASTE NO.2	0.3	1.1	3	0.6			3	1.1	0.3	MOTORIZED VALVE MOV-221-4 FILTER TO WASTE NO.2	20	32
			0.3				0.6				0.3			
			0.3					0.6			0.3			
37	20	MOTORIZED VALVE MOV-221-5 AIR SCOUR SUPPLY NO.2	0.3	1.1	3	0.6			3	1.1	0.3	MOTORIZED VALVE MOV-231-1 FILTER EFFLUENT NO.3	20	38
			0.3				0.6				0.3			
			0.3					0.6			0.3			
PANEL PP-7A LOCATION BIO FILTER E-ROOM BUILDING NOTES:			TOTAL KVA			3.9	3.9	3.9	SERVICE CHARACTERISTICS VOLTS: 480Y/277 PHASE: 3 WIRE: 4 10k MIN AIC SYMM, FULLY RATED ASSEMBLY					
			GRAND CONNECTED TOTAL KVA			11.7								
_____ 200 A MLO _____ A MCB														

PANELBOARD SCHEDULE PP-7A

CKT NO.	TRIP AMPS	DESCRIPTION OF LOAD	LOAD KVA	AMPS	POLES	KVA PER PHASE			POLES	AMPS	LOAD KVA	DESCRIPTION OF LOAD	TRIP AMPS	CKT NO.
						A	B	C						
1	20	MOTORIZED VALVE MOV-202 EAST BTU RAW WATER	0.3	1.1	3	0.6			3	1.1	0.3	MOTORIZED VALVE MOV-204 CLEARWELL FILL	20	2
			0.3				0.6				0.3			
			0.3					0.6			0.3			
7	20	MOTORIZED VALVE MOV-251-1 FILTER EFFLUENT NO.5	0.3	1.1	3	0.6			3	1.1	0.3	MOTORIZED VALVE MOV-251-2 BACKWASH SUPPLY NO.5	20	8
			0.3				0.6				0.3			
			0.3					0.6			0.3			
13	20	MOTORIZED VALVE MOV-251-3 BACKWASH TO WASTE NO.5	0.3	1.1	3	0.6			3	1.1	0.3	MOTORIZED VALVE MOV-251-4 FILTER TO WASTE NO.5	20	14
			0.3				0.6				0.3			
			0.3					0.6			0.3			
19	20	MOTORIZED VALVE MOV-251-5 AIR SCOUR SUPPLY NO.5	0.3	1.1	3	0.6			3	1.1	0.3	MOTORIZED VALVE MOV-261-1 FILTER EFFLUENT NO.6	20	20
			0.3				0.6				0.3			
			0.3					0.6			0.3			
25	20	MOTORIZED VALVE MOV-261-2 BACKWASH SUPPLY NO.6	0.3	1.1	3	0.6			3	1.1	0.3	MOTORIZED VALVE MOV-261-3 BACKWASH TO WASTE NO.6	20	26
			0.3				0.6				0.3			
			0.3					0.6			0.3			
31	20	MOTORIZED VALVE MOV-261-4 FILTER TO WASTE NO.6	0.3	1.1	3	0.6			3	1.1	0.3	MOTORIZED VALVE MOV-261-5 AIR SCOUR SUPPLY NO.6	20	32
			0.3				0.6				0.3			
			0.3					0.6			0.3			
37	20	MOTORIZED VALVE MOV-273 AIR UNLOADING	0.3	1.1	3	0.3			3				50	38
			0.3				0.3							
			0.3					0.3						
PANEL PP-8A LOCATION BIO FILTER E-ROOM BUILDING NOTES:			TOTAL KVA			3.9	3.9	3.9	SERVICE CHARACTERISTICS VOLTS: 480Y/277 PHASE: 3 WIRE: 4 10k MIN AIC SYMM, FULLY RATED ASSEMBLY					
			GRAND CONNECTED TOTAL KVA			11.7								
200 A MLO A MCB														

PANELBOARD SCHEDULE PP-8A

CKT NO.	TRIP AMPS	DESCRIPTION OF LOAD	LOAD KVA	AMPS	POLES	KVA PER PHASE			POLES	AMPS	LOAD KVA	DESCRIPTION OF LOAD	TRIP AMPS	CKT NO.
						A	B	C						
1	20	MOTORIZED VALVE MOV-231-2 BACKWASH SUPPLY NO.3	0.3	1.1	3	0.6			3	1.1	0.3	MOTORIZED VALVE MOV-231-3 BACKWASH TO WASTE NO.3	20	2
			0.3				0.6				0.3			
			0.3					0.6			0.3			
7	20	MOTORIZED VALVE MOV-231-4 FILTER TO WASTE NO.3	0.3	1.1	3	0.6			3	1.1	0.3	MOTORIZED VALVE MOV-231-5 AIR SCOUR SUPPLY NO.3	20	8
			0.3				0.6				0.3			
			0.3					0.6			0.3			
13	20	MOTORIZED VALVE MOV-241-1 FILTER EFFLUENT NO.4	0.3	1.1	3	0.6			3	1.1	0.3	MOTORIZED VALVE MOV-241-2 BACKWASH SUPPLY NO.4	20	14
			0.3				0.6				0.3			
			0.3					0.6			0.3			
19	20	MOTORIZED VALVE MOV-241-3 BACKWASH TO WASTE NO.4	0.3	1.1	3	0.6			3	1.1	0.3	MOTORIZED VALVE MOV-241-4 FILTER TO WASTE NO.4	20	20
			0.3				0.6				0.3			
			0.3					0.6			0.3			
25	20	MOTORIZED VALVE MOV-241-5 AIR SCOUR SUPPLY NO.4	0.3	1.1	3	0.3			3			SPARE	20	26
			0.3				0.3							
			0.3					0.3						
31	20	SPARE			3	0.0			1					32
							0.0							
								0.0						
37					1	0.0			1					38
39					1		0.0		1					40
41					1			0.0	1					42
PANEL PP-7B LOCATION BIO FILTER E-ROOM BUILDING NOTES:			TOTAL KVA			2.7	2.7	2.7	SERVICE CHARACTERISTICS			QSA		
			GRAND CONNECTED TOTAL KVA			8.1			VOLTS: 480Y/277 PHASE: 3 WIRE: 4 10k MIN AIC SYMM, FULLY RATED ASSEMBLY			200 A MLO A MCB		

 

A circular professional engineer seal for Aubrey A. Haudrick. The outer ring contains the text "AUBREY A. HAUDRICK" at the top and "PROFESSIONAL ENGINEER" at the bottom, separated by two stars. Inside the ring, the word "LICENSE" is at the top, "No 66861" is in the center, a single star is below the number, and "STATE OF FLORIDA" is at the bottom.

1365 Hamlet Avenue
Clearwater, Florida 33756
Phone: (727)442-7196, Fax: (727)461-3827
CA Lic. No. 29588
www.mckimcreed.com



CONTROL SCHEMATICS

DATE: OCTOBER 2015 MCE PROJ. # 1024-0167 DRAWN AAH DESIGNED AAH CHECKED JSL PROJ. MGR. PJL	SCALE	DRAWING NUMBER E-3.4
HORIZONTAL: AS SHOWN VERTICAL: NA		
STATUS: REVISION ISSUE FOR BID		



DATE: OCTOBER 2015	SCALE	DRAWING NUMBER
MCF PROJ. # 1024-0167	HORIZONTAL: AS SHOWN VERTICAL: NA	E-3.5
DRAWN _____		
DESIGNED _____		
CHECKED _____		
PROJ. MGR. _____		

STATUS: _____ REVISION _____

ISSUE FOR BID