

MANATEE COUNTY, FLA.

SANITARY SEWERAGE PROJECT

PART D

SECTION III-MASTER LIFT STATION ID

& SECTION IV - FORCE MAIN ID

RUSSELL & AXON


ENGINEERS - PLANNERS - ARCHITECTS

DAYTONA BEACH, FLA.

ST. LOUIS, MO.

INDEX

	SHEET NO.	DESCRIPTION
	1	COVER SHEET & INDEX
	2	KEY MAP
	3	KEY MAP
	4	SITE PLAN
	5	ARCHITECTURAL - FLOOR PLAN, ELEVATIONS, & SECTION
	6	ARCHITECTURAL - DETAILS
	7	ARCHITECTURAL - SCHEDULES & DETAILS
	8	MECHANICAL - FLOOR PLANS
	9	MECHANICAL - SECTIONS
SECTION III	10	MECHANICAL - SECTION & MISC. DETAILS
	11	MECHANICAL - DETAILS
	12	MISC. DETAILS
	13	STRUCTURAL - FLOOR PLANS
	14	STRUCTURAL - SECTIONS
	15	STRUCTURAL - SECTION
	16	ELECTRICAL - WIRING FLOOR PLAN
	17	ELECTRICAL - LIGHTING
	18	ELECTRICAL - MOTOR CONTROL
	19	ELECTRICAL - SCHEDULES & SCHEMATICS
SECTION IV	20	FORCE MAIN ID
	21	FORCE MAIN ID
	22	FORCE MAIN ID
	23	FORCE MAIN STANDARD DETAILS

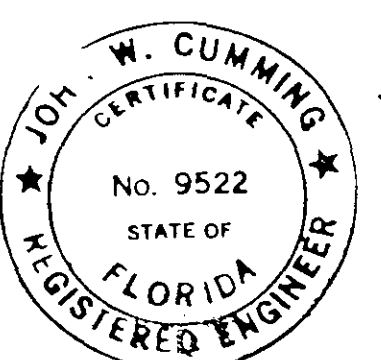


MANATEE COUNTY, FLORIDA
SANITARY SEWERAGE PROJECT
PART D
SECTION III-MASTER LIFT STATION I
SECTION IV-FORCE MAIN ID
PROJECT NO. 6681-8b
SHEET NO. 1 OF 23

RECORD DRAWING

DATE 2-26-84 PM

CK LKN

T274






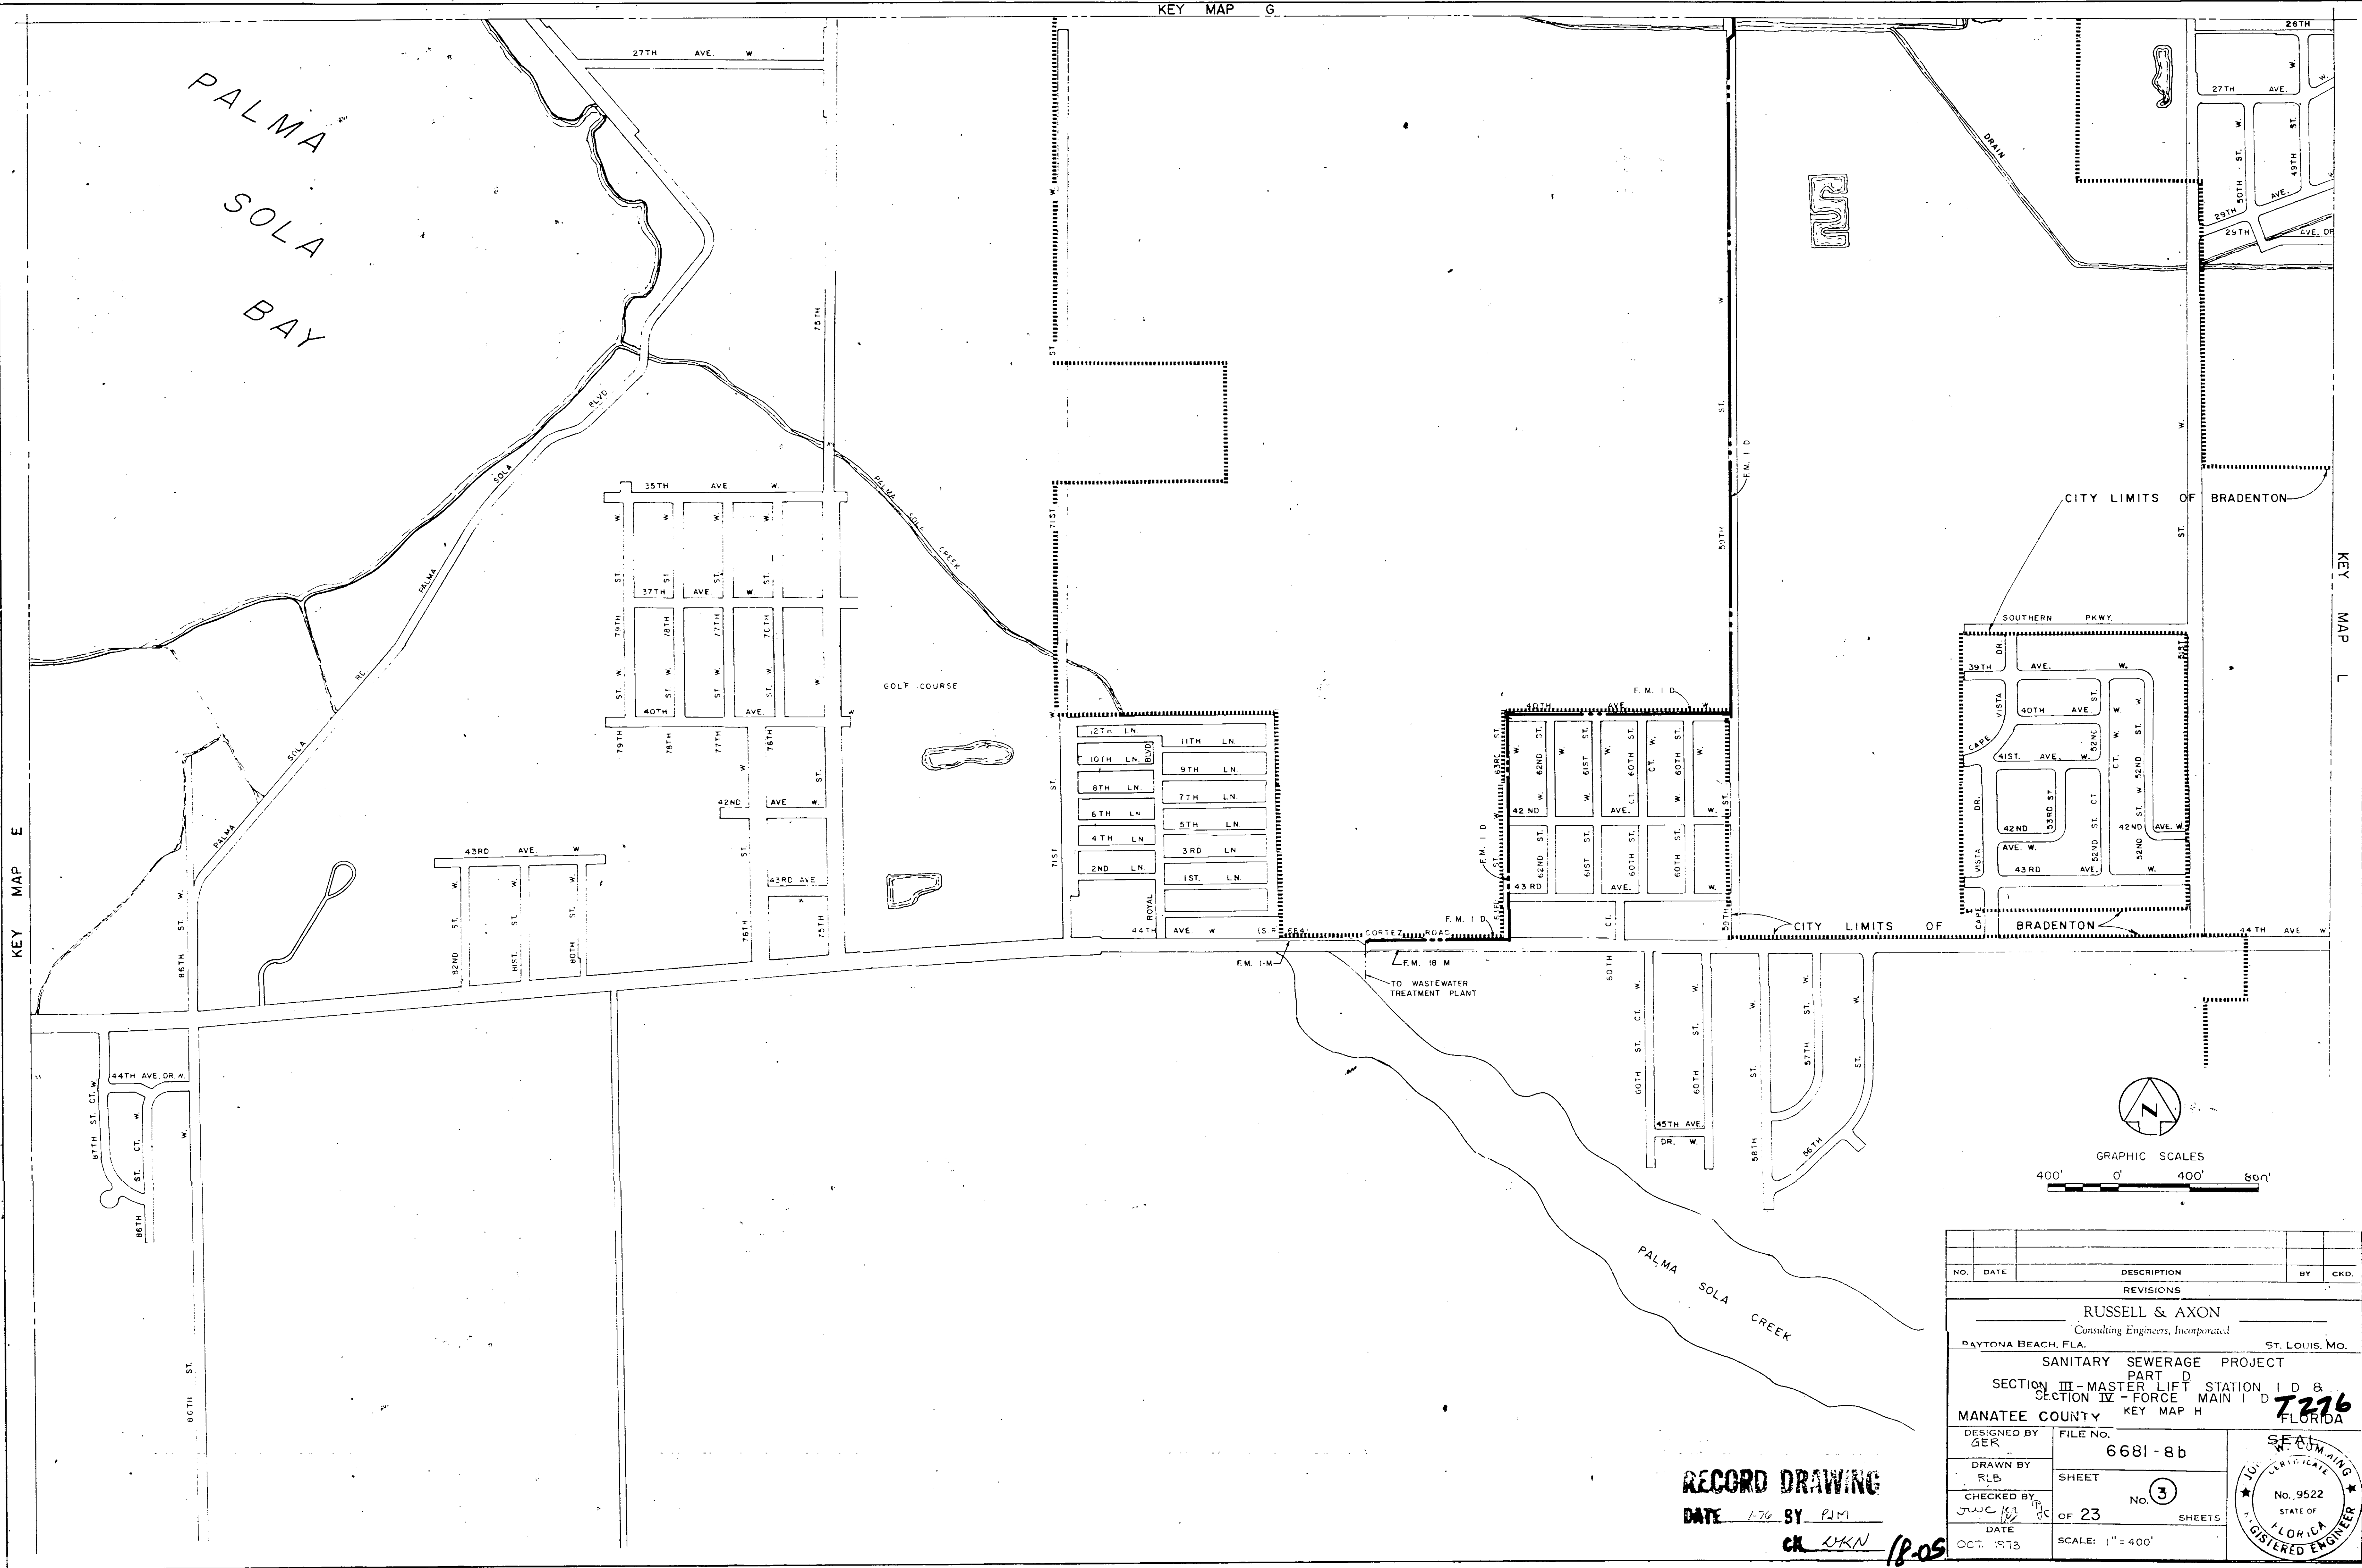


NO.	DATE	DESCRIPTION	BY	CHKD.
REVISIONS				
RUSSELL & AXON Consulting Engineers, Incorporated DAYTONA BEACH, FLA. ST. LOUIS, MO.				
SANITARY SEWERAGE PROJECT PART D SECTION III - MASTER LIFT STATION I D & SECTION IV - FORCE MAIN I D MANATEE COUNTY KEY MAP H				
DESIGNED BY GER	FILE NO. 6681-8b	SEAL No. 9522 STATE OF FLORIDA REGISTERED ENGINEER		
DRAWN BY RLB	SHEET OF 23			
CHECKED BY JWC	DATE OCT. 1973			


RECORD DRAWING

DATE 7-76 BY PJM

CK LKN 18-05

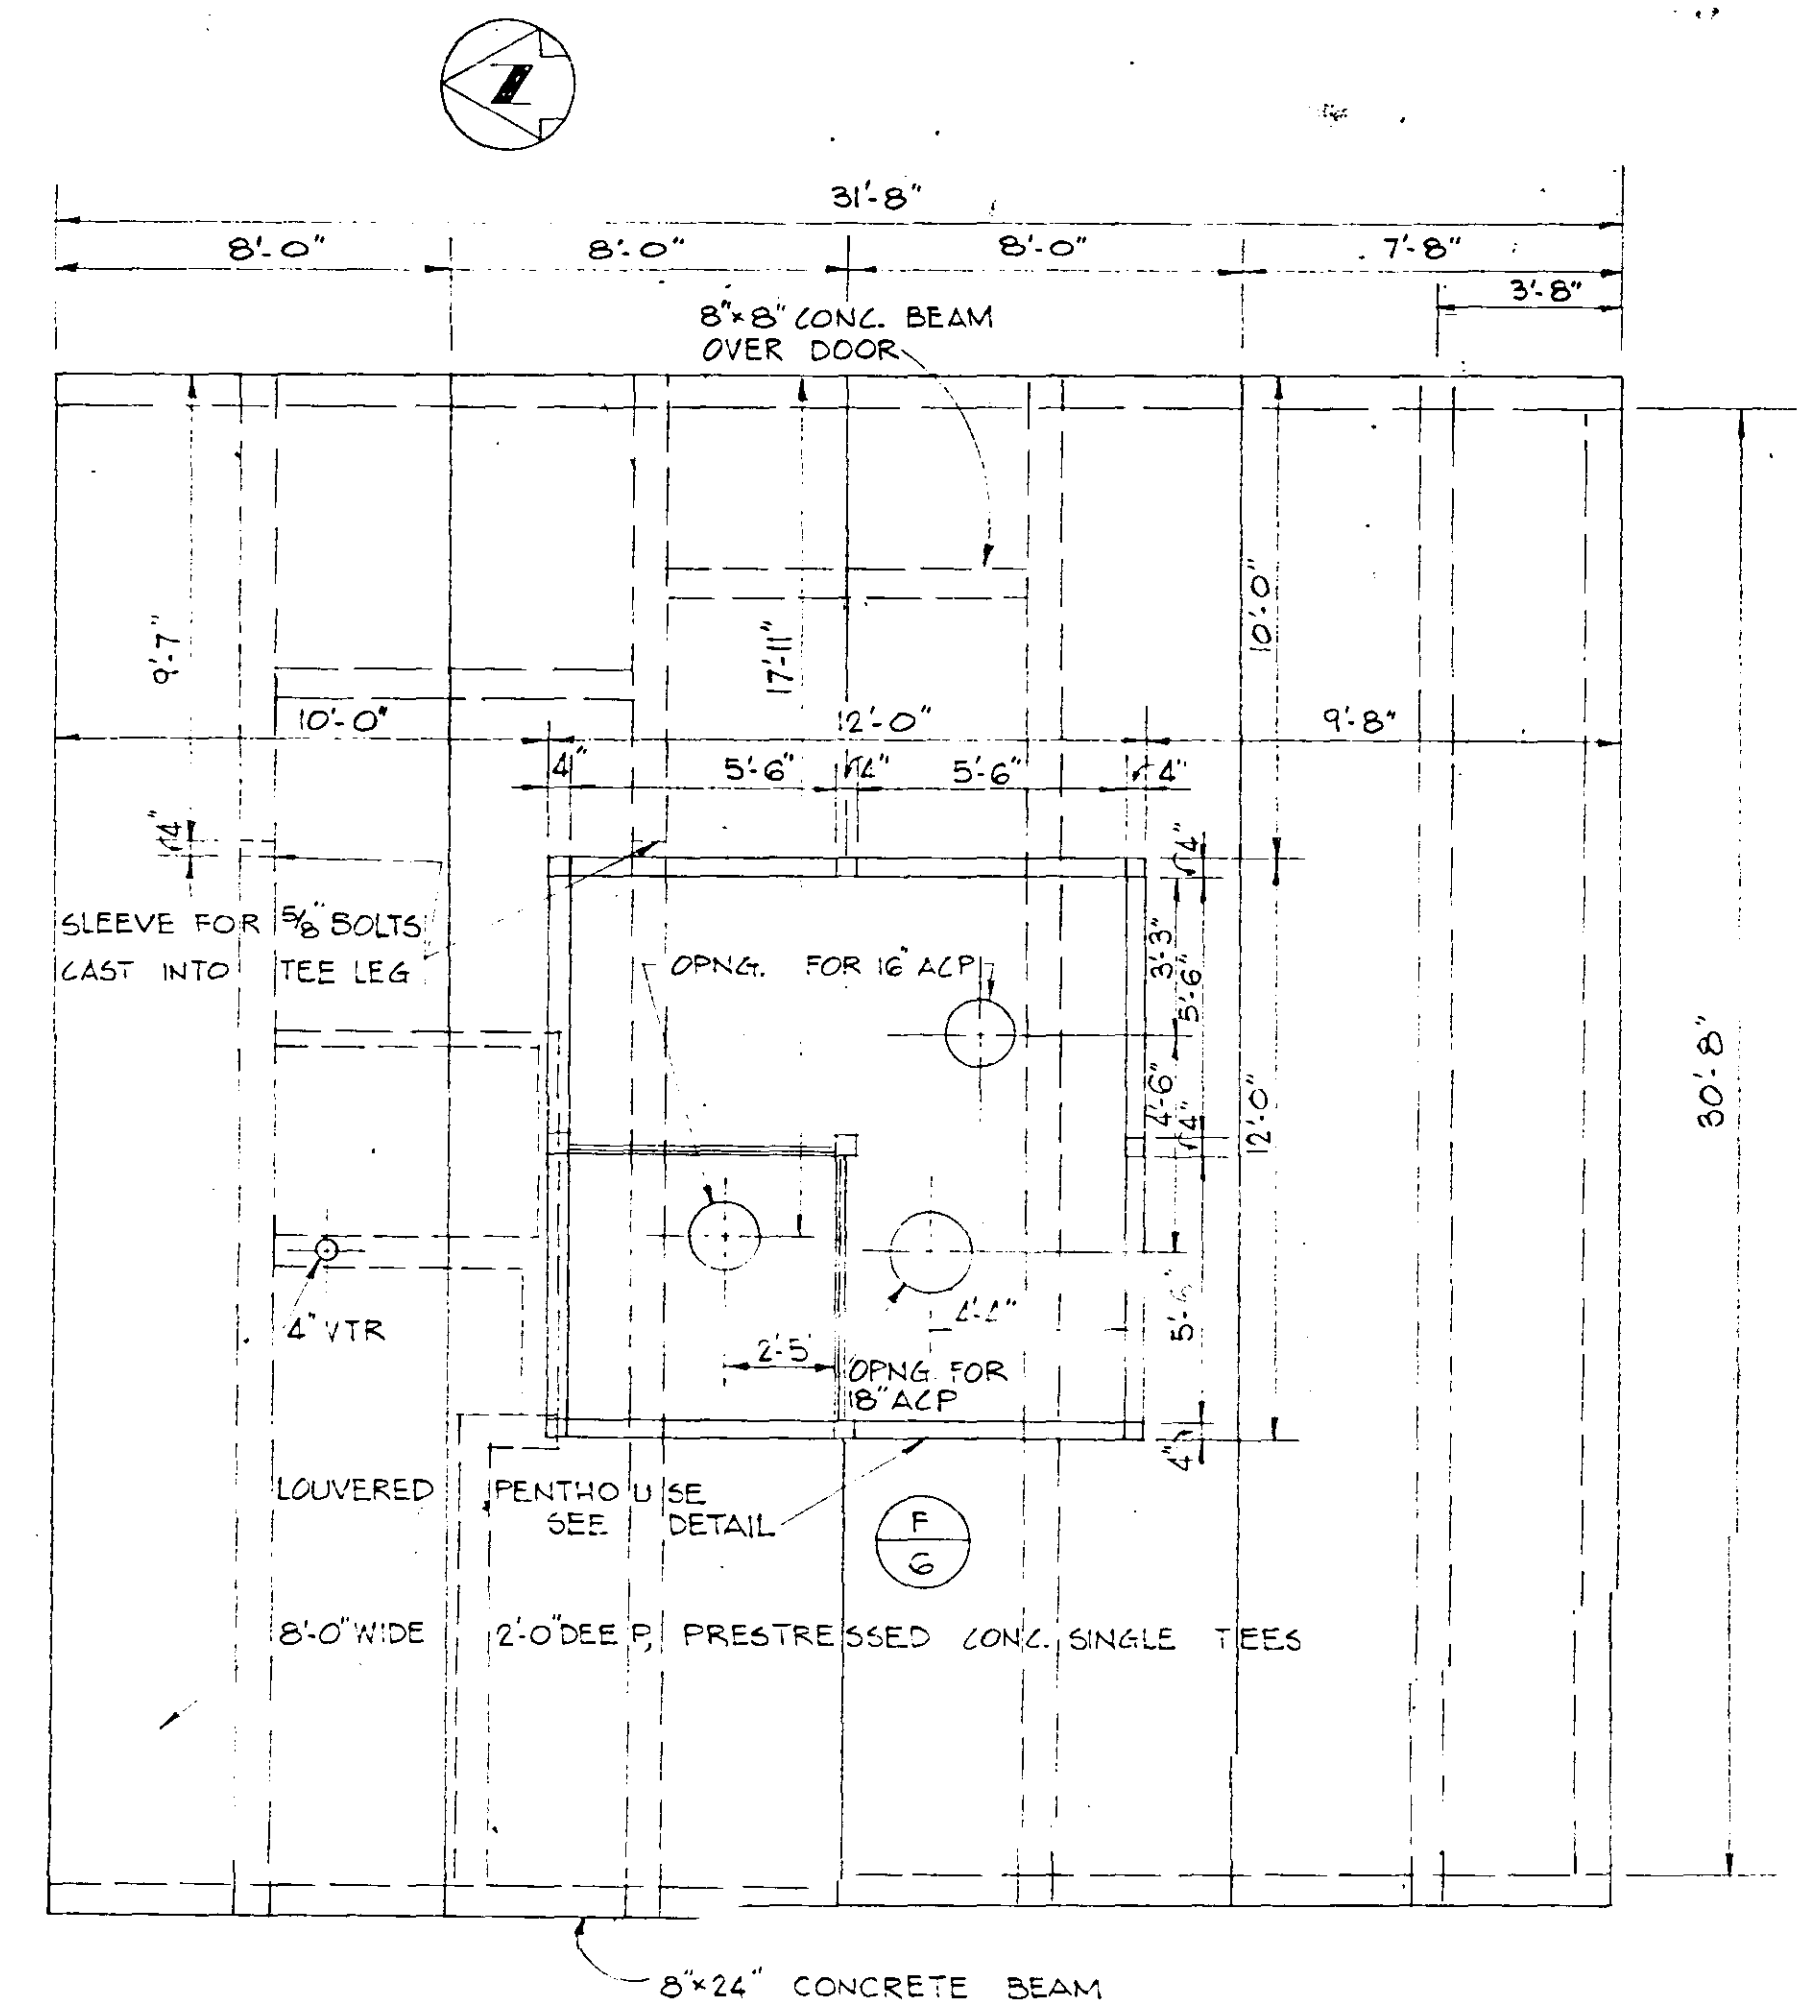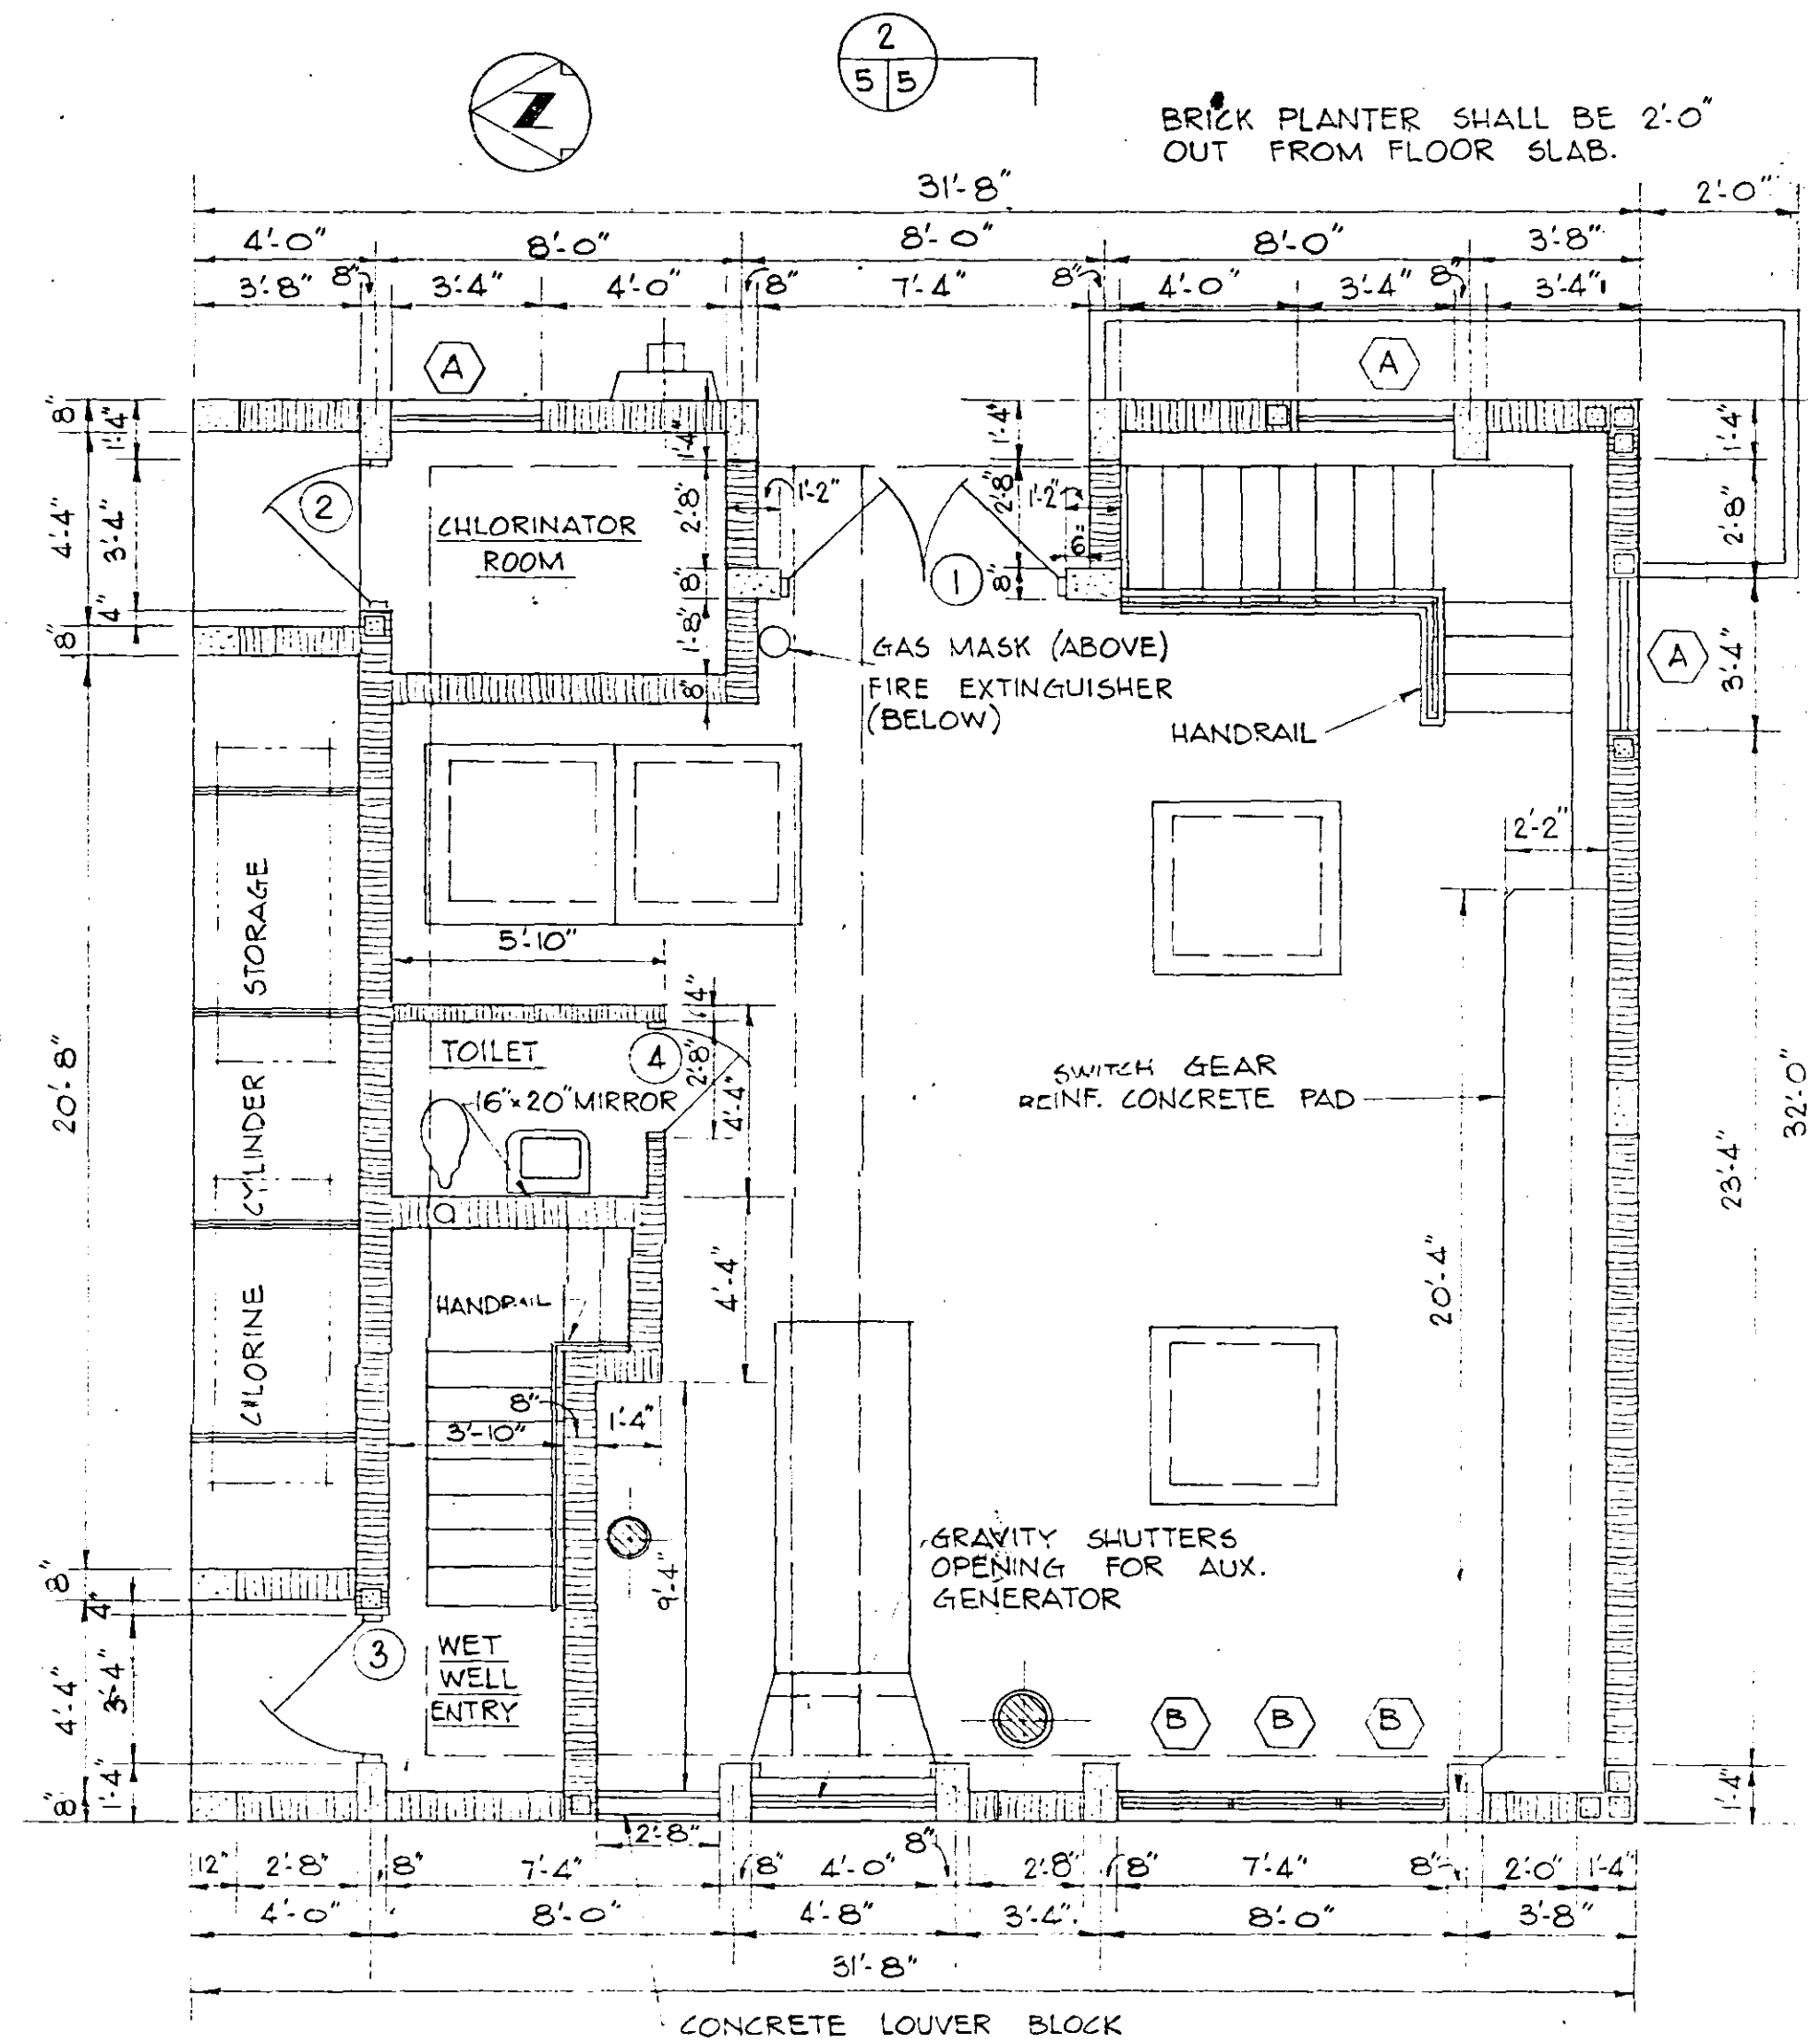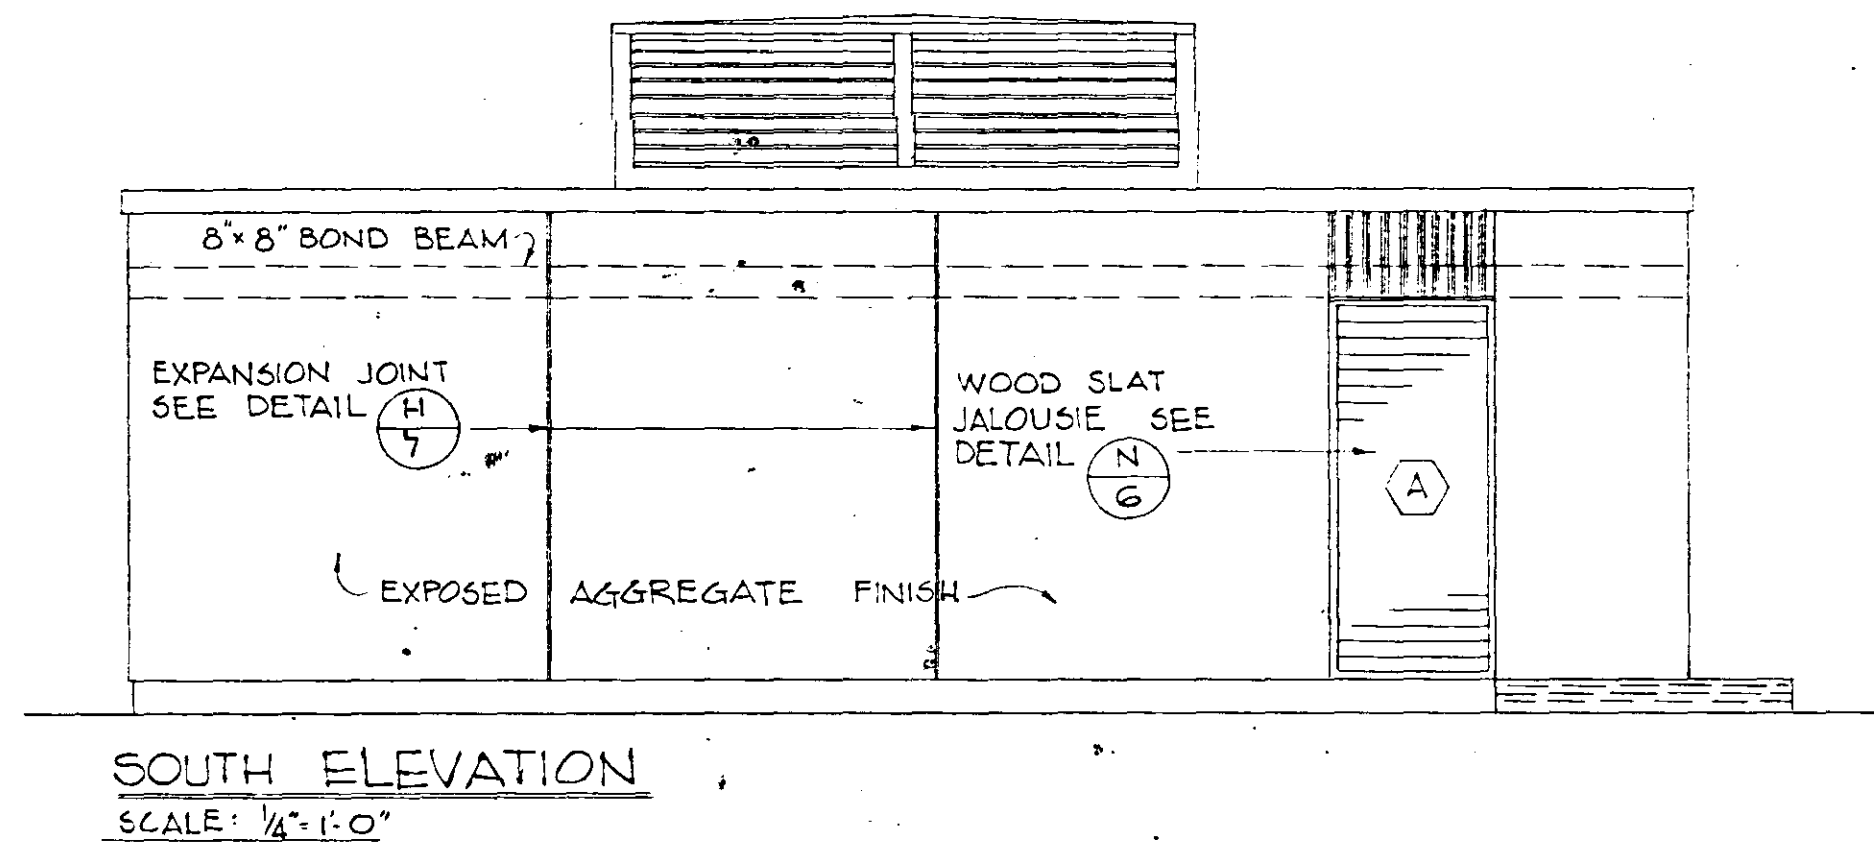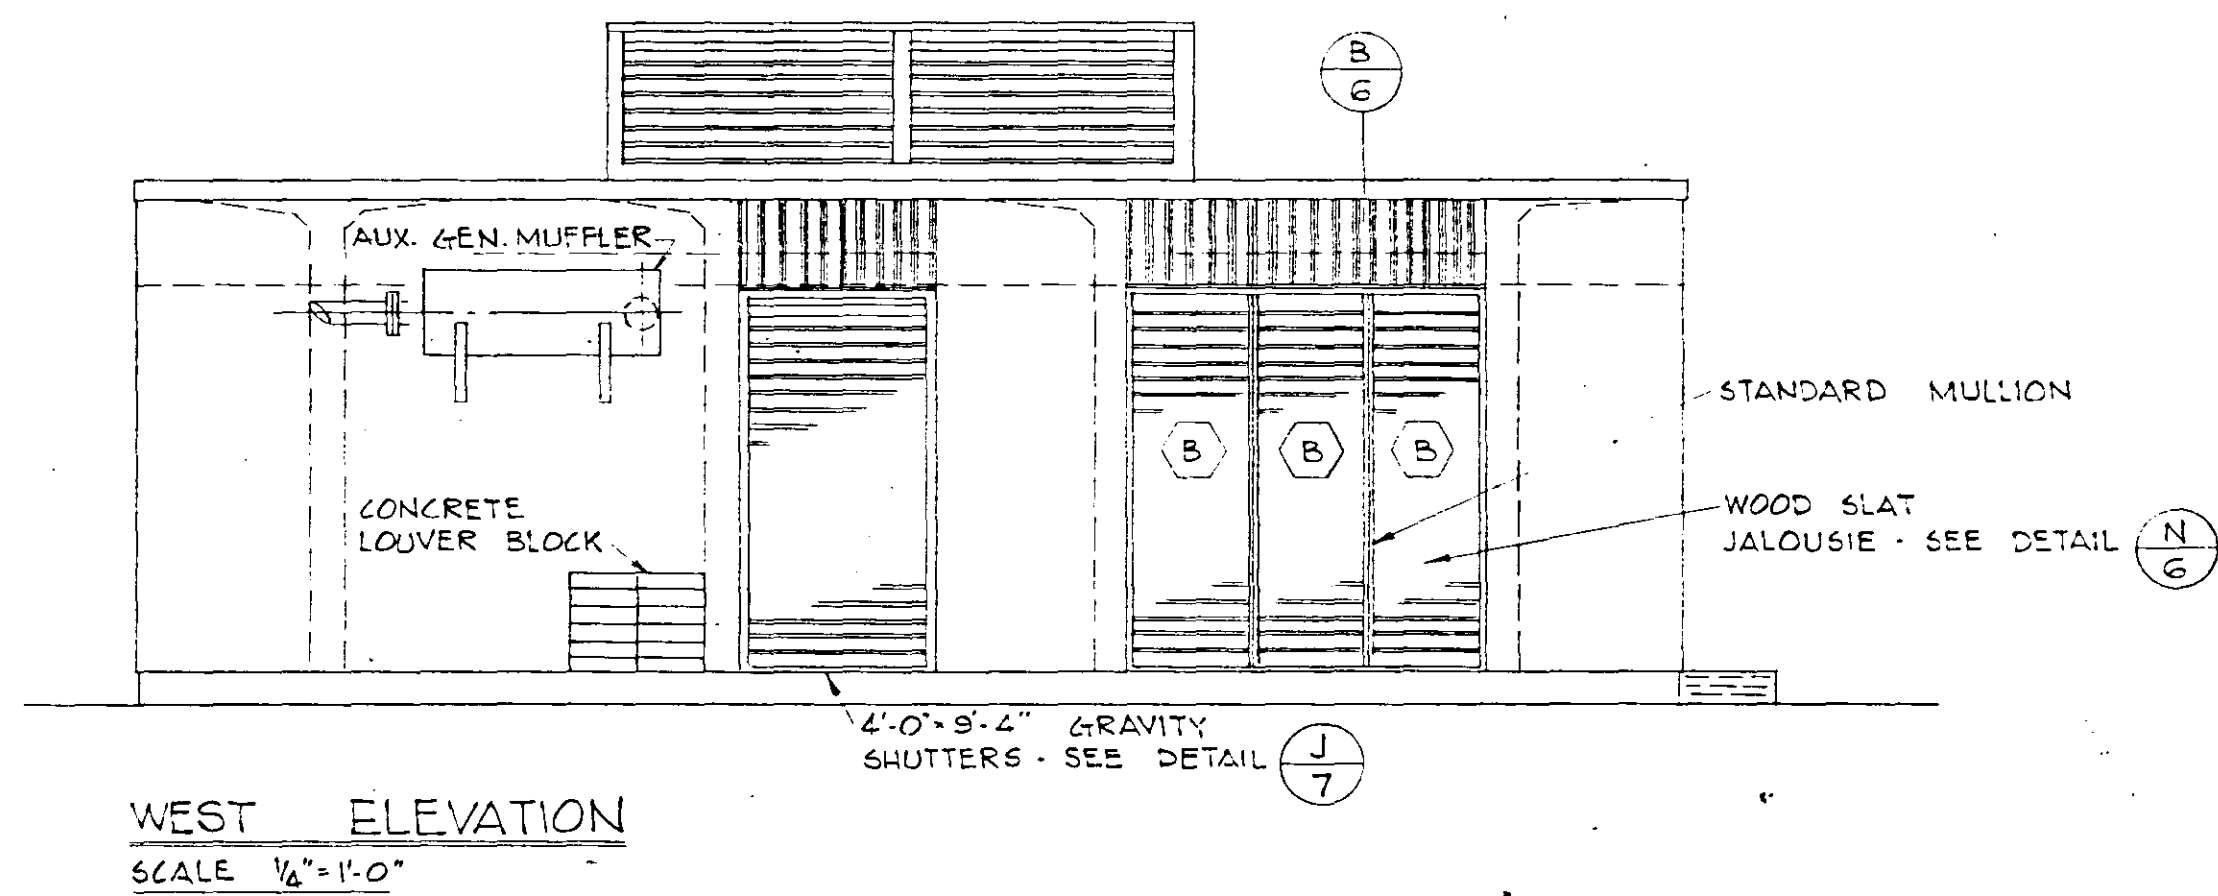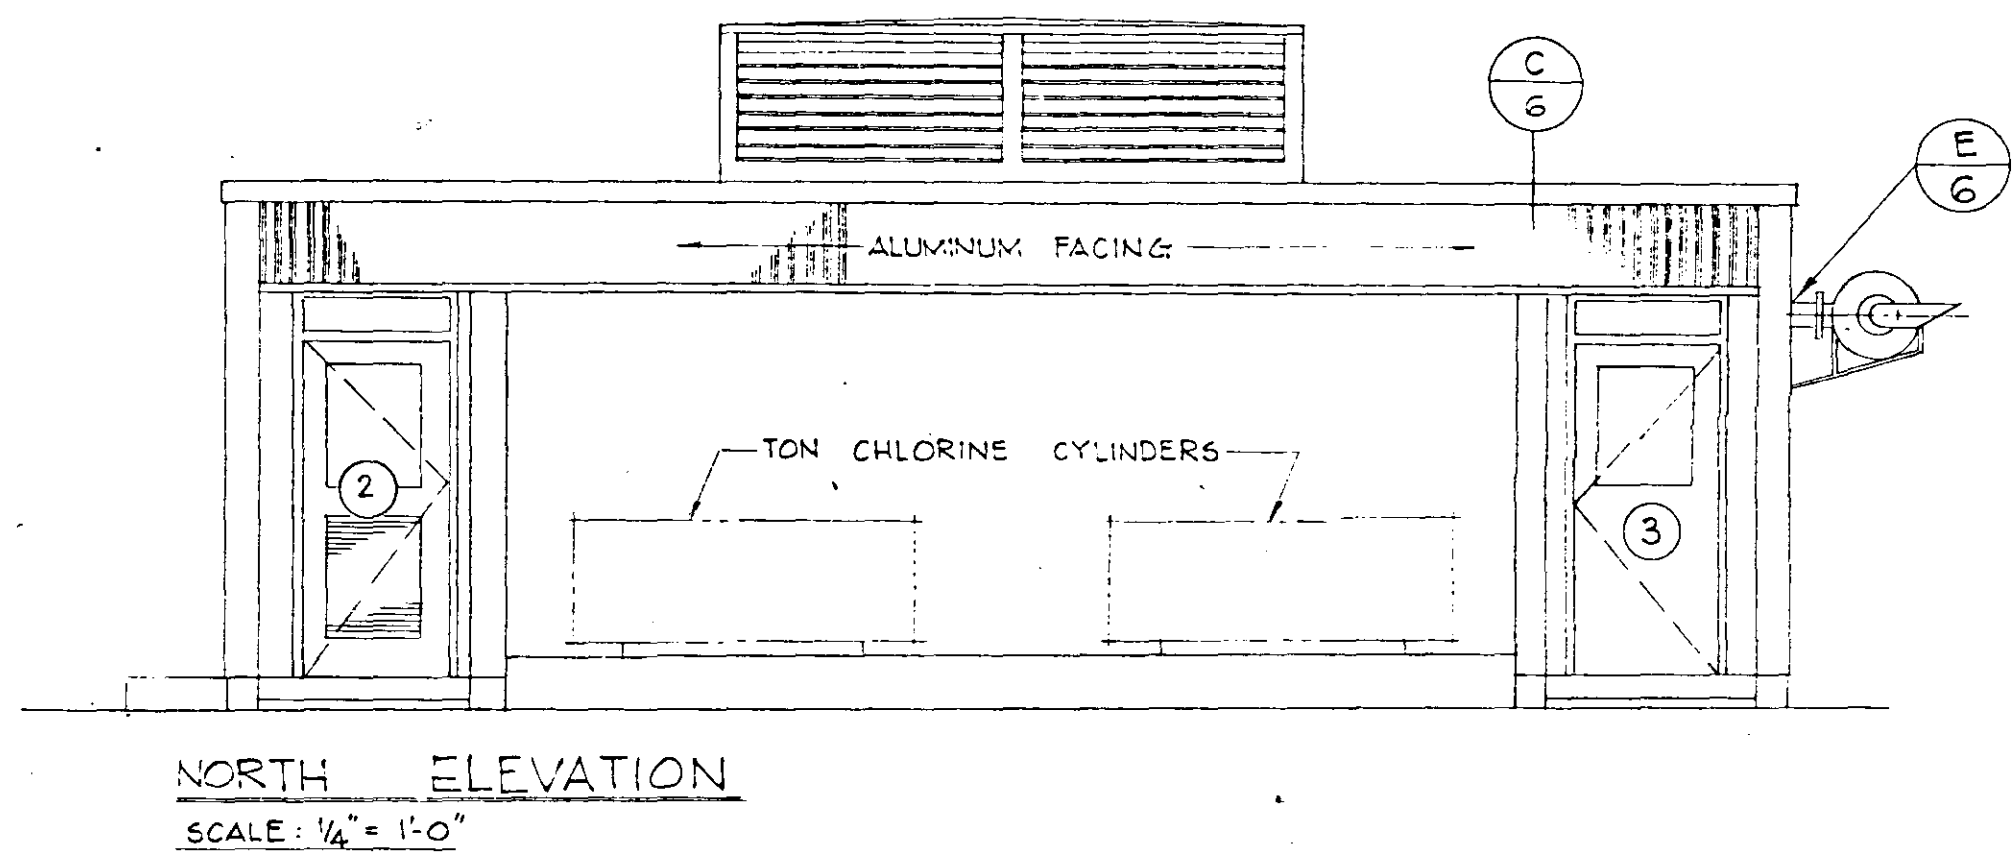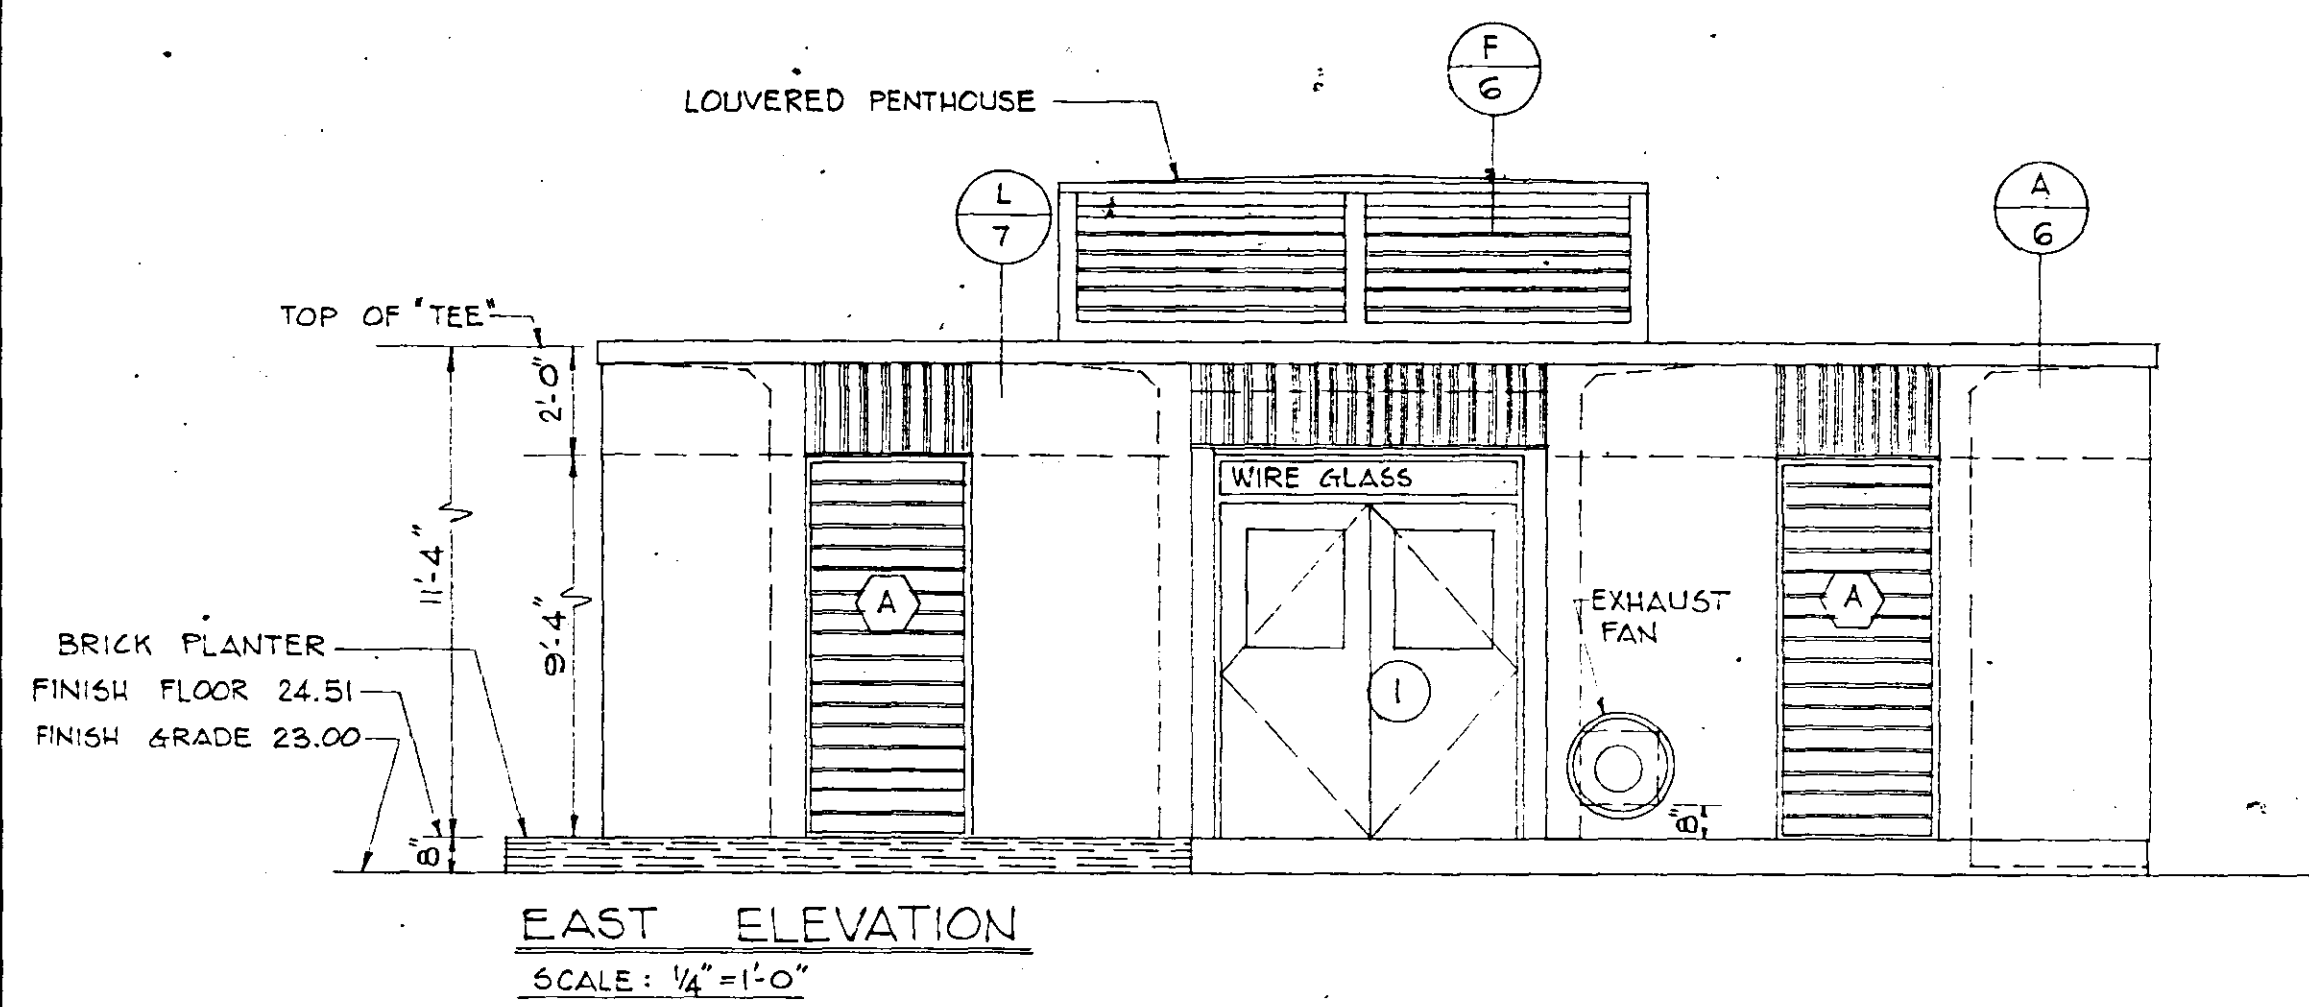

NOTE:
ALL COLUMNS ARE 8"x16" UNLESS OTHERWISE NOTED. SEE STRUCTURAL DRAWINGS FOR REINFORCING.
CELLS OF CONCRETE MASONRY UNITS, SHOWN SHALL HAVE 1/2" IN CENTER (DOWEL DOWN INTO CONCRETE) & BE FILLED W/ GROUT.

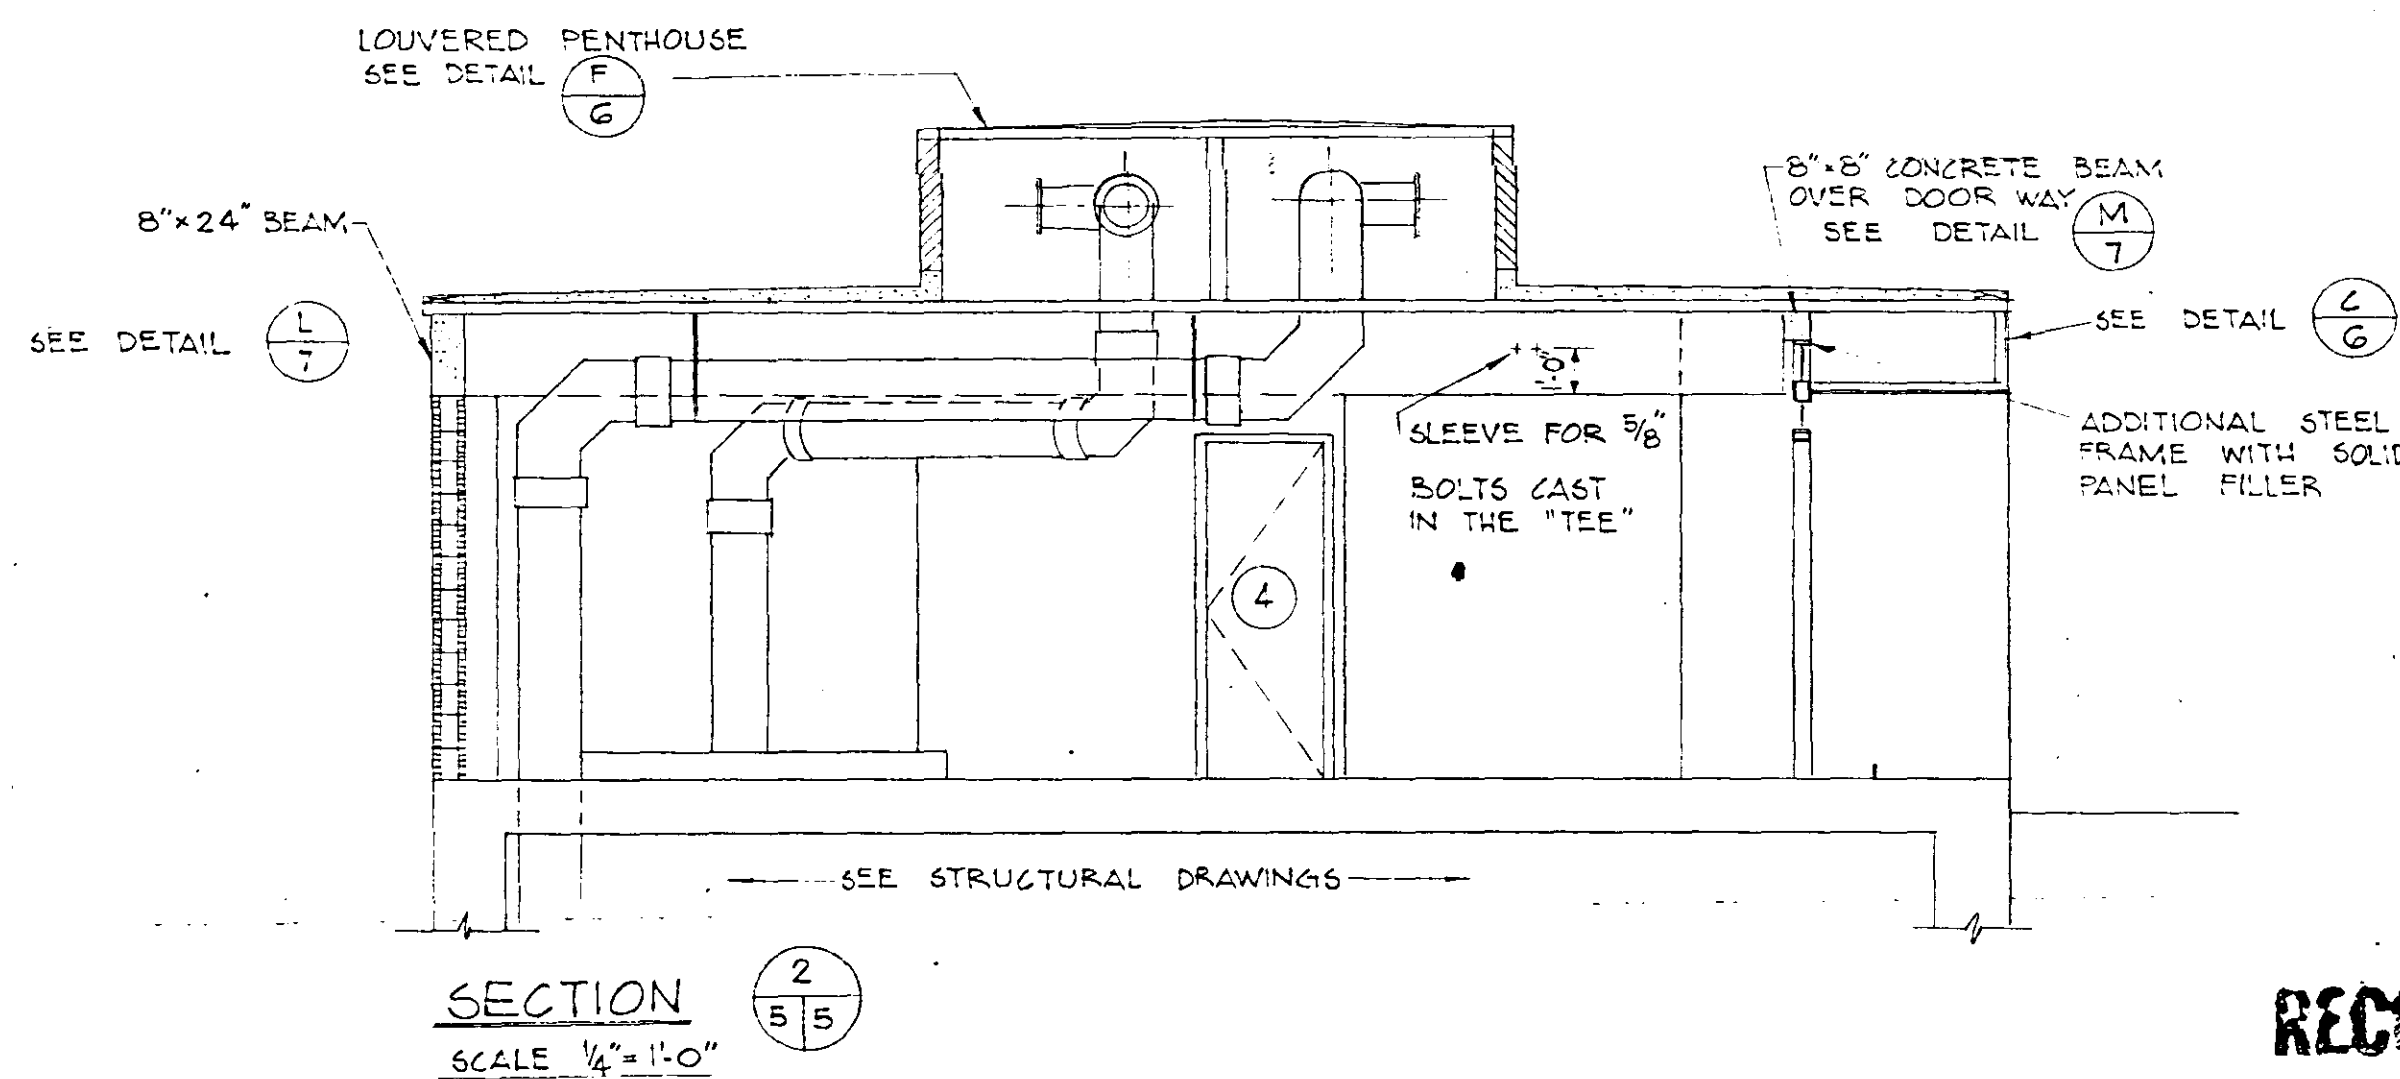


RECORD DRAWING










DATE 7-76 BY P.J.M.
CK

NO.	DATE	DESCRIPTION	BY	CHKD.
7-76		RECORD DRAWING	P.J.M.	
REVISIONS				
RUSSELL & AXON				
Engineers - Planners - Architects				
DAYTONA BEACH, FLORIDA				
SANITARY SEWERAGE PROJECT				
PART D				
SECTION III - MASTER LIFT STATION I D				
ARCH: FLOOR PLAN, ELEVATIONS, & SECTION				
MANATEE COUNTY, FLORIDA				
DESIGNED BY	FILE NO.			
ROV/GER	6681 - 8b			
DRAWN BY	SHEET			
RLB	5			
CHECKED BY	NO.			
JWC	23			
DATE	OF 23 SHEETS			
OCT. 1973	SCALE: AS SHOWN			

RECORD DRAWING

DATE 7-76 BY P.J.M.
CK

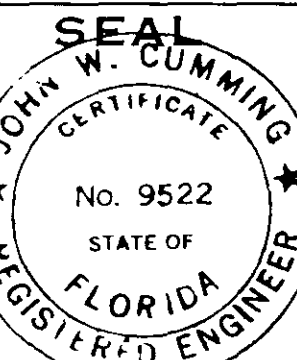

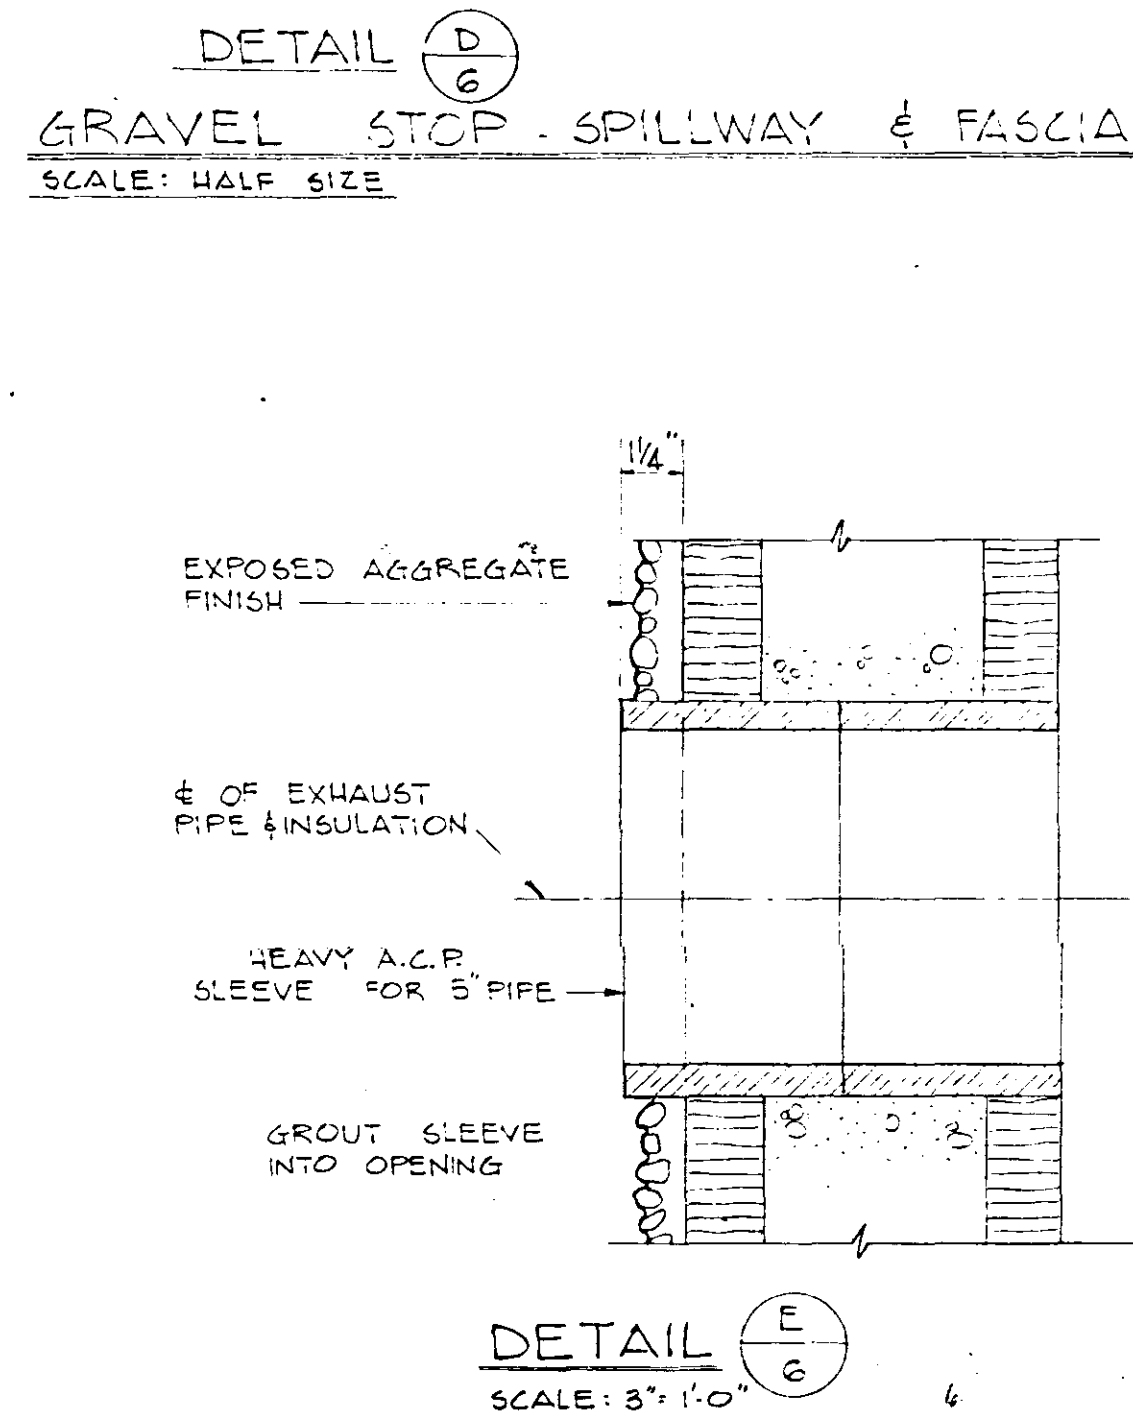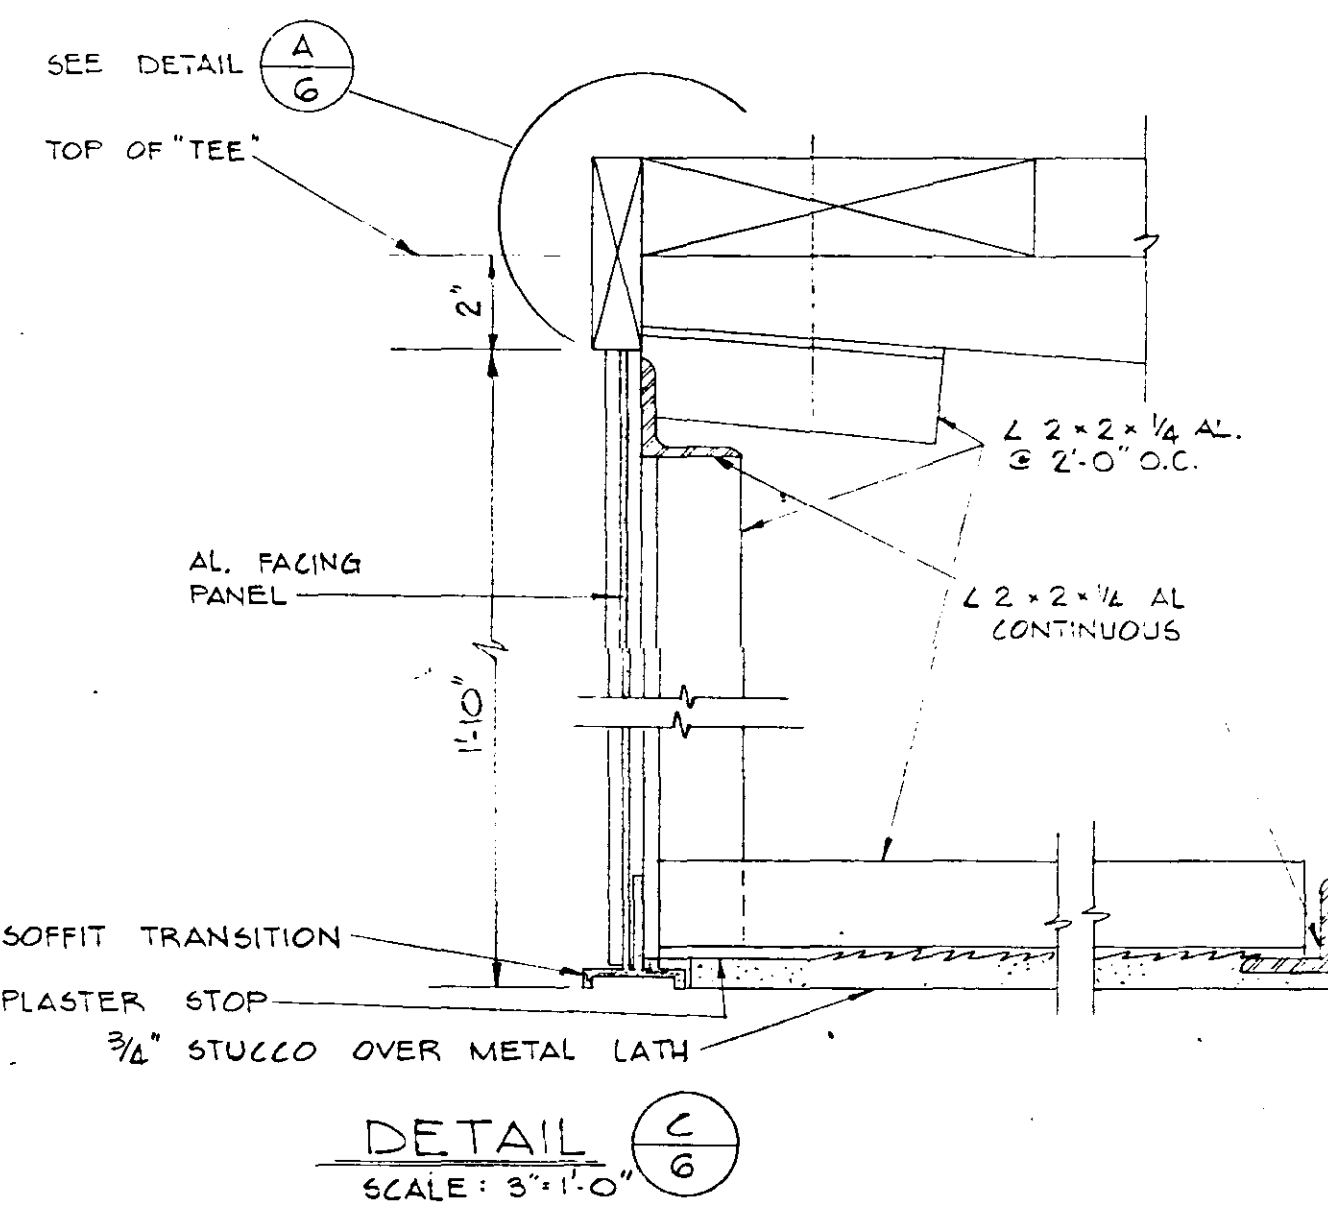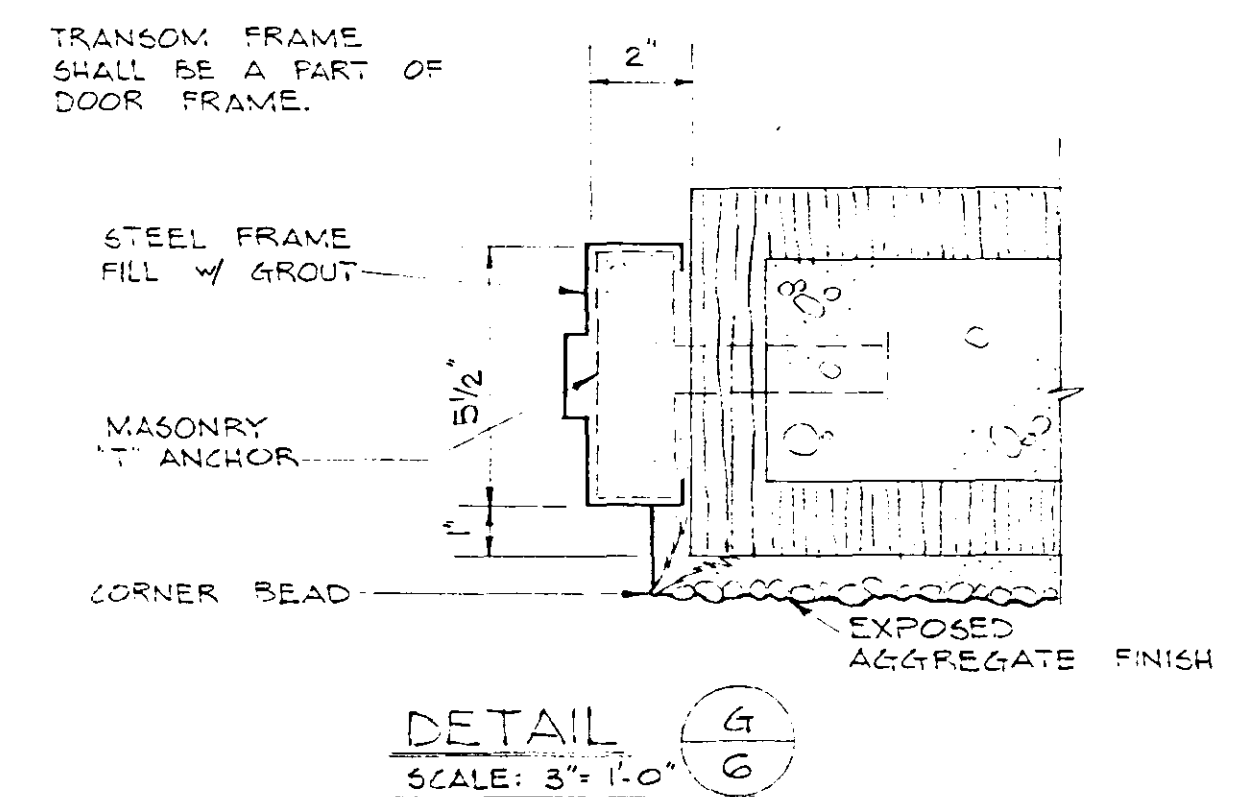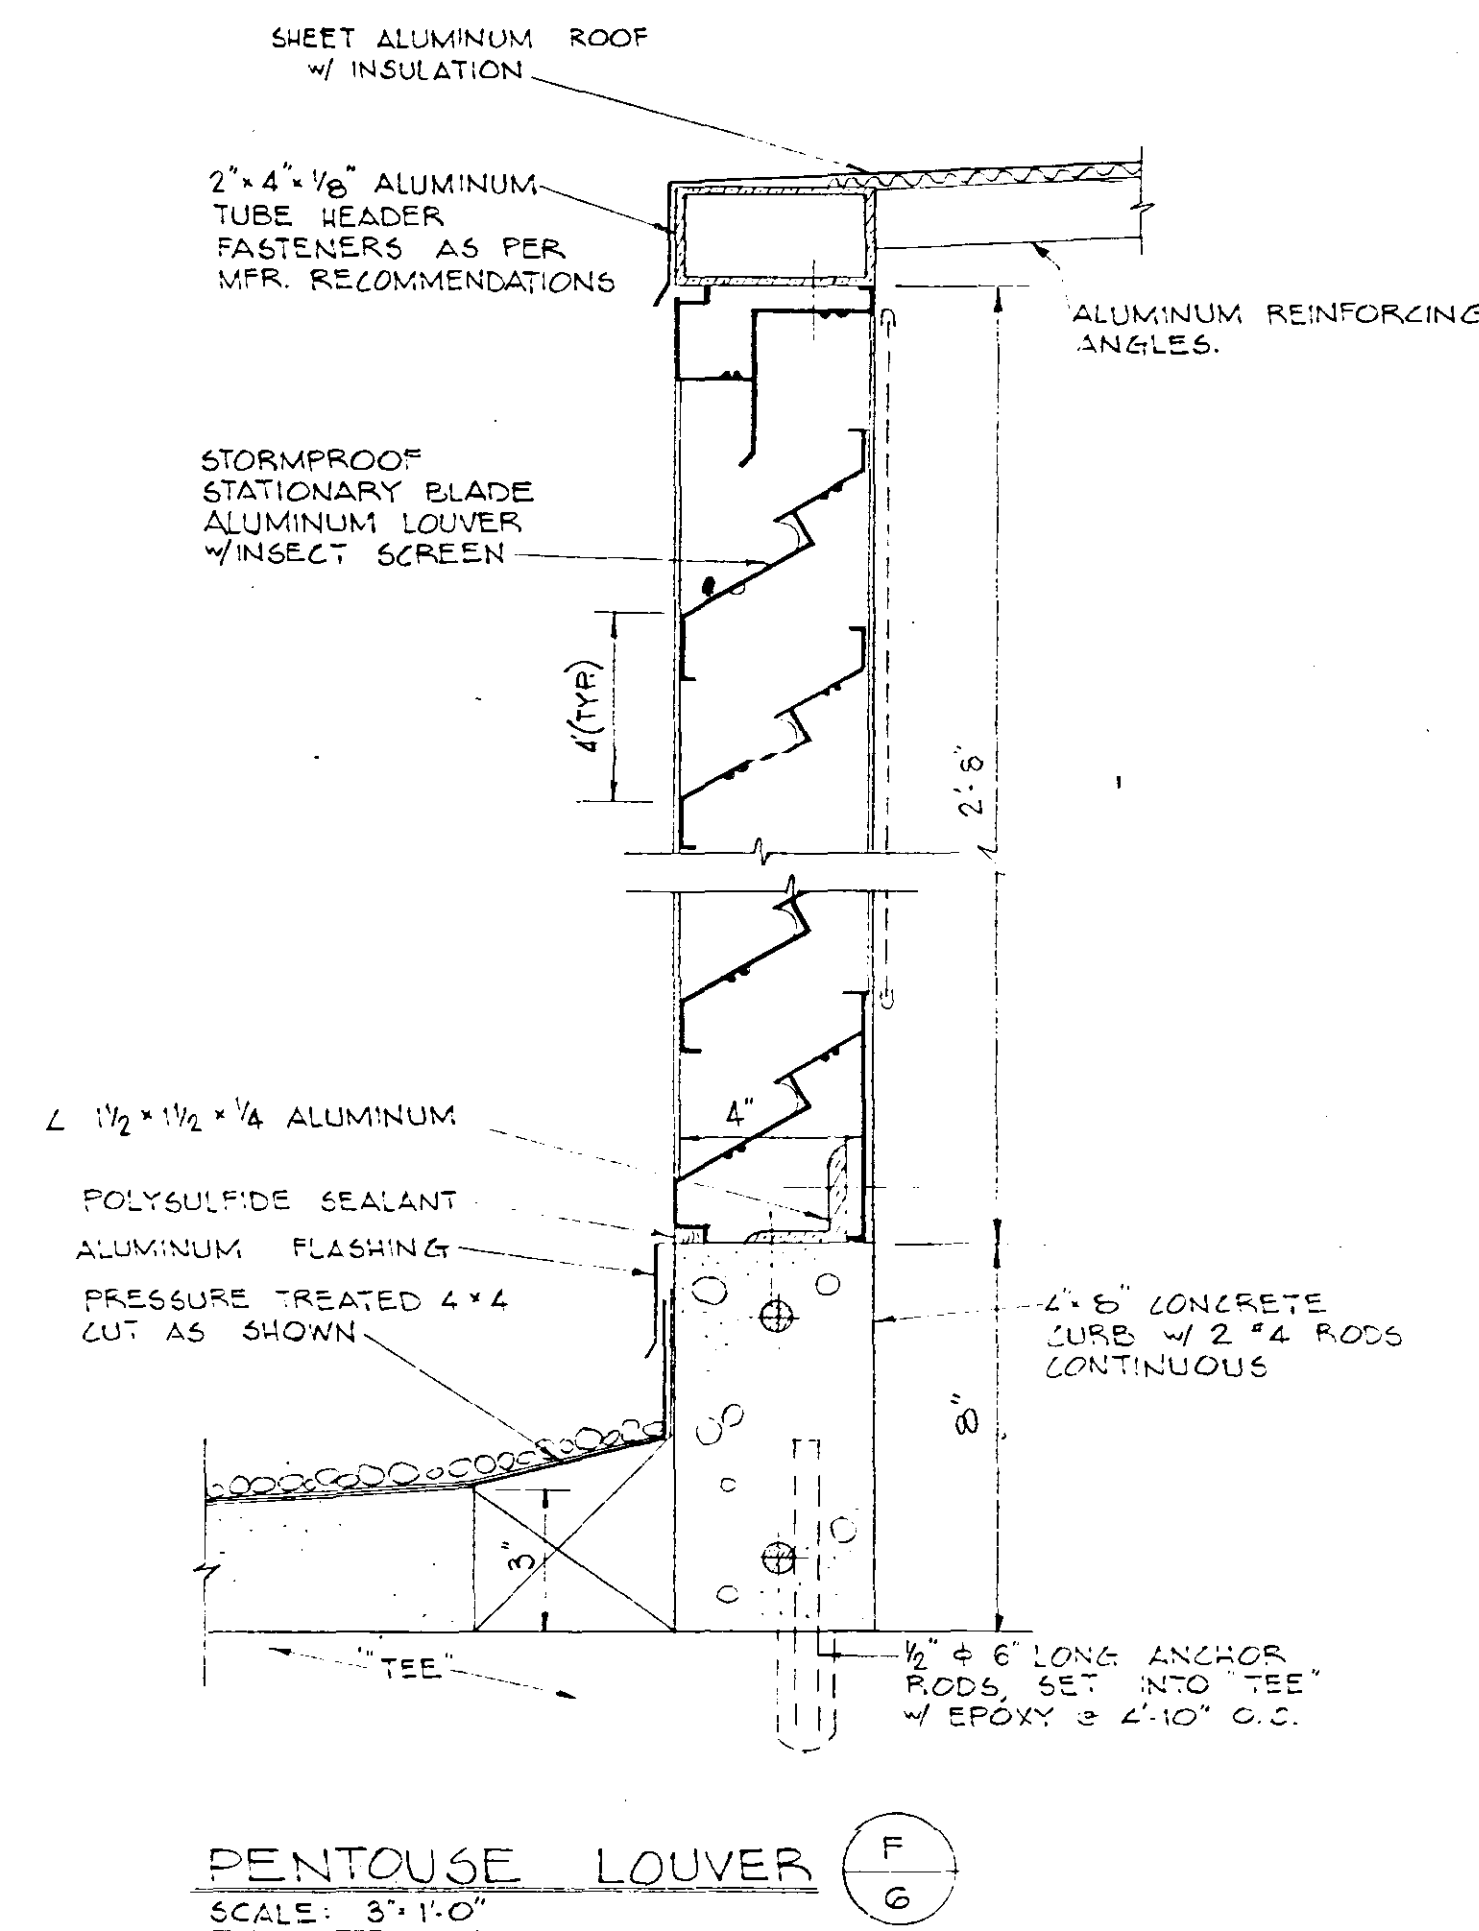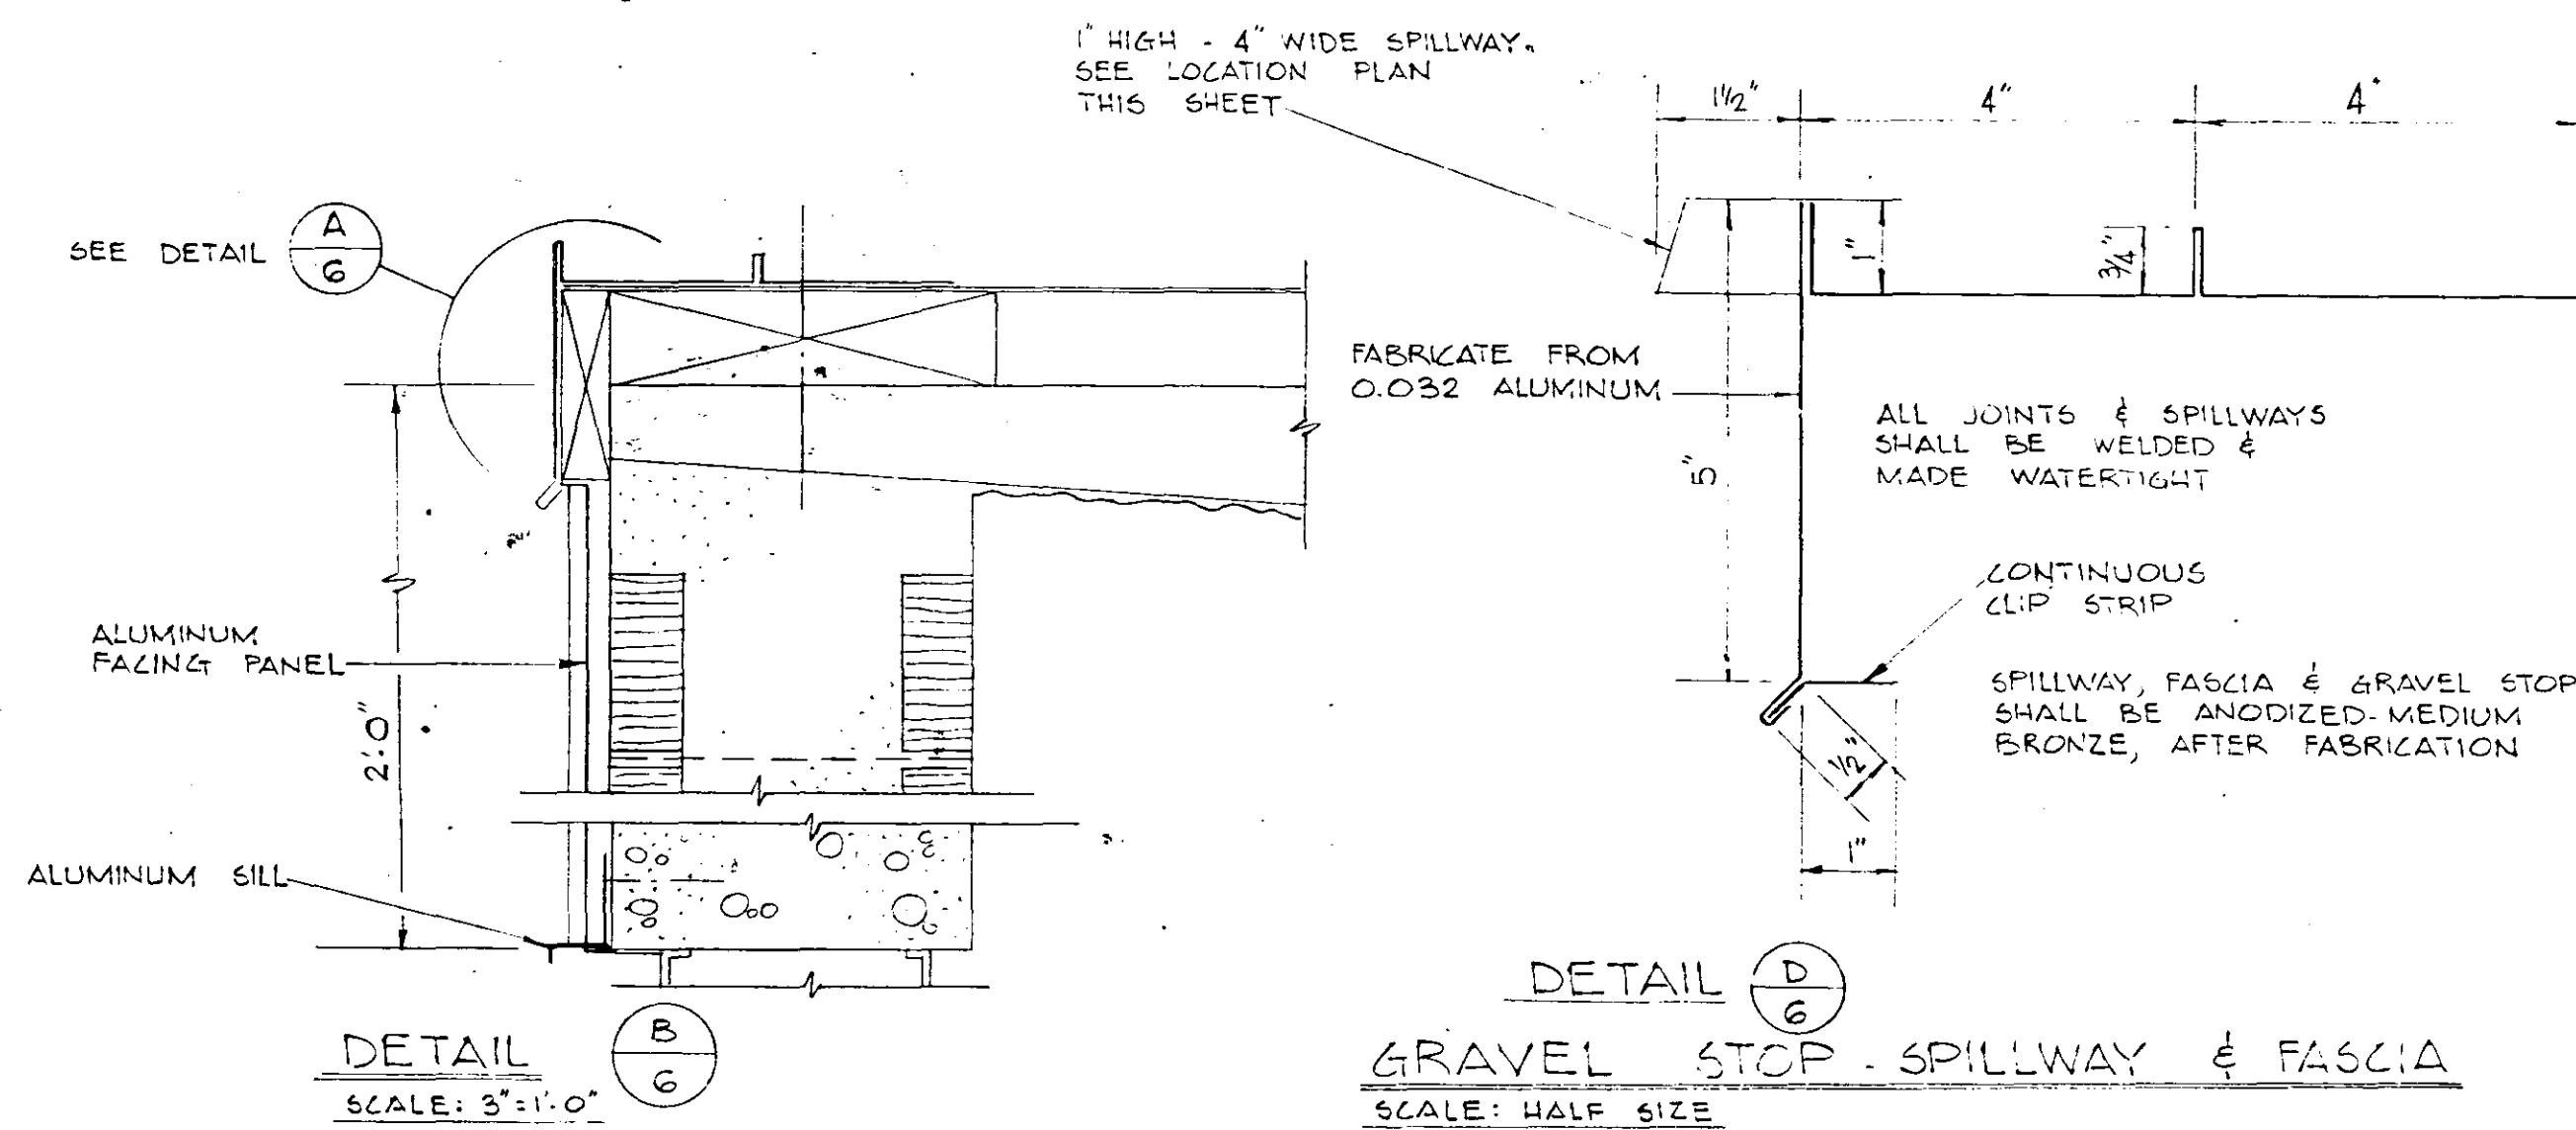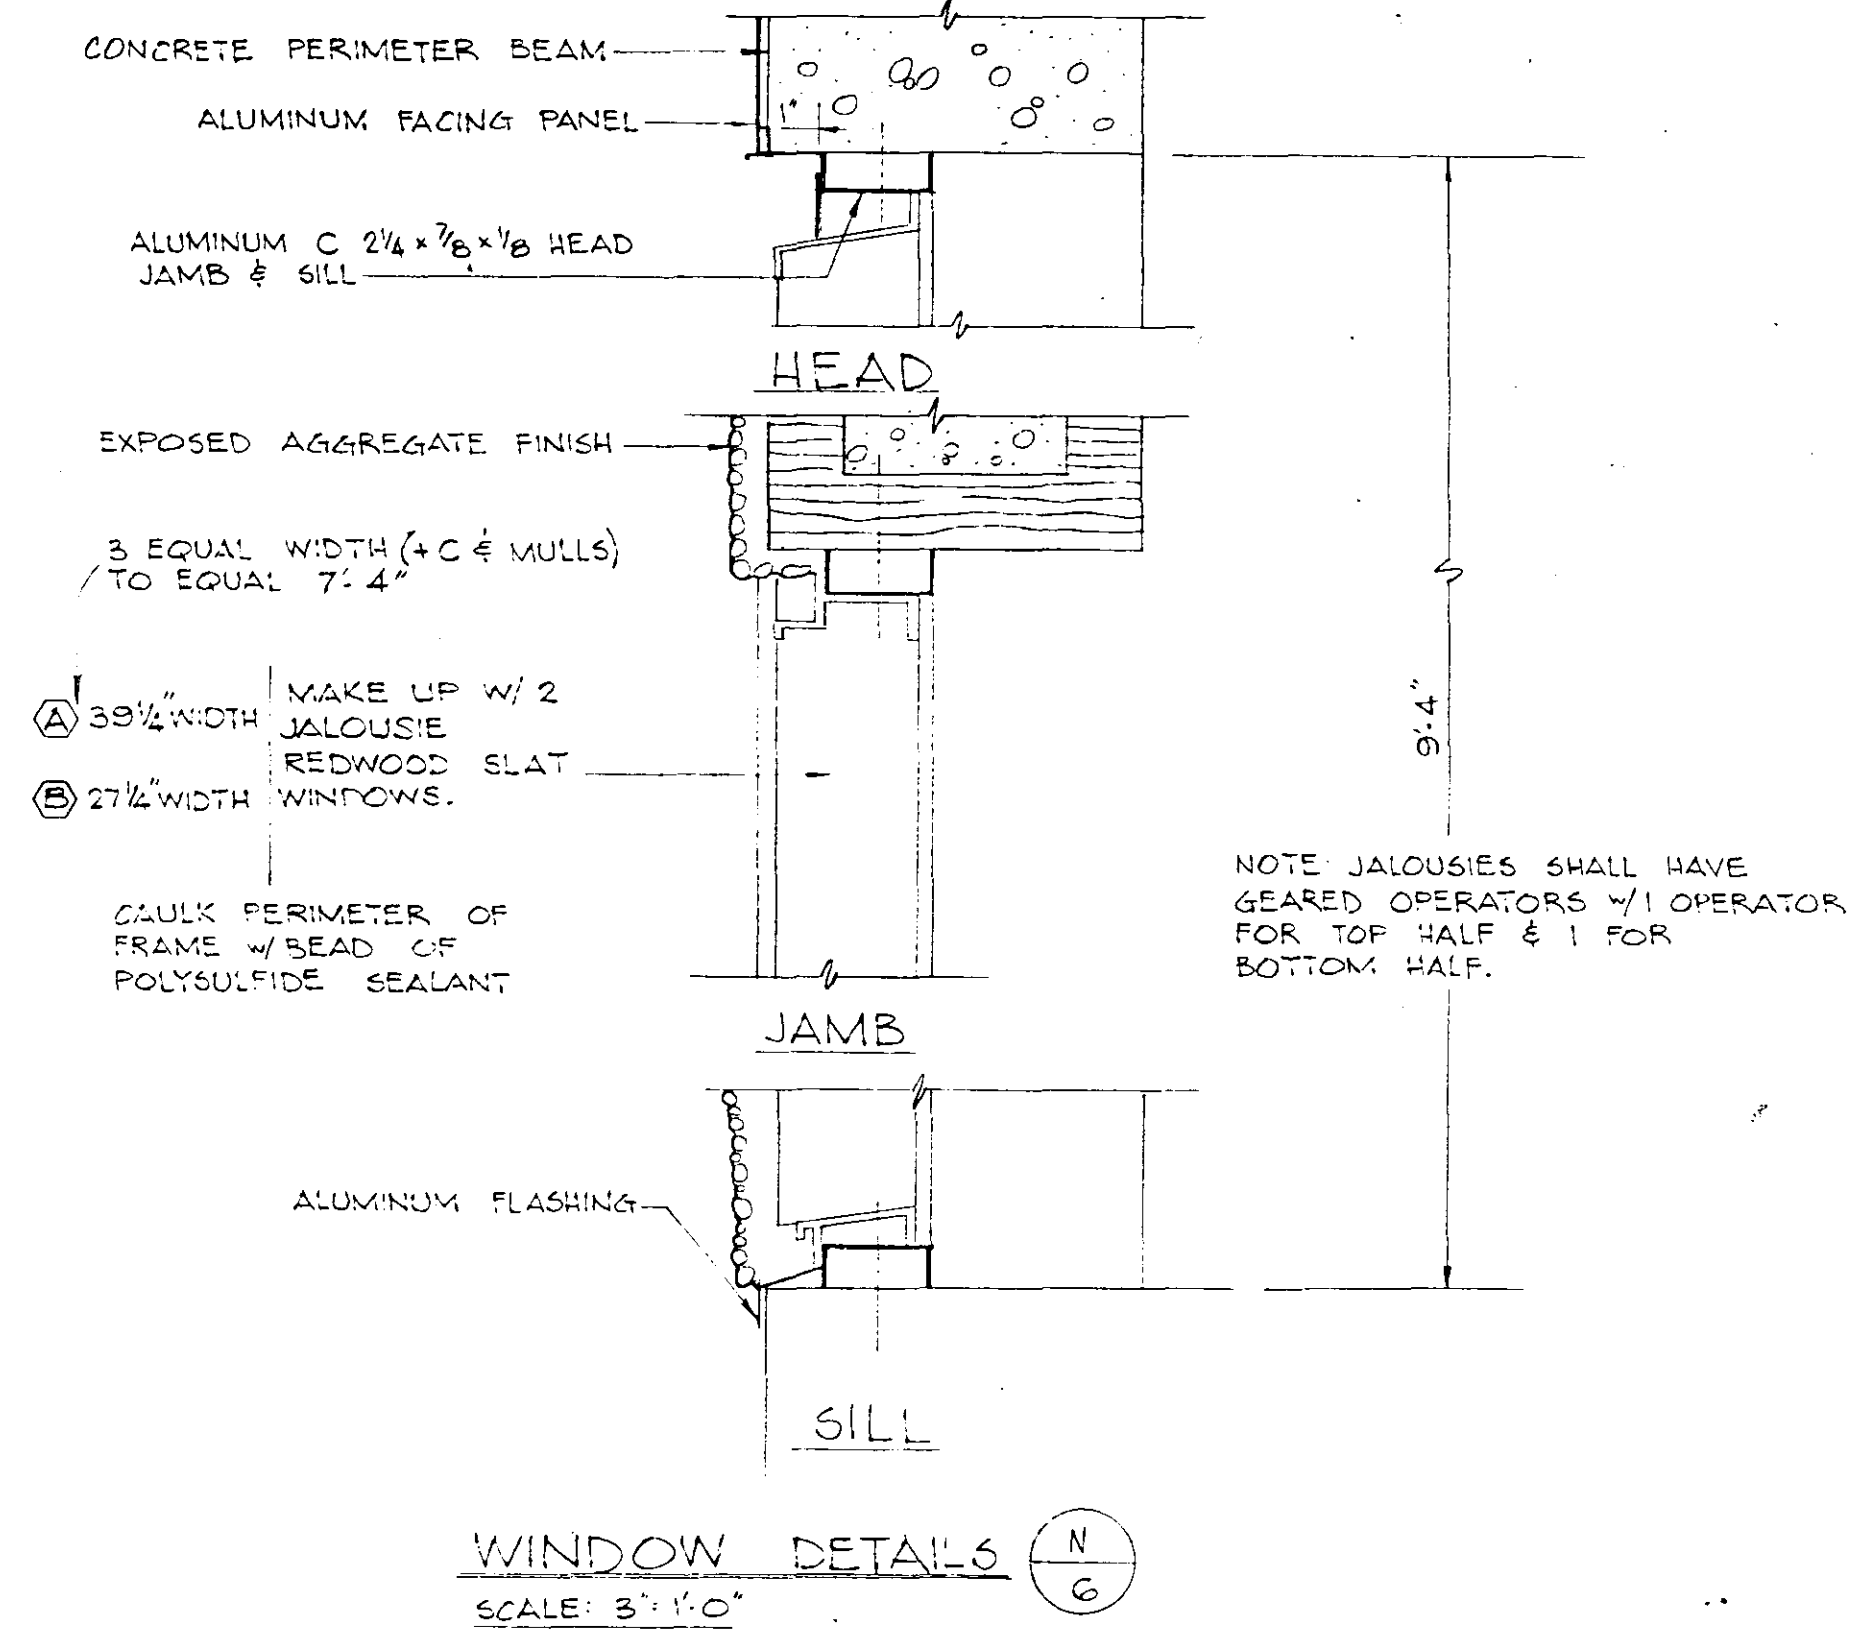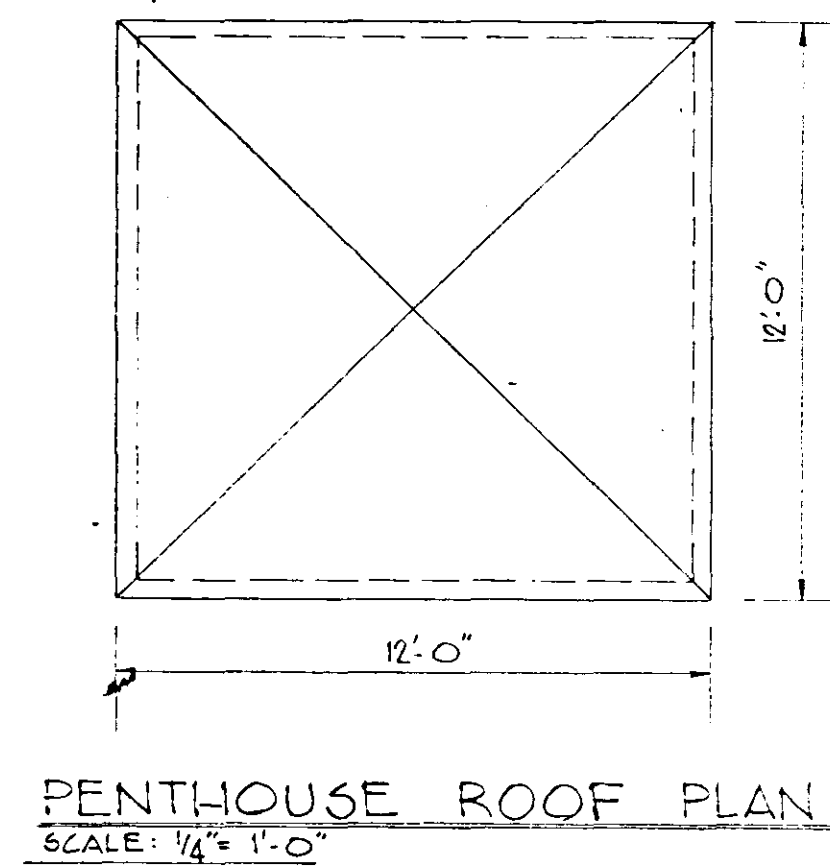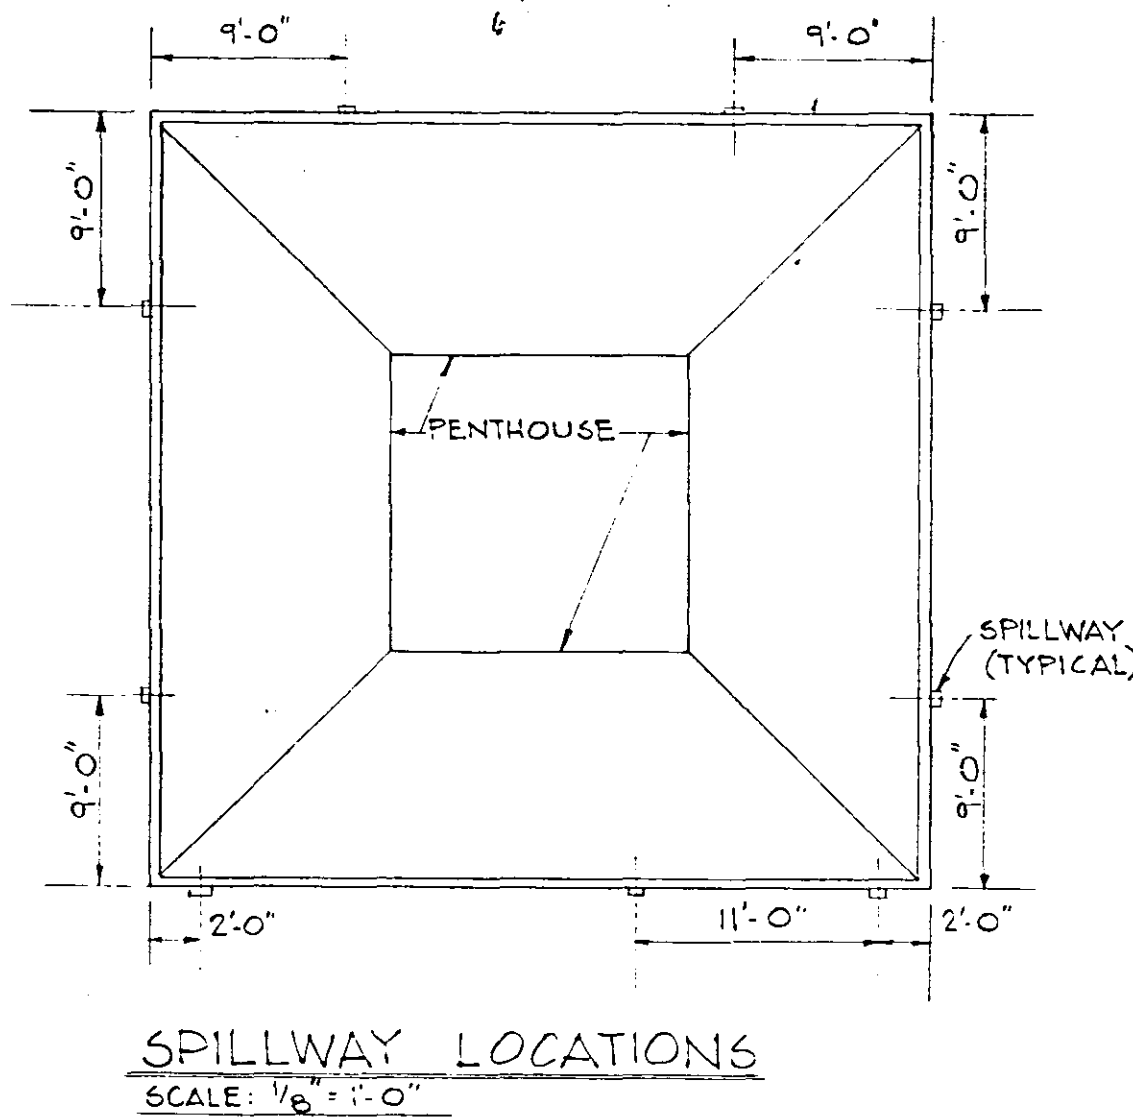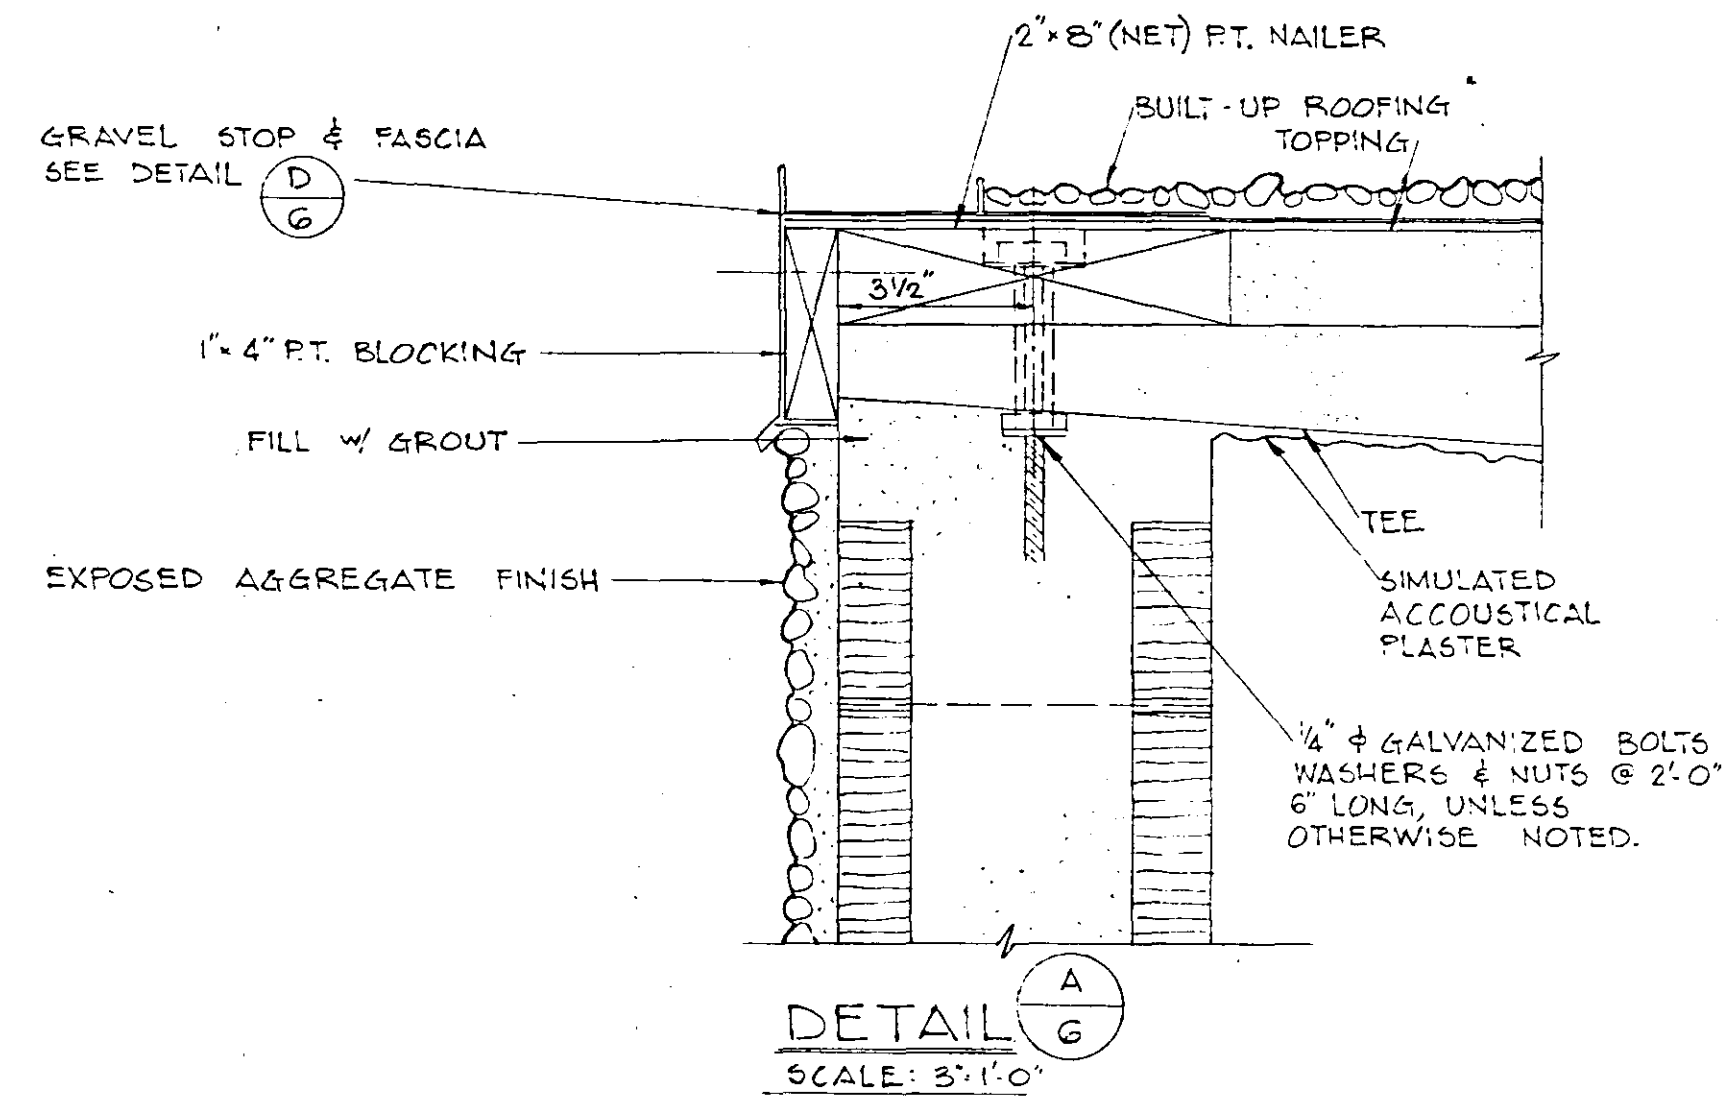

RECORD DRAWING			
NO.	DATE	DESCRIPTION	BY
REVISIONS			
RUSSELL & AXON Engineers - Planners - Architects			
DAYTONA BEACH, FLORIDA		FLORIDA	
SANITARY SEWERAGE PROJECT PART D SECTION III - MASTER LIFT STATION 1 D ARCH. - DETAILS			
MANATEE COUNTY, FLORIDA			
DESIGNED BY ROV/GER	FILE NO. 6681-8b	SHEET 6	
DRAWN BY RLB	CHECKED BY JWC	OF 23	SHEETS
DATE OCT. 1973	SCALE: AS SHOWN	REGISTERED ENGINEER	

RECORD DRAWING

DATE 7-26 BY RJM

CK. JKN 1809

SPACE FINISH SCHEDULE



ROOM DESCRIPTION	FLOOR		WAINSCOT		WALLS		CEILING		REMARKS
	CONCRETE CONC./PTD.	COLOR CODE	CONC./PTD. NONE	COLOR CODE	CONC./PTD. PAINTED RUBBED	COLOR CODE	CONC./PTD. EXR/PTD.	COLOR CODE	
OPERATING FLOOR	X	TERRA COTTA	X	B-306-5	X	B-320-5	X		
TOILET	X	TERRA COTTA	X	B-306-5	X	B-320-5	X		
CHLORINATOR ROOM	X	TERRA COTTA	X	B-306-5	X	B-320-5	X		
PUMP ROOM	X		X		X		X	WHITE	
WET WELL ENTRY	X		X		X	B-307-5	X		
WET WELL LOWER	X		X		X		X	WHITE	
CHLOR. CYLINDER STOR.	X		X		X		X	WHITE	#379 IVORY

CONC. - CONCRETE
 CMU PTD. - CONC. MASONRY UNIT - PAINTED
 S.A.P. - SPRAYED ACOUSTICAL PLASTER
 PLAS. PTD. - PLASTER PAINTED


DOOR SCHEDULE

MARK	SIZE	TYPE	MATERIAL	LITE	LOUVER	TH'D	LOCK	REMARKS
1	2'3"0" x 7'0" x 1 3/4"	A	METAL	25" x 30"	—	AL.	440	EA. LEAF, w/ BOLTS ON INACTIVE LEAF, OVERLAPPING ASTRAGAL
2	3'0" x 7'0" x 1 3/4"	C	METAL	25" x 30"	WALF	AL.	440	CLOSER #3541
3	3'0" x 7'0" x 1 3/4"	B	METAL	25" x 30"	—	AL.	440	
4	2'4" x 6'2" x 1 3/8"	D	METAL	—	18" x 12"	—	426	


ALL DOORS & FRAMES SHALL BE PAINTED #307 MEDIUM GRAY

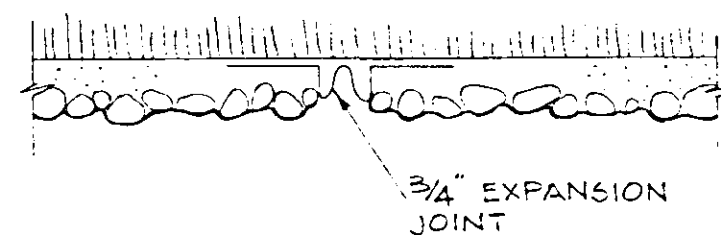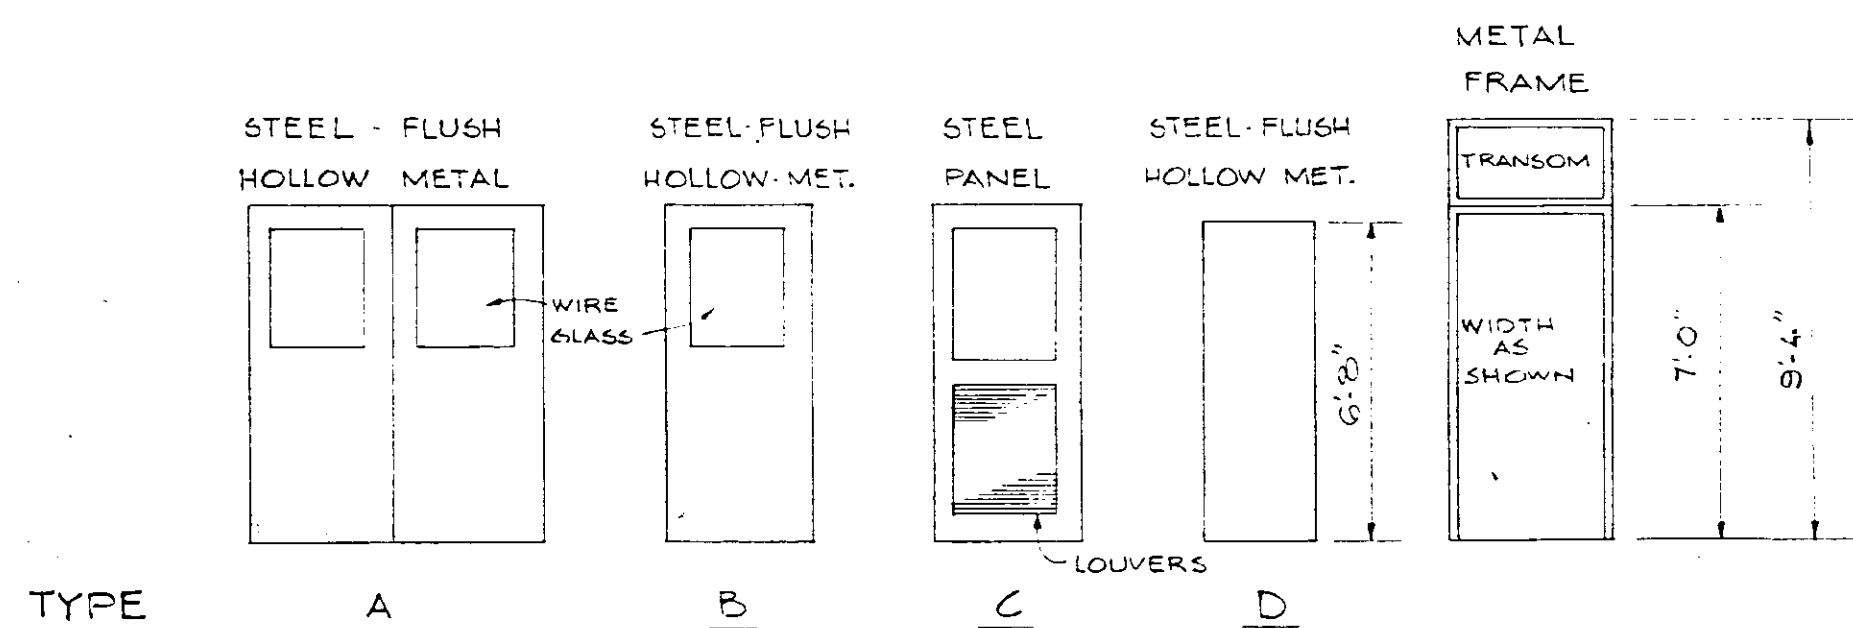

DETAIL H
 SCALE: 3/4" = 1'-0"

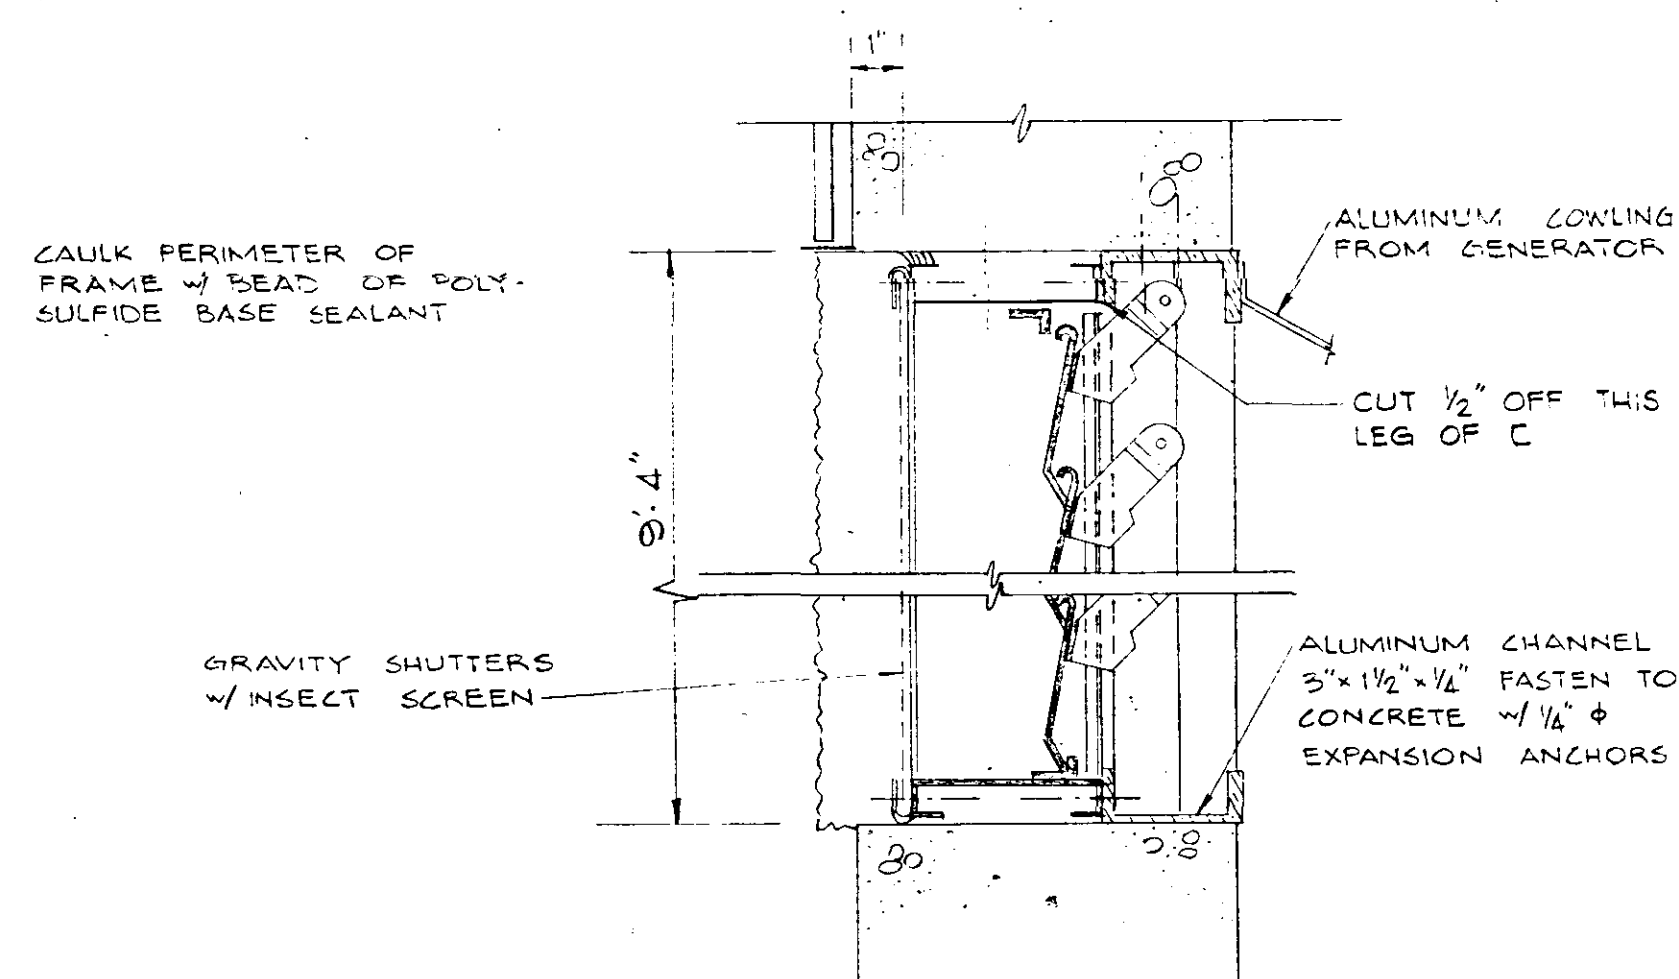


DETAIL J
 SCALE: 3/4" = 1'-0"

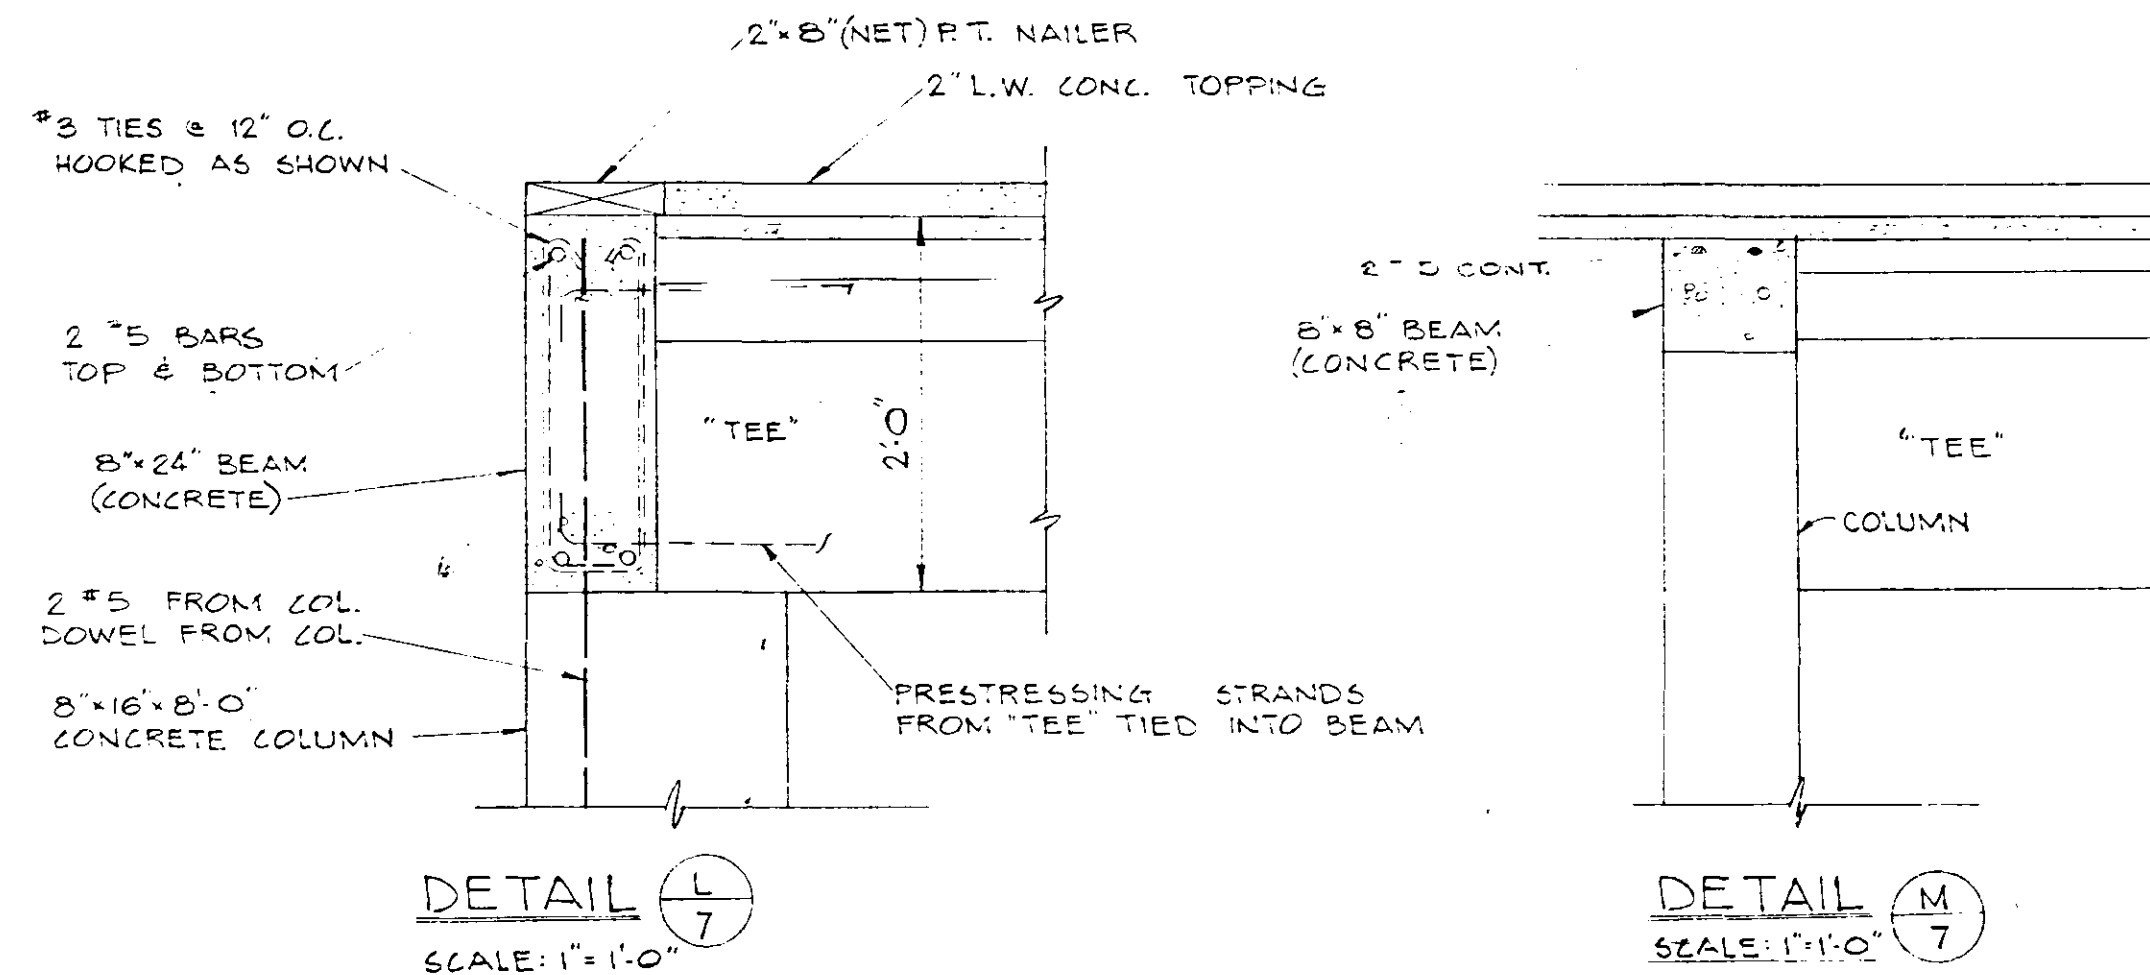

DETAIL L
 SCALE: 1" = 1'-0"

DETAIL M
 SCALE: 1" = 1'-0"

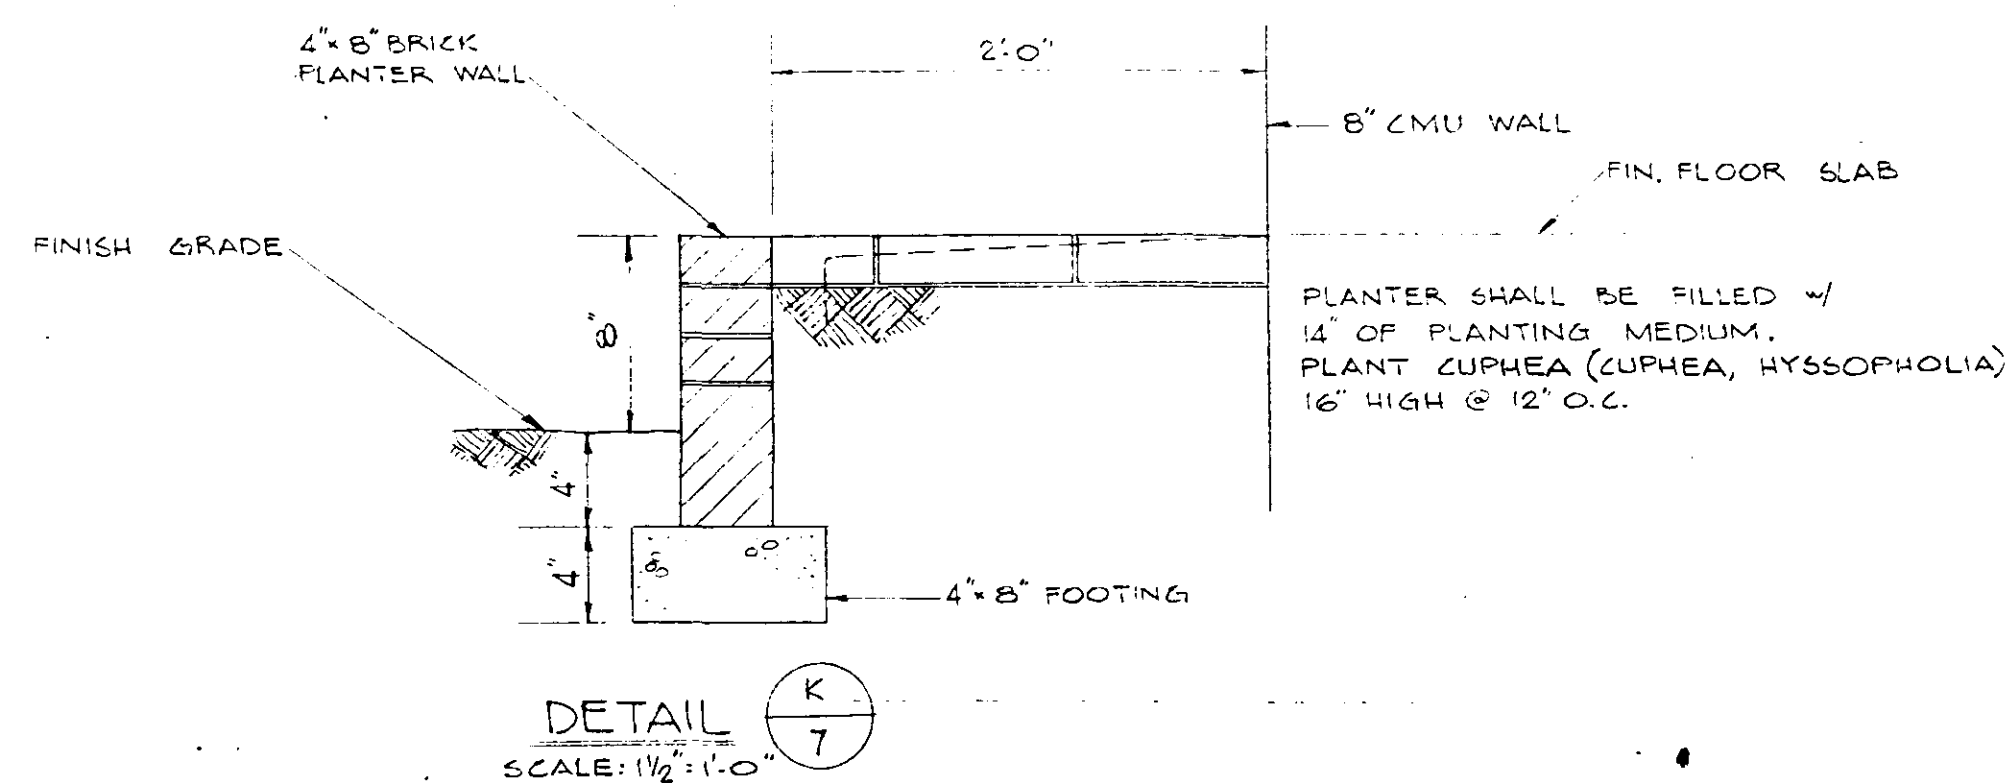


DETAIL K
 SCALE: 1 1/2" = 1'-0"

RECORD DRAWING



DATE 7-76 BY PSM

CK WKN 18-05

RECORD DRAWING		NO. DATE		DESCRIPTION		BY CKD.	
REVISIONS							
RUSSELL & AXON Engineers — Planners — Architects DAYTONA BEACH, FLORIDA							
SANITARY SEWERAGE PROJECT PART D SECTION III — MASTER LIFT STATION I.D. ARCH. SCHEDULES & DETAILS MANATEE COUNTY, FLORIDA							
DESIGNED BY ROV/GER	FILE NO. 6681 - 8b	SEAL JOHN W. CUMMING No. 9522 STATE OF FLORIDA REGISTERED ENGINEER					
DRAWN BY RLB	SHEET 7	OF 23 SHEETS					
CHECKED BY JWC 18/76	DATE OCT. 1973	SCALE: AS SHOWN					

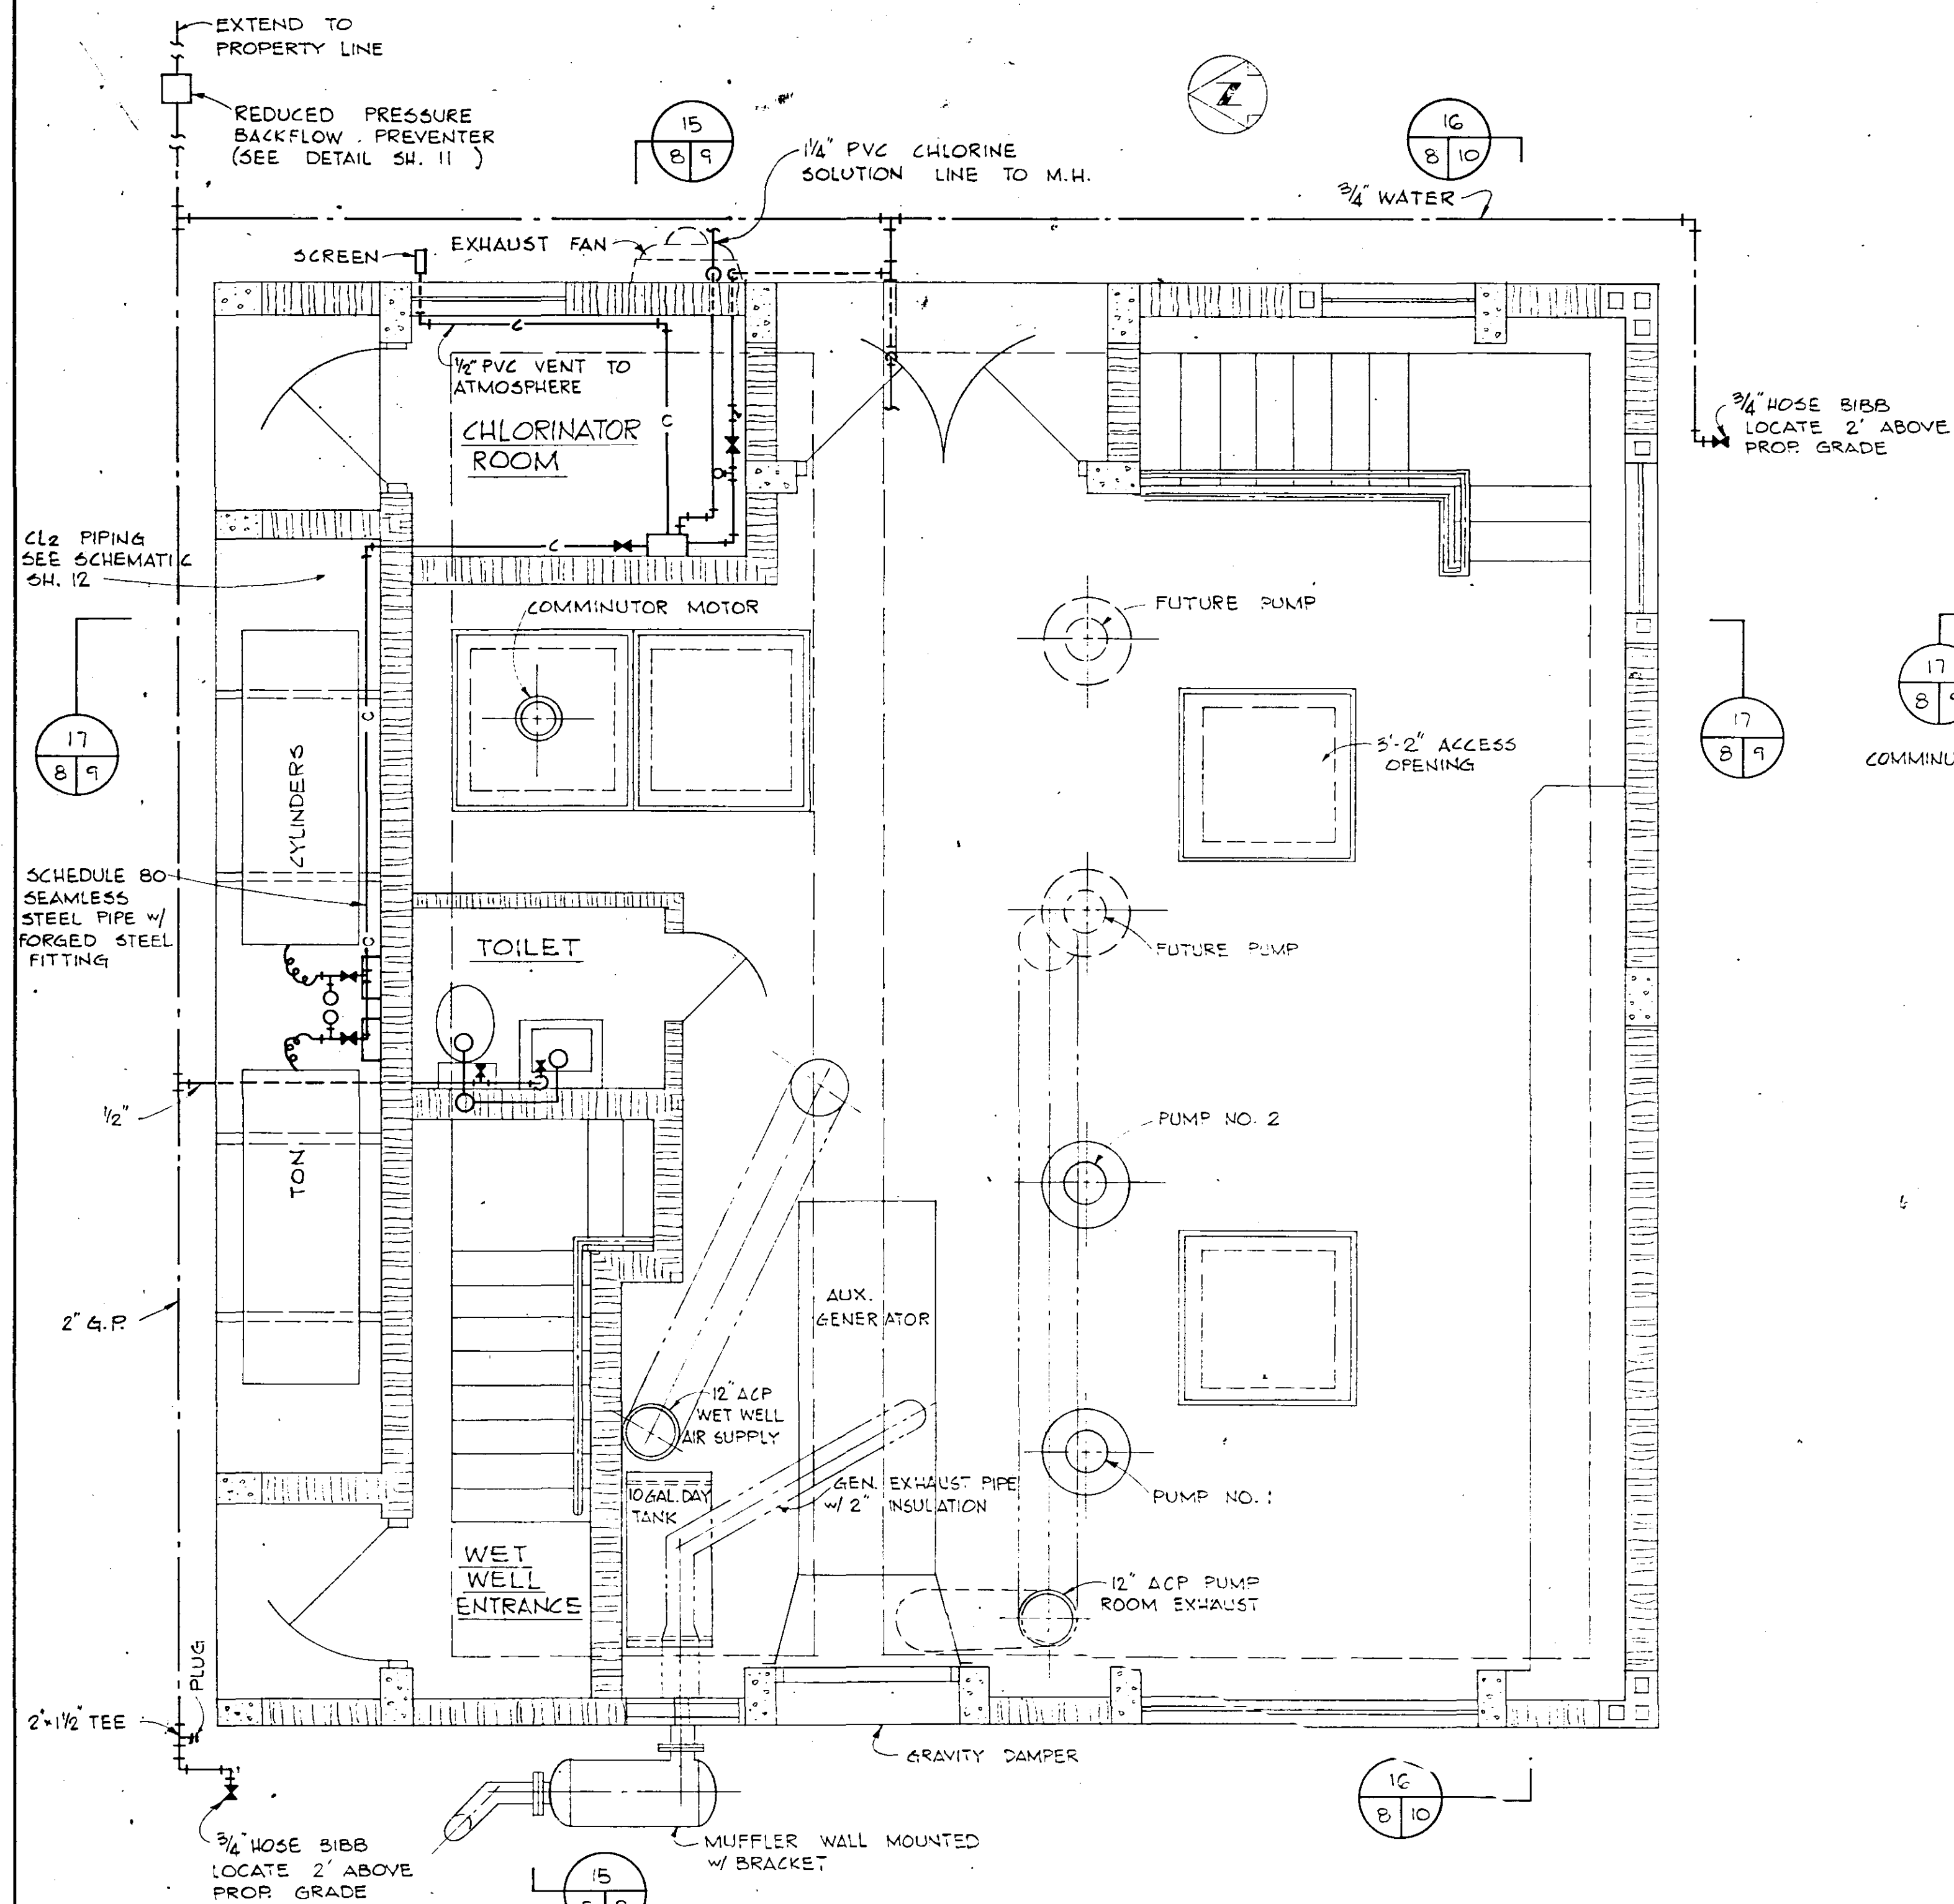

PLAN - OPERATING FLOOR

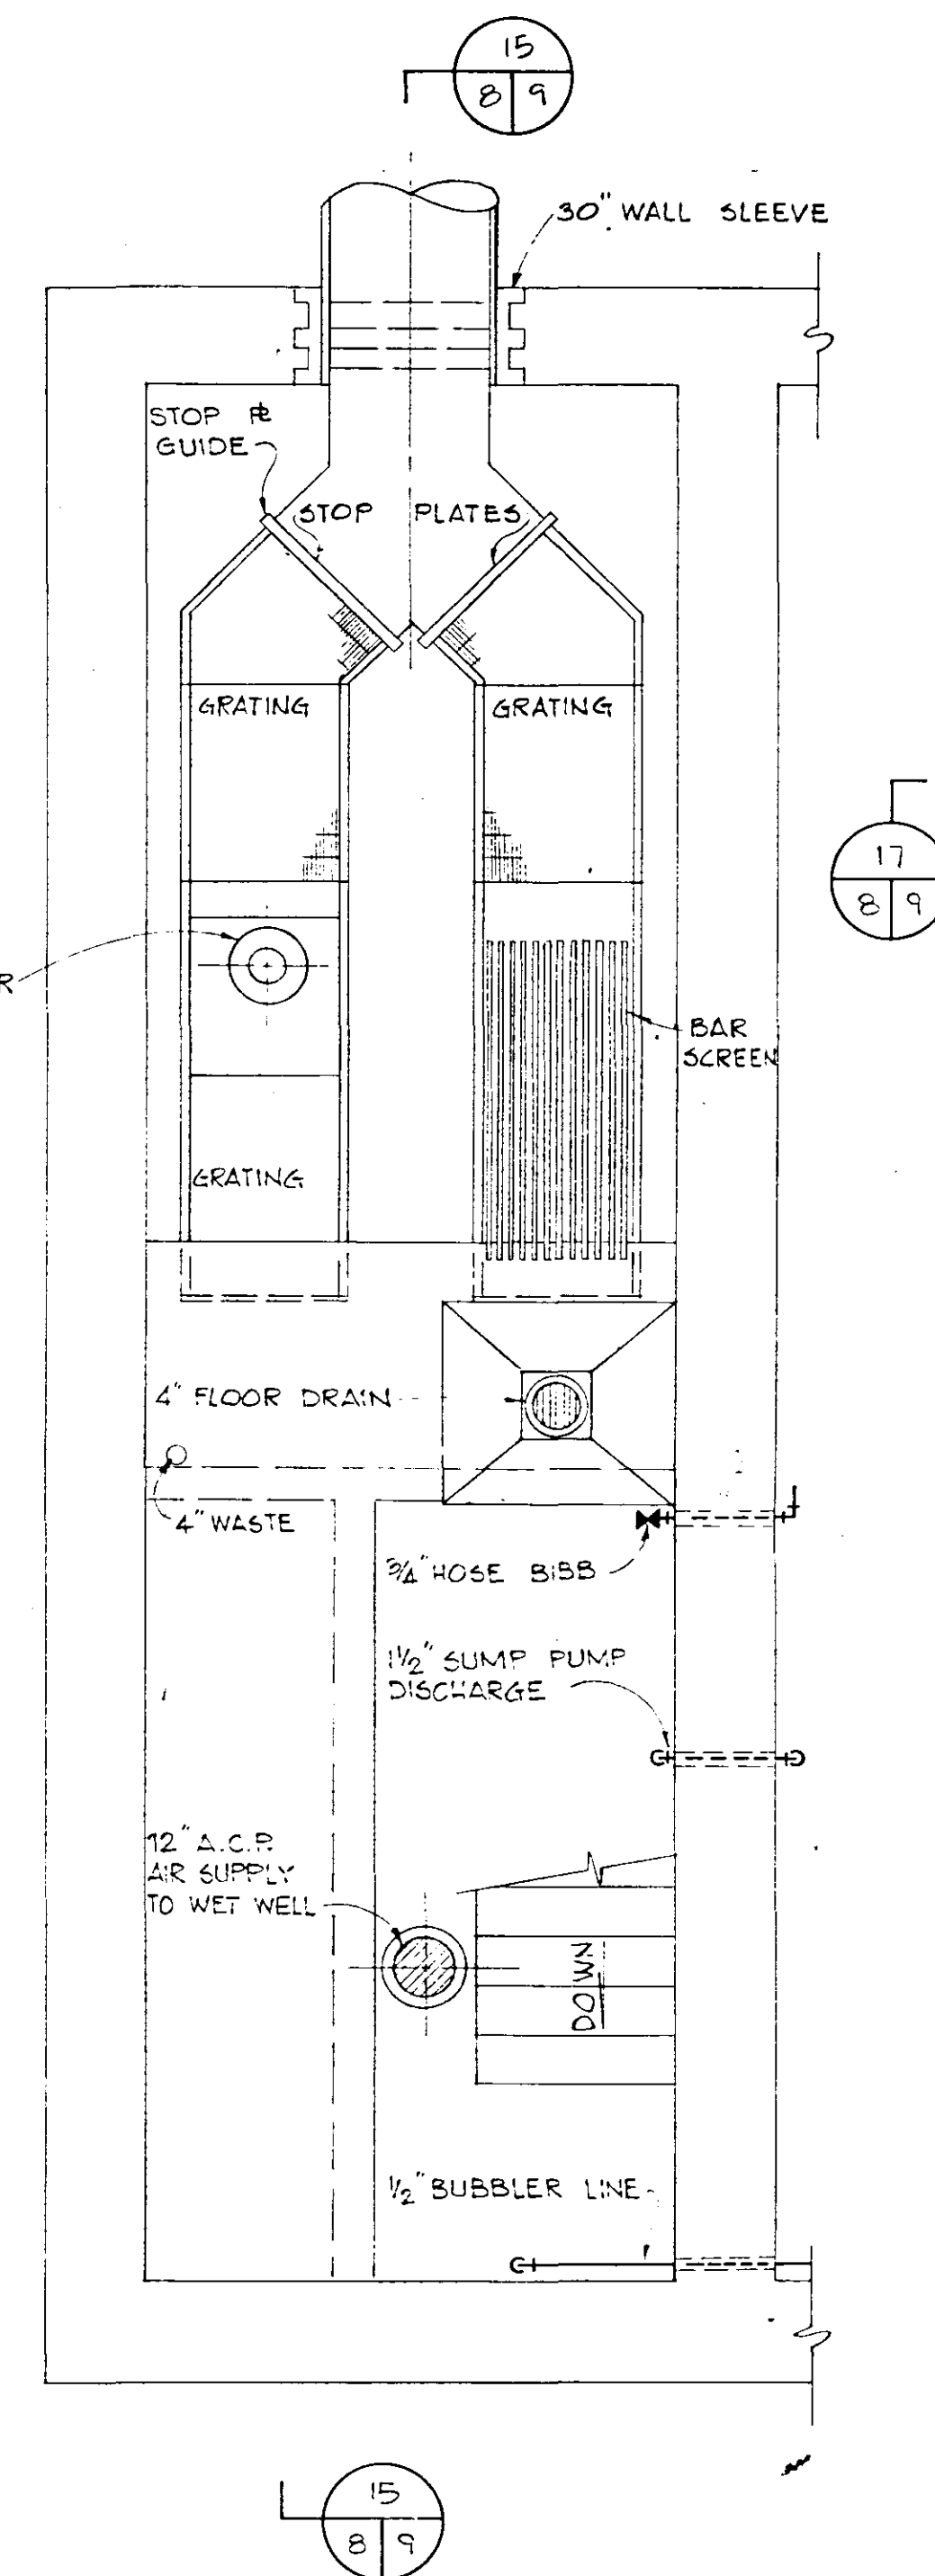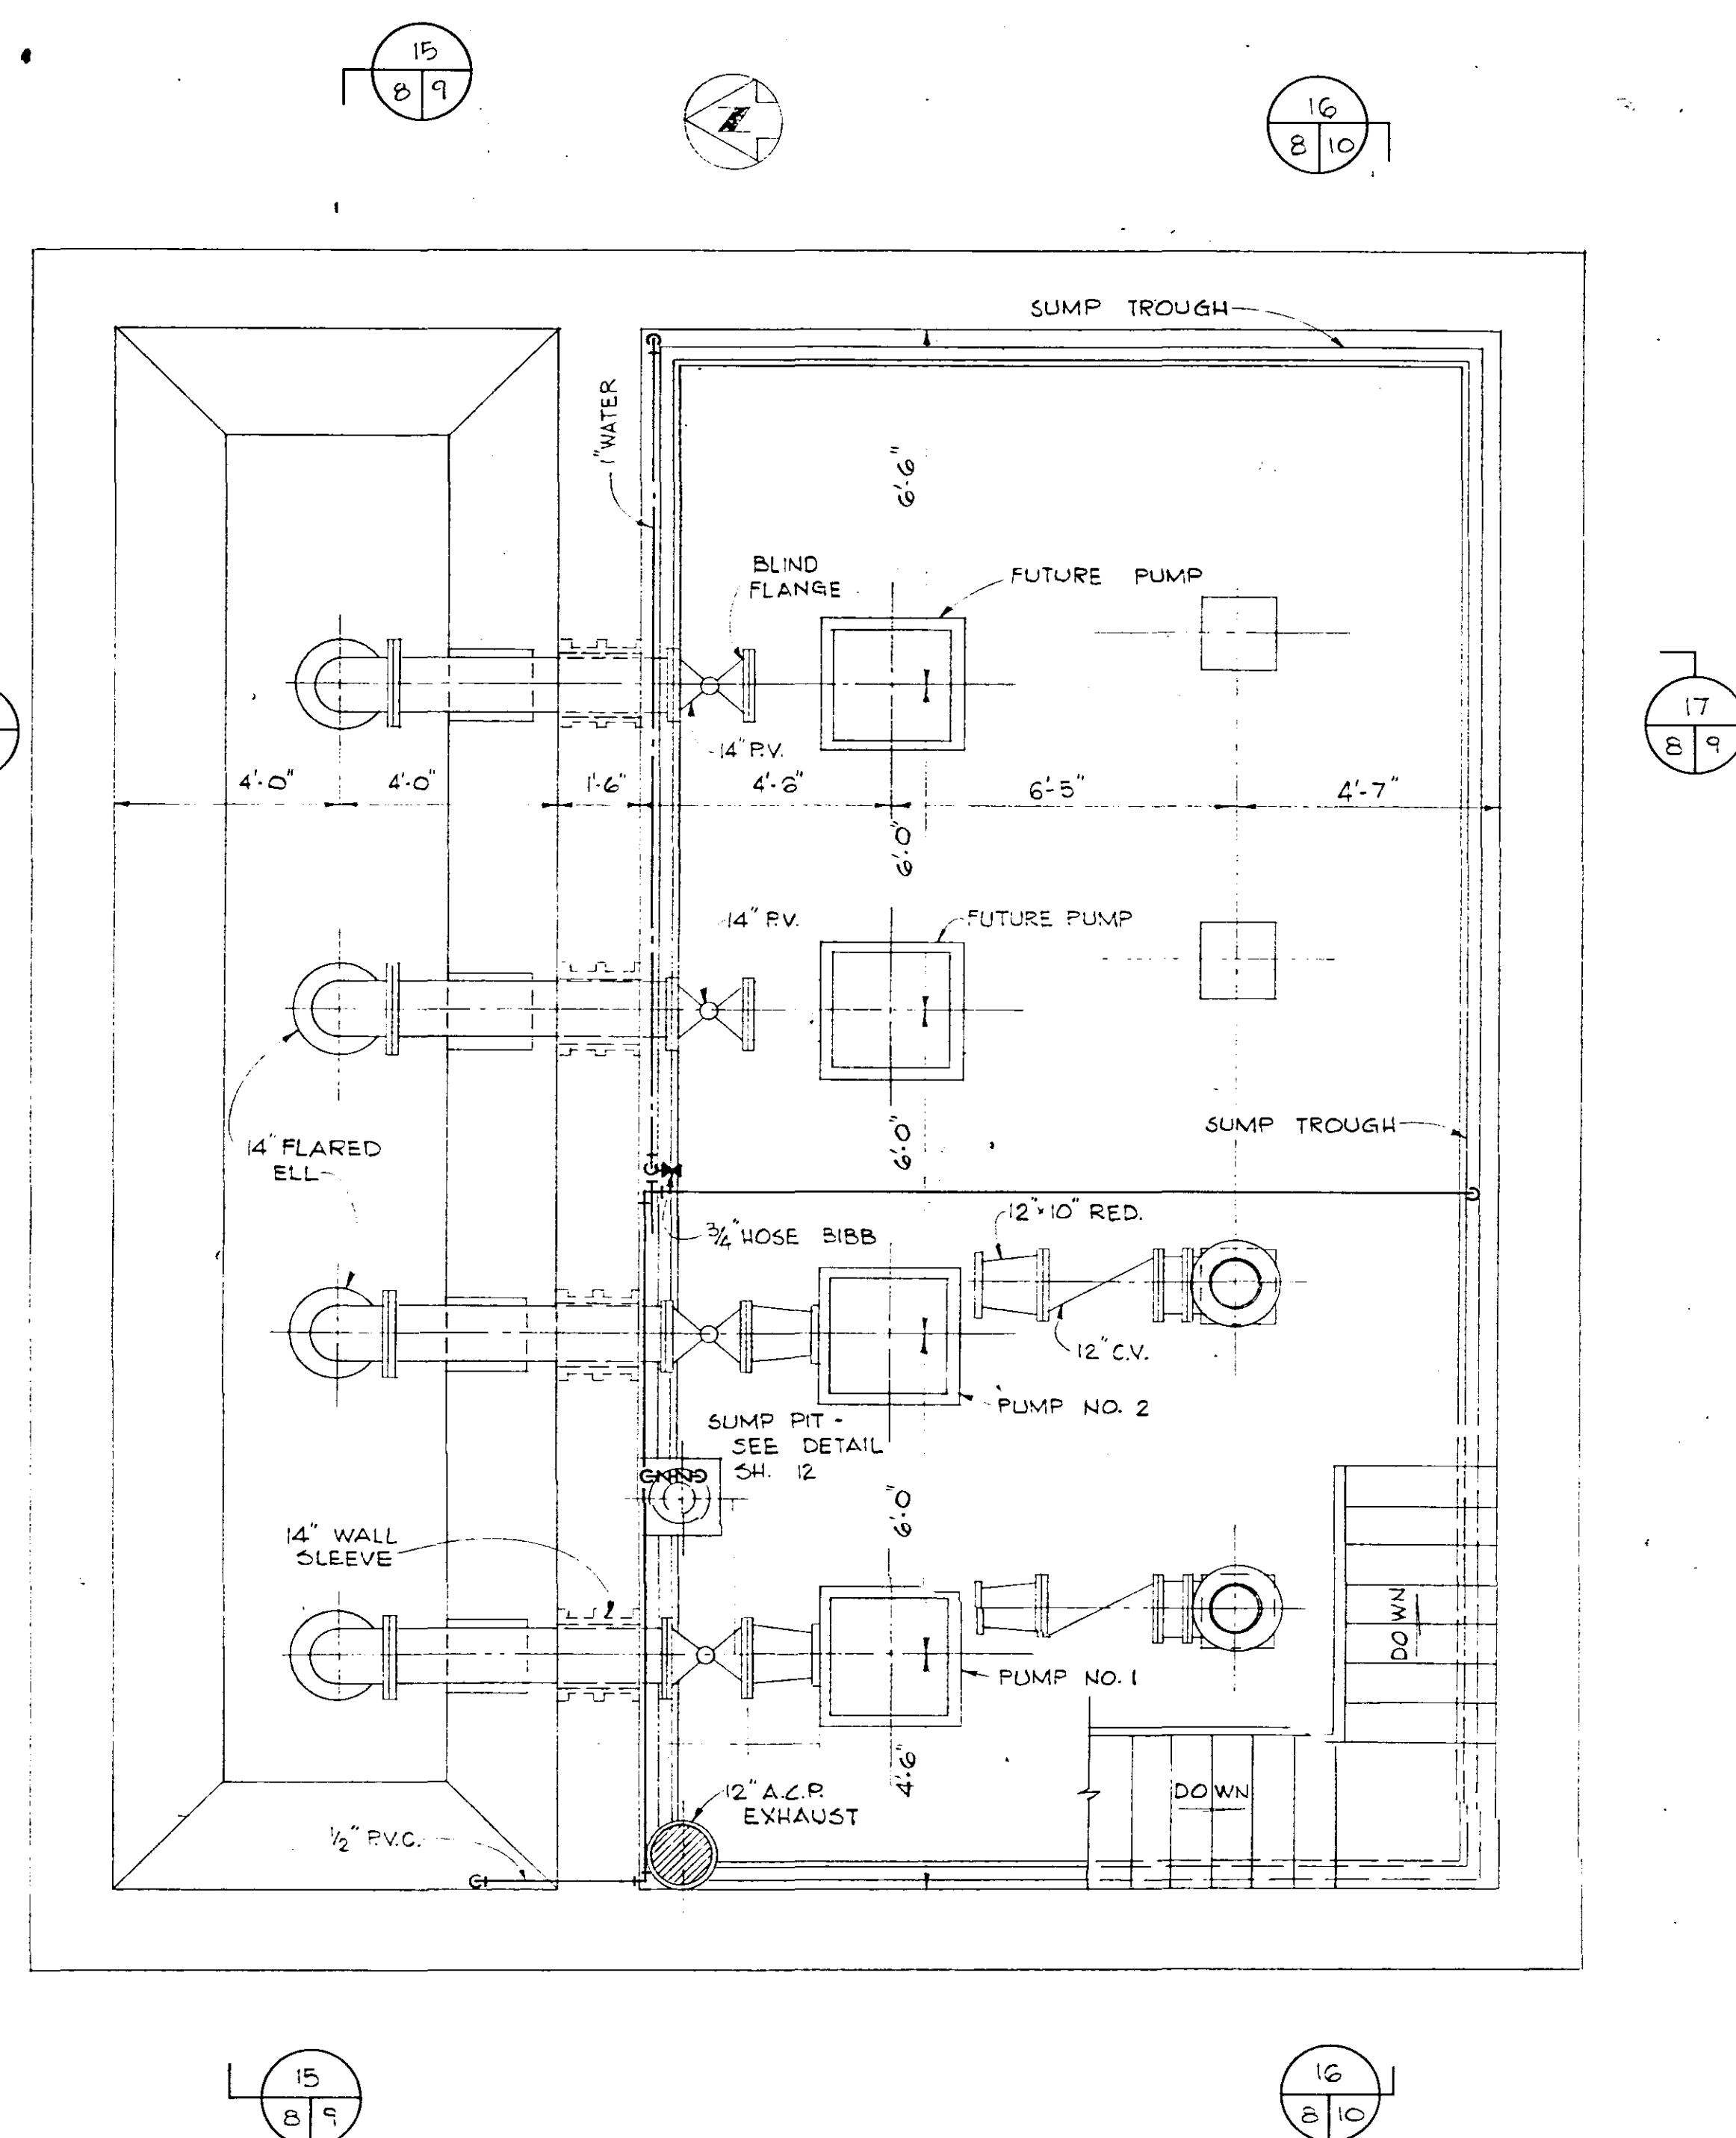PLAN - WET WELL
INTERMEDIATE LEVEL


PLAN - PUMP ROOM & WET WELL


RECORD DRAWING

DATE 7-76 BY PJM


CL 24KN 18-05

RECORD DRAWING			
NO.	DATE	DESCRIPTION	BY CKD.
REVISIONS			
RUSSELL & AXON Engineers — Planners — Architects DAYTONA BEACH, FLORIDA			
SANITARY SEWAGE PROJECT PART D SECTION III — MASTER LIFT STATION I D MECH. — FLOOR PLANS			
MANATEE COUNTY			
DESIGNED BY GER	FILE NO. 6681 - 8b		
DRAWN BY RUB	SHEET 8		
CHECKED BY JWC	OF 23 SHEETS		
DATE OCT. 1973	SCALE: 3/8" = 1'-0"		

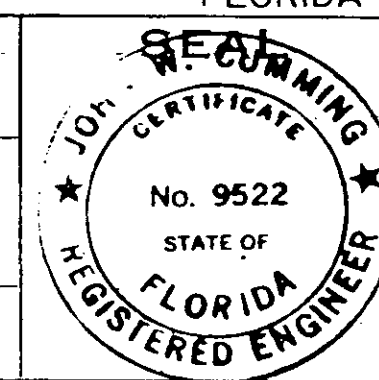

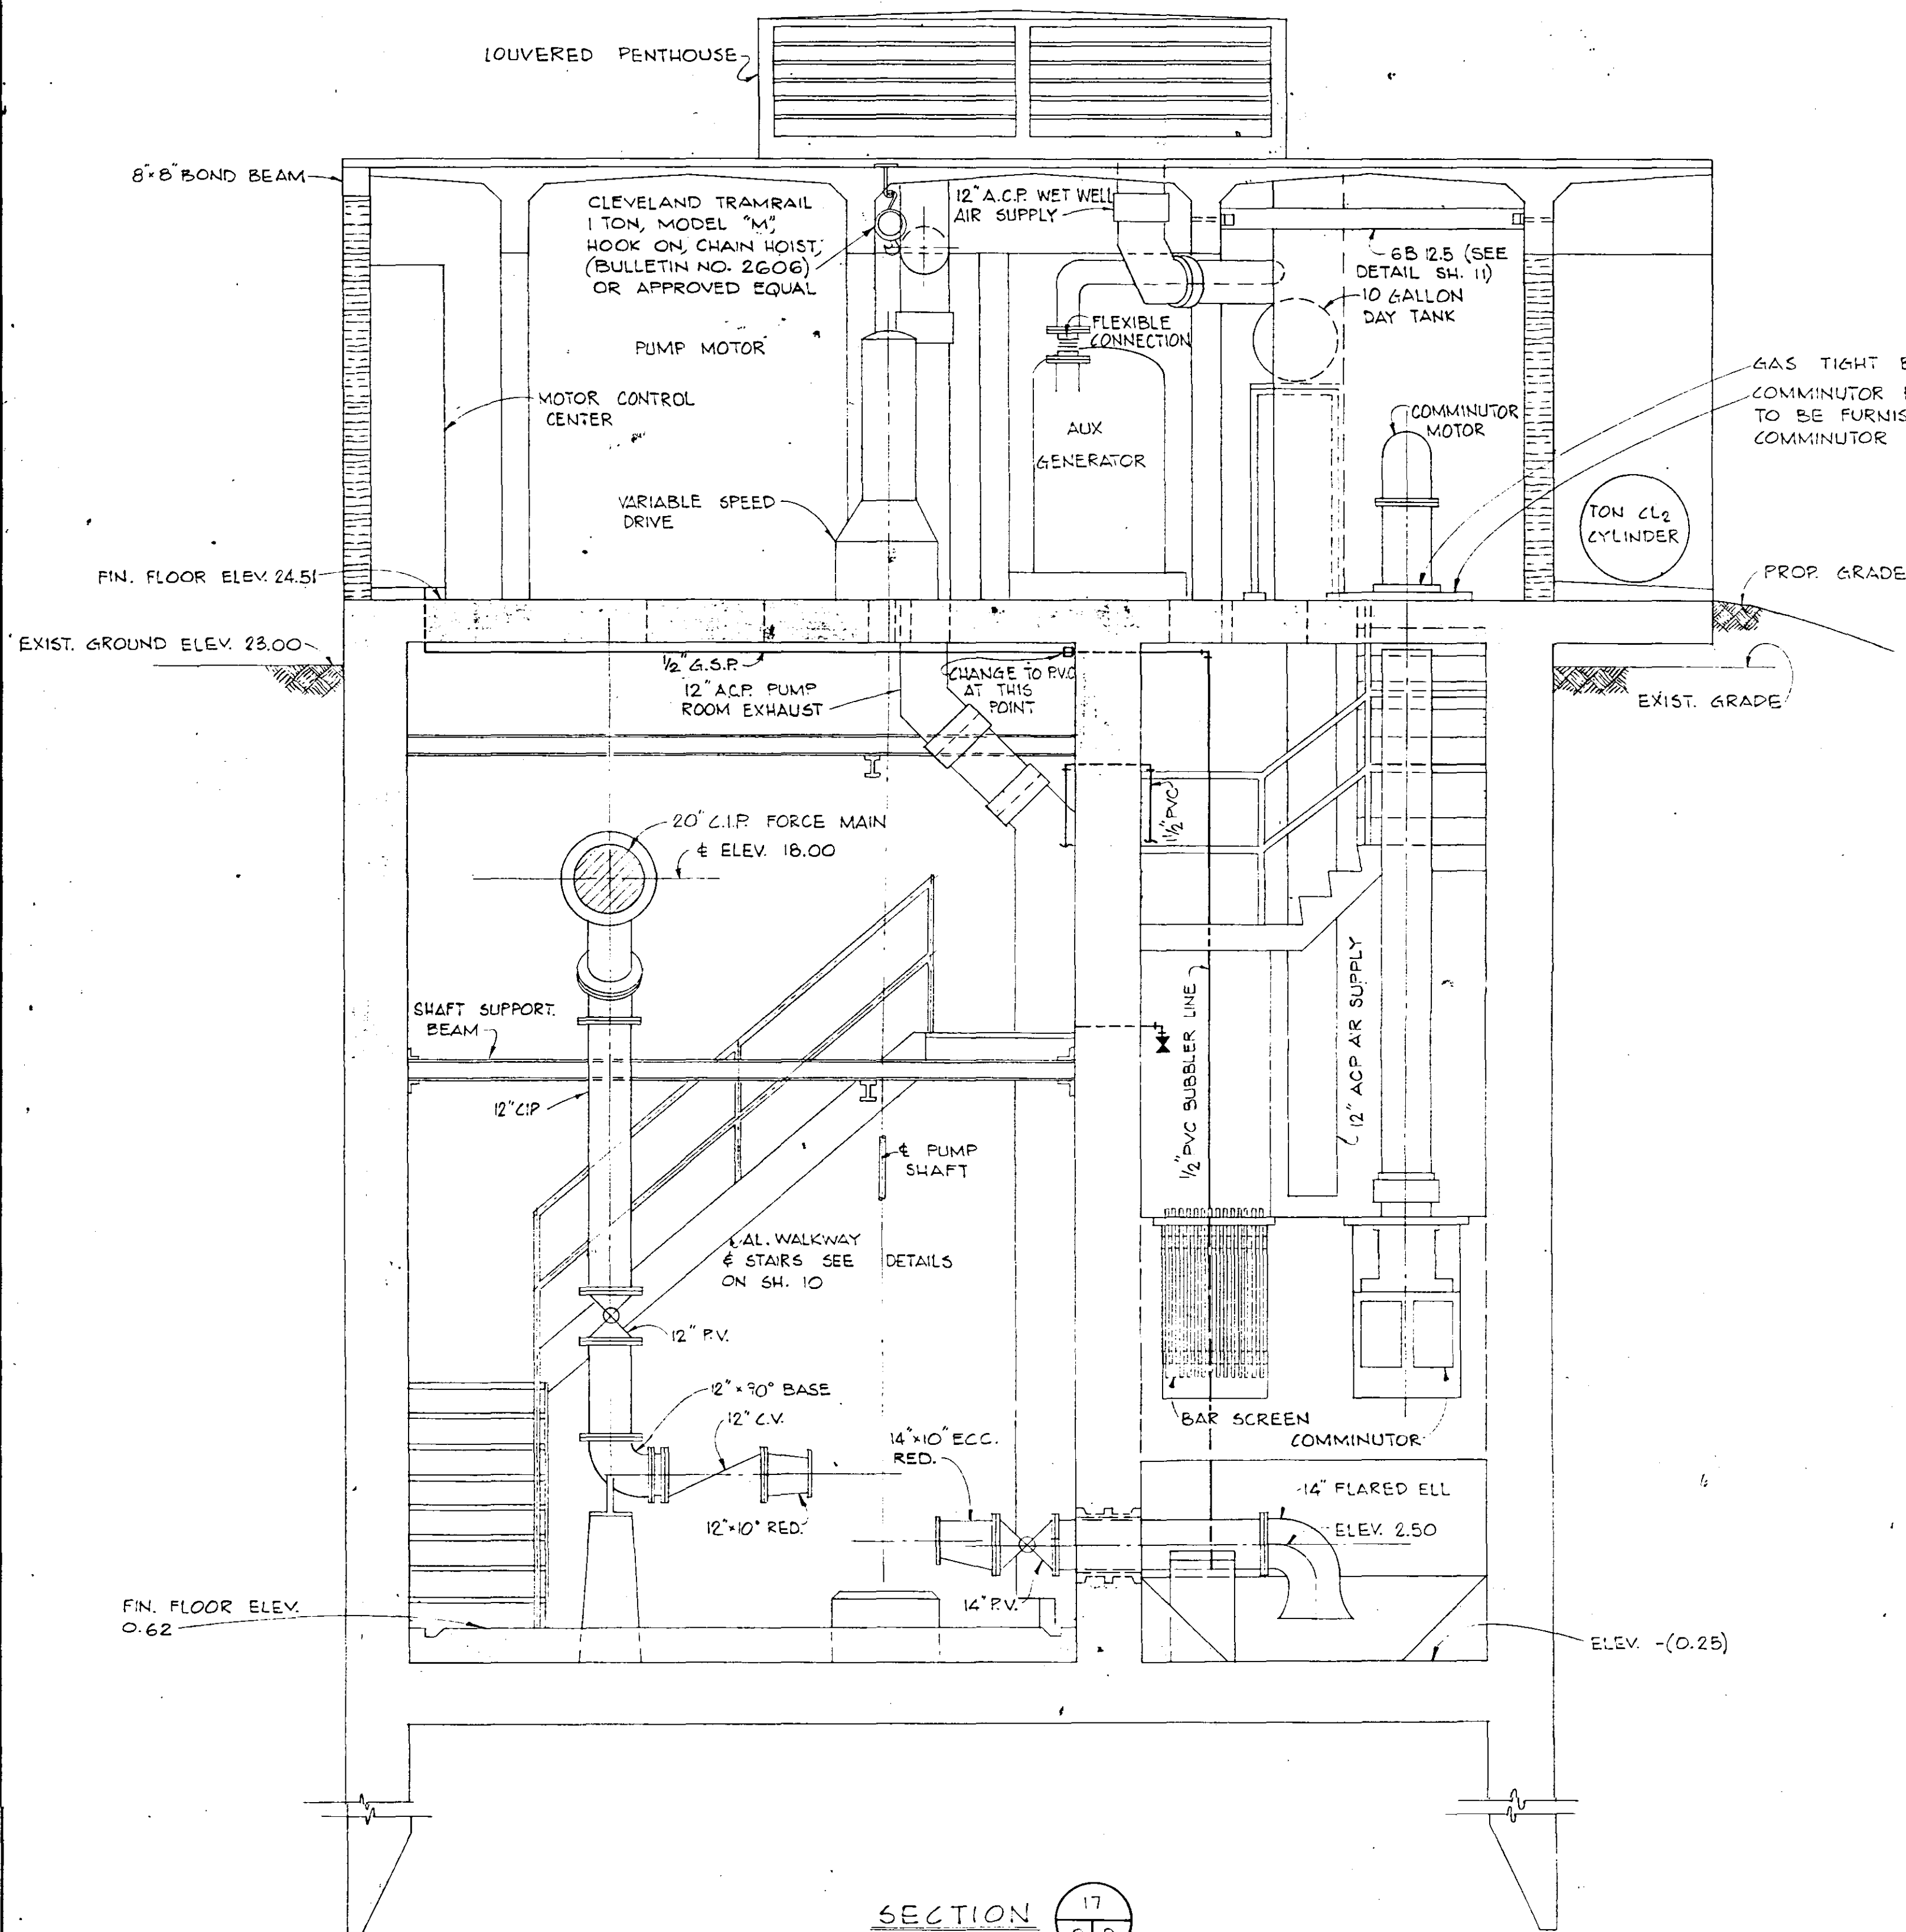

SECTION 17
8/9

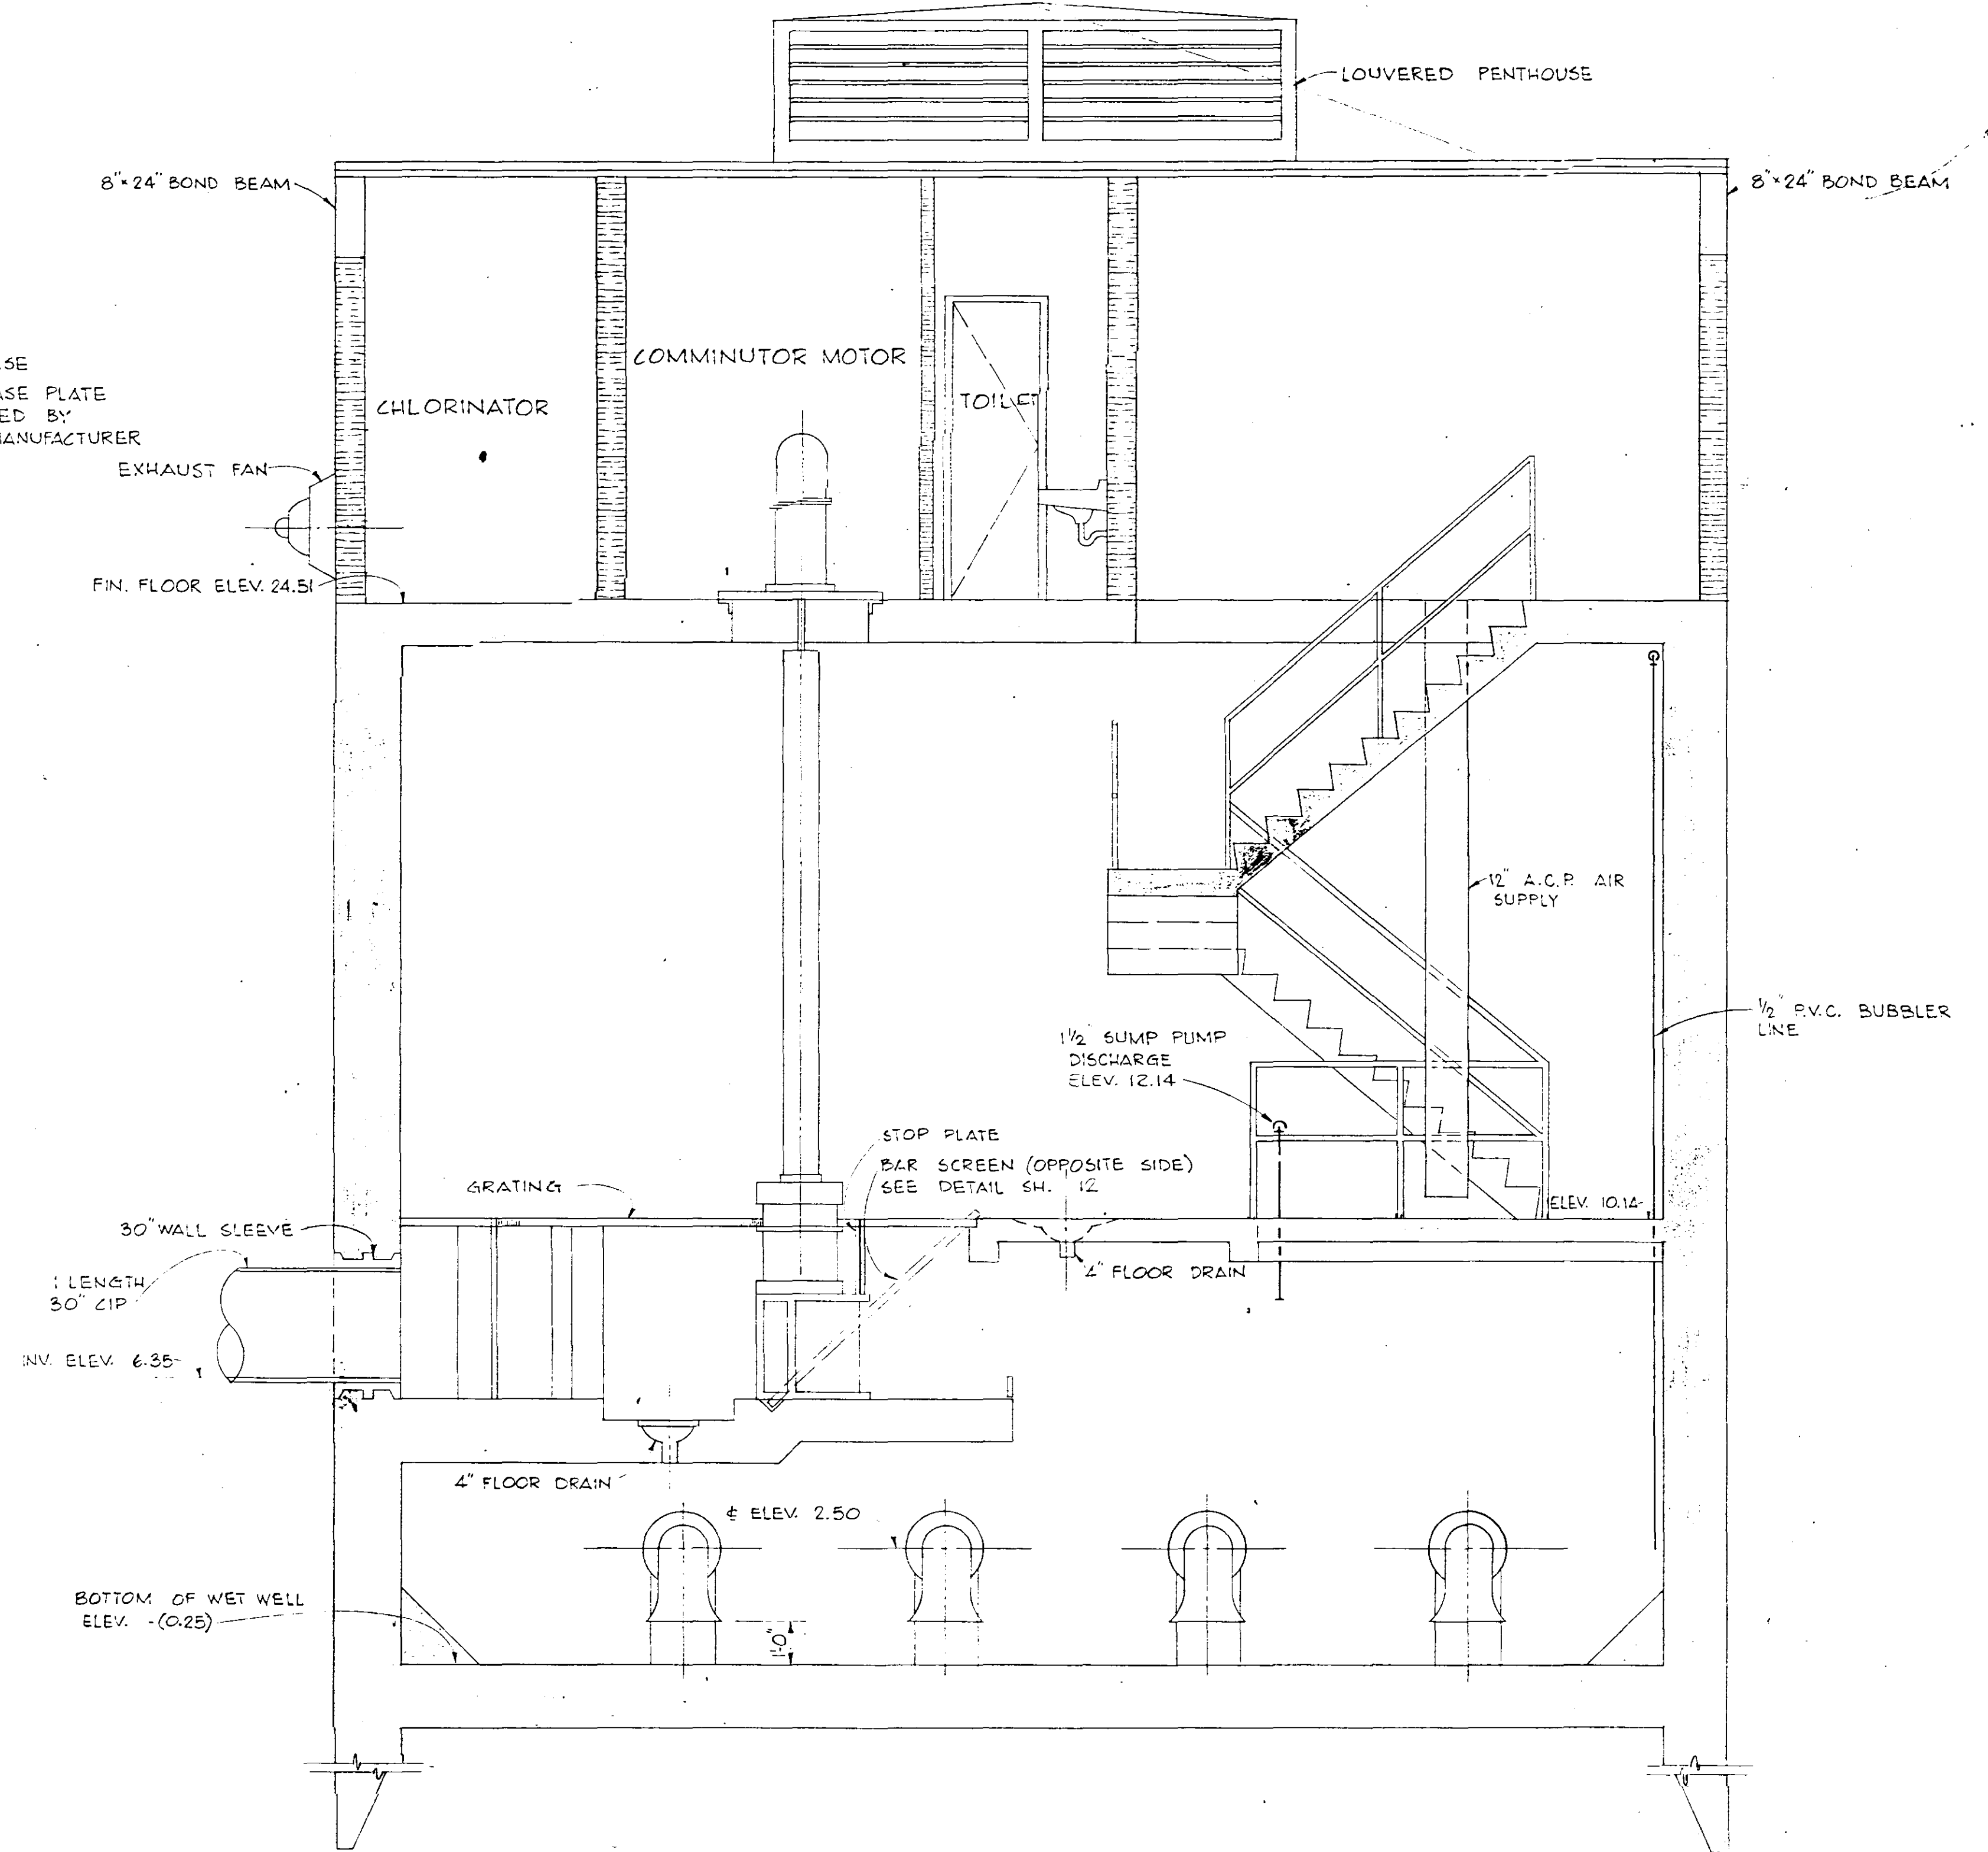


SECTION 15
8/9


RECORD DRAWING

DATE 7-76 BY R.J.M.

EX LWN 18-05

NO.	DATE	DESCRIPTION	BY	CKD.
7-76		REV. SUMP PUMP DISCHARGE ELEV.	RJM	ND
REVISIONS				
RUSSELL & AXON				
Engineers — Planners — Architects				
DAYTONA BEACH, FLORIDA				
SANITARY SEWERAGE PROJECT				
PART D				
SECTION III — MASTER LIFT STATION I.D.				
MECH. — SECTIONS				
MANATEE COUNTY, FLORIDA				
DESIGNED BY	FILE NO.			
GER	6681-8b			
DRAWN BY	SHEET			
RLB	9			
CHECKED BY	DATE			
JWC	OCT. 1973			
DATE	SCALE: 3/8" = 1'-0"			
OCT. 1973				

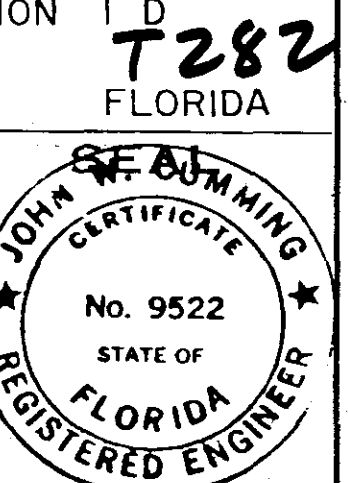

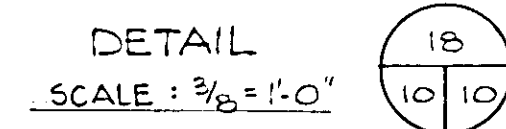


This mechanical floor plan illustrates the layout of a pump room, including the following components and specifications:


- Structural Elements:**
 - LOUVERED PENTHOUSE:** Located at the top of the plan.
 - 8"x24" BOND BEAM:** Runs along the top and right edges of the room.
 - 6 B 12.5:** Structural beam designation near the penthouse.
 - FIN. FLR. ELEV. 24.51** and **GR. ELEV. 23.00:** Elevation markers on the right side.
 - WALKWAY ELEV. 14.18:** Elevation for the central walkway.
 - ELEV. 5.92:** Elevation marker on the left side.
 - ELEV. 2.50:** Elevation marker near the bottom pumps.
 - ELEV. 0.62** and **ELEV. -(0.25):** Elevation markers at the bottom right.
- Piping and Equipment:**
 - 10 GAL. DAY TANK:** Located in the upper left.
 - 12" ACP WET WELL A/R SUPPLY GENERATOR EXHAUST PIPE w/ 1/2" INSULATION:** Pipe running from the day tank.
 - 12" ACP PUMP ROOM EXHAUST:** Exhaust pipe at the top center.
 - PUMP VARIABLE MOTOR SPEED AUX. GENERATOR:** Two units labeled **NO. 1** and **NO. 2**.
 - 8" C 5.62 (AL):** and **6" W F 7.85 (AL.):** Structural beam designations.
 - 12"x12" WYE, 16"x12" RED., 16"x12" WYE, 20"x16" RED., 20"x12" WYE, 20"x12" WYE:** Various pipe fittings and connections.
 - 12"x45" BEND:** A pipe bend in the central area.
 - 20" PLUG VALVE & BOX:** Located on the right side.
 - 12" C.I.P. (Cast Iron Pipe):** Vertical pipes connecting to pumps.
 - 12" P.V. (Pressure Valve):** Valves on the vertical pipes.
 - BLIND FLANGE & COMPANION FLANGE:** Connections for the vertical pipes.
 - 6" C.I.P. and 6" COMPANION FLANGE:** Smaller pipe connections at the bottom.
- Other Details:**
 - EYE BOLT HANGER SEE DETAIL GK. 11:** Hangers for the horizontal beams.
 - 12"x90° BASE:** Base for the pump shaft.
 - 12" PUMP SHAFT:** Vertical shaft for the pumps.

 JAN. 74		RECORD DRAWING ADDED 1 (ONE) EYE BOLT HANGER RLB		N.D. 1-1-74	
NO.	DATE	DESCRIPTION			BY CKD.
REVISIONS					
_____ RUSSELL & AXON _____ Engineers — Planners — Architects					
DAYTONA BEACH,			FLORIDA		
SANITARY SEWERAGE PROJECT PART D SECTION III—MASTER LIFT STATION 1 D MECH.—SECTION & MISC. DETAILS					
MANATEE COUNTY,			T283 FLORIDA		
DESIGNED BY GER		FILE NO.			
DRAWN BY RLB		6681-8b			
CHECKED BY JWC for RLB		SHEET			
DATE OCT. 1973		No. (10)		SHEETS	
		SCALE: AS SHOWN			


CR LKN 18-05

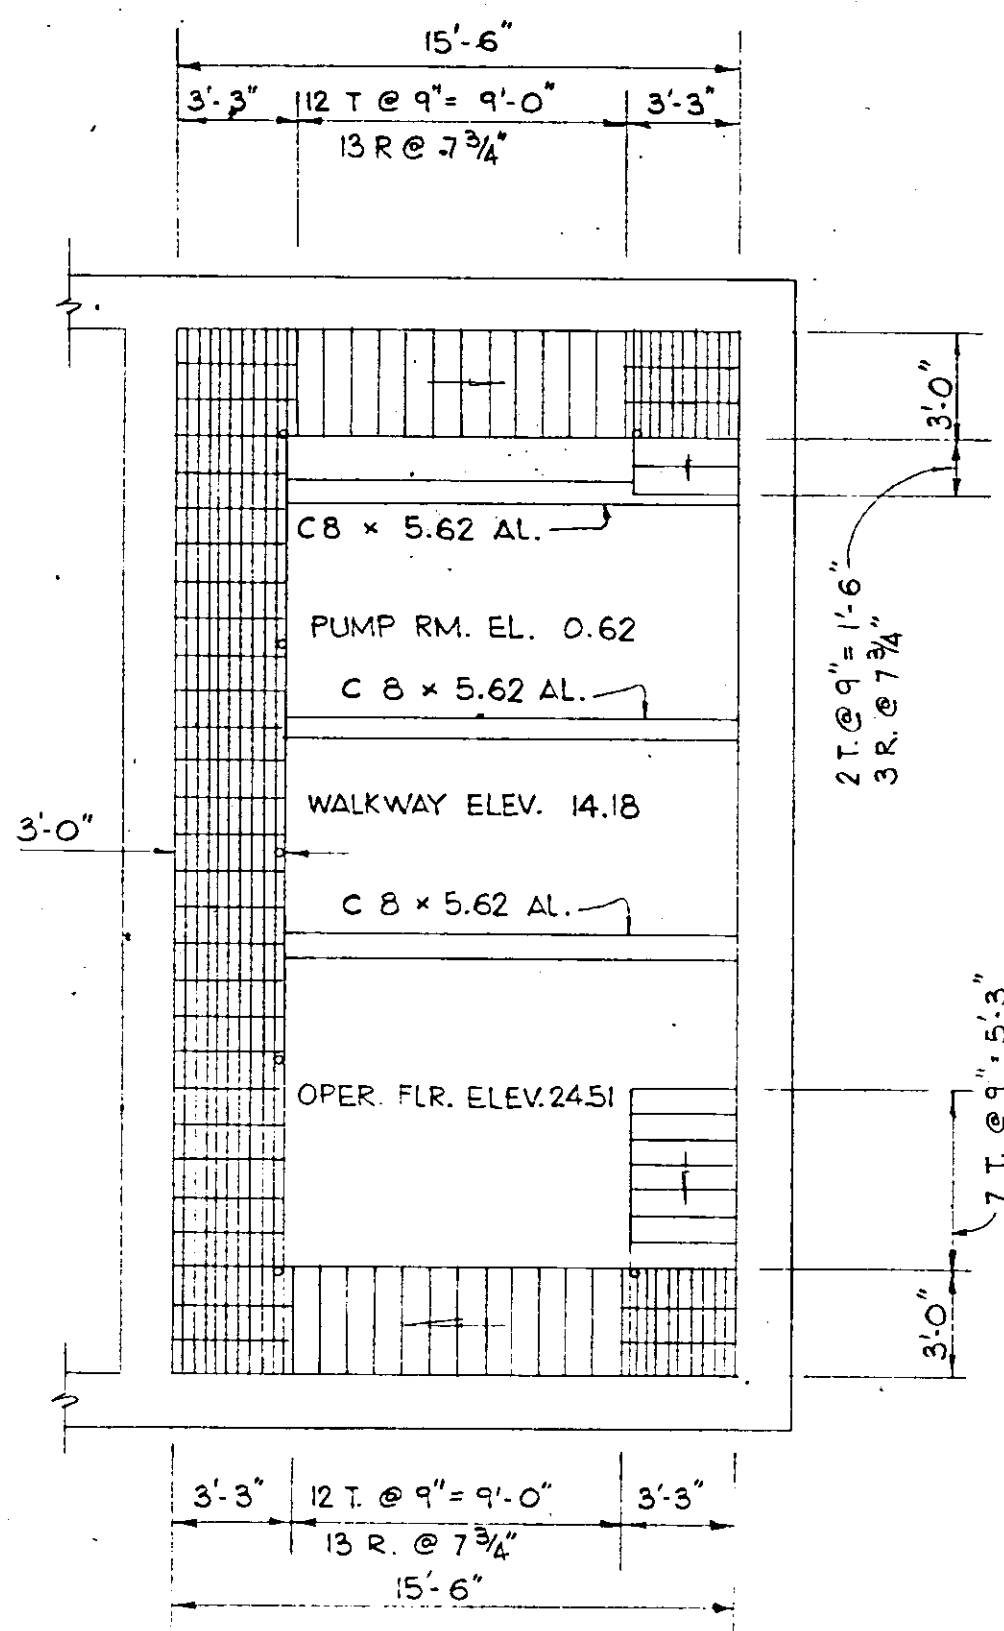


PLAN VIEW - ALUMINUM STAIRS & WALKWAY
SCALE: 3/16" = 1'-0"

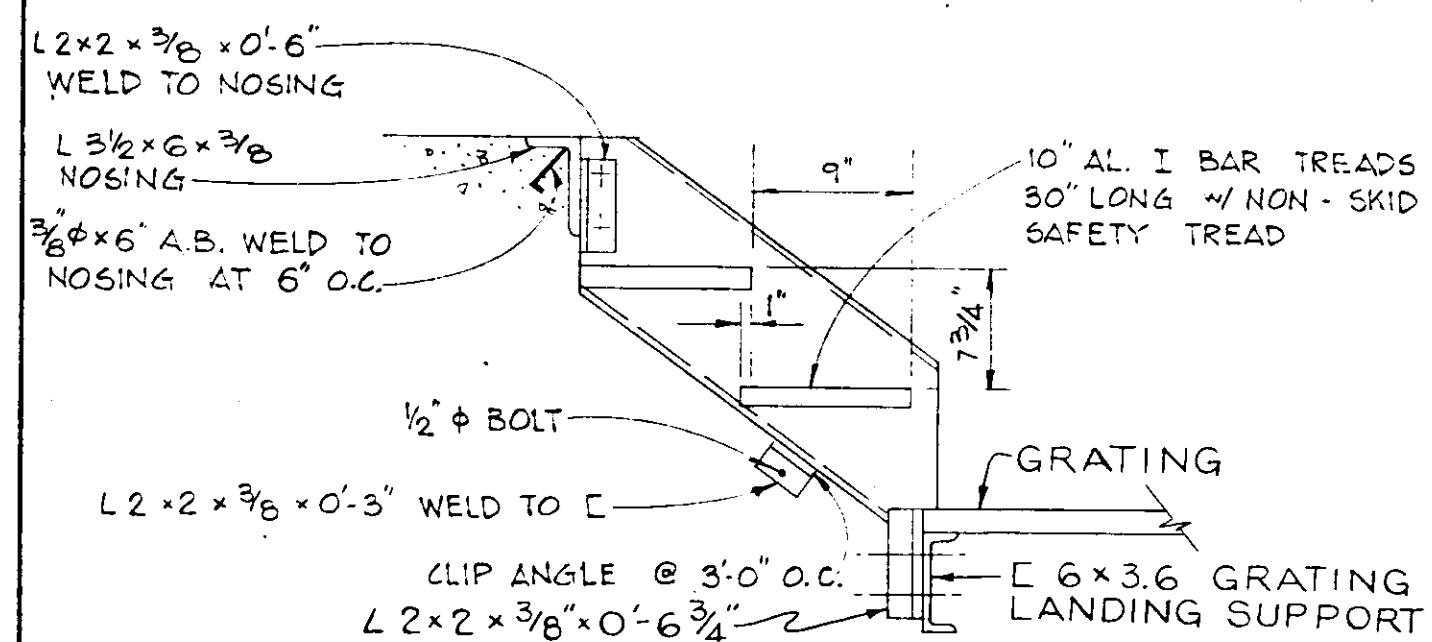


CONC. FL. TO AL. GRATING
AL. STAIR DETAIL
SCALE: 1" = 1'-0"

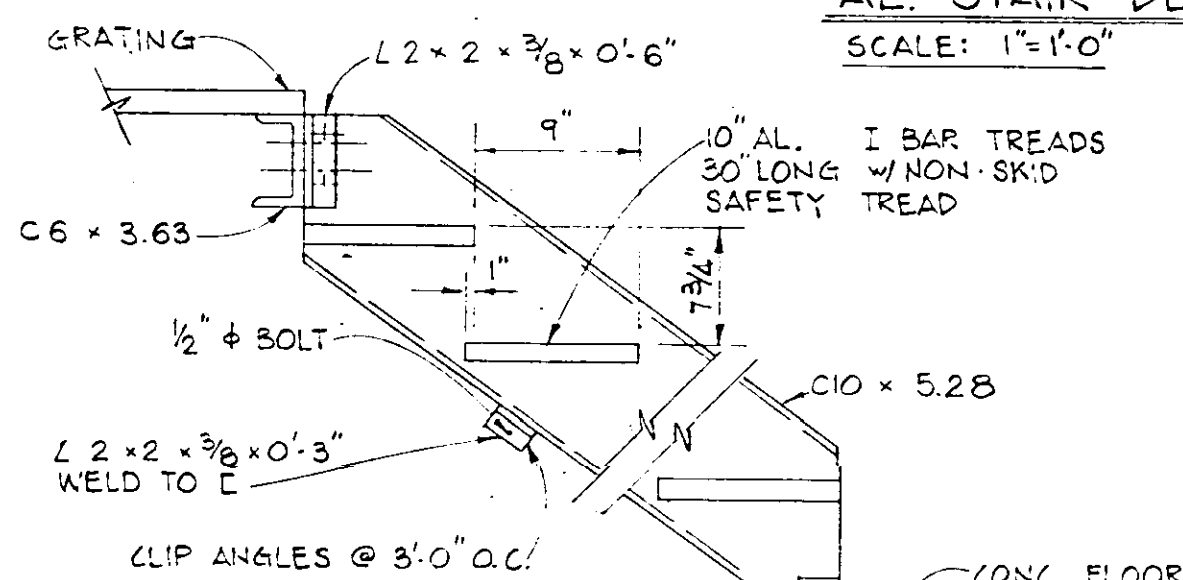


AL. GRATING TO AL. GRATING
AL. STAIR DETAIL
SCALE: 1" = 1'-0"

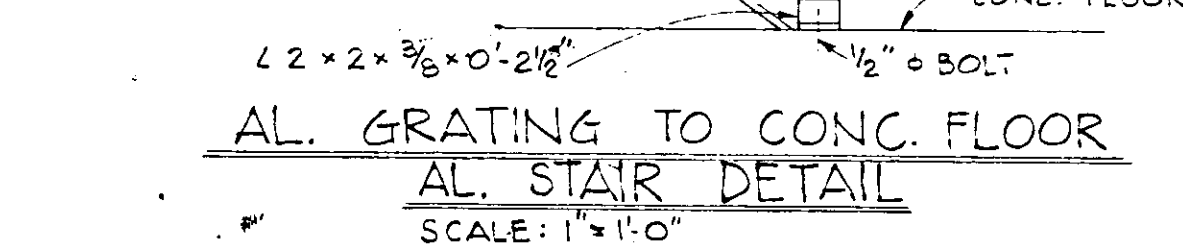


AL. GRATING TO CONC. FLOOR
AL. STAIR DETAIL
SCALE: 1" = 1'-0"

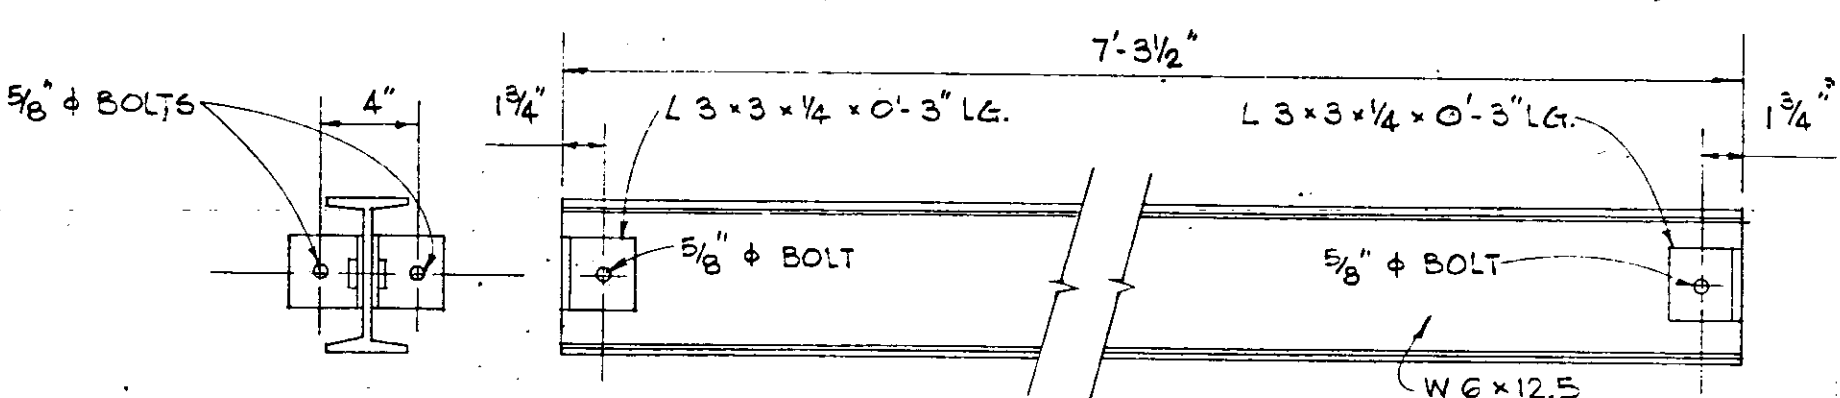


6B125 STEEL BEAM
SCALE: 1 1/2" = 1'-0"

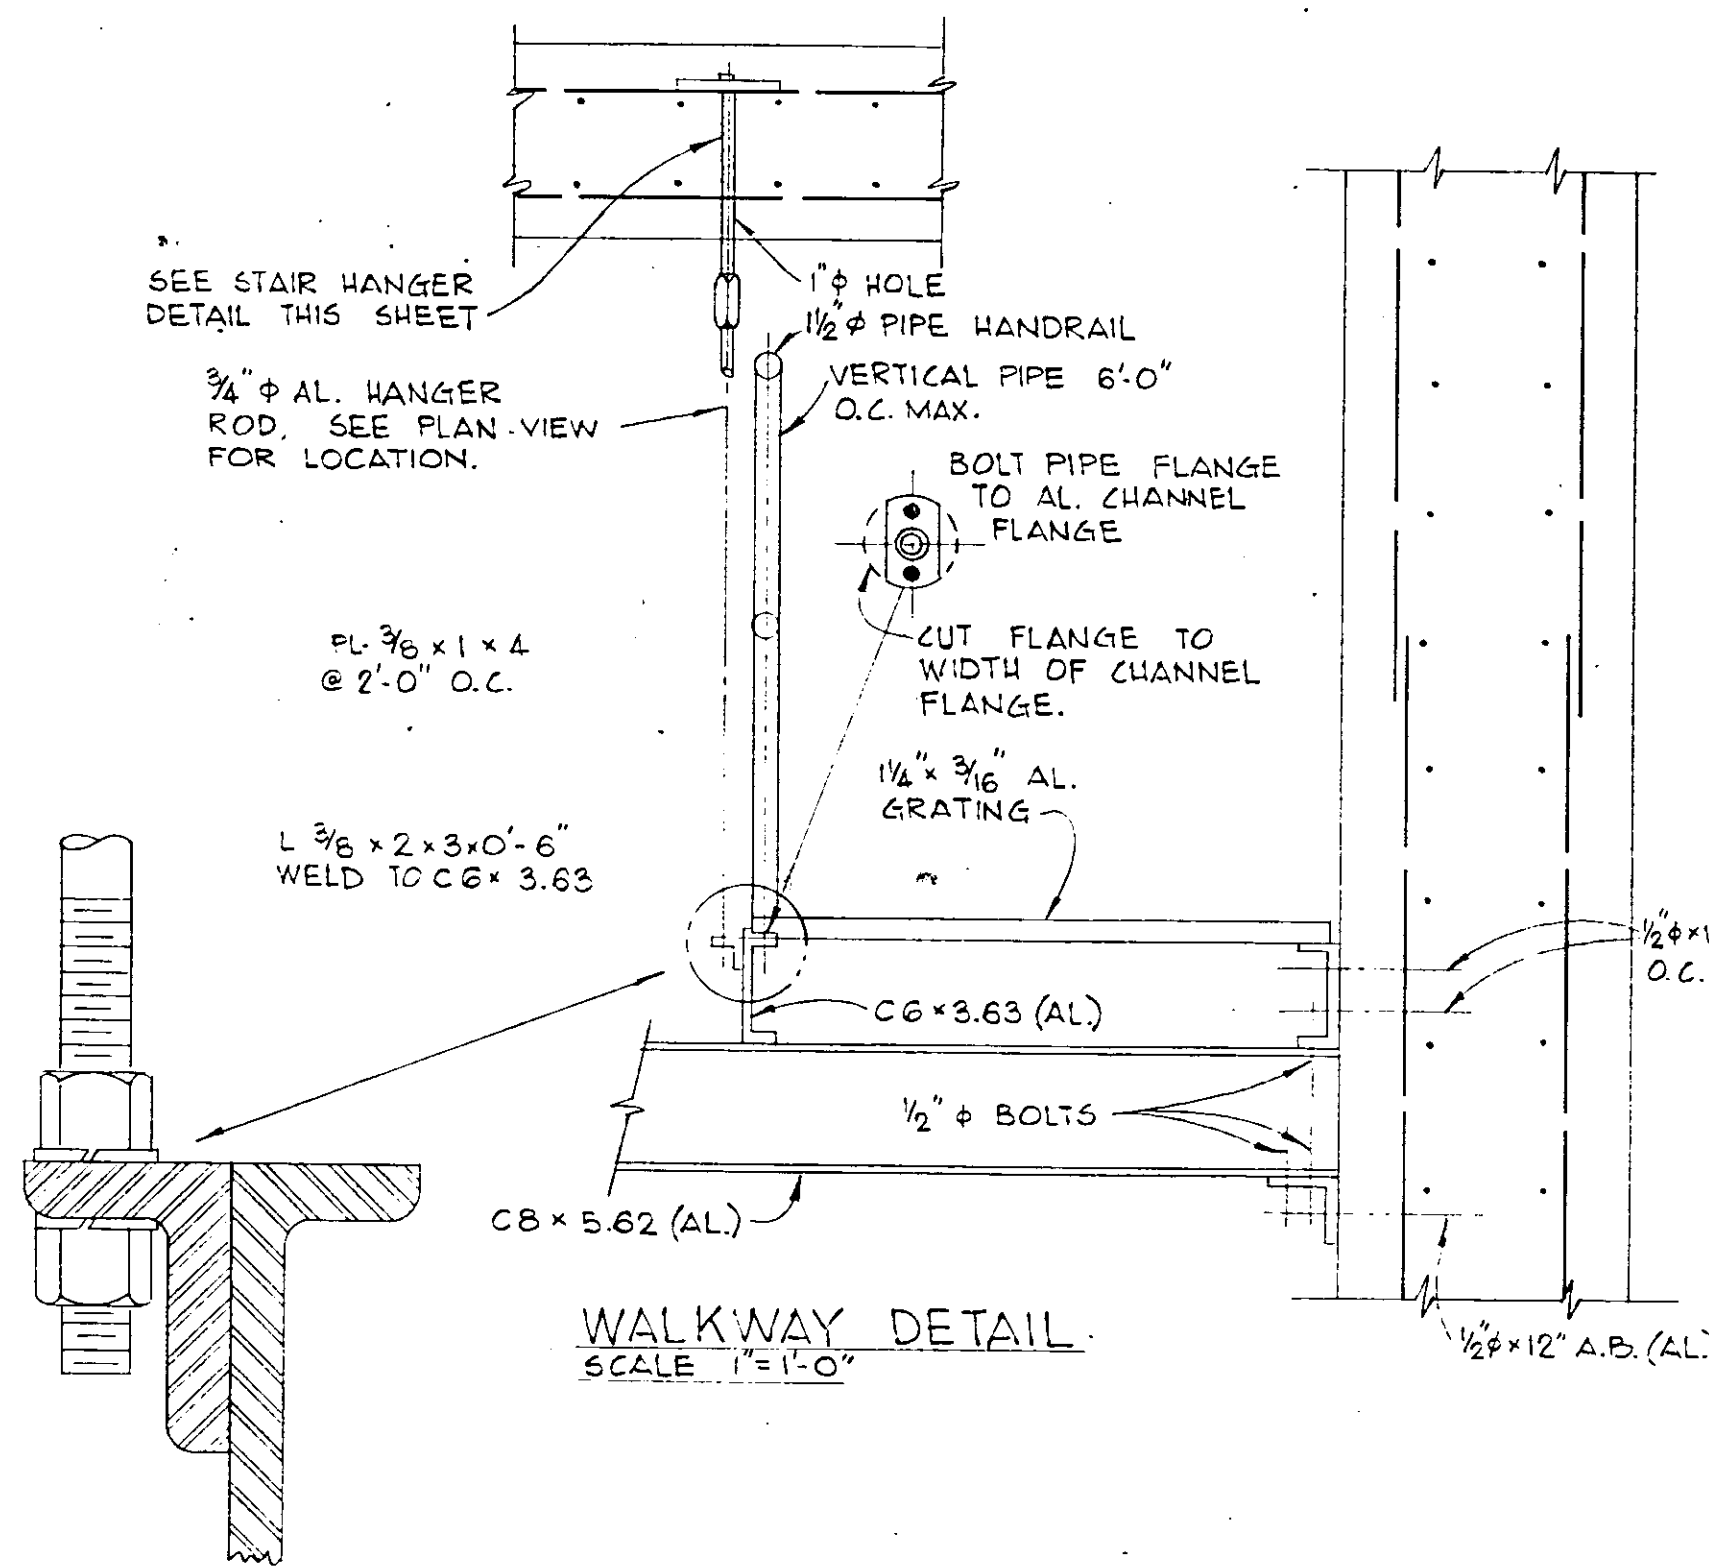


WALKWAY DETAIL
SCALE: 1" = 1'-0"

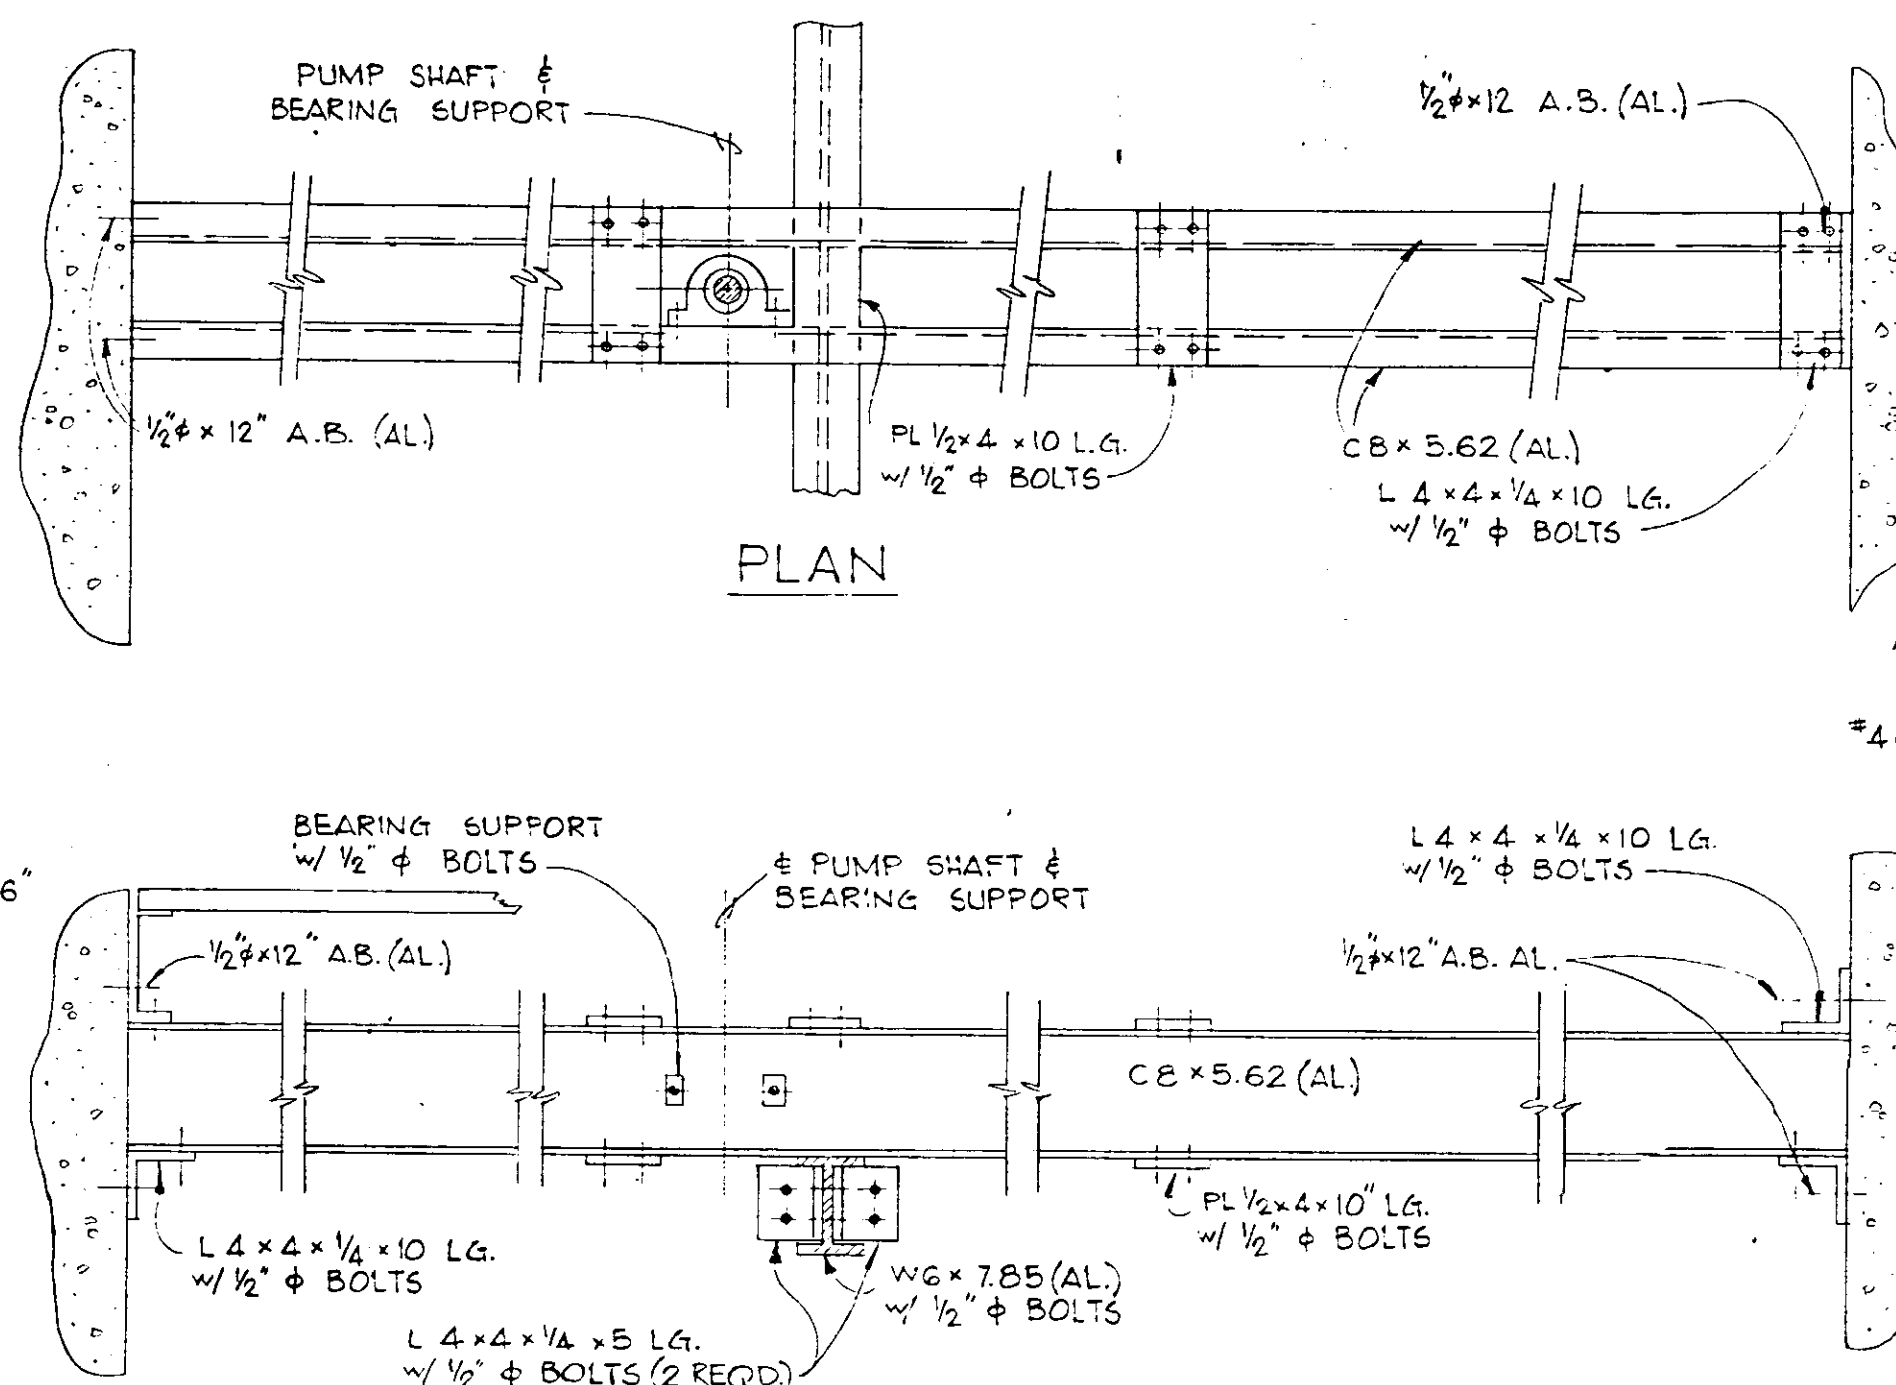


DETAIL OF PUMP SHAFT & BEARING SUPPORT
SCALE: 1" = 1'-0"

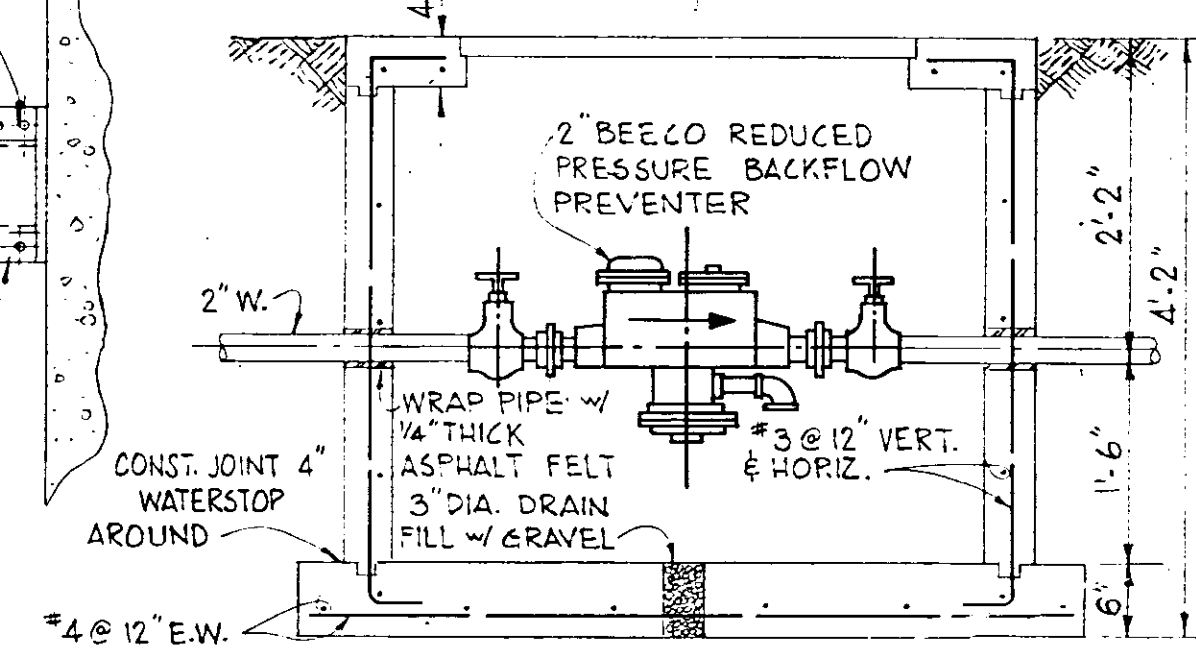


SECTION A-A

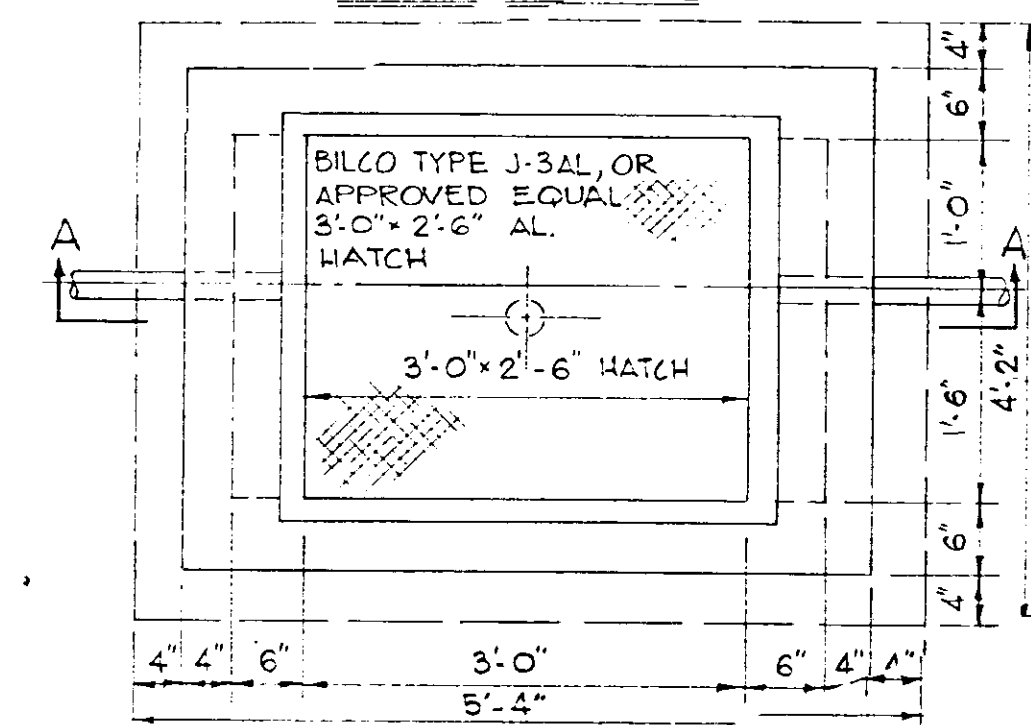


PLAN VIEW
BACKFLOW PREVENTER PIT DETAIL
SCALE: 3/4" = 1'-0"

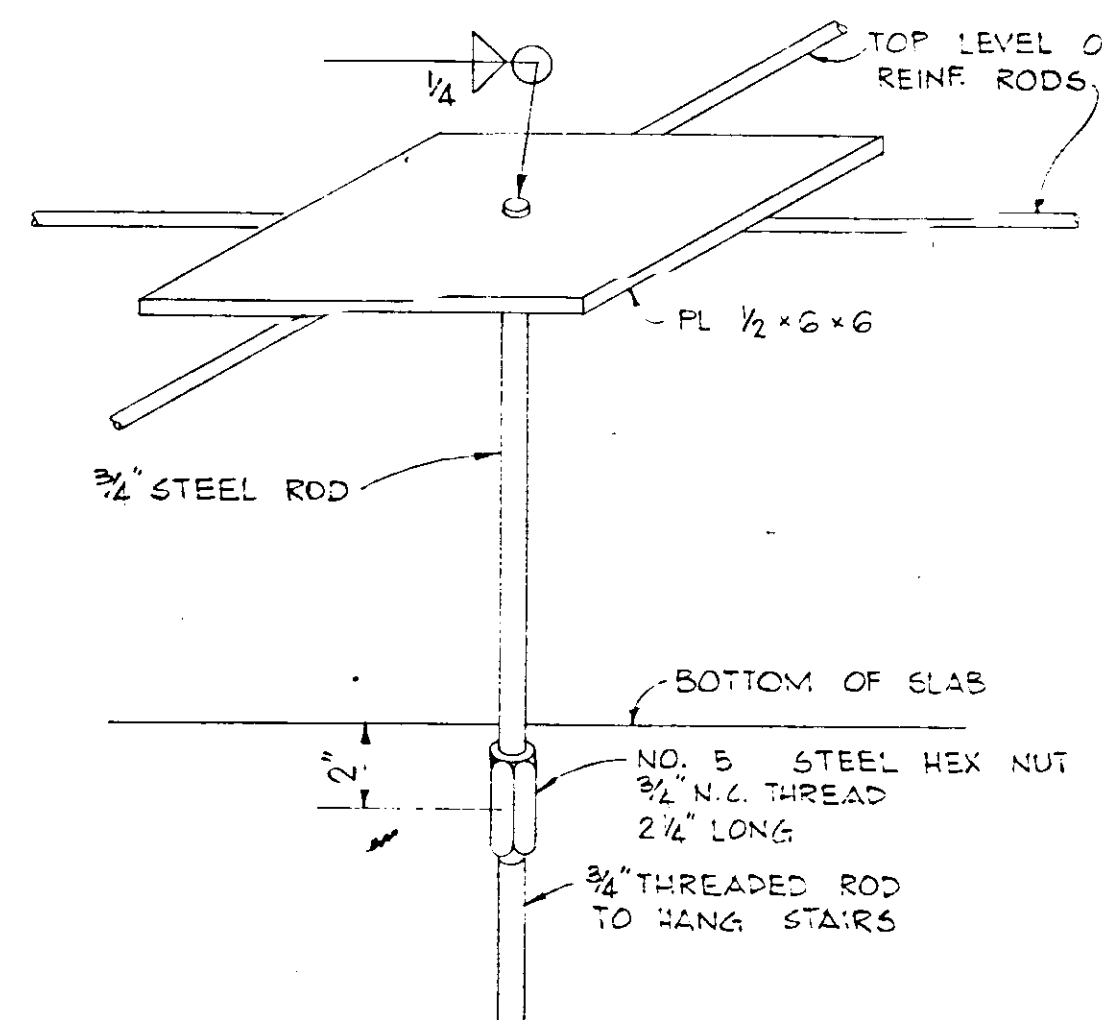


STAIR HANGER DETAIL
NOT TO SCALE

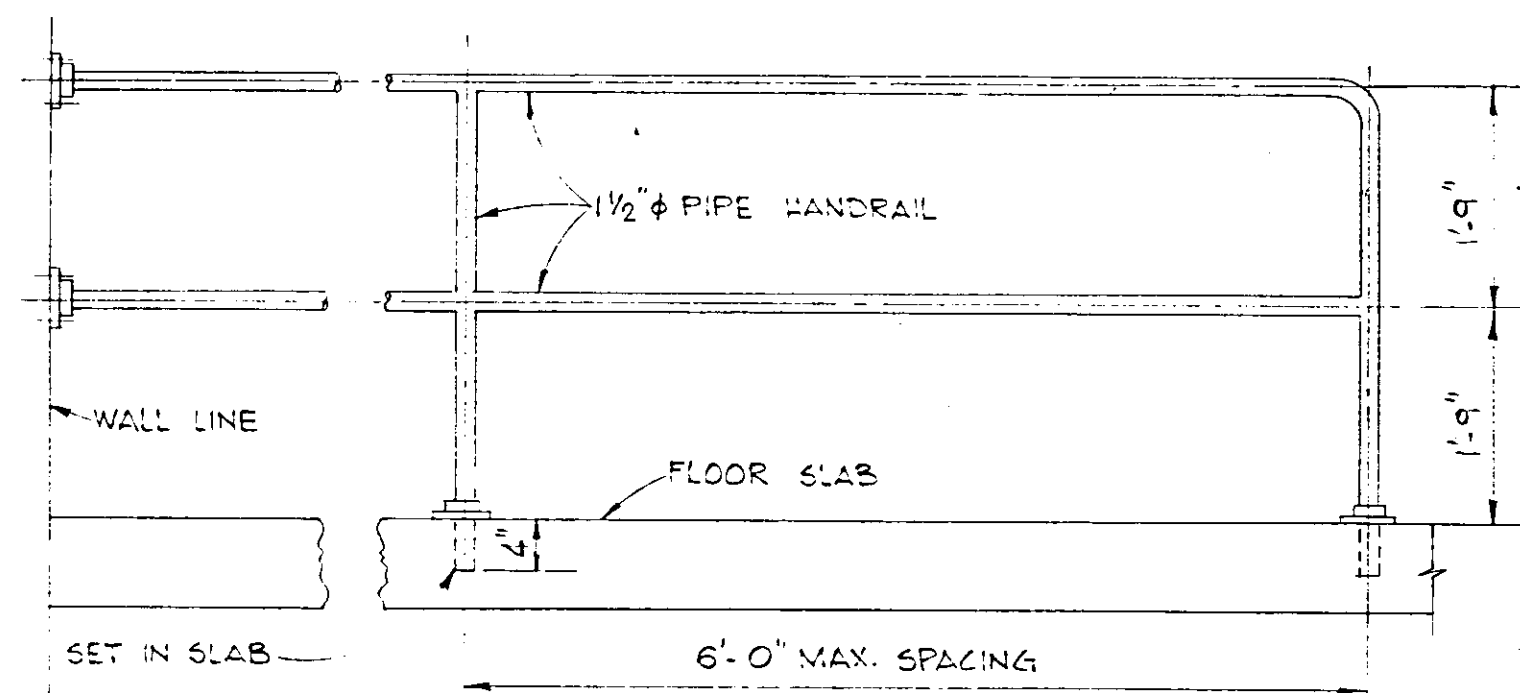

HANDRAIL DETAIL
NOT TO SCALE

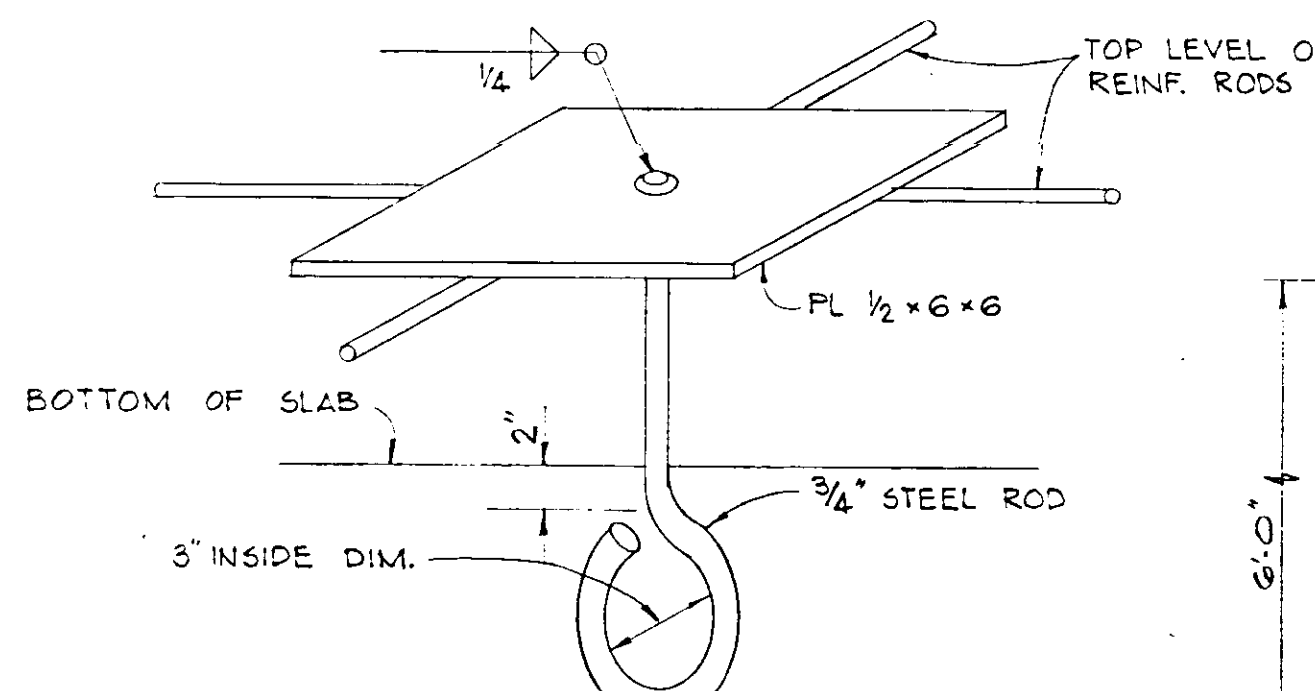

EYE BOLT HANGER DETAIL
NOT TO SCALE

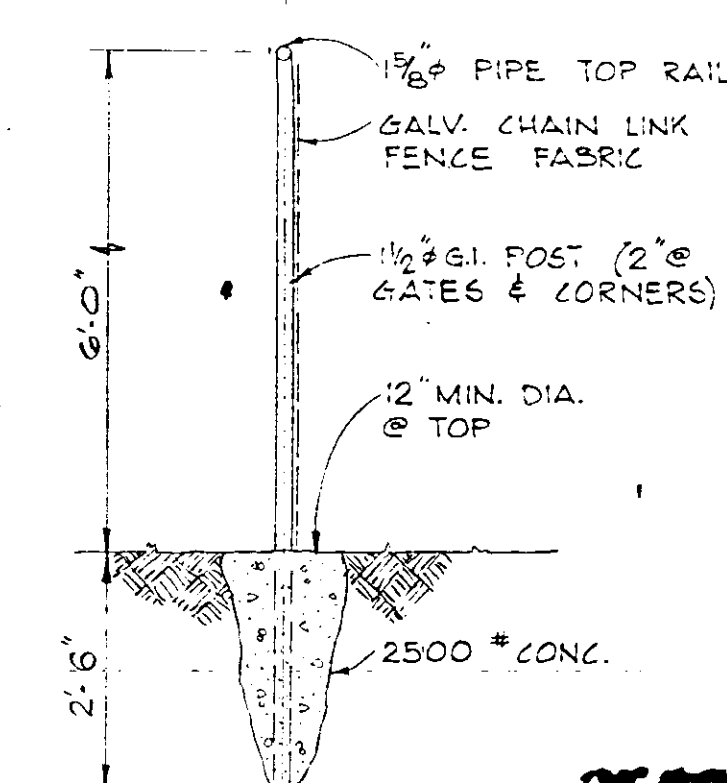


FENCE DETAIL
SCALE: 1/2" = 1'-0"


RECORD DRAWING
DATE 7-76 BY PJM
CH LKN 1805

RECORD DRAWING		REVISIONS	
NO.	DATE	DESCRIPTION	BY
DESIGNED BY GER			
DRAWN BY RLB			
CHECKED BY JWC			
DATE OCT. 1973			
FILE NO. 6681 - 8b		SHEET 11	
OF 23		SHEETS	
SCALE: AS SHOWN		No. 9522 STATE OF FLORIDA REGISTERED ENGINEER	


RUSSELL & AXON
Engineers - Planners - Architects
DAYTONA BEACH, FLORIDA
SANITARY SEWERAGE PROJECT
PART D
SECTION III - MASTER LIFT STATION I D
MECH. - DETAILS
MANATEE COUNTY, FLORIDA
T284

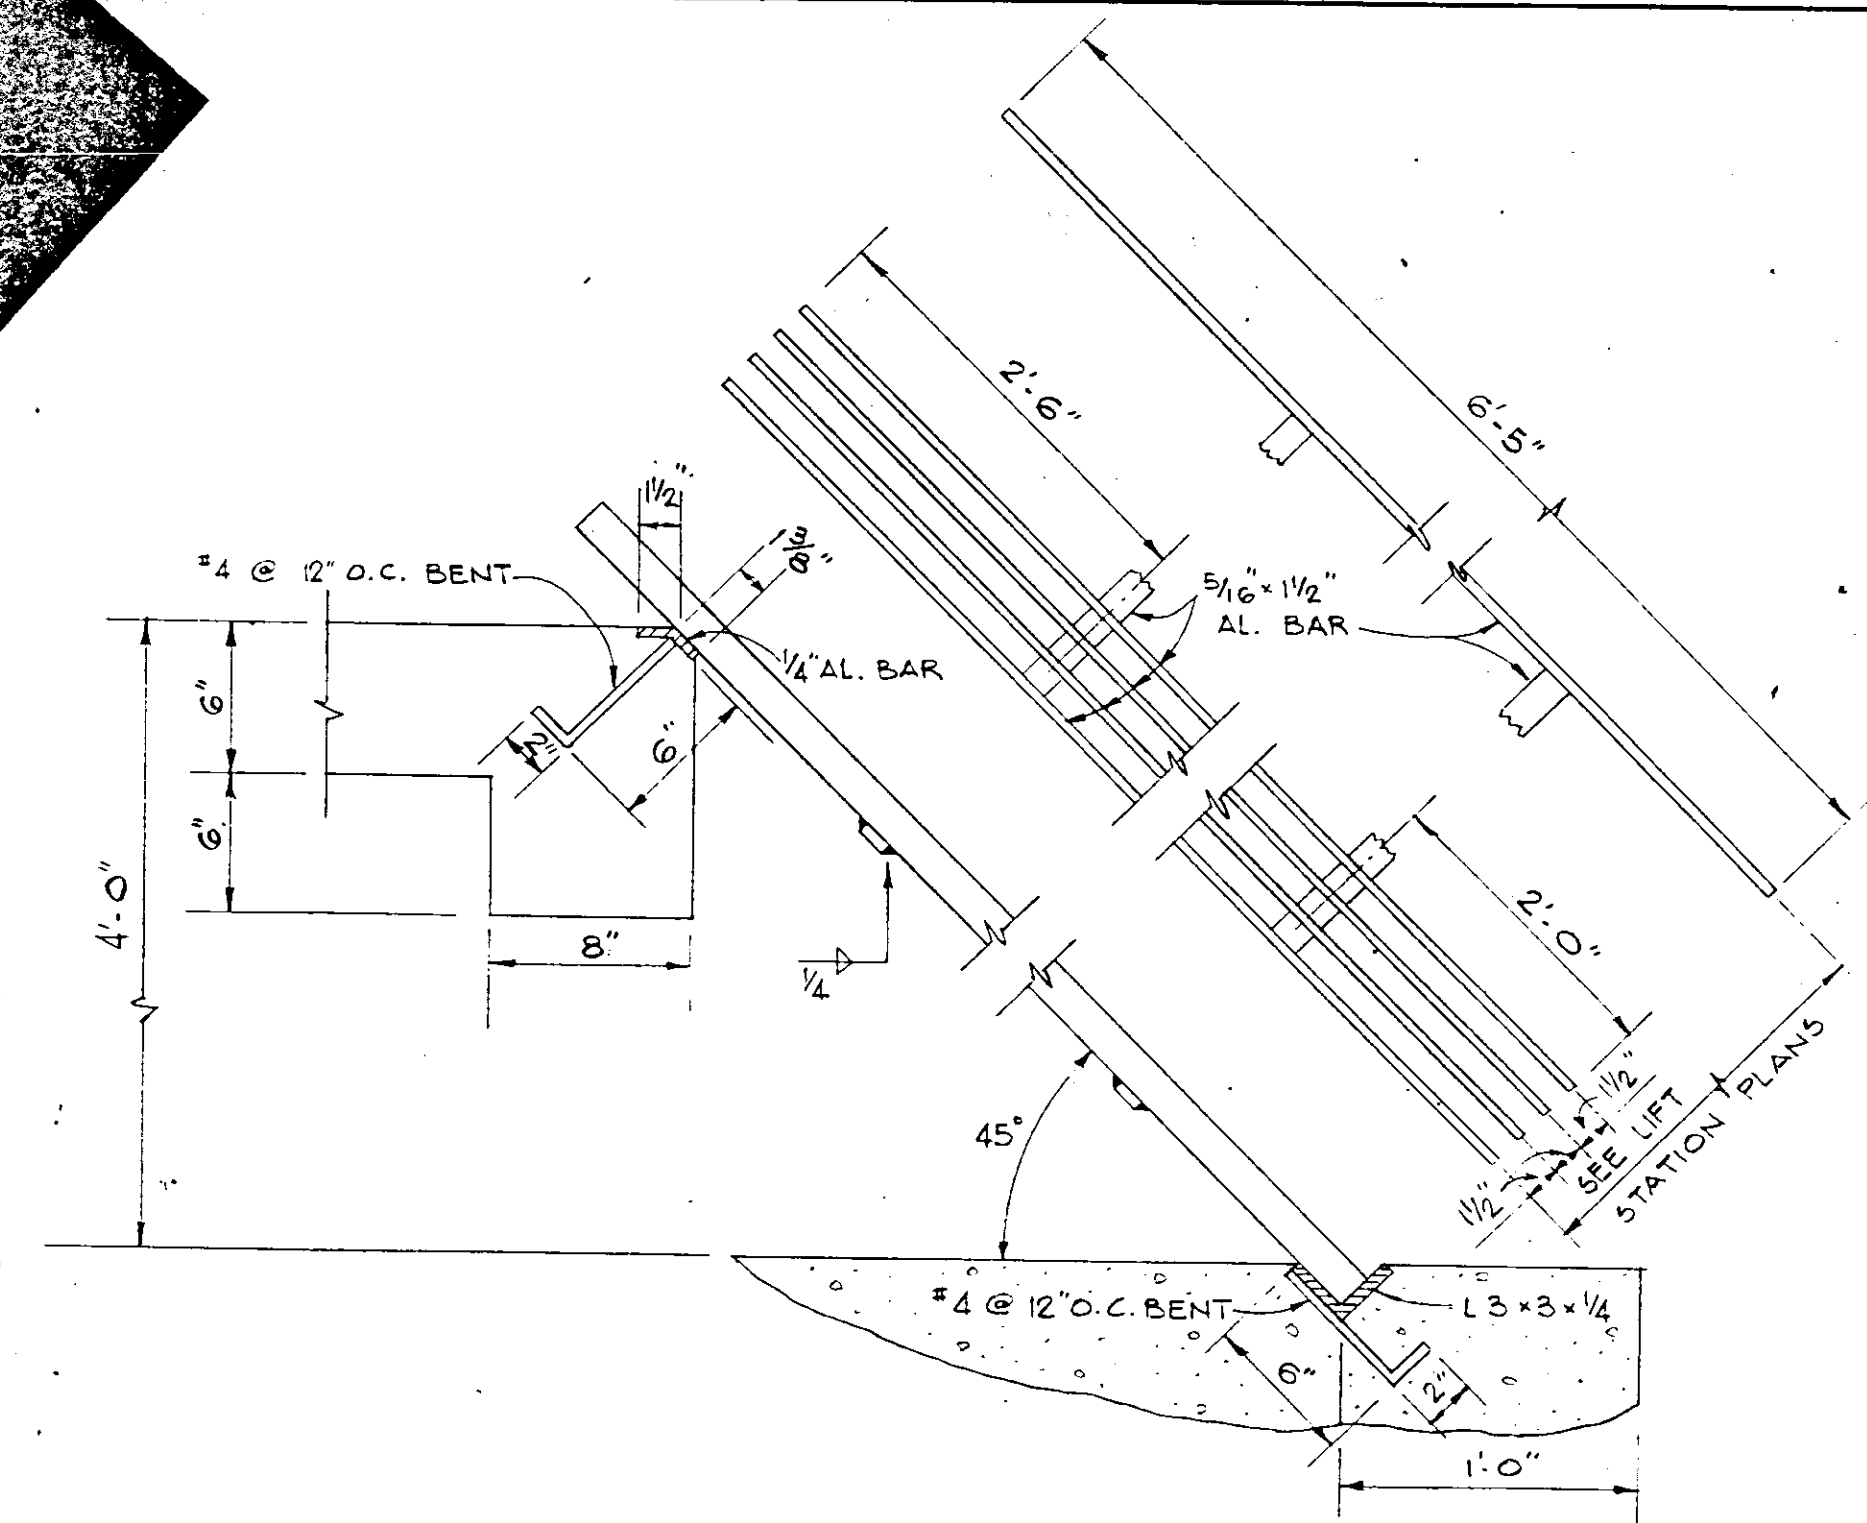


BAR SCREEN - DETAIL
SCALE: 1 1/2\"/>

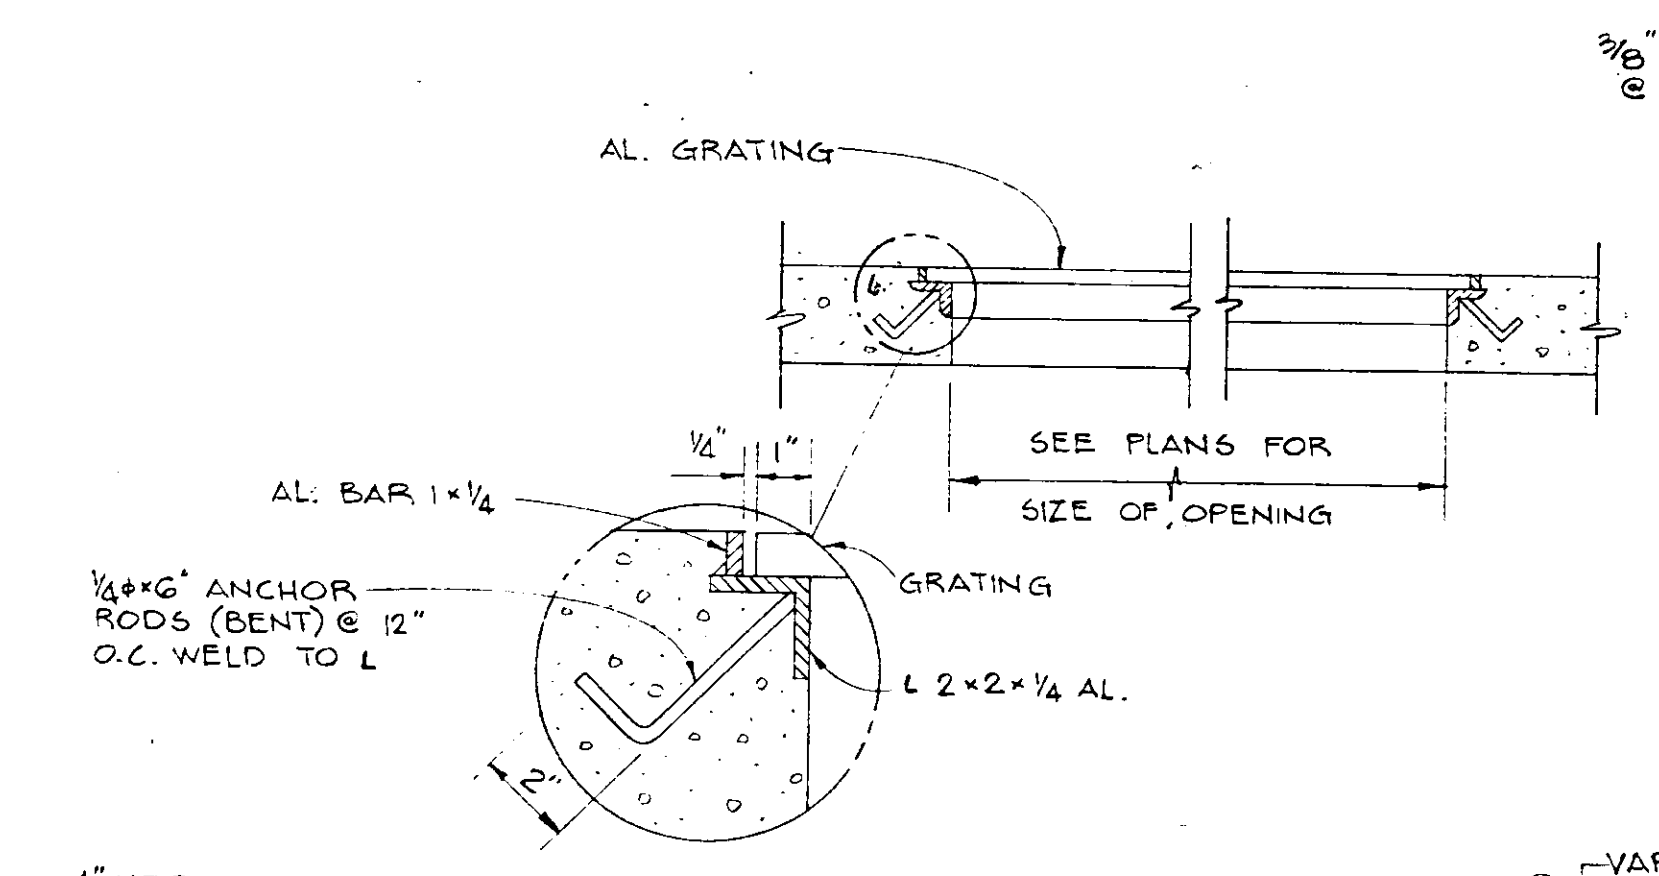


GRATING SEAT DETAIL
NOT TO SCALE

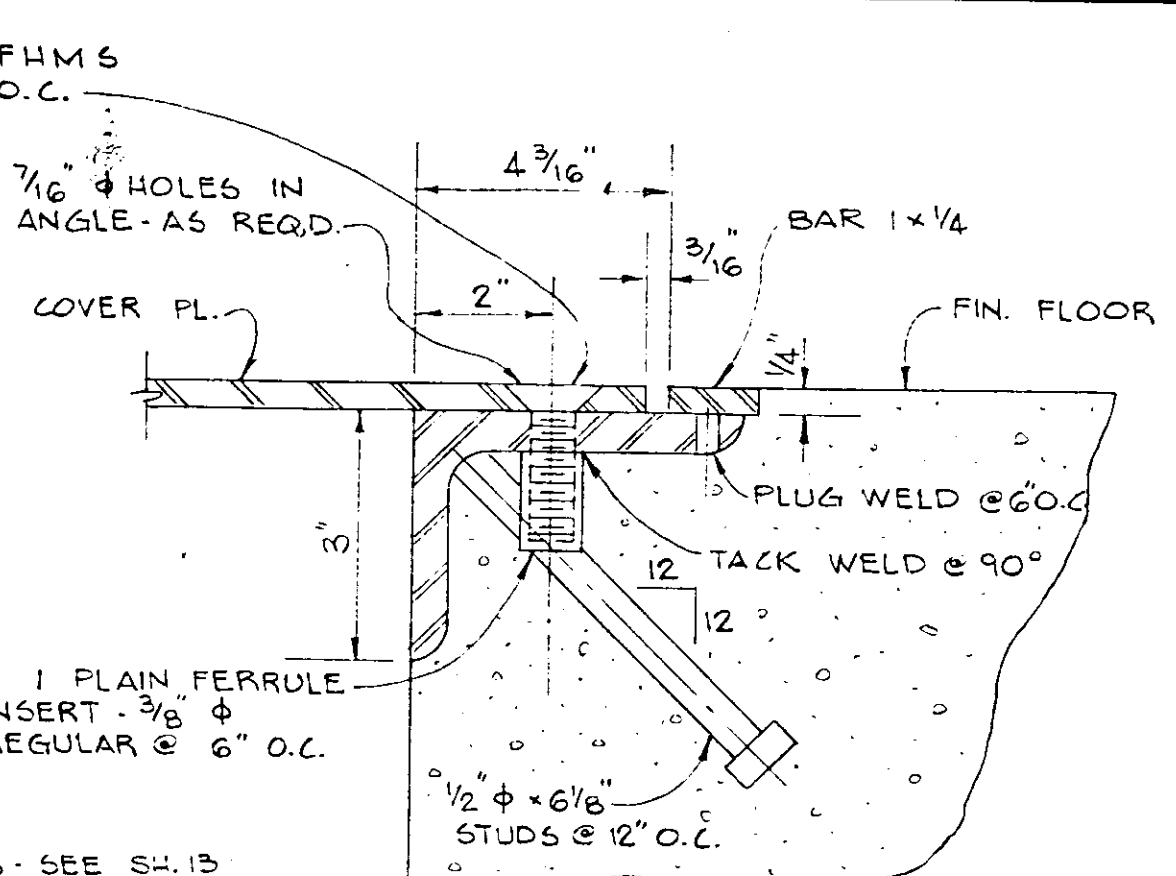


HATCH COVER & FRAME DETAIL
NOT TO SCALE

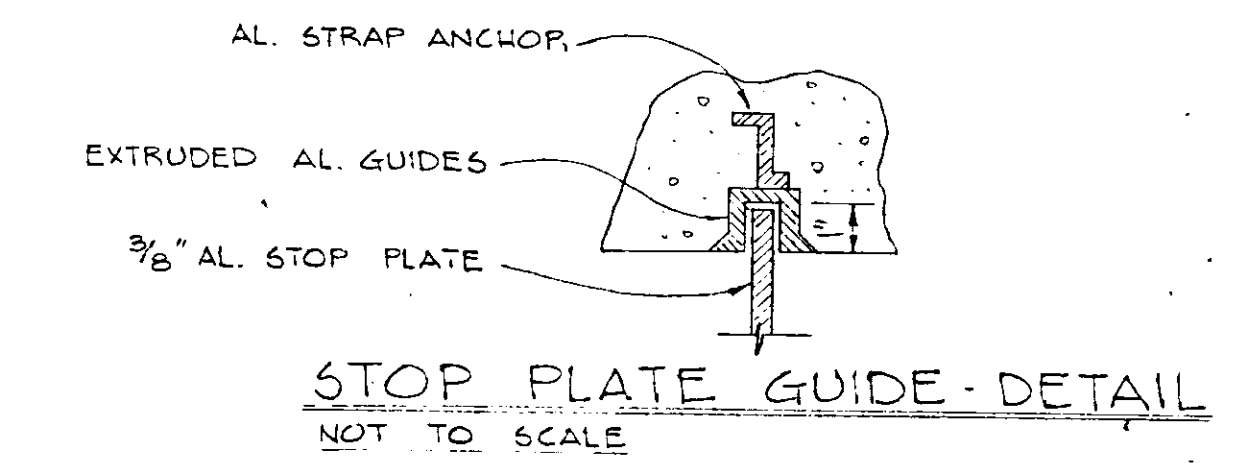


STOP PLATE GUIDE - DETAIL
NOT TO SCALE

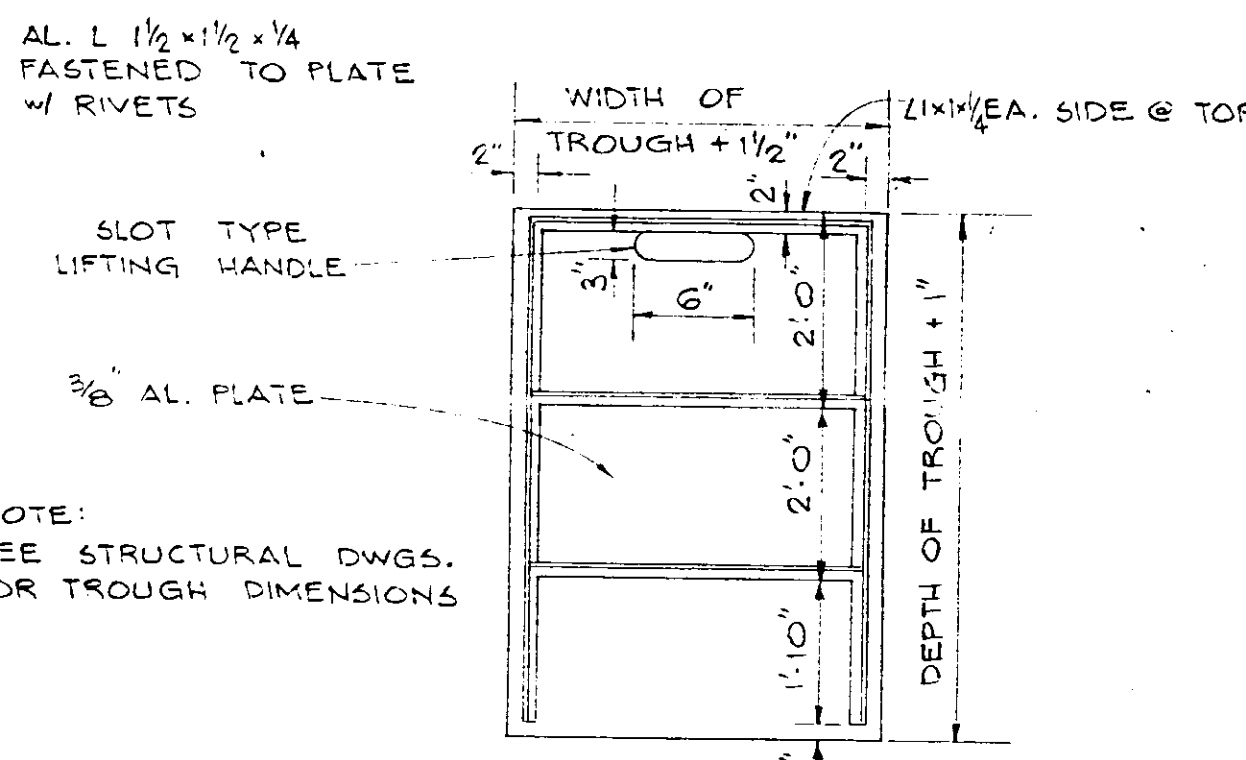


STOP PLATE DETAIL
NOT TO SCALE

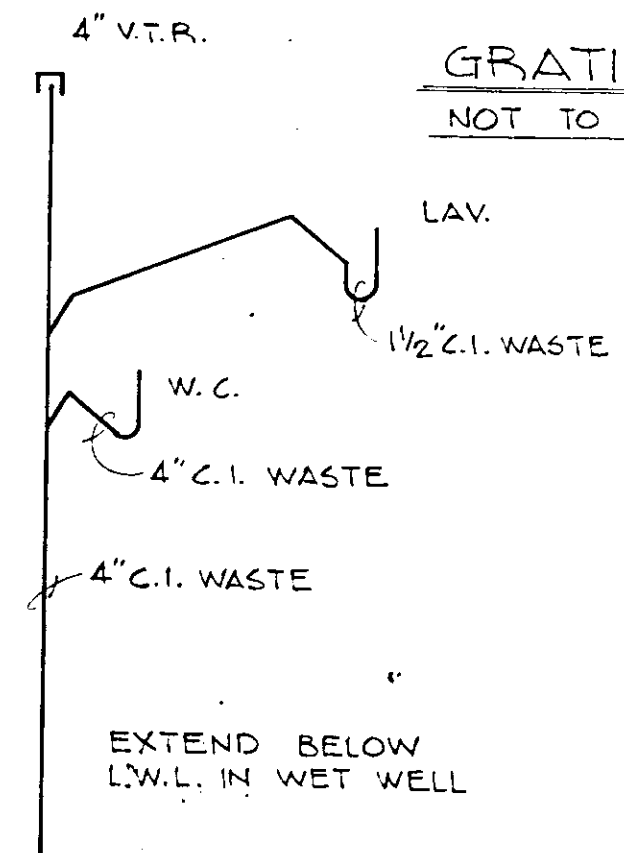


WASTE PIPING SCHEMATIC
NOT TO SCALE

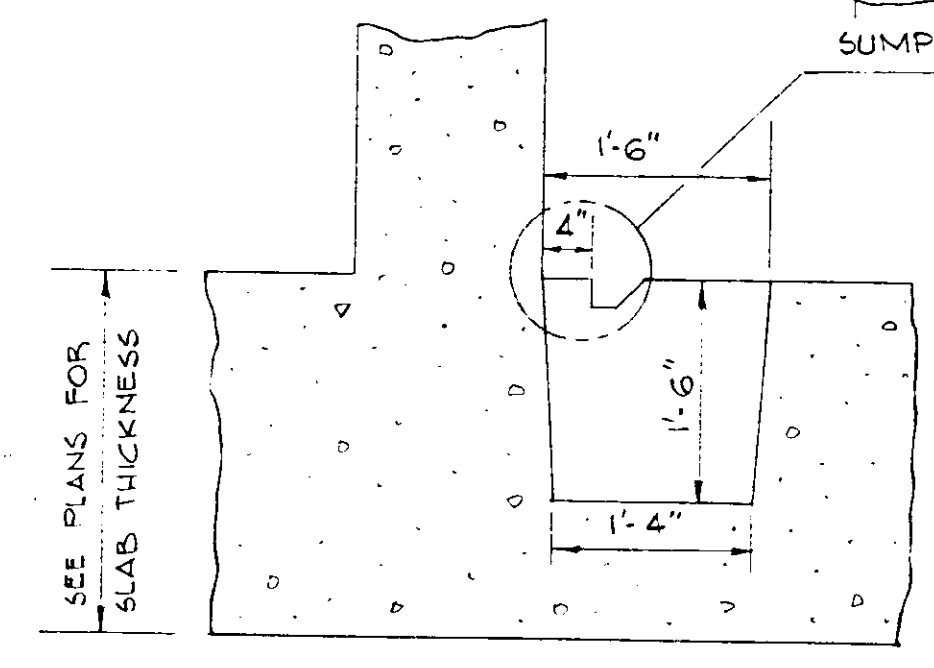


SUMP PIT DETAIL
SCALE: 3/4\"/>

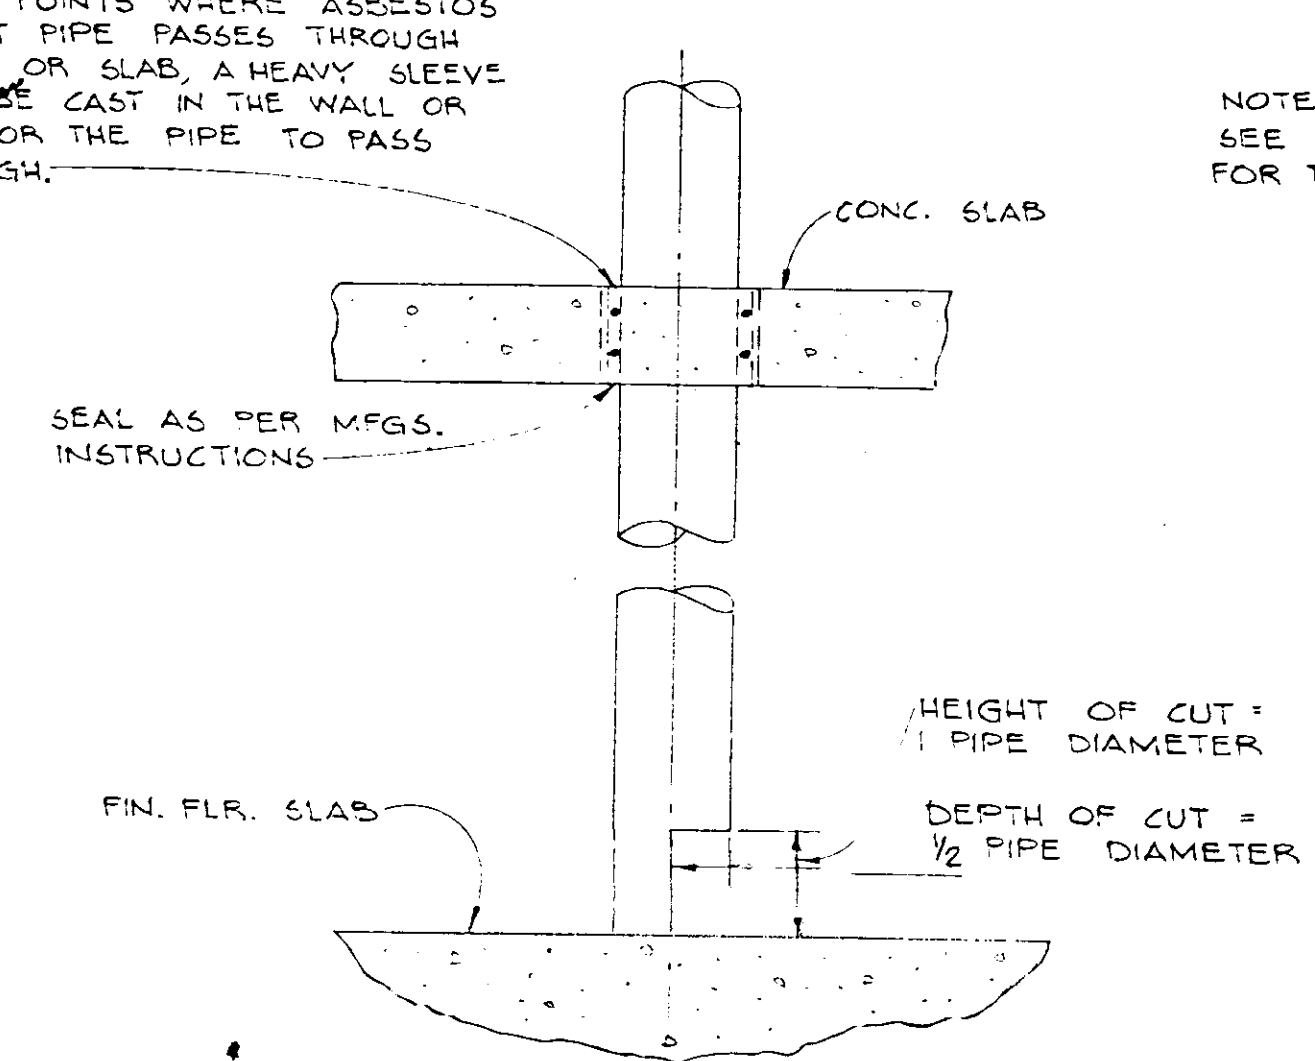


VENTILATION PIPE DETAIL
SCALE: 1/2\"/>

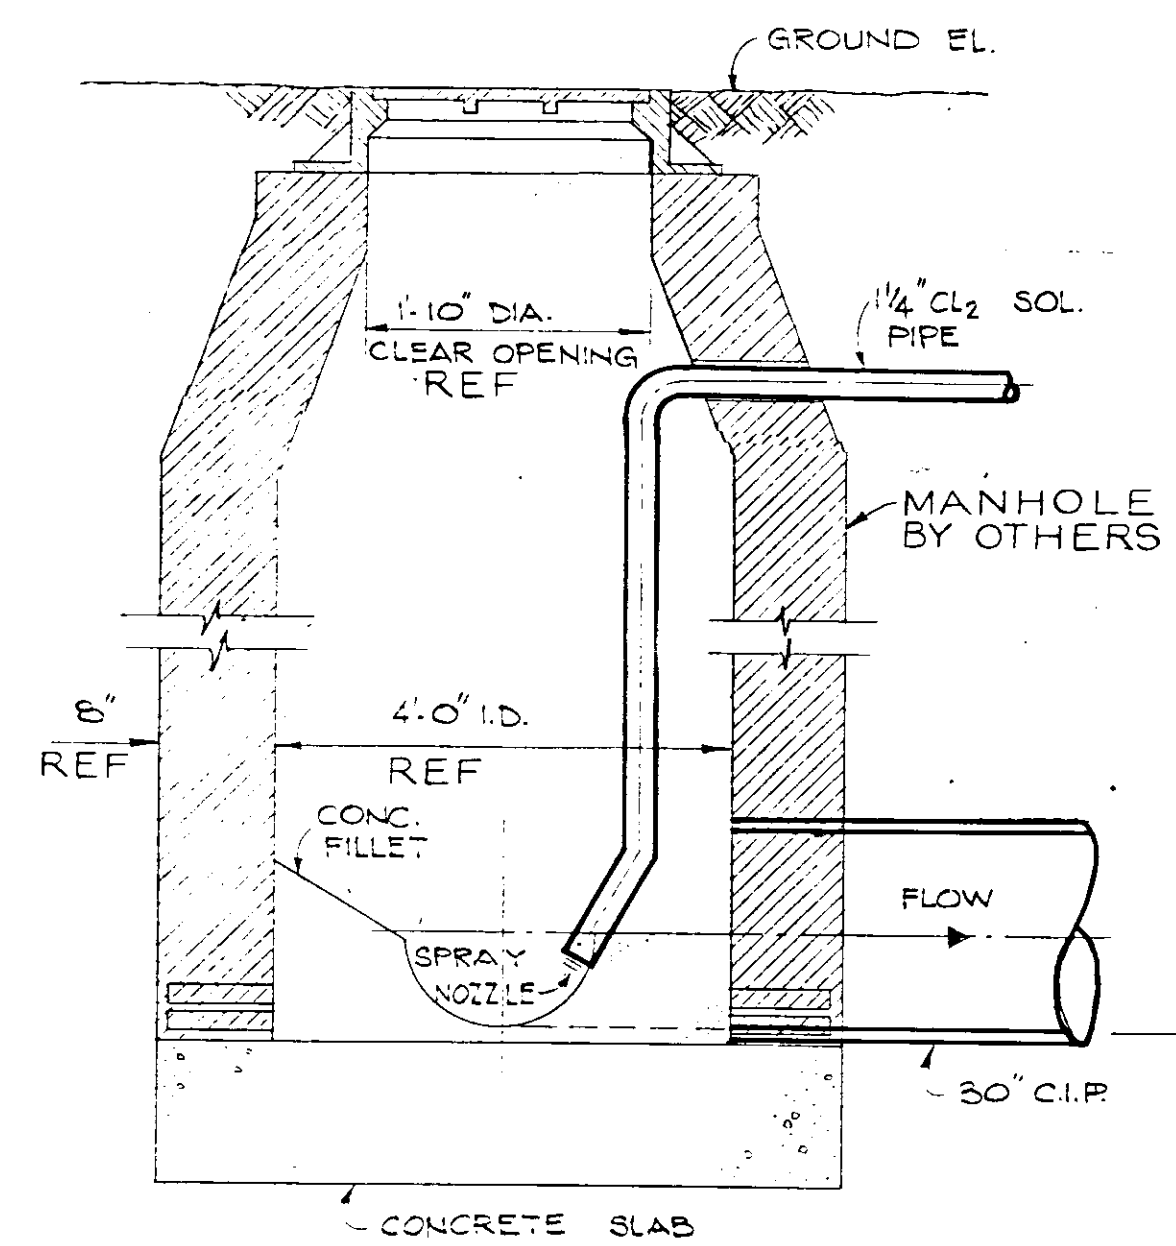


CHLORINE CONNECTION TO MANHOLE
NOT TO SCALE

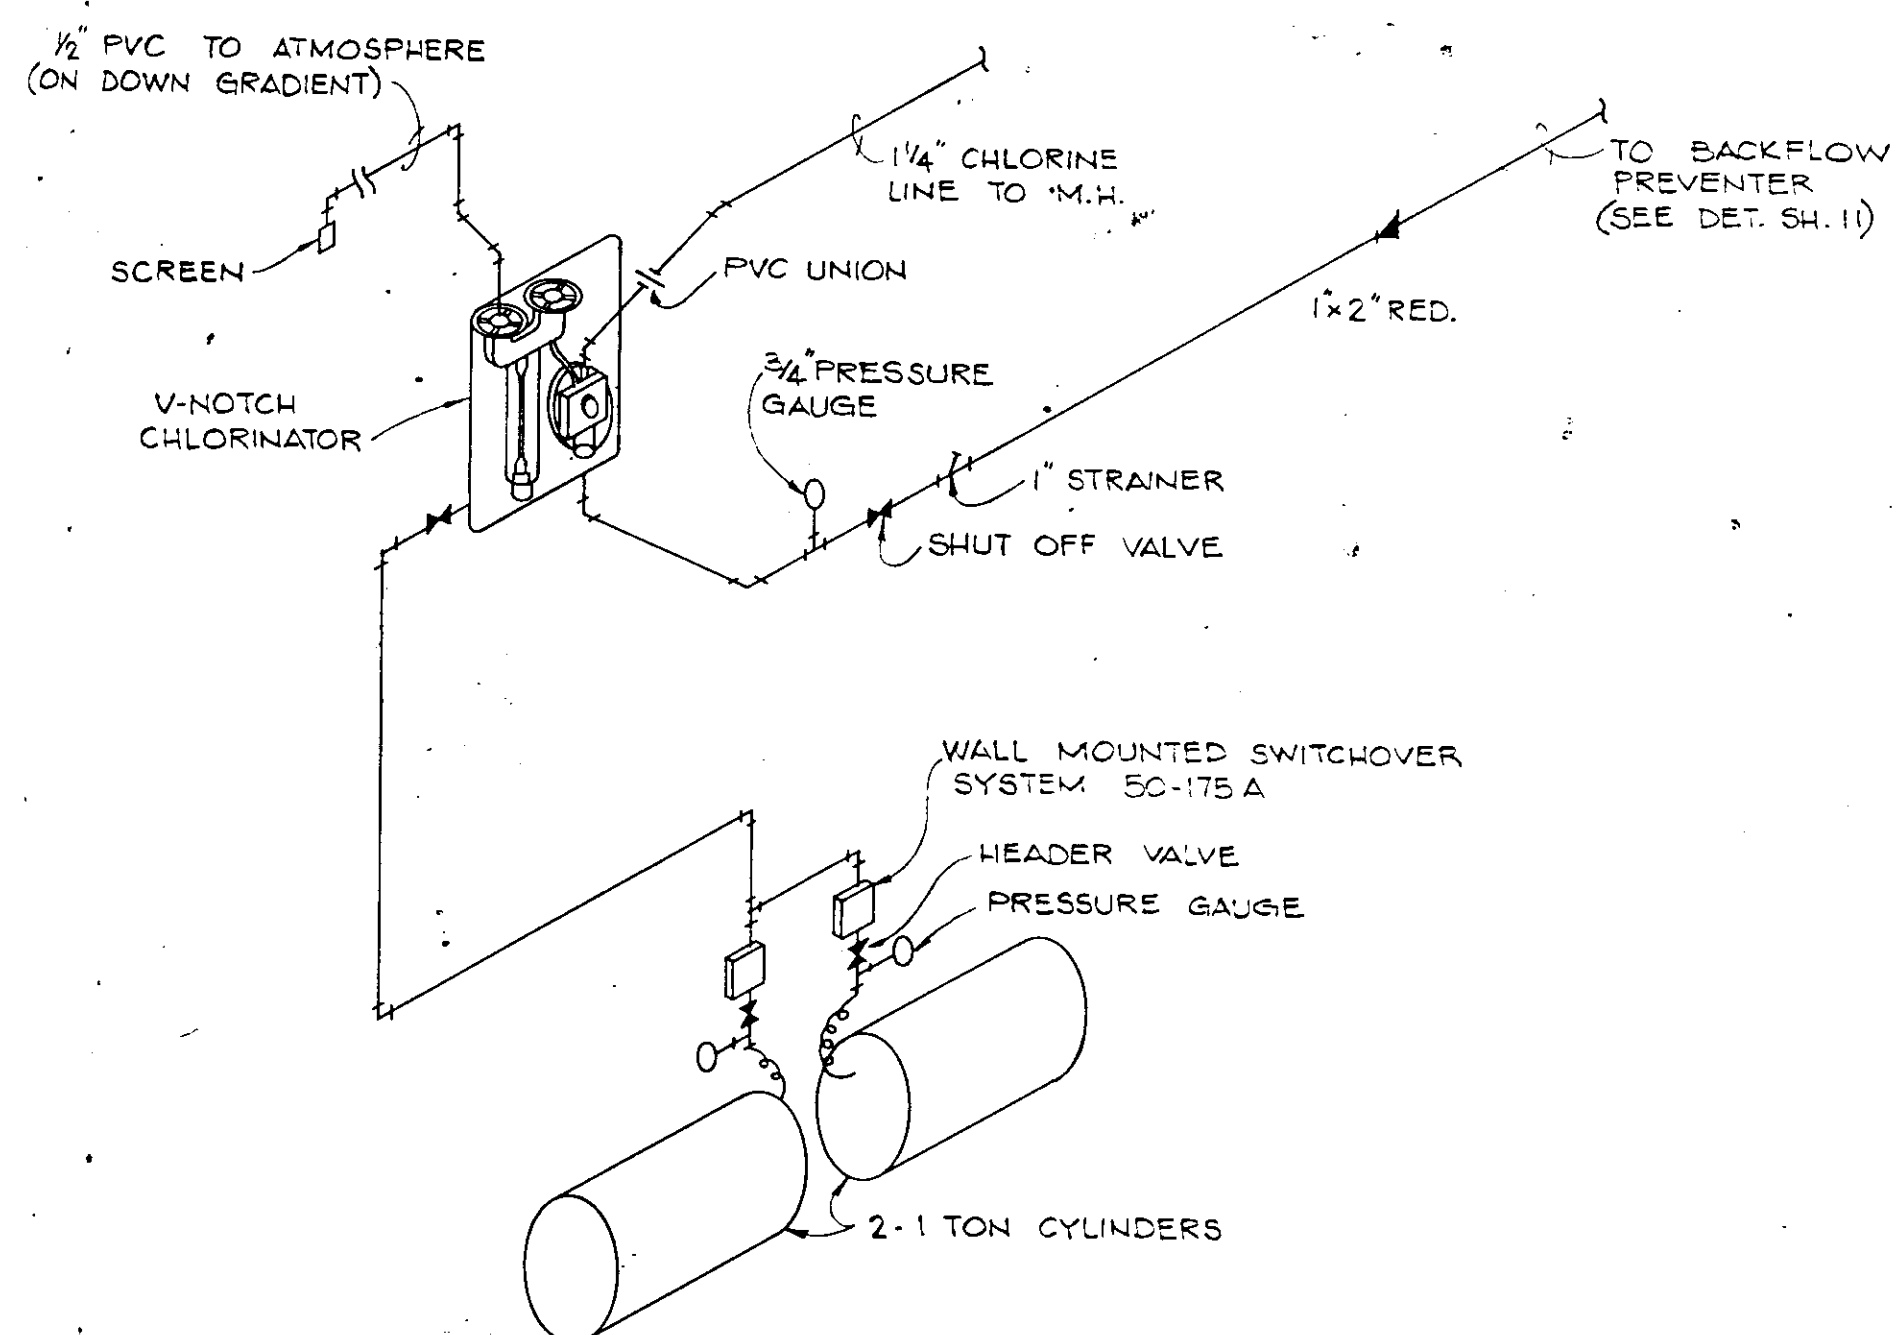


CHLORINATOR INSTALLATION SCHEMATIC
NOT TO SCALE

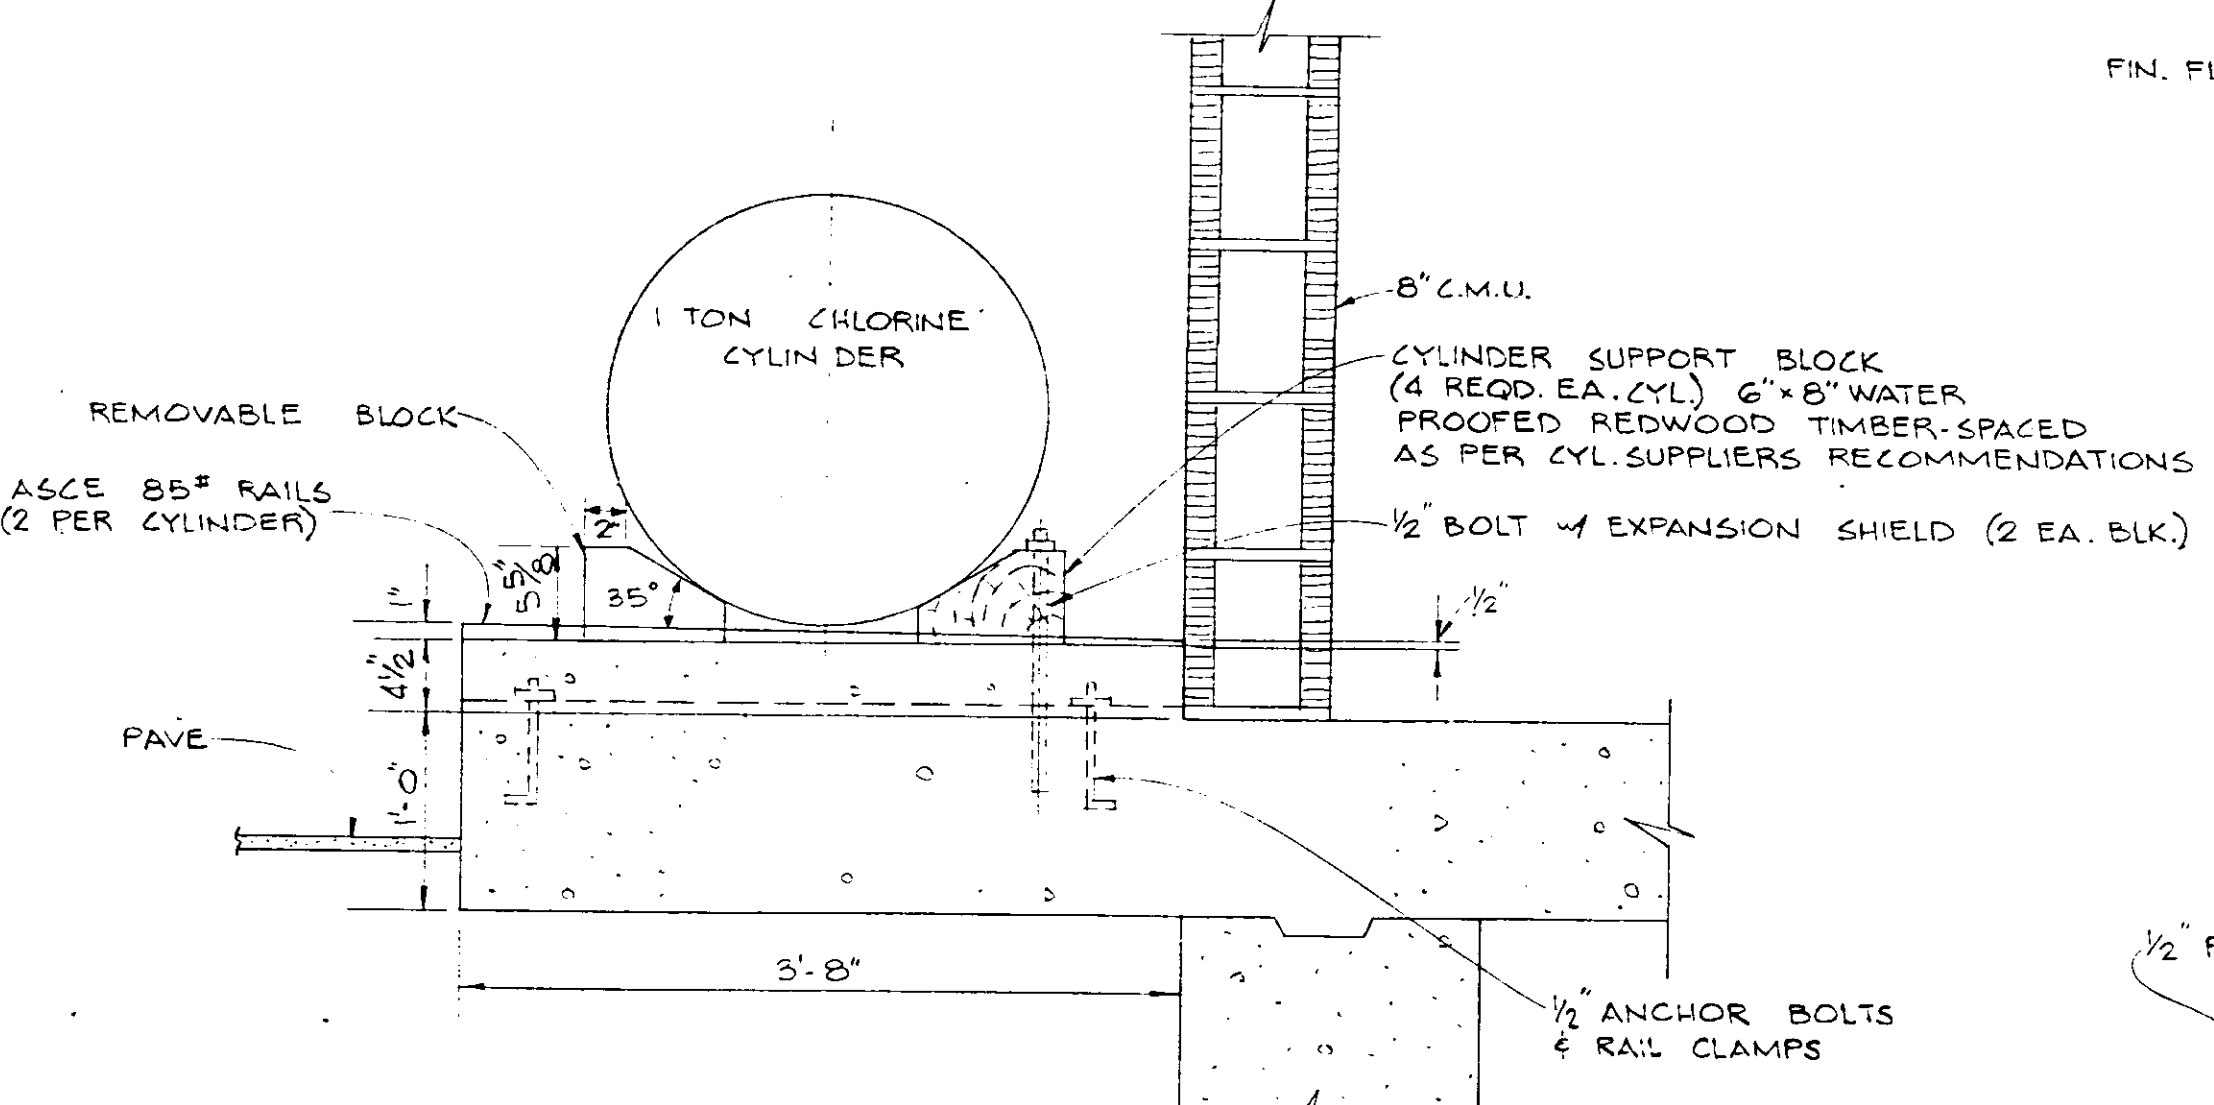


CHLORINE CYLINDER PLATFORM - DETAIL
SCALE: 1\"/>

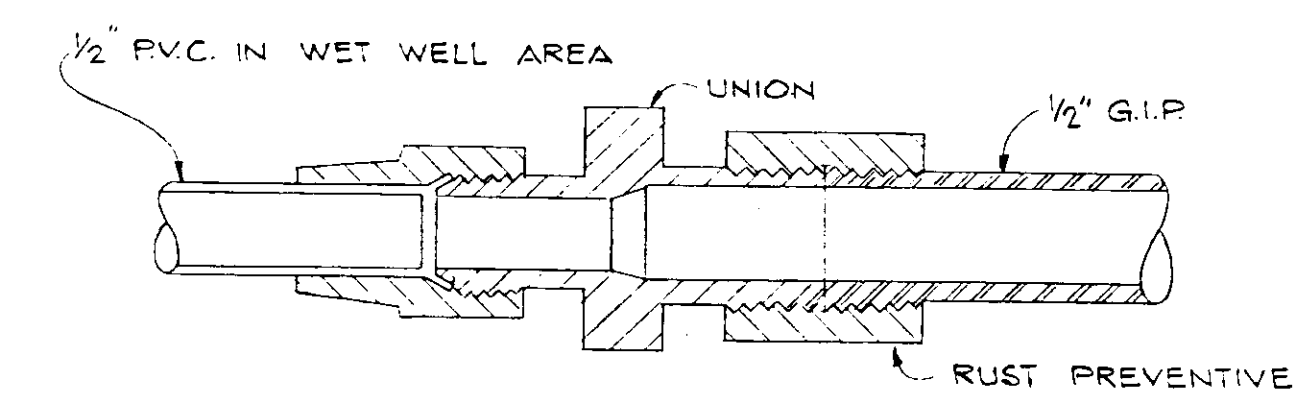


AIR TIGHT CONNECTION
FOR BUBBLER LINE
NOT TO SCALE

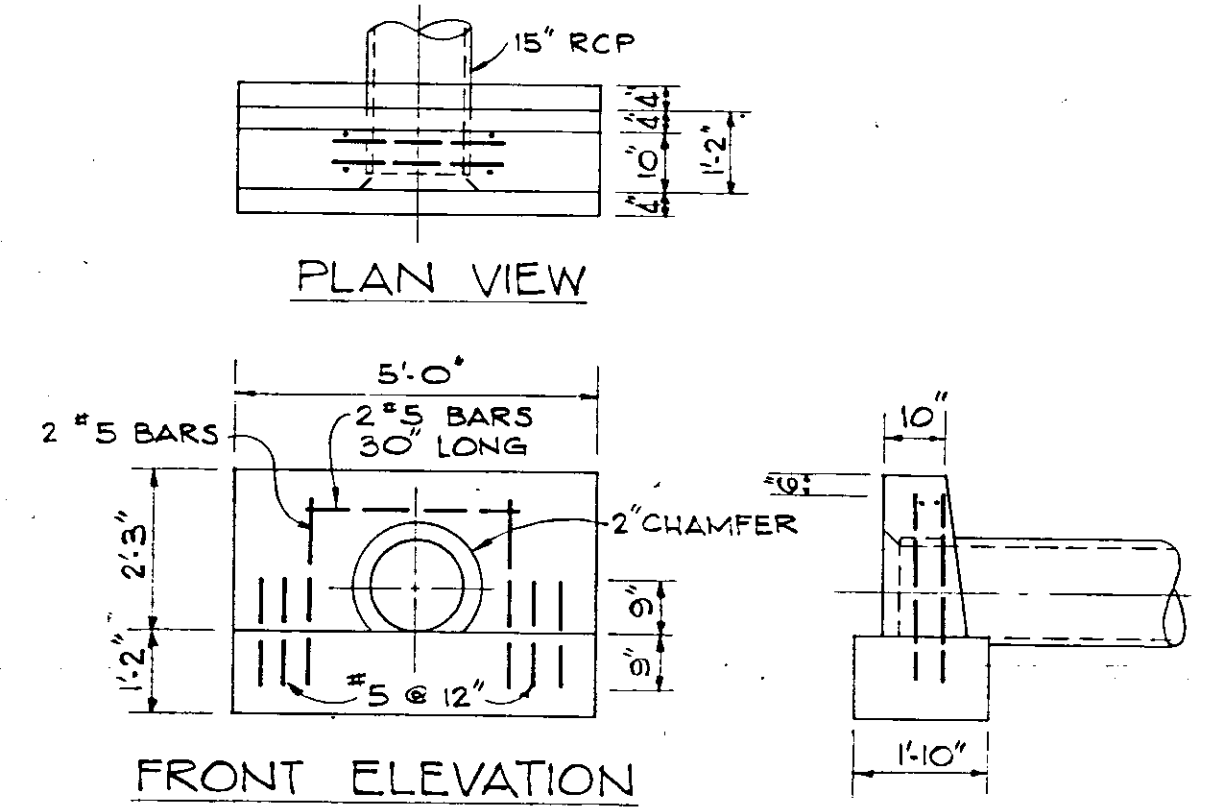

CONC. ENDWALL DETAIL
SCALE: 3/8\"/>

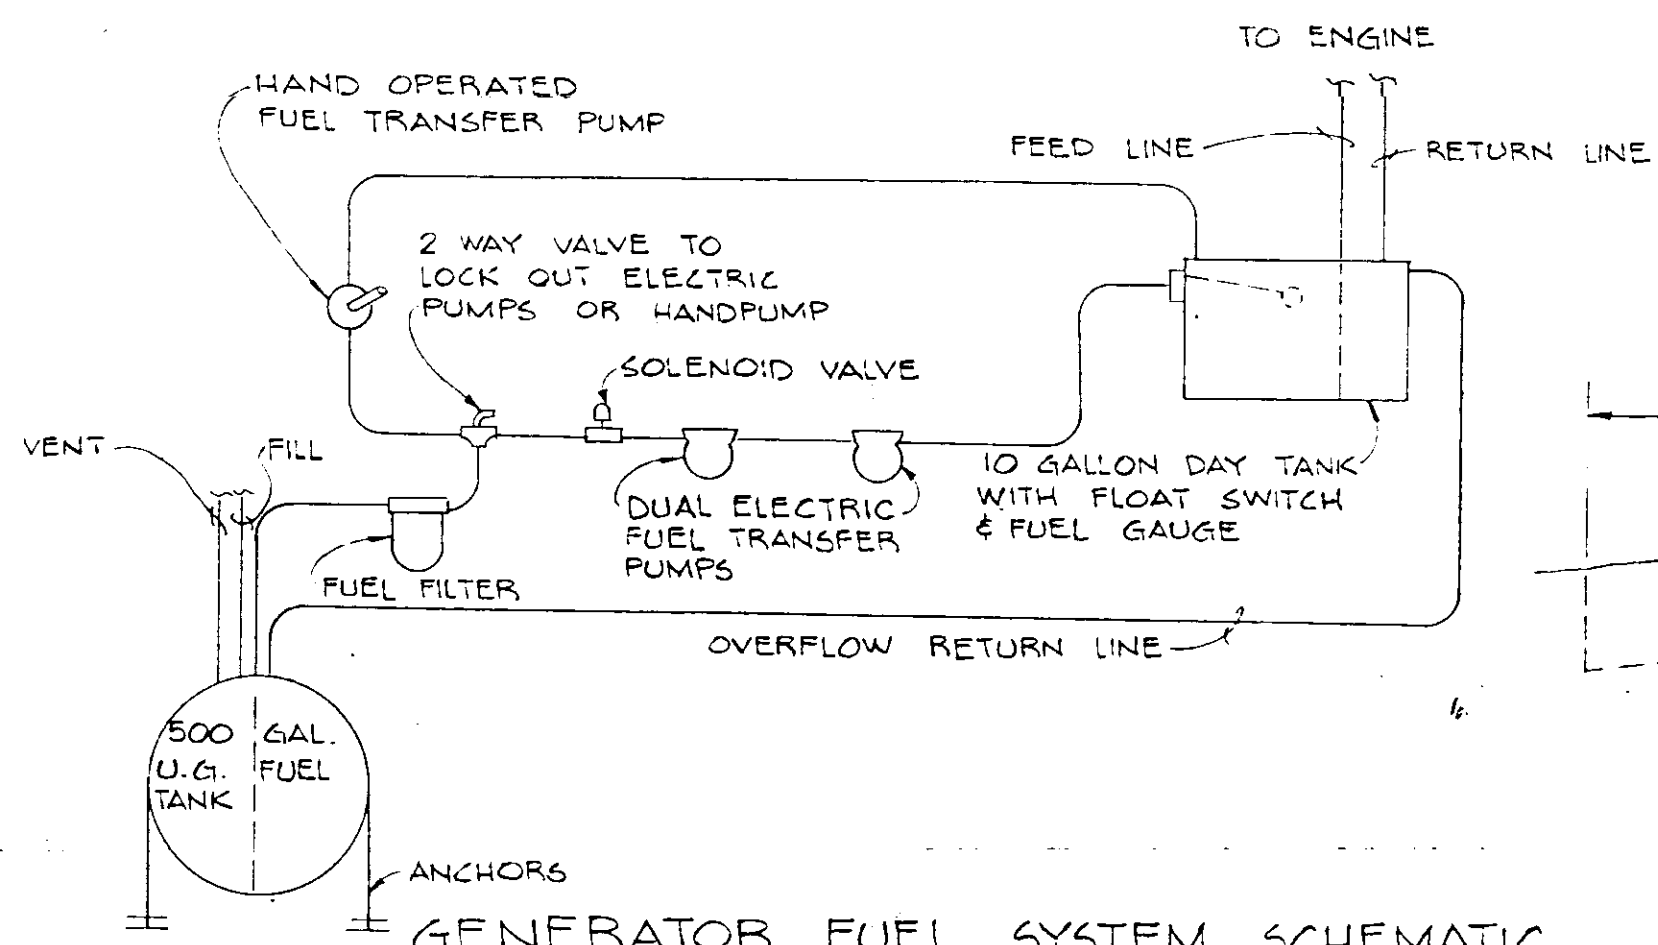

GENERATOR FUEL SYSTEM SCHEMATIC

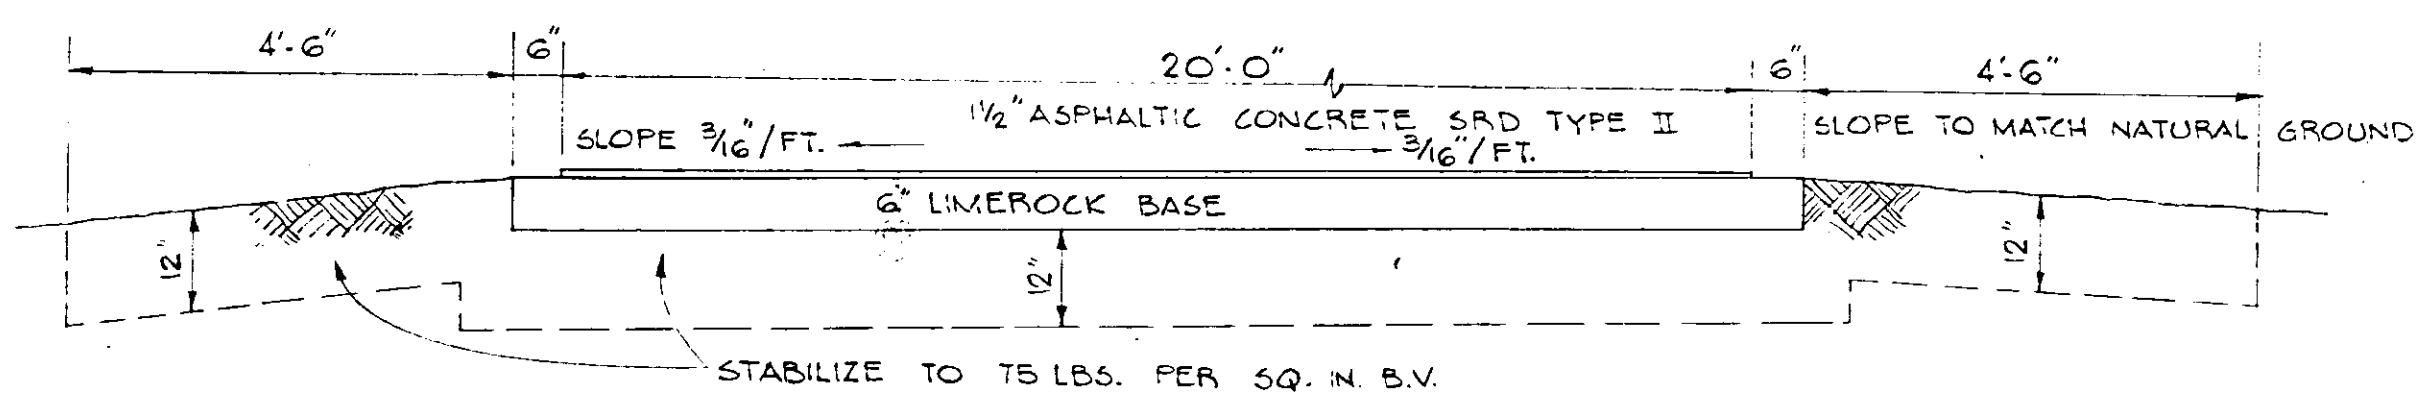

TYPICAL PAVEMENT SECTION
NOT TO SCALE

RECORD DRAWING			
NO.	DATE	DESCRIPTION	BY
REVISIONS			
NO.	DATE	DESCRIPTION	BY
DESIGNED BY GER			
DRAWN BY R.L.B.			
CHECKED BY JWC			
DATE OCT. 1973			
FILE NO. 6681-8b			
SHEET OF 23			
No. 12 SHEETS			
SCALE: AS SHOWN			

RUSSELL & AXON
Engineers — Planners — Architects
DAYTONA BEACH, FLORIDA

SANITARY SEWERAGE PROJECT
PART D
SECTION III - MASTER LIFT STATION I D
MISC. DETAILS


MANATEE COUNTY

FLORIDA


REGISTERED ENGINEER

No. 9522
STATE OF FLORIDA

CL WKN 18-05

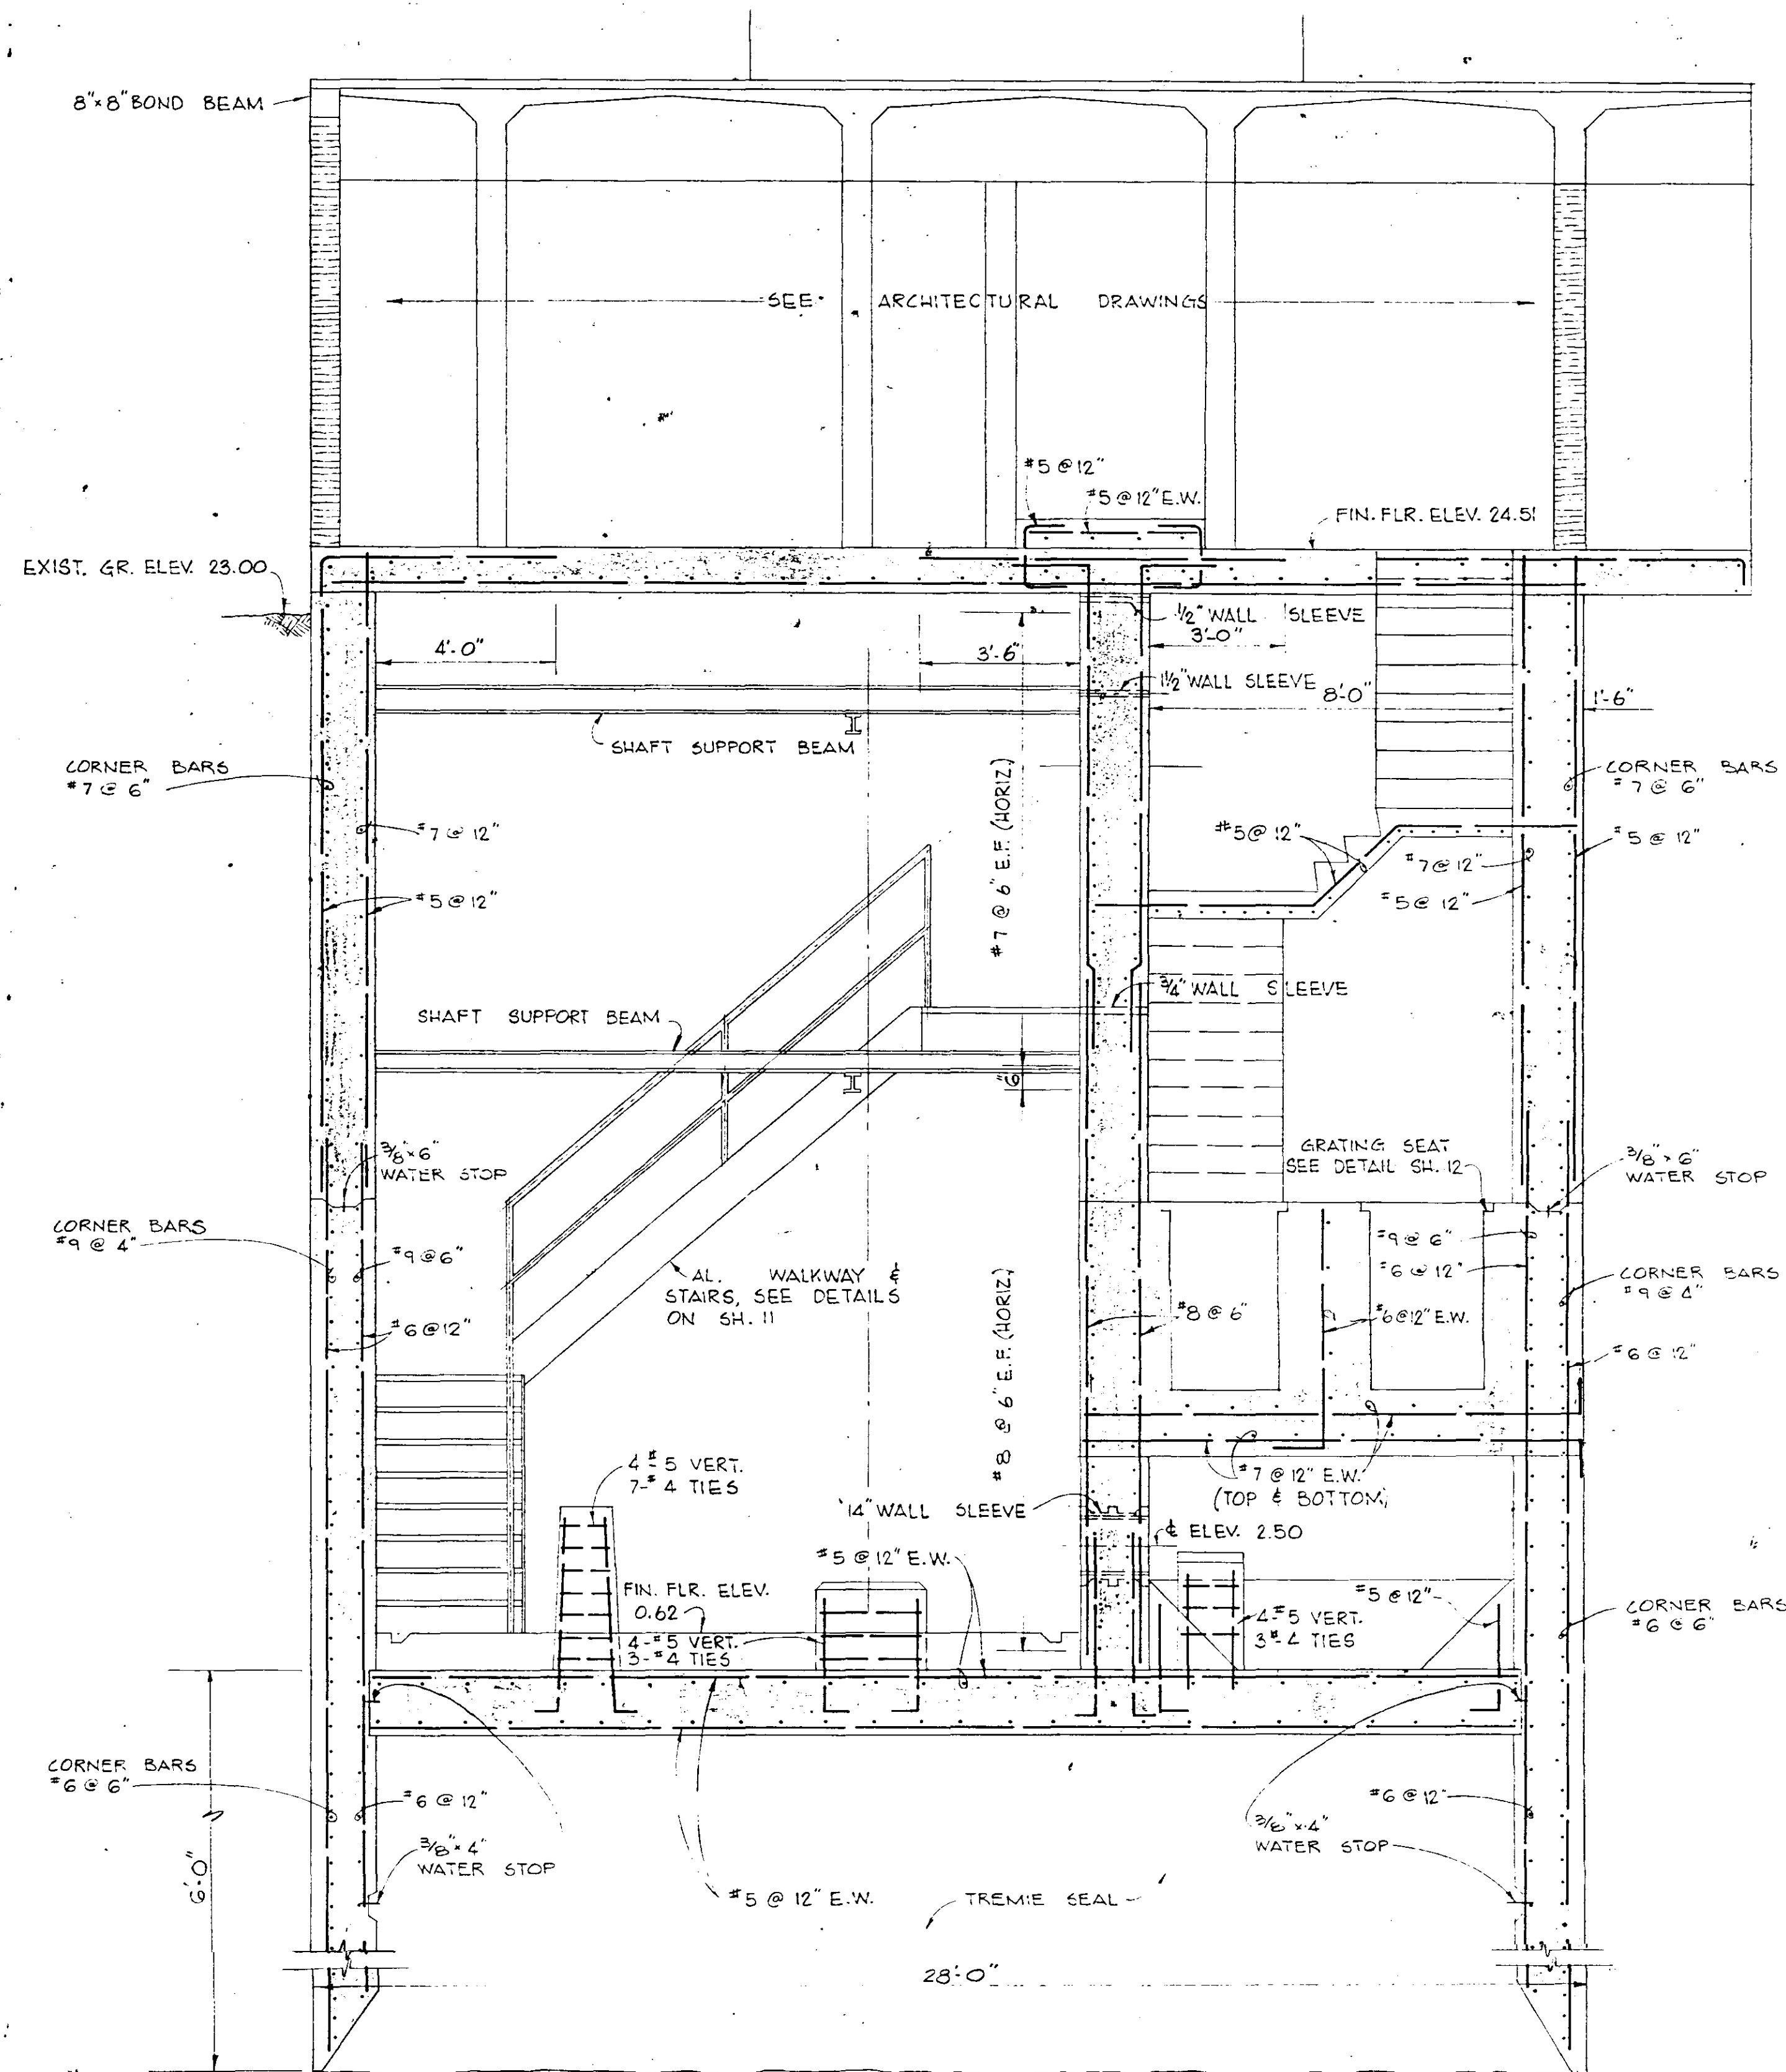

SECTION 21
13/14

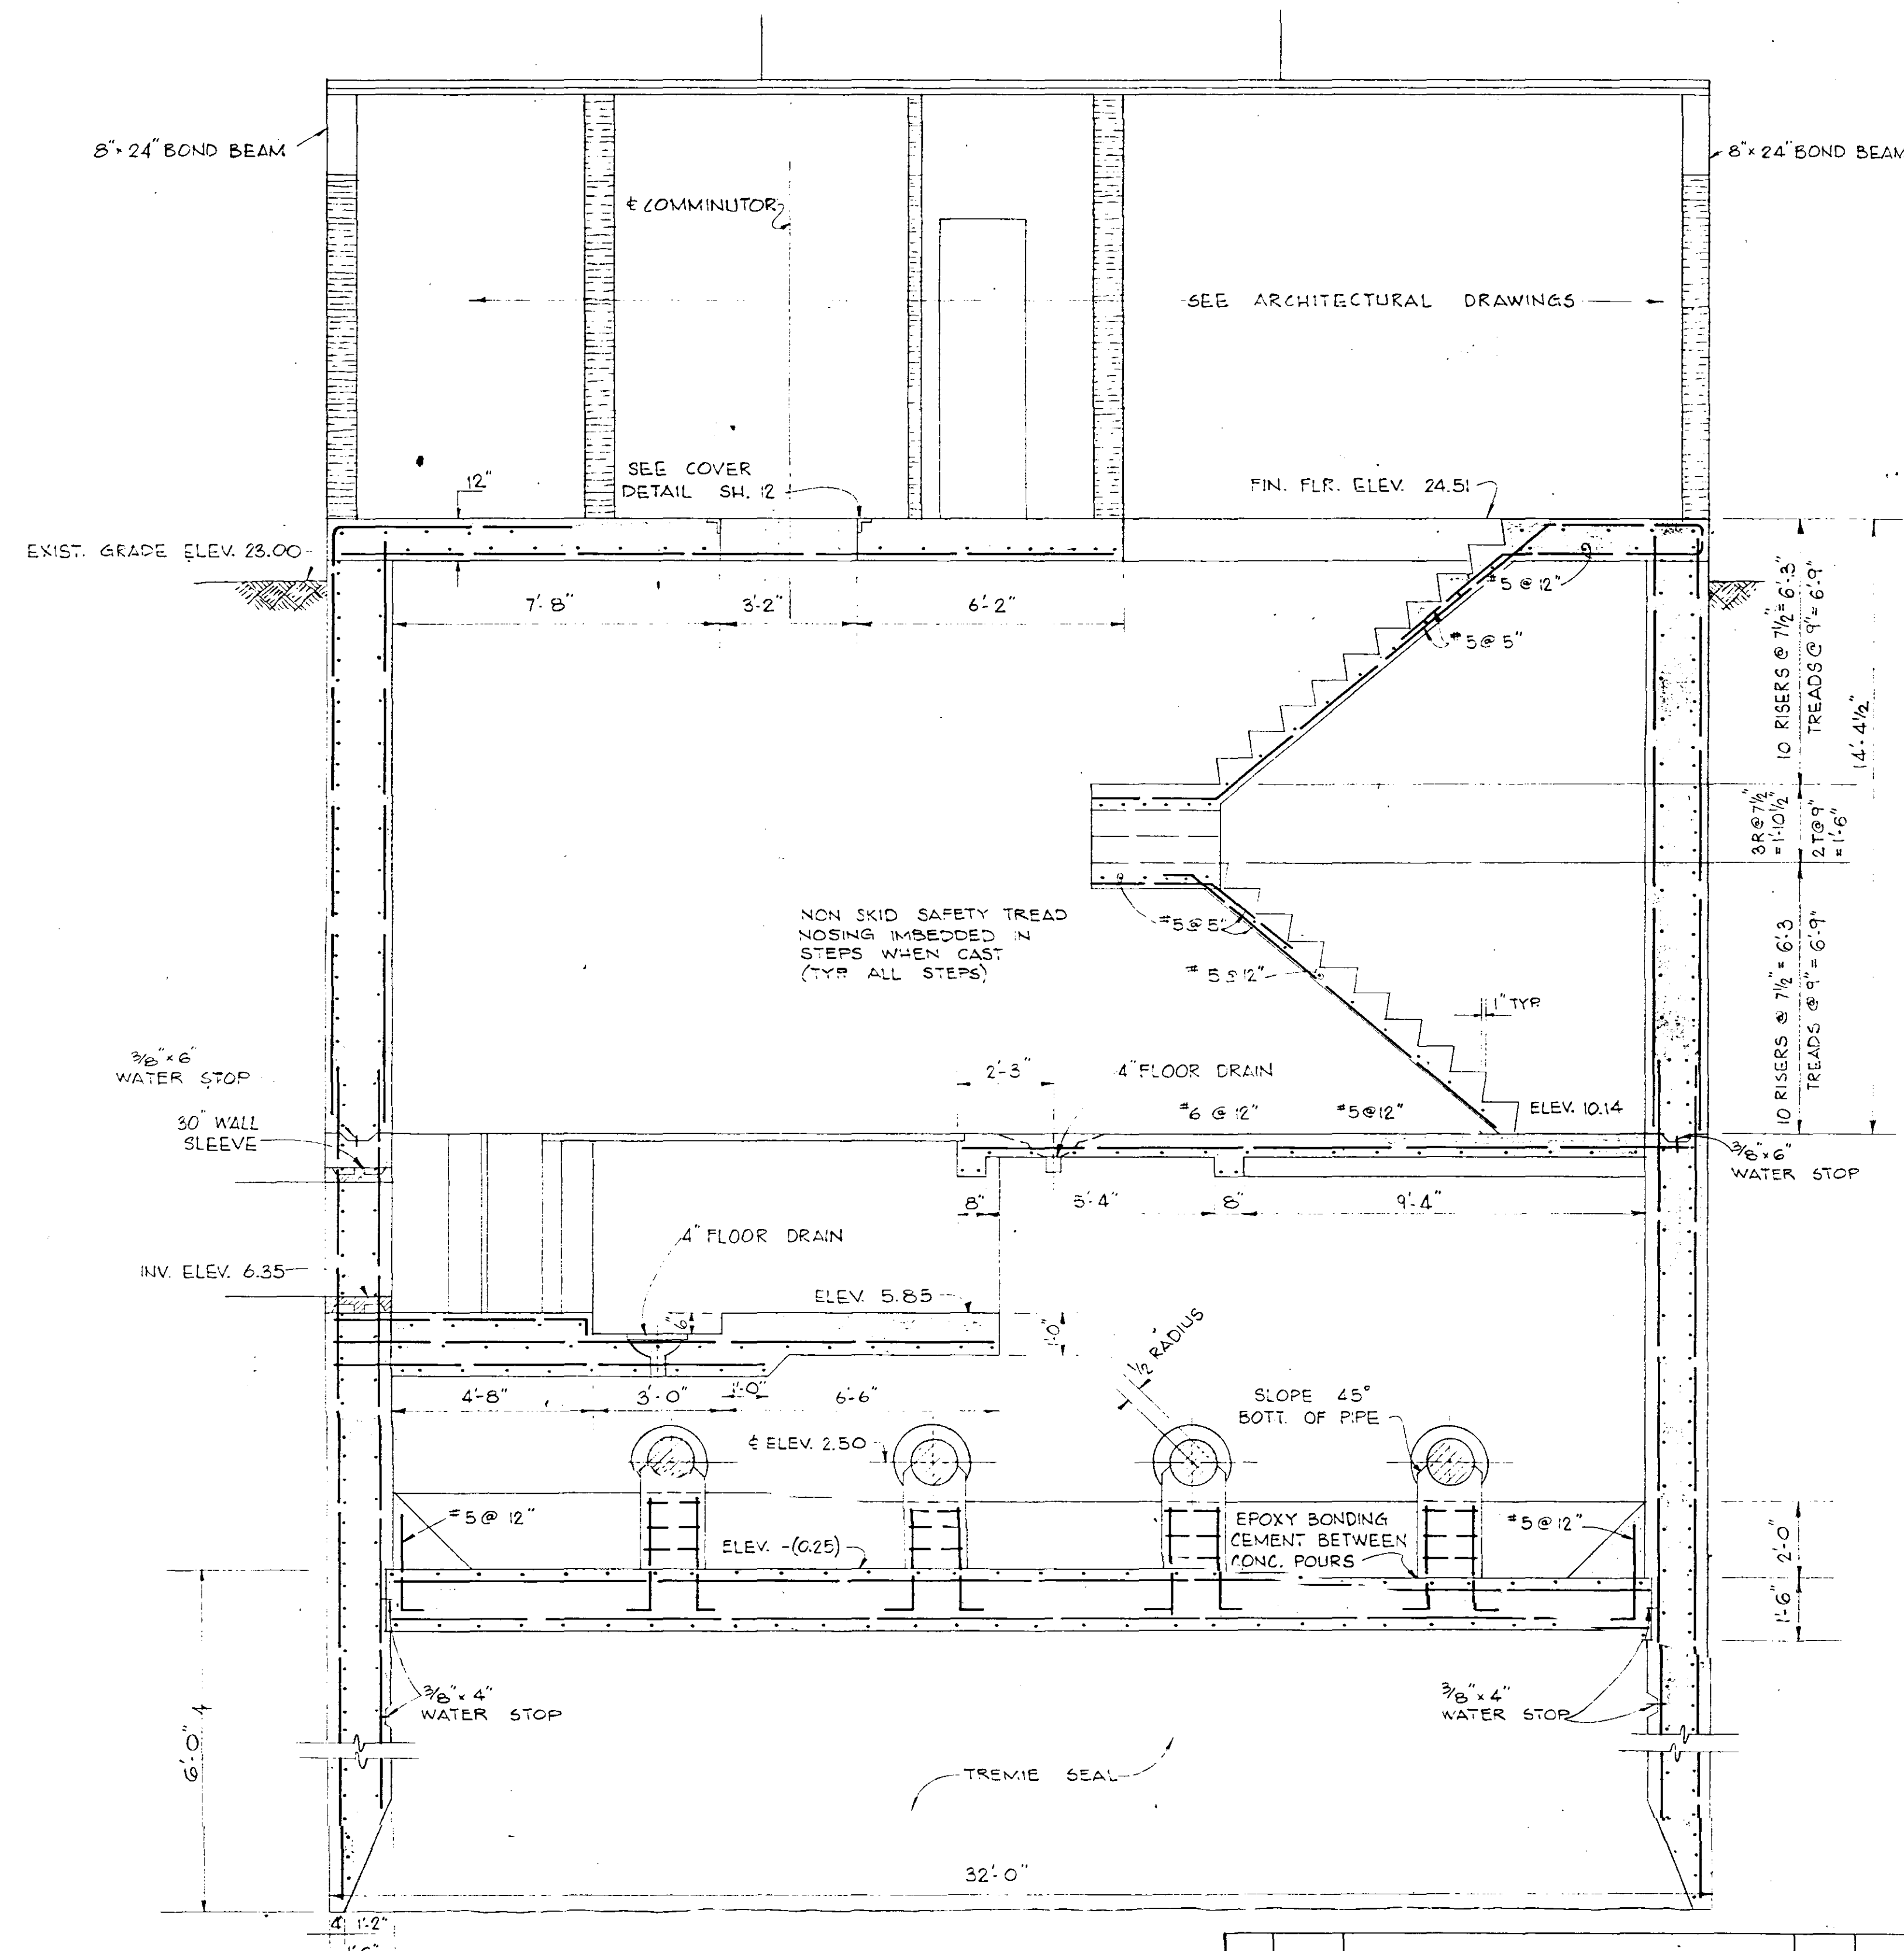

SECTION 19
13/14


RECORD DRAWING


DATE 7-76 BY RJB

CK LKN

18-05

RECORD DRAWING		NO. DATE	
DESCRIPTION		BY CKD.	
REVISIONS			
RUSSELL & AXON			
Engineers — Planners — Architects			
DAYTONA BEACH, FLORIDA		FLORIDA	
SANITARY SEWERAGE PROJECT			
PART D			
SECTION III — MASTER LIFT STATION I D			
STRUCTURAL-SECTIONS			
MANATEE COUNTY, FLORIDA			
DESIGNED BY GER/JS	FILE NO. 6681 - 8b	SHEET NO. 14	
DRAWN BY RLB	CHECKED BY JWC/JS	OF 23 SHEETS	
DATE OCT. 1973	SCALE: 3/8" = 1'-0"		

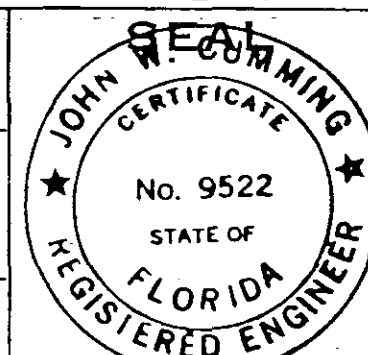

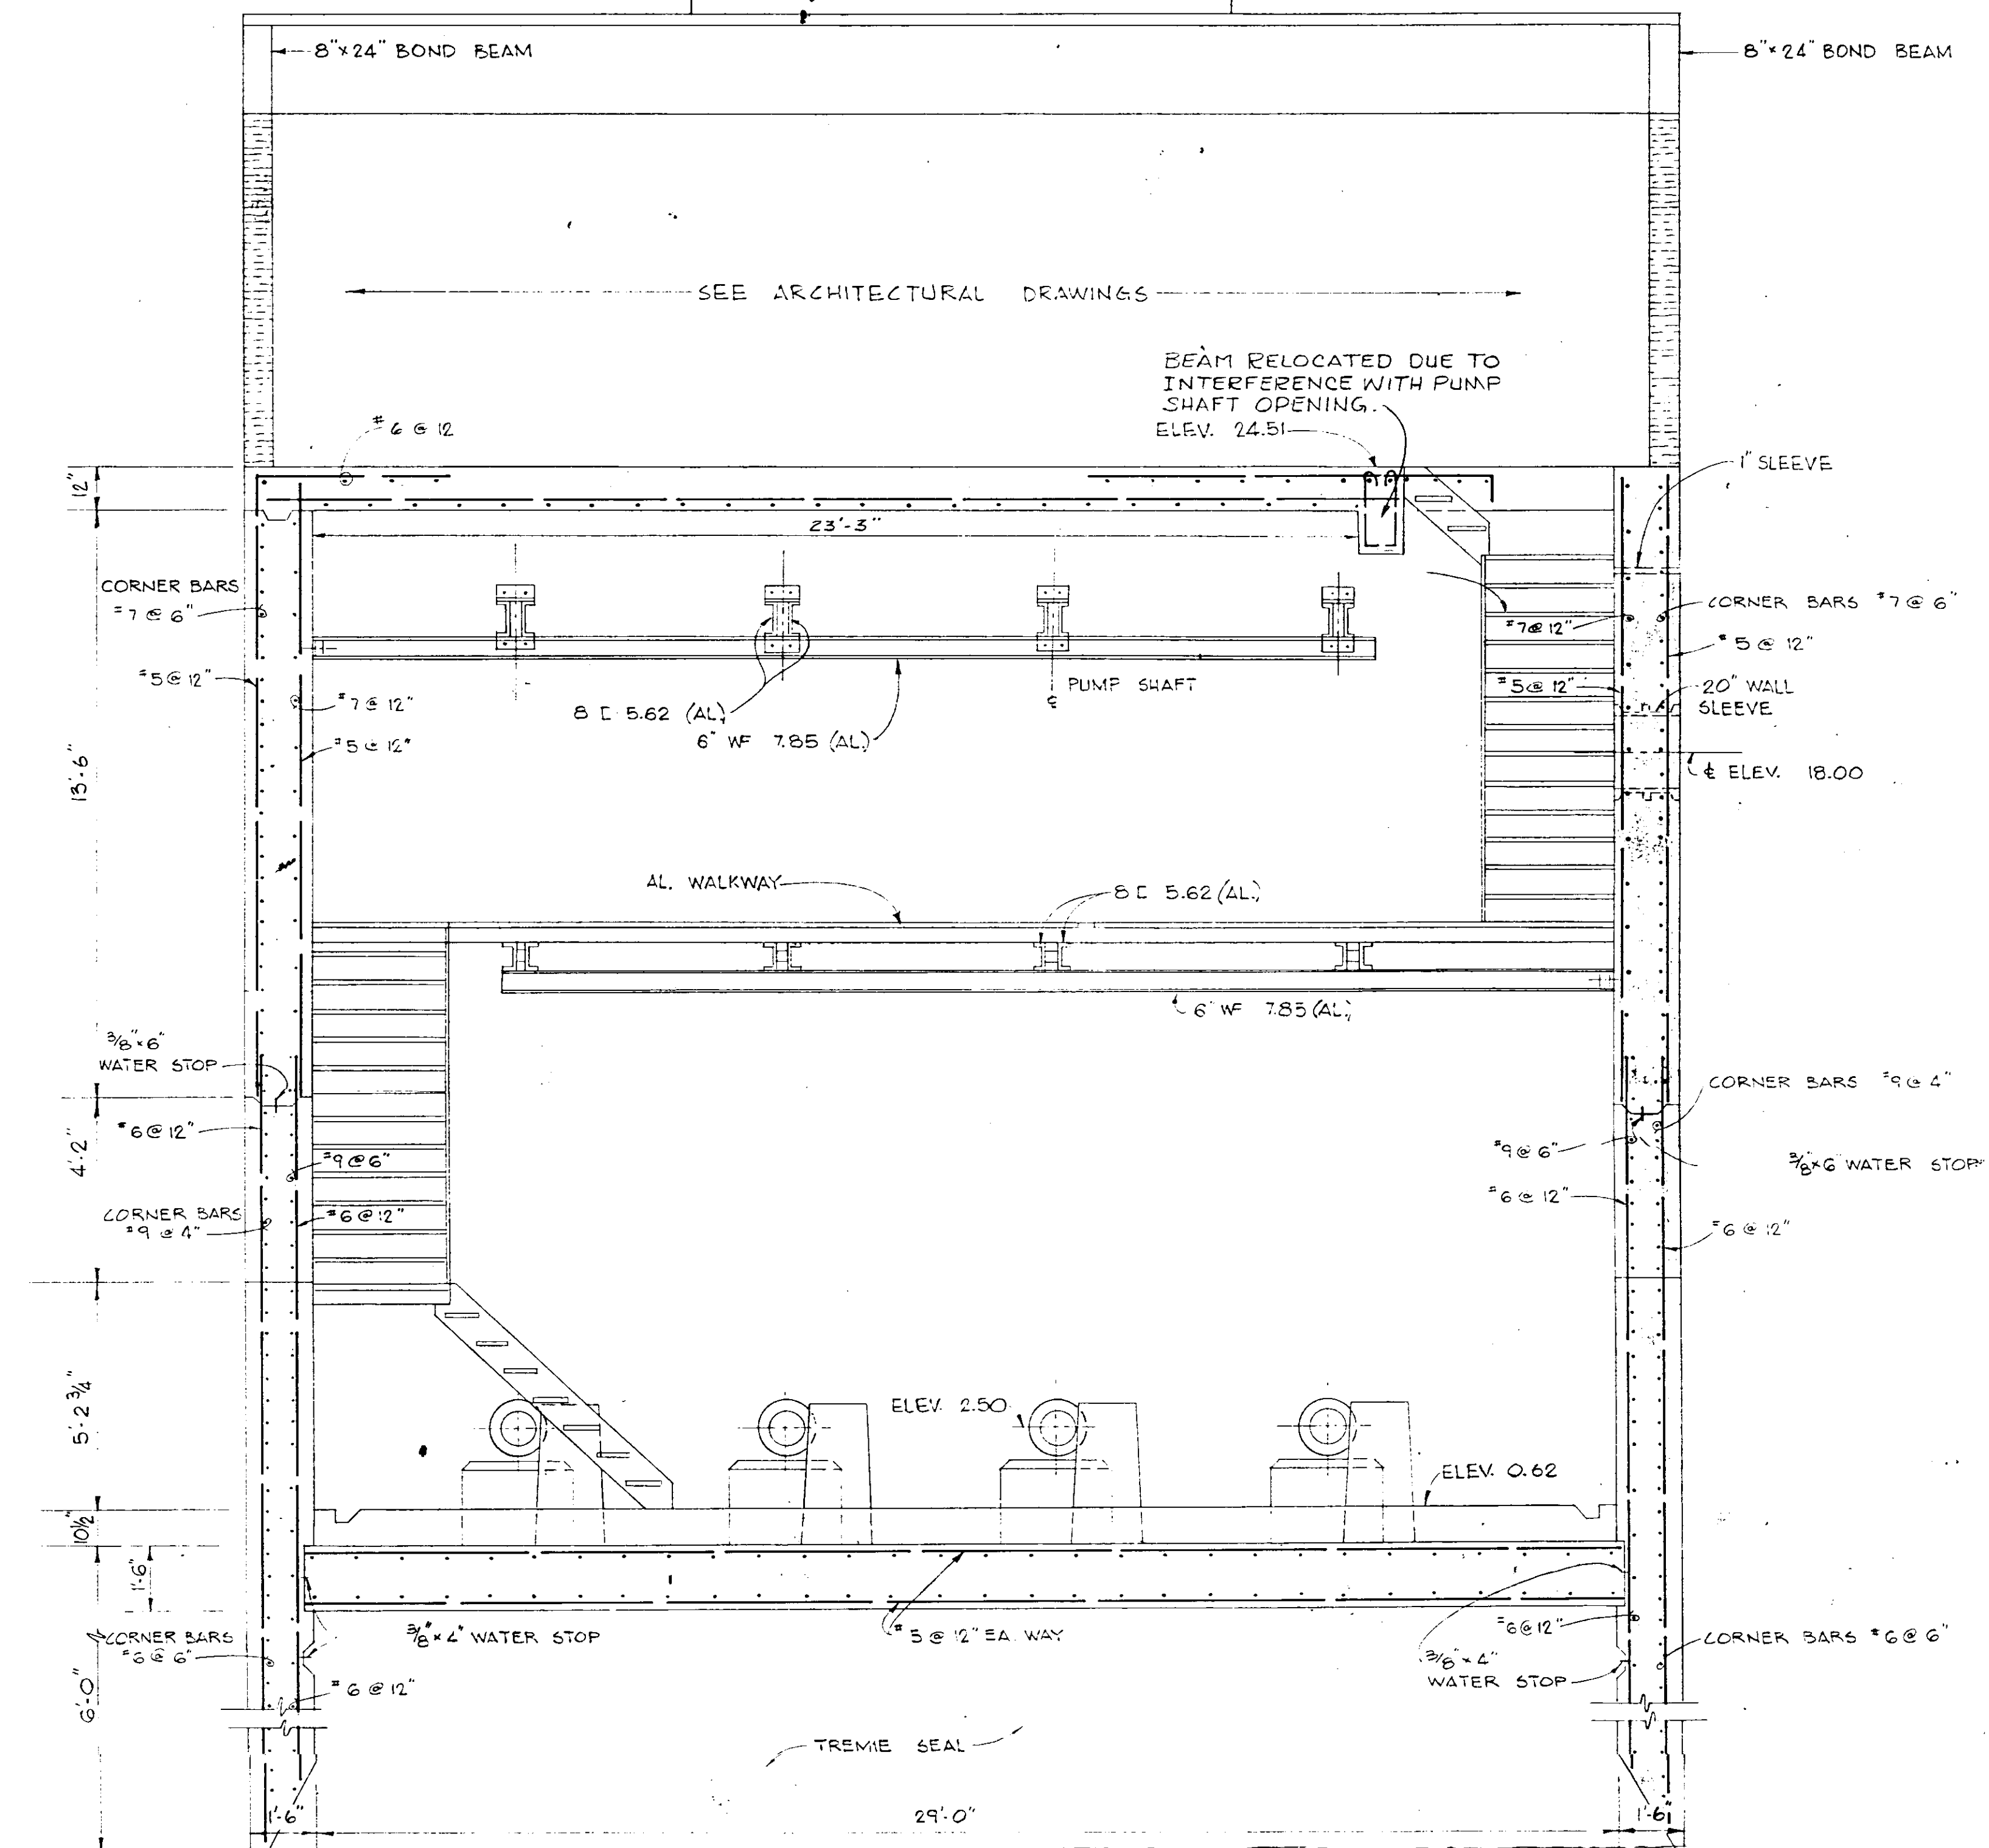


SECTION 20
13 15

RECORD DRAWING

DATE 7-76 BY P.J.M.

CK LKN 805

NO.	DATE	DESCRIPTION	BY	CKD.
7-76		BEAM RELOCATED (RECORD DRAWING)	P.J.M.	W.D.
REVISIONS				
RUSSELL & AXON Engineers — Planners — Architects DAYTONA BEACH, FLORIDA				
SANITARY SEWERAGE PROJECT PART D SECTION III - MASTER LIFT STATION I D STRUCTURAL - SECTION				
MANATEE COUNTY, FLORIDA				
DESIGNED BY	FILE NO.	SHEET NO. 15 OF 23 SHEETS SCALE: 3/8" = 1'-0"		
DRAWN BY	6681 - 8b			
CHECKED BY				
DATE		SEAL JOHN W. COMBING No. 9522 STATE OF FLORIDA REGISTERED ENGINEER		
OCT. 1973				

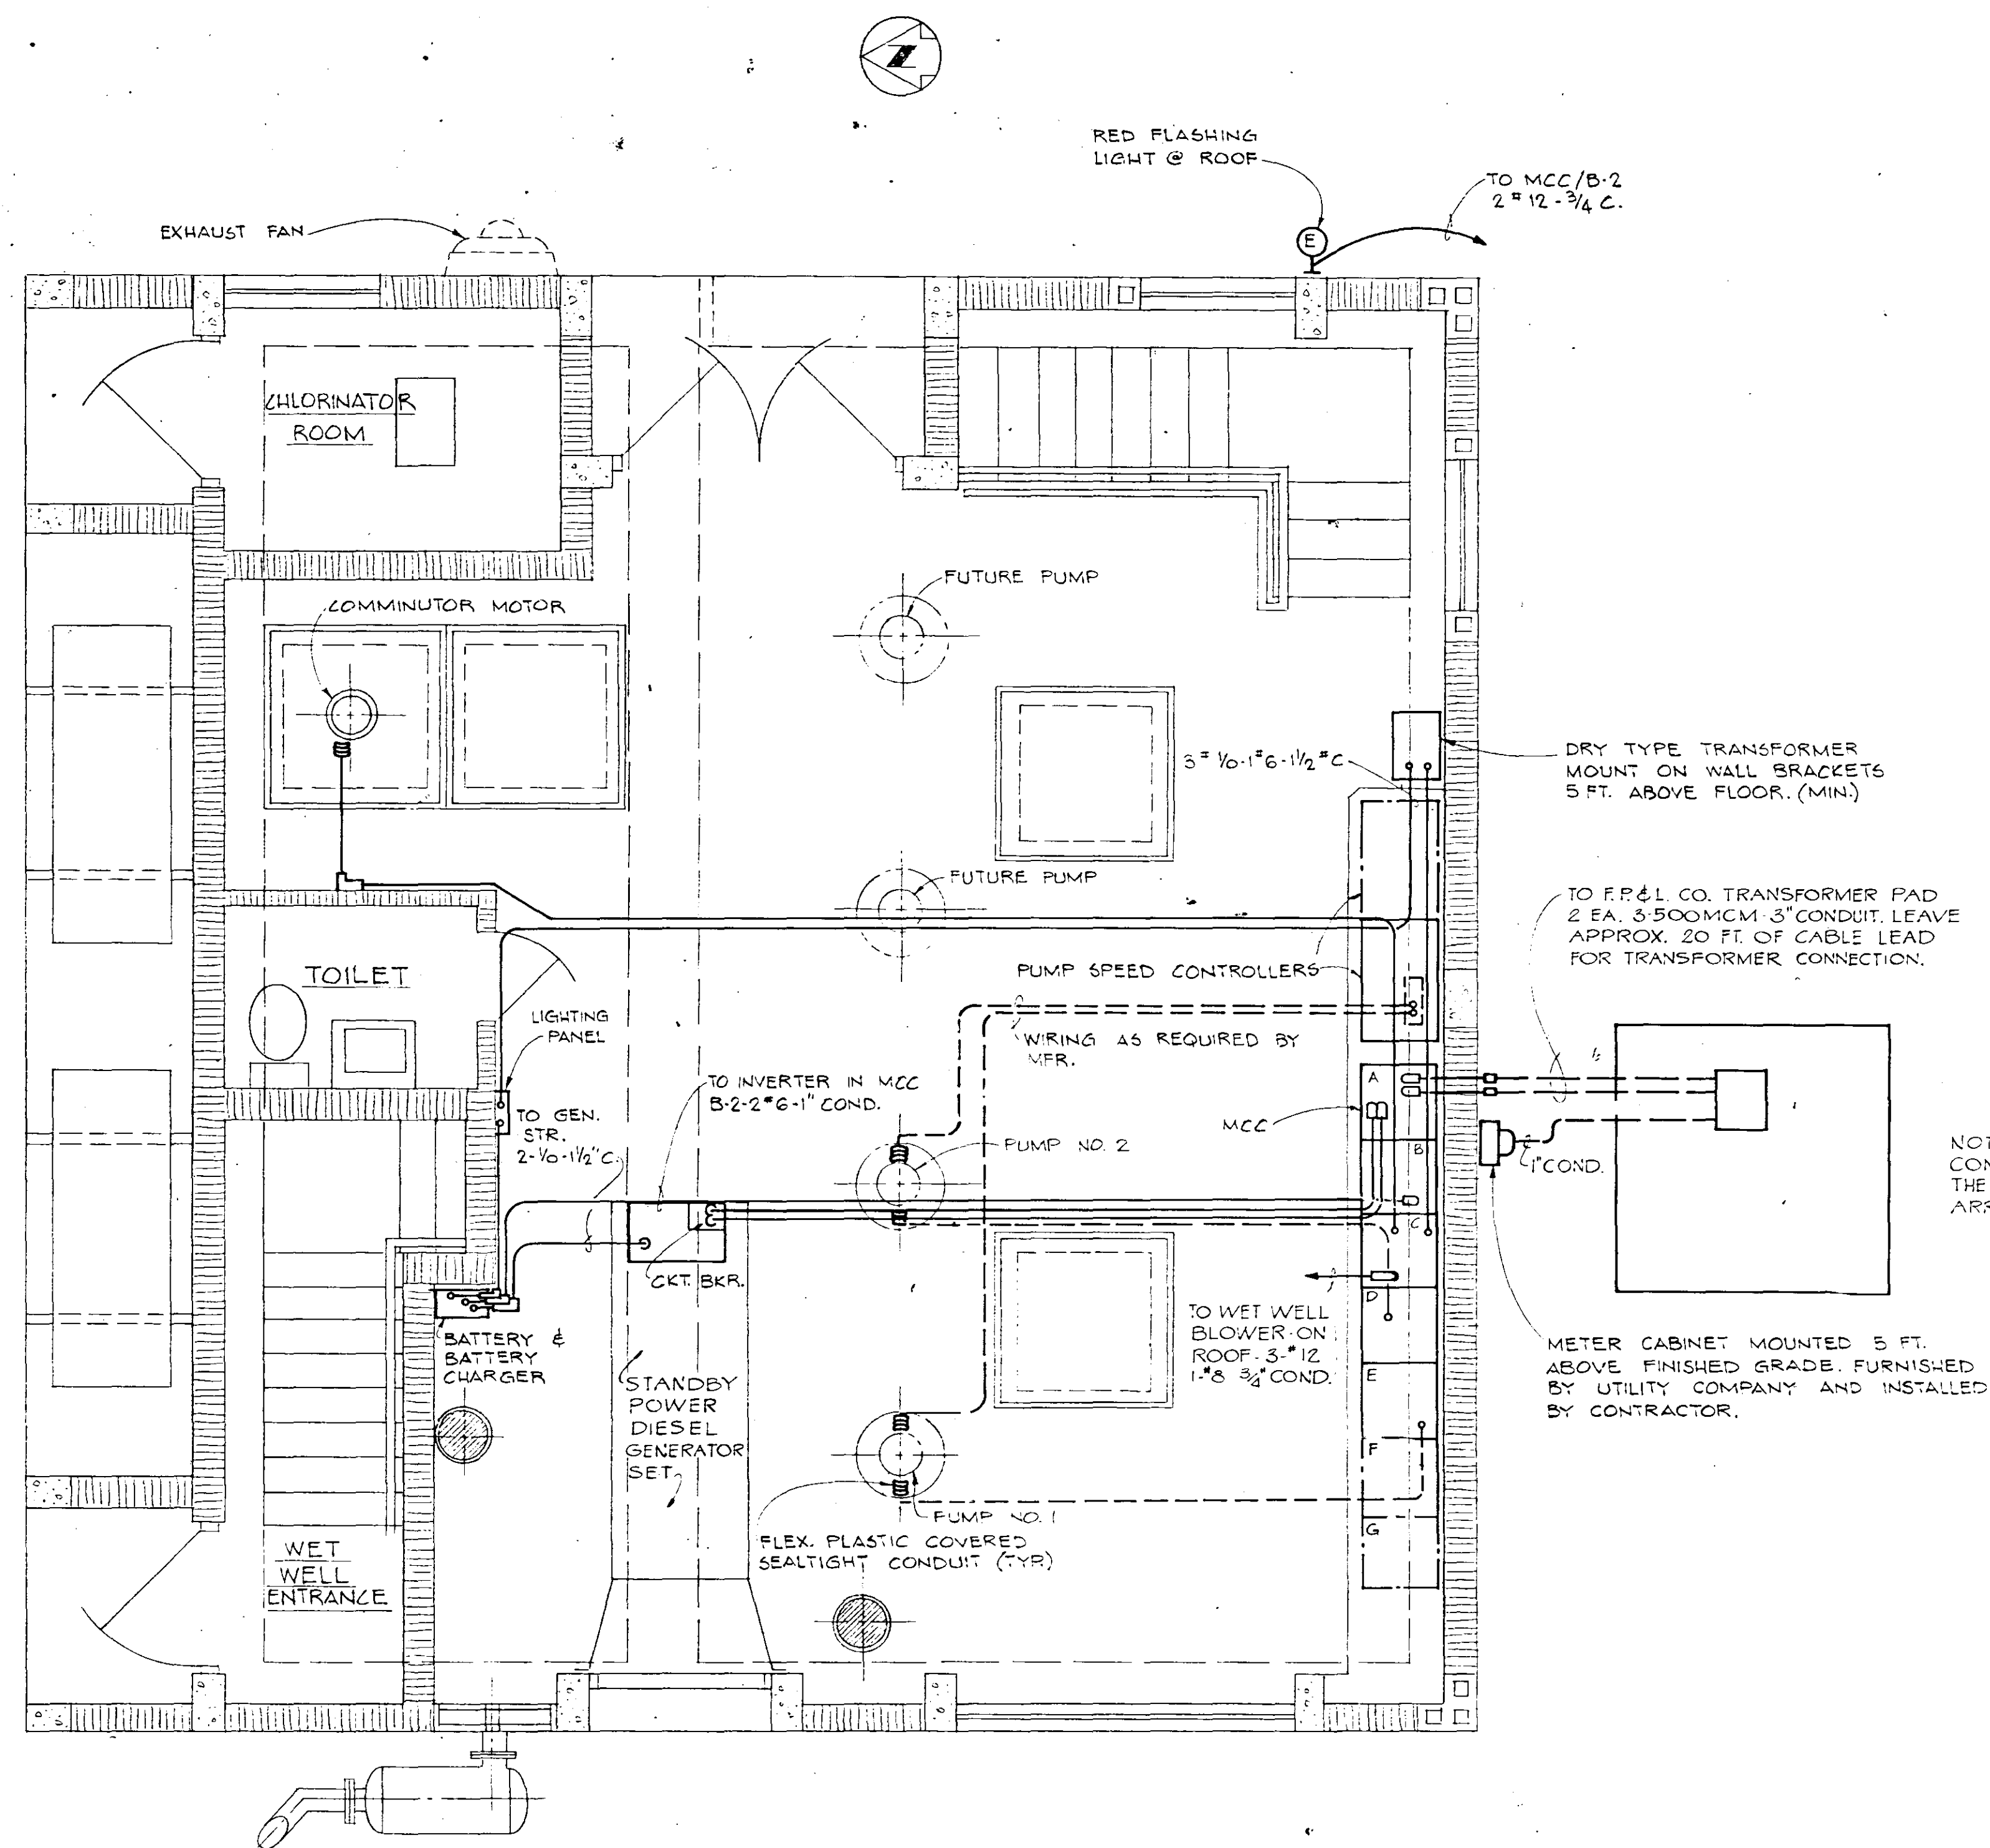

NOTE:
CONTRACTOR SHALL VERIFY W/UTILITY CO.,
THE LOCATION OF TRANSFORMER & CONDUIT
ARRANGEMENT, FOR SECONDARY CONNECTION.

PLAN - OPERATING FLOOR

NOTE:
RUN DOTTED CONDUITS UNDER
FLOOR SLAB OR UNDERGROUND.


RECORD DRAWING		DATE		BY		CHKD.	
NO.	DATE	DESCRIPTION	BY	CHKD.			
REVISIONS							
RUSSELL & AXON Engineers — Planners — Architects DAYTONA BEACH, FLORIDA							
SANITARY SEWERAGE PROJECT PART D SECTION III - MASTER LIFT STATION ELECTRICAL - WIRING FLOOR PLAN MANATEE COUNTY, FLORIDA							
DESIGNED BY	FILE NO.						
GER/SJG	6681 - 8b						
DRAWN BY	SHEET						
RLE	No. 16						
CHECKED BY	OF 23						
JWC	SHEETS						
DATE	SCALE: 3/8" = 1'-0"						
OCT. 1973							


RECORD DRAWING

DATE 7-76 BY PJM


CK. LKN

18-05

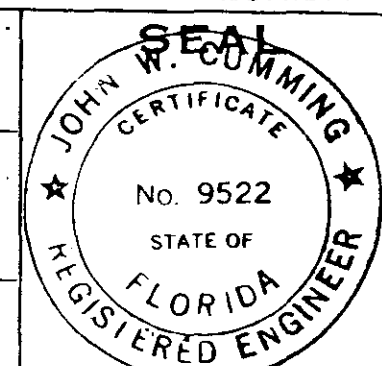


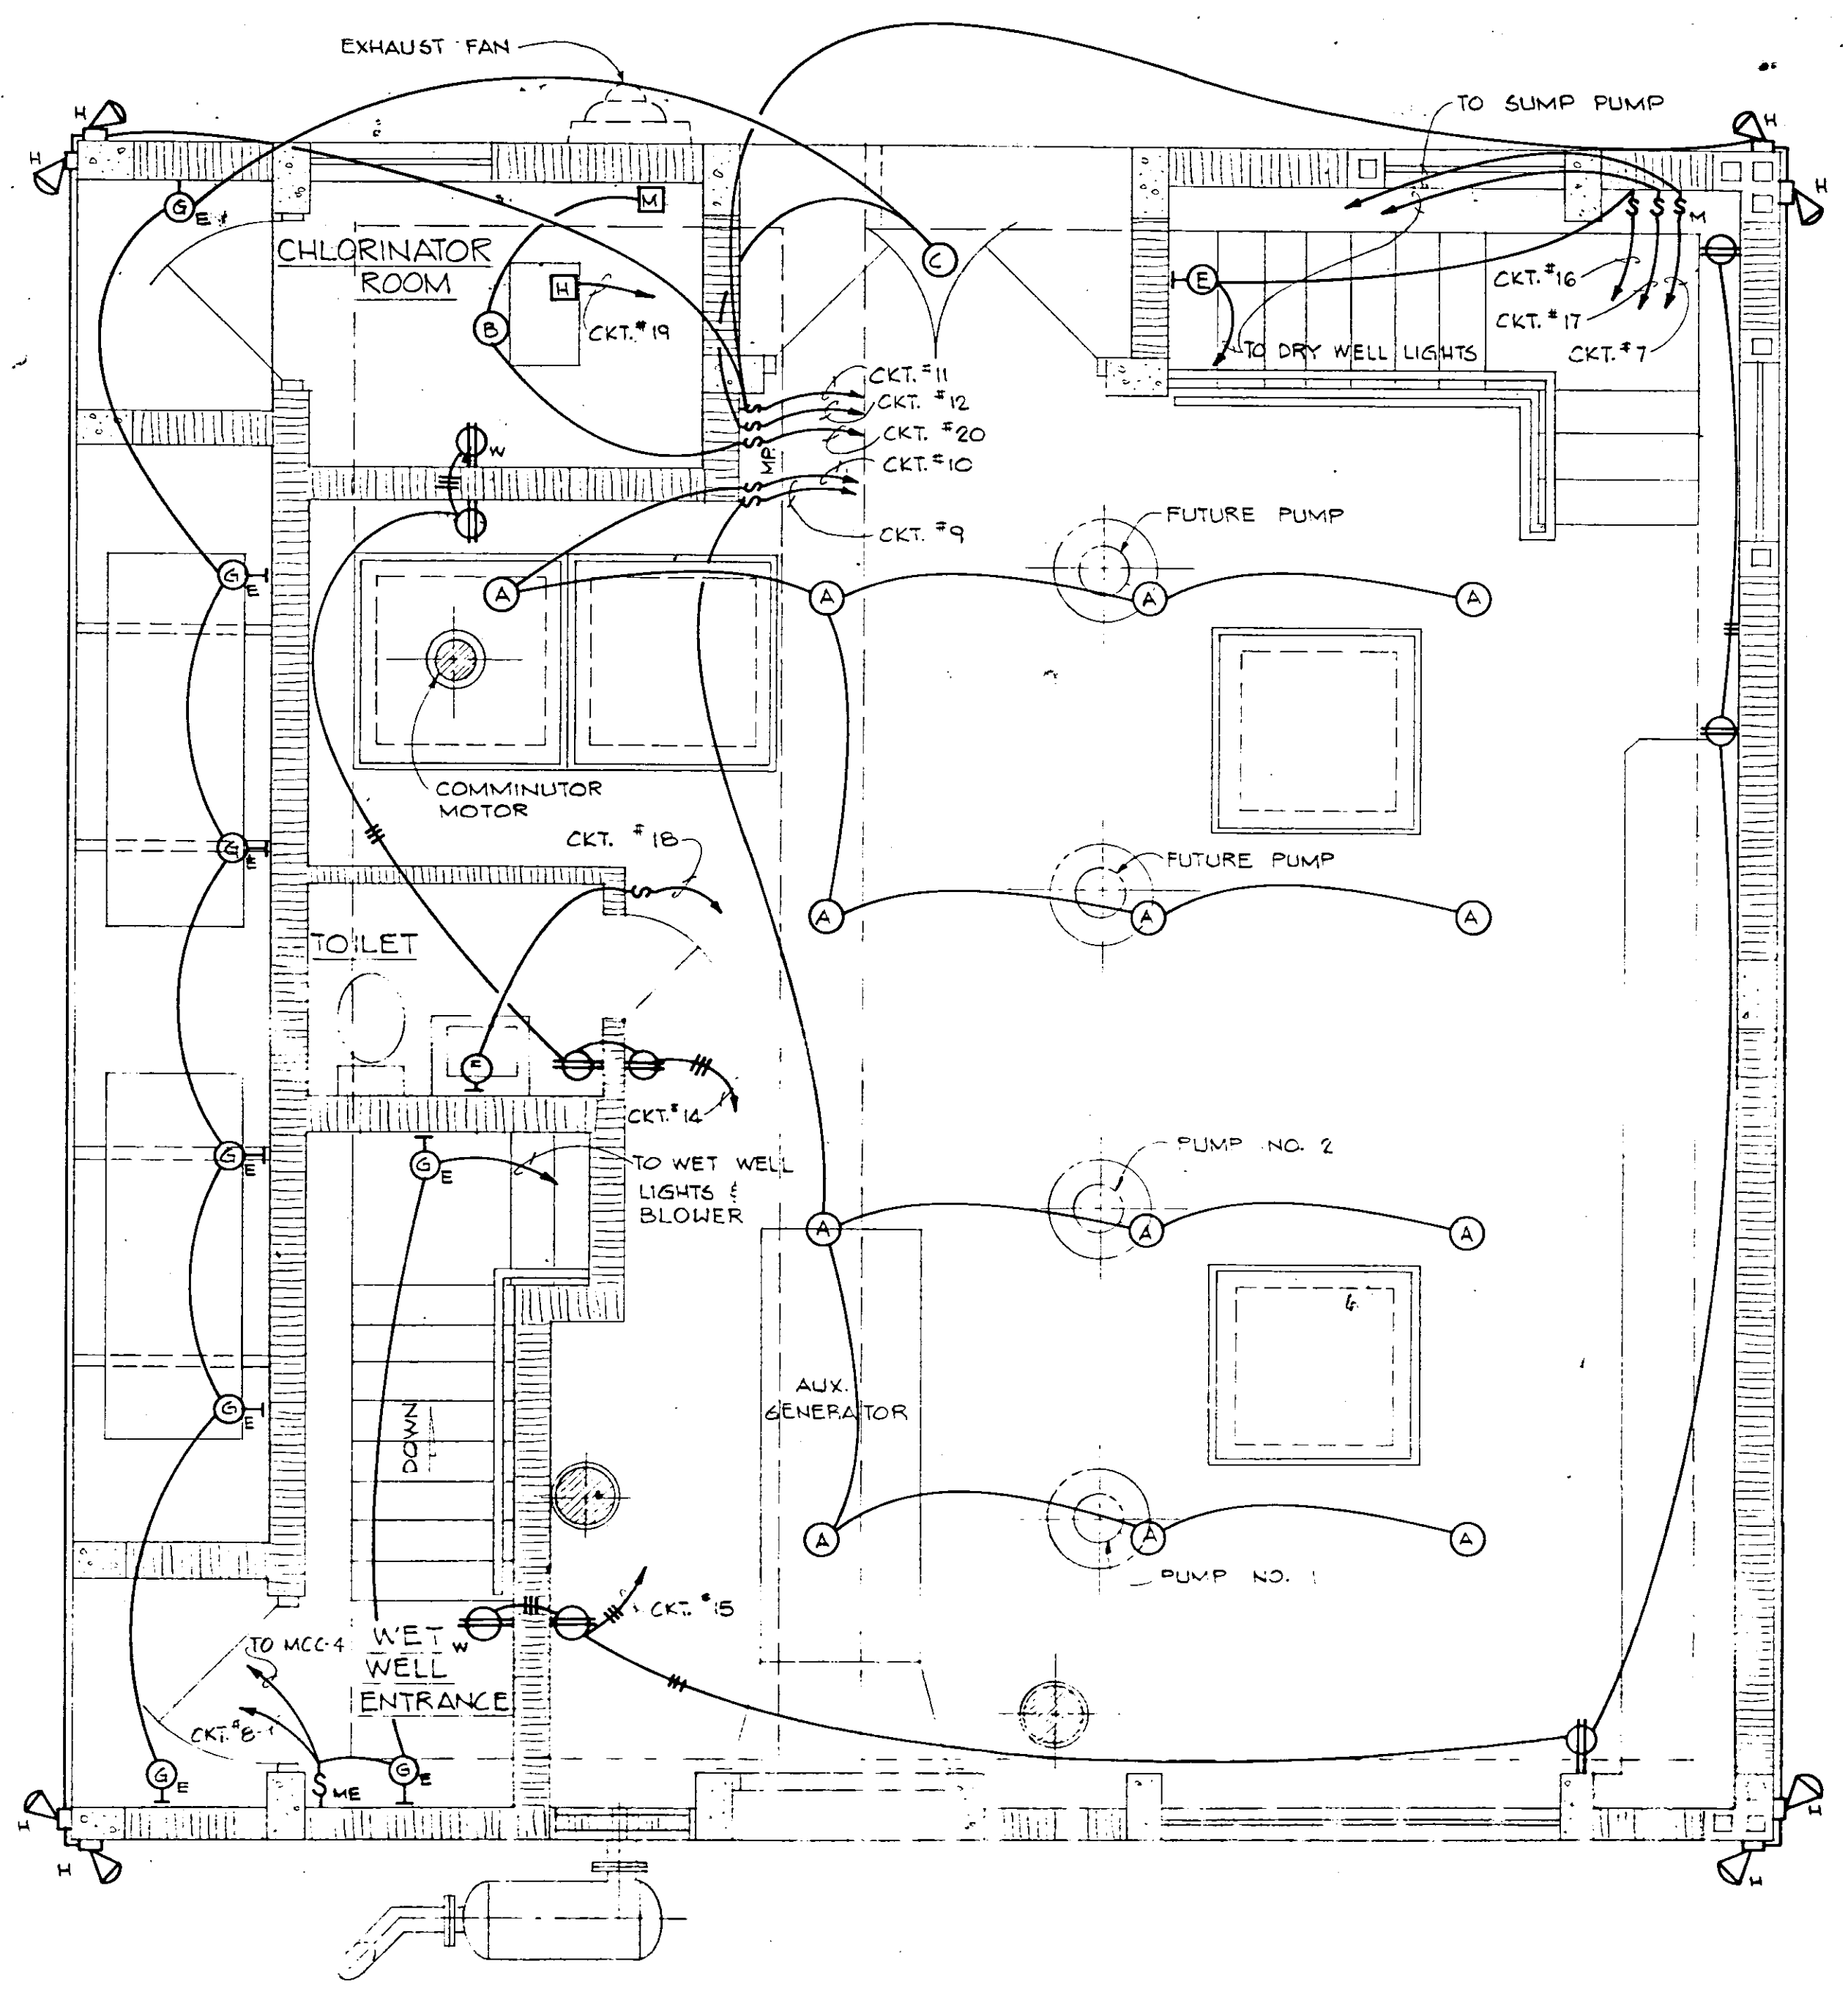

PLAN - OPERATING FLOOR

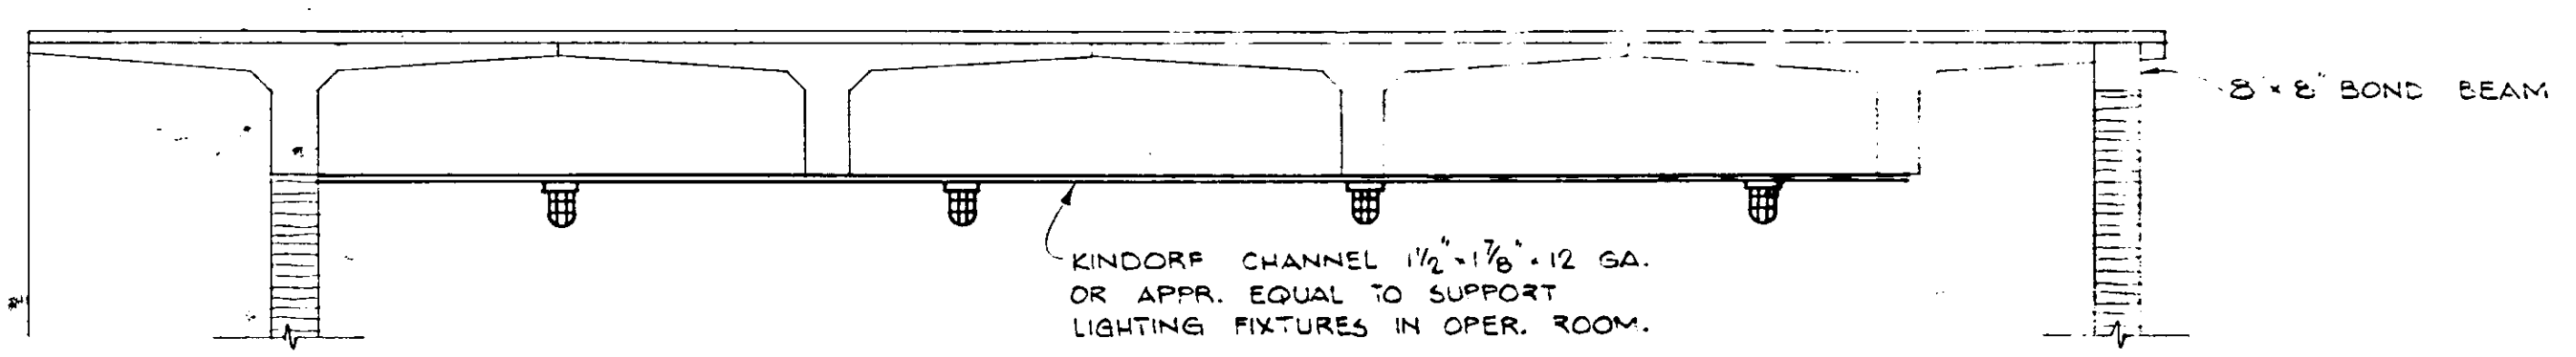

ELEVATION
OPERATING FLOOR


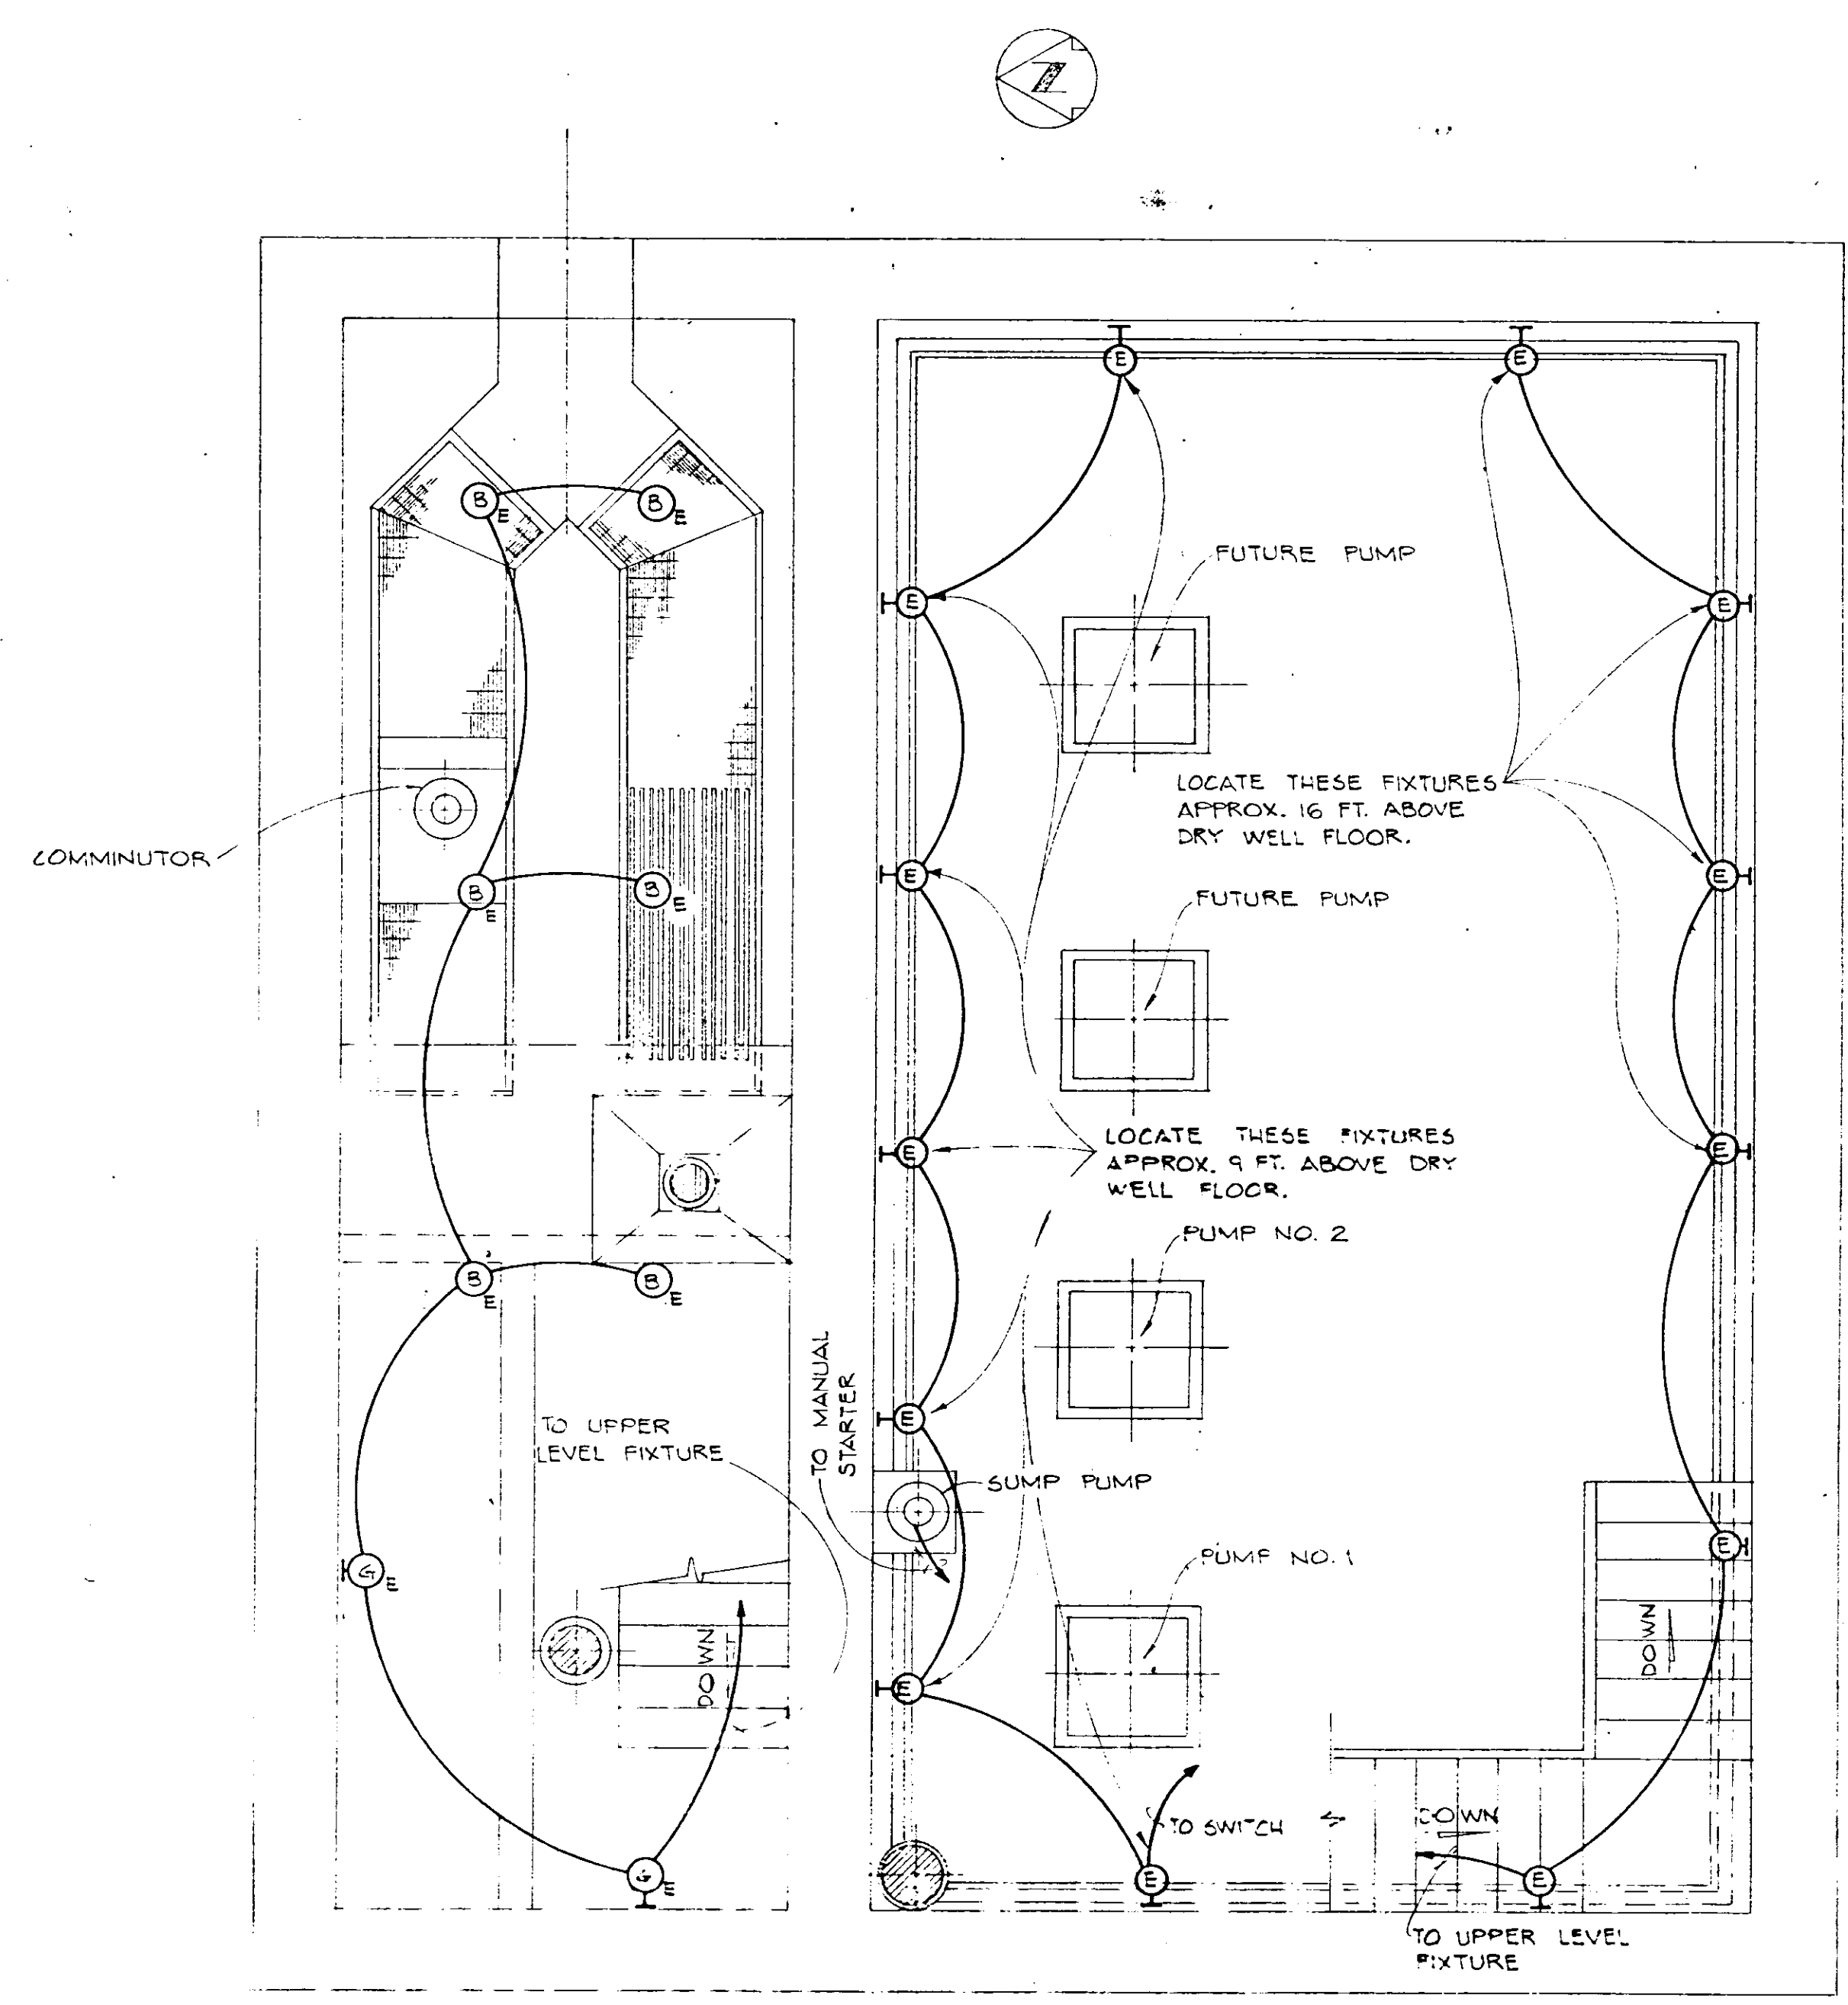


PLAN PUMP ROOM & WET WELL

RECORD DRAWING
DATE 7-16 BY PJM
CK. LKN 18-05

RECORD DRAWING		CHANGE ORDER NO. 1		BY JLB		CHK. SJG	
NO.	DATE	DESCRIPTION		REVISIONS			
RUSSELL & AXON Engineers — Planners — Architects DAYTONA BEACH, FLORIDA							
SANITARY SEWERAGE PROJECT PART D SECTION III MASTER LIFT STATION ELECTRICAL - LIGHTING							
MANATEE COUNTY, FLORIDA							
DESIGNED BY GER/SJG		FILE NO. 6681-8b		SHEET 17		No. 9522 STATE OF FLORIDA REGISTERED ENGINEER	
DRAWN BY RLB		CHECKED BY JWC		DATE OCT. 1973		SCALE: 3/8" = 1'-0"	

MOTOR CONTROL CENTER - SINGLE LINE DIAGRAM

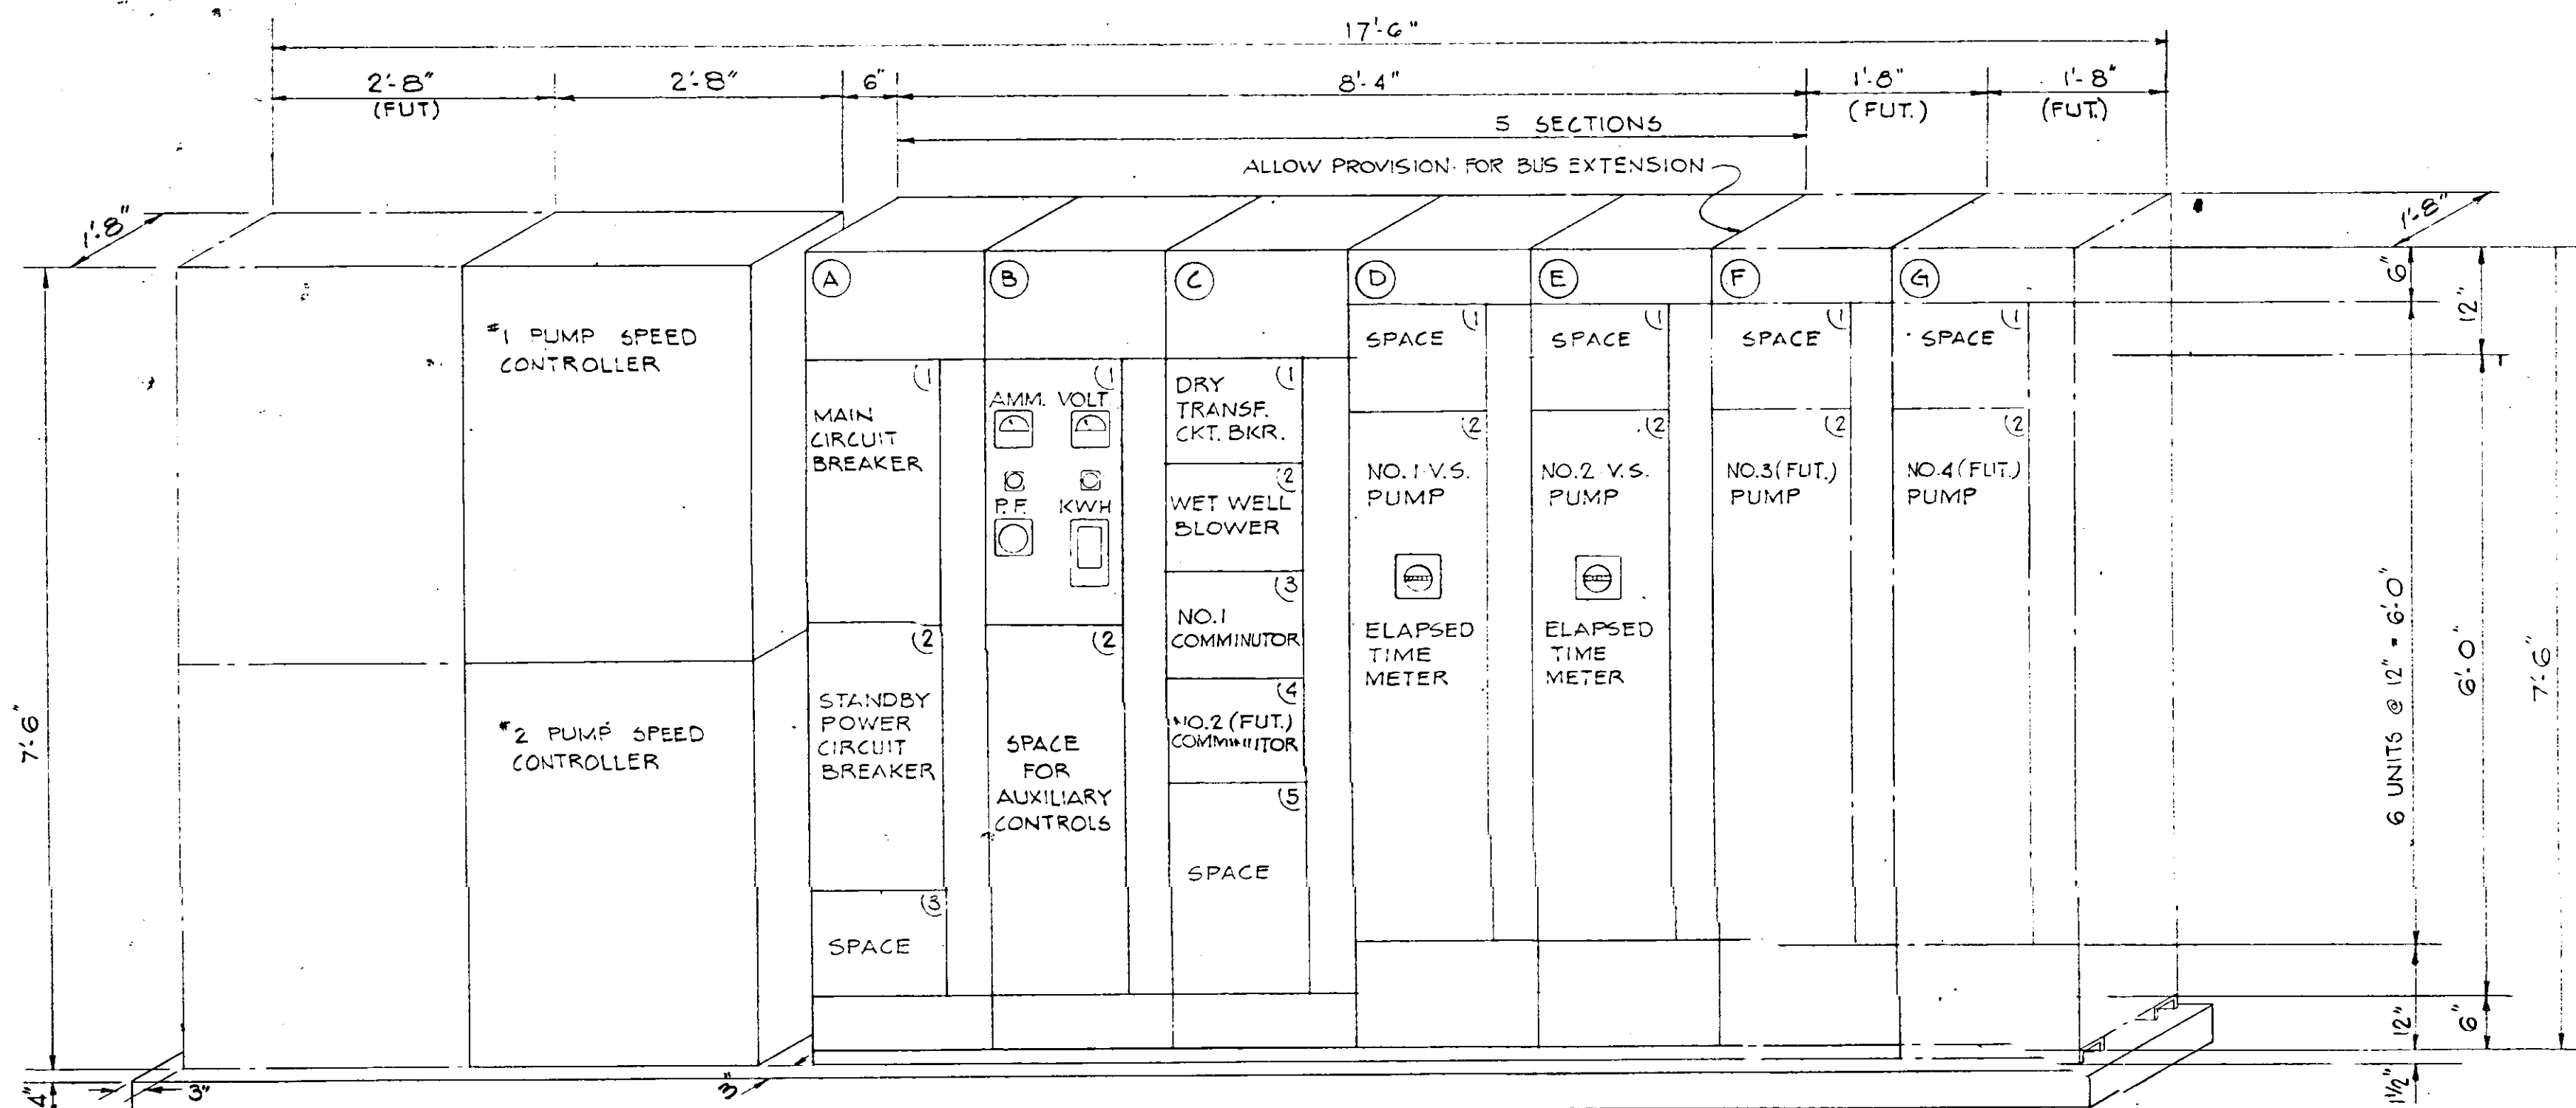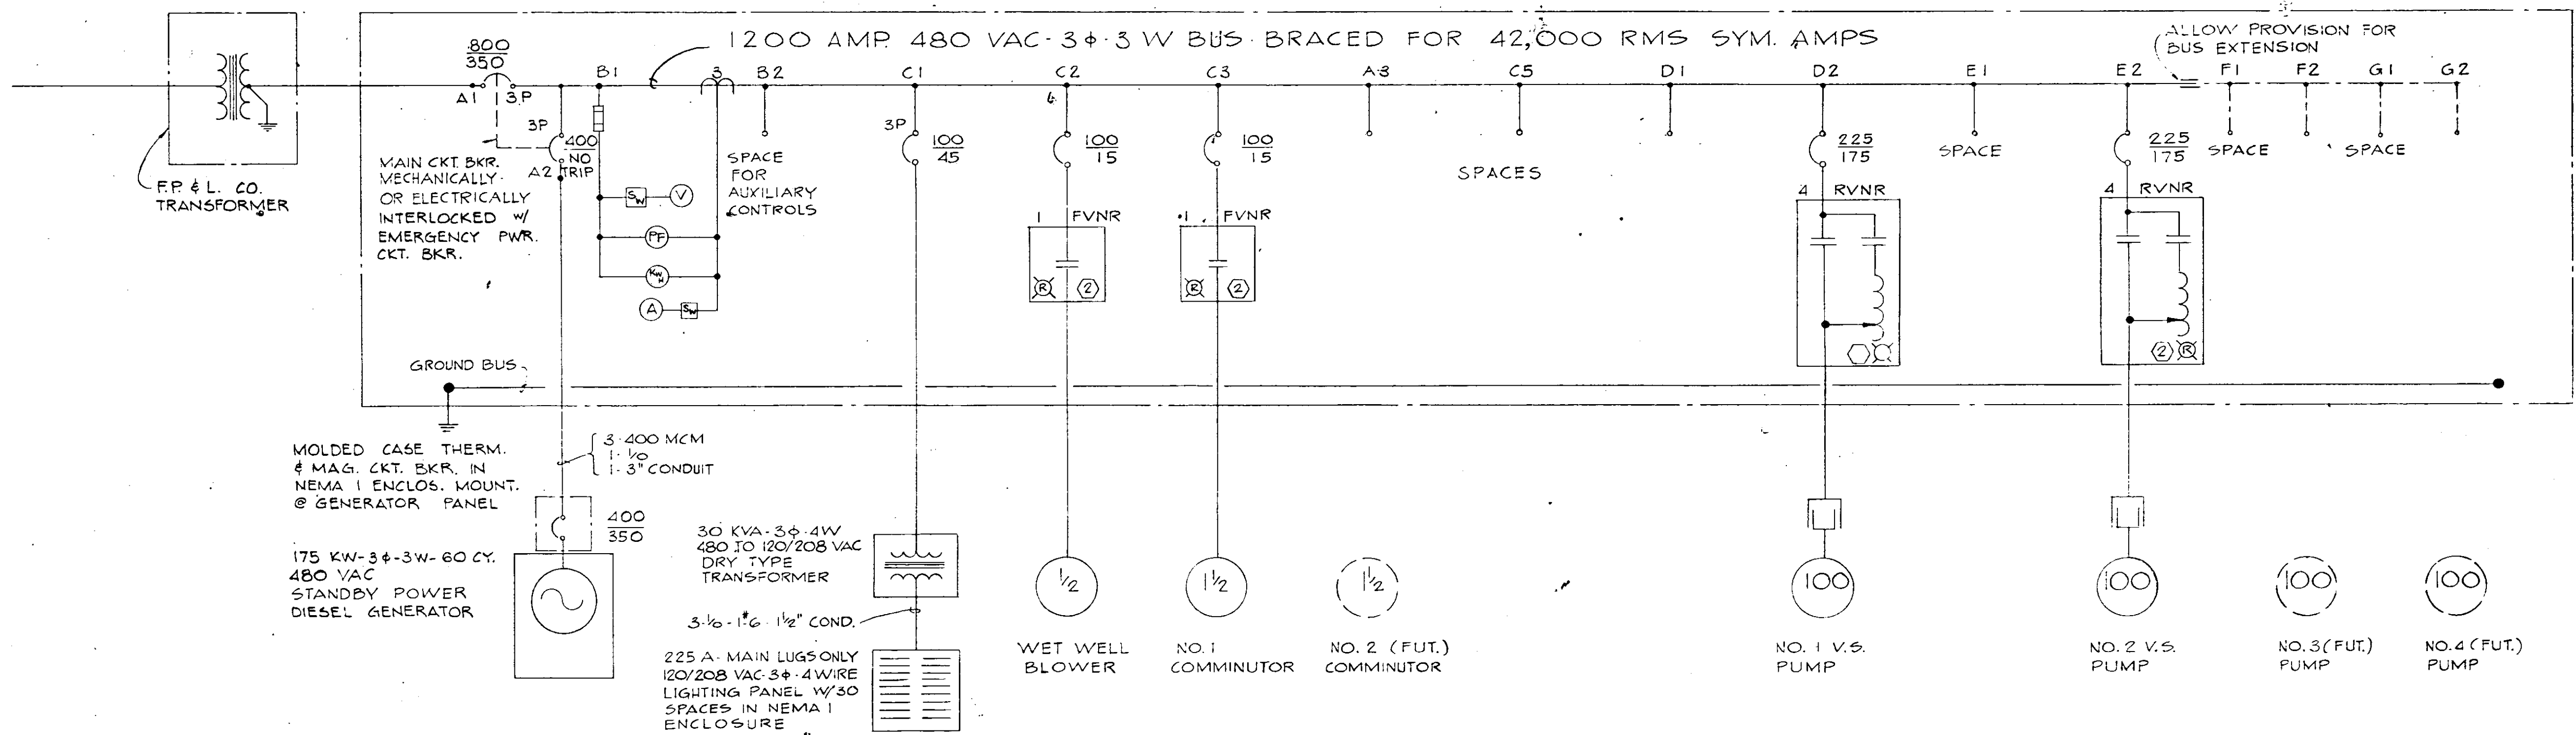

PUMP SPEED CONTROLLER LAYOUT

MOTOR CONTROL CENTER - LAYOUT

CKT. BKRS. A1 & B1 TO BE MECHANICALLY OR ELECTRICALLY INTERLOCKED TO PREVENT INDEPENDENT OPERATION (WHEN ONE BREAKER IS IN CLOSED POSITION THE OTHER MUST STAY OPEN & VICE-VERSA)

MOTOR CONTROL CENTER SCHEDULE																								
MCC SEC.	UNIT NO.	LOAD		CKT. BKR.			MOTOR STARTER				MODIFICATION 6							WIRING		COND.	SERVICE			
		KVA	FLA	POLES	FRAME	TRIP	POLES	SIZE	TYPE	COIL VOLT.	MOT. RED	LIGHT GREEN	SELECT SW	F.B. LOCAL	STA. MCC	INTERLOCKS N.O.	CONT. N.C.	RELAY TRANS. AUX.	C.T. YAWM			AMM SW.	PHASES	GRD.
A	1			3	800	350															6500MCM		2-3'	MAIN CKT. BKR
	2		263	3	400	NO TRIP																		STANDBY PWR. CKT. BKR.
	3																							SPACE
B	1																							METERING EQUIPMENT
	2																							SPACE FOR AUX. CONTROLS
C	1	30	2.6	3	100	45															3*8	1*8	1"	DRY XFMR. CKT. BKR.
	2	1/2	1	3	100	15	3	1	FVNR	120	YES			YES	3	2					3*12	1*8	3/4"	WET WELL BLOWER
	3	1 1/2	2.6	3	100	15	3	1	FVNR	120	YES			YES	3	2					3*12	1*8	3/4"	NO. 1 COMMUNITOR
	4	1 1/2																						NO. 2 COMMUNITOR (FUT.)
D	5																							SPACE
	1																							SPACE
	2	100	124	3	225	175	3	4	RVNR	120	YES			YES	3	2					3*8	1*4	2"	NO. 1 V.S. PUMP
E	1																							SPACE
	2	100	24	3	225	175	3	4	RVNR	120	YES			YES	3	2					3*20	1*4	2"	NO. 2 V.S. PUMP
F	1																							SPACE
	2	100																						NO. 3 V.S. PUMP (FUT.)
G	1																							SPACE
	2	100																						NO. 4 V.S. PUMP (FUT.)


RECORD DRAWING		DATE		BY		CHKD.	
SEPT. 74		CHANGE ORDER NO. 1		J.E. 438		SVG	
REVISIONS							
RUSSELL & AXON							
Engineers - Planners - Architects							
DAYTONA BEACH, FLORIDA							
SANITARY SEWAGE PROJECT							
PART D							
SECTION III - MASTER LIFT STATION I D							
ELECTRICAL - MOTOR CONTROL							
MANATEE COUNTY, FLORIDA							
DESIGNED BY	FILE NO.						
GER/SJG	6681-8b						
DRAWN BY	SHEET						
RLB	(18)						
CHECKED BY	OF 23						
JWC							
DATE	SCALE: NONE						
OCT. 1973							

RECORD DRAWING


DATE 7-76 BY PJM

CHKD. JKN


18-05

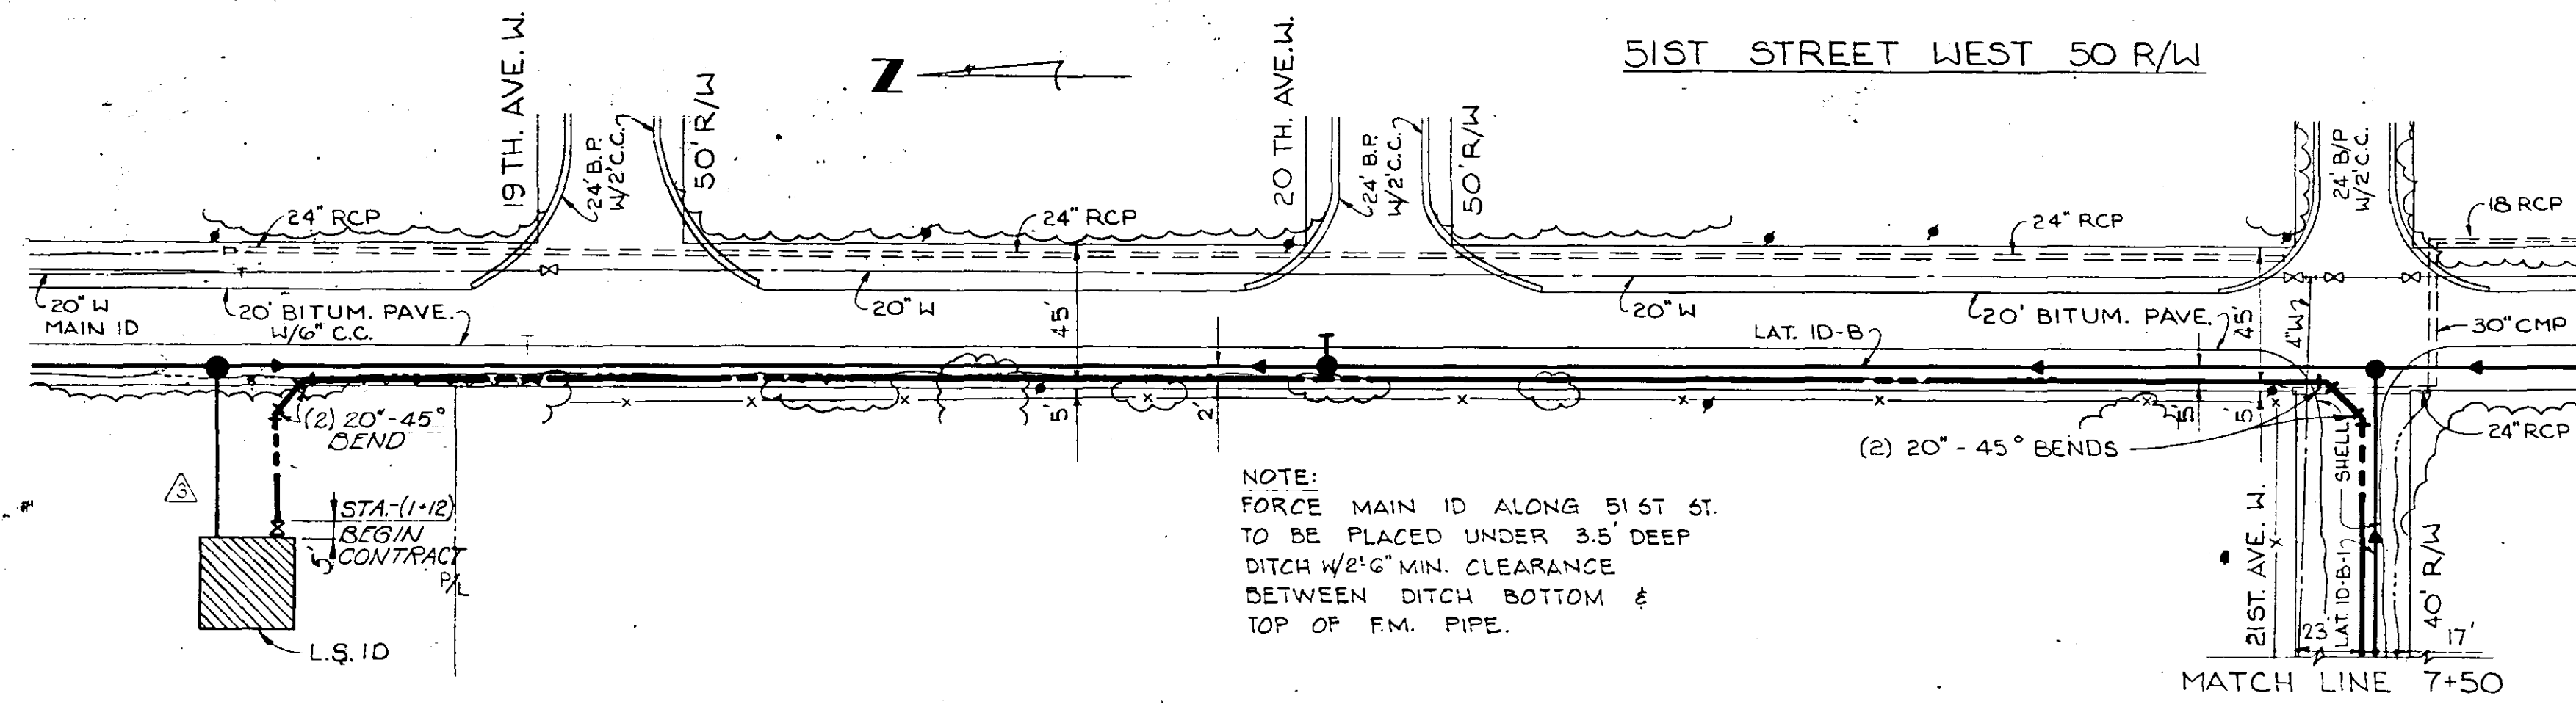


PROPOSED 20" FORCE MAIN ID

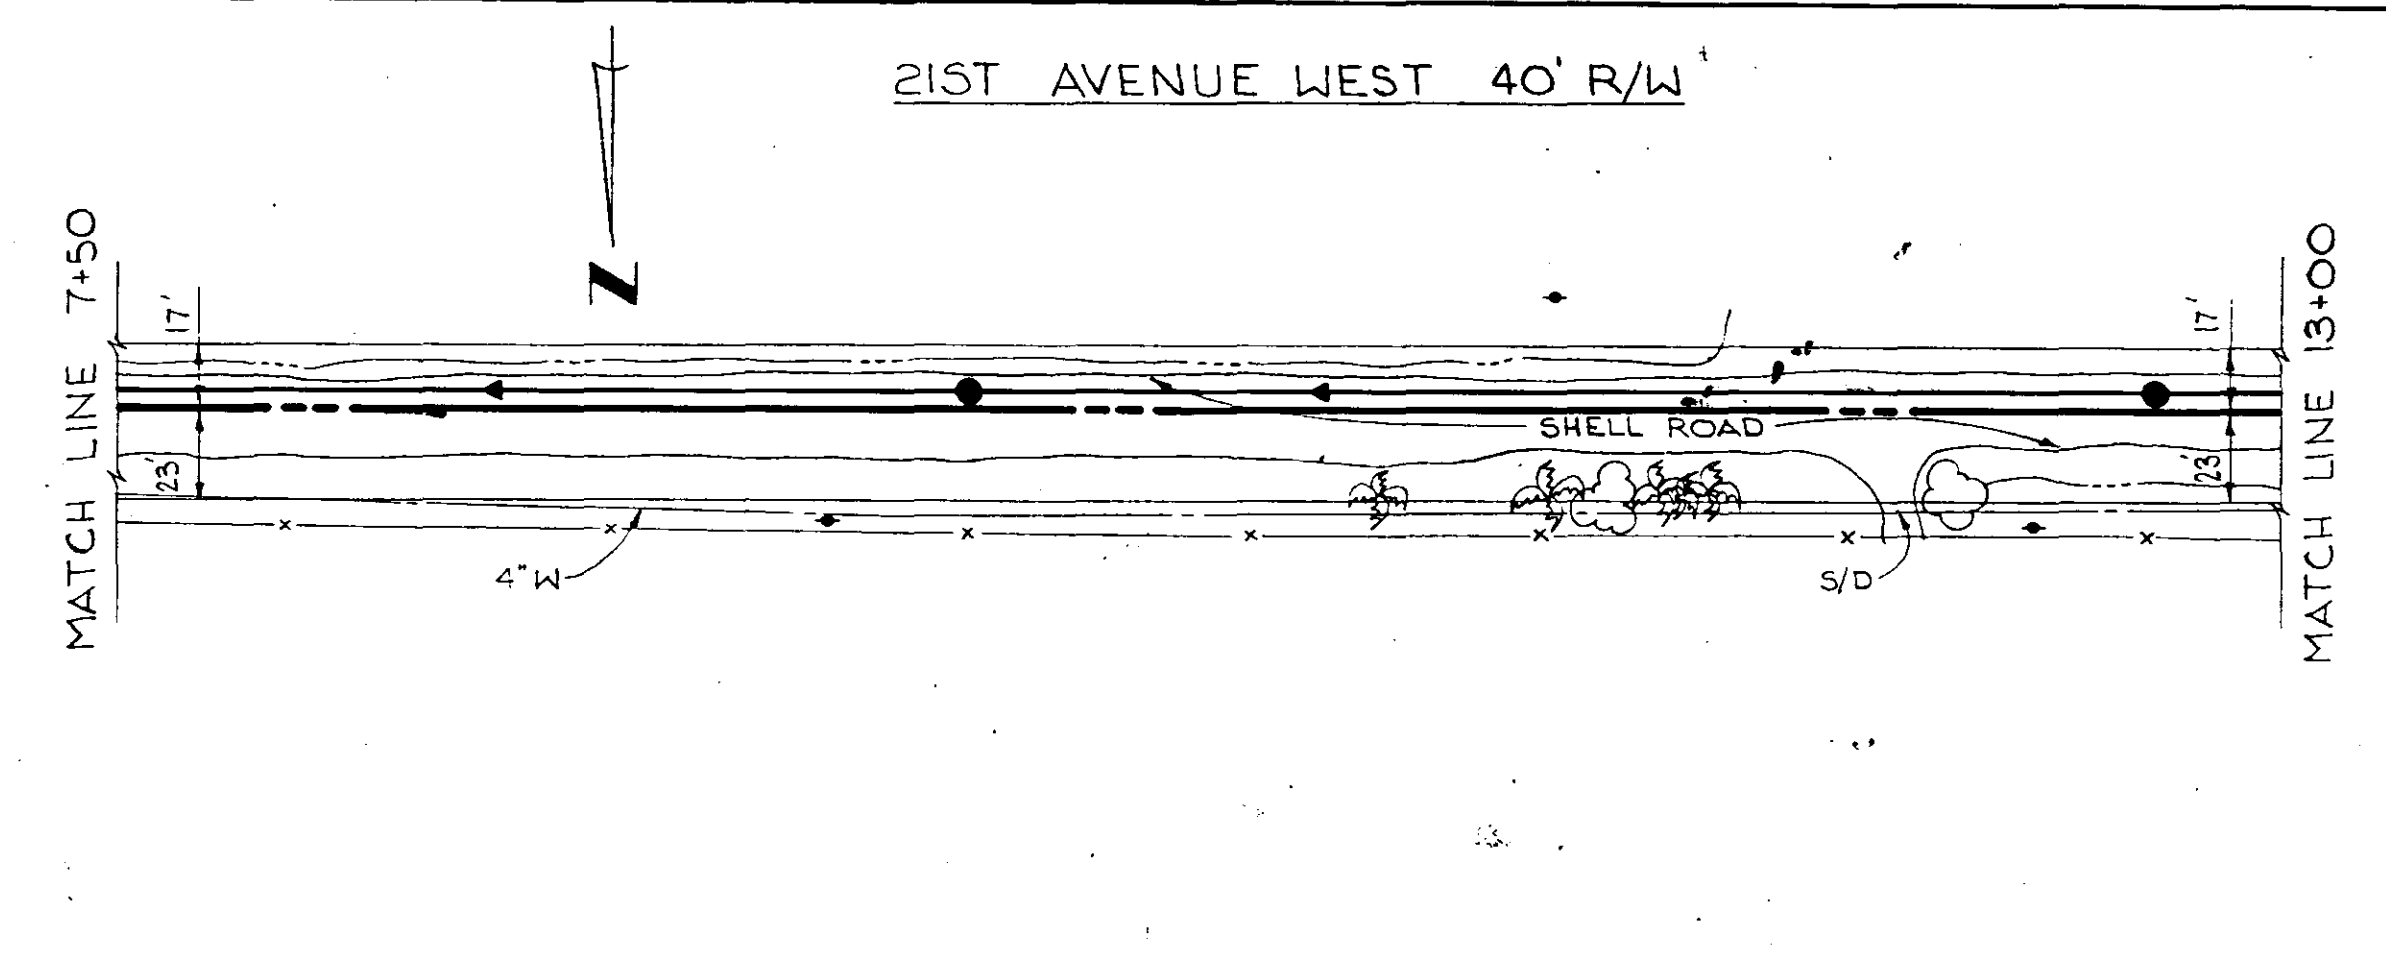


PROPOSED 20" FORCE MAIN ID

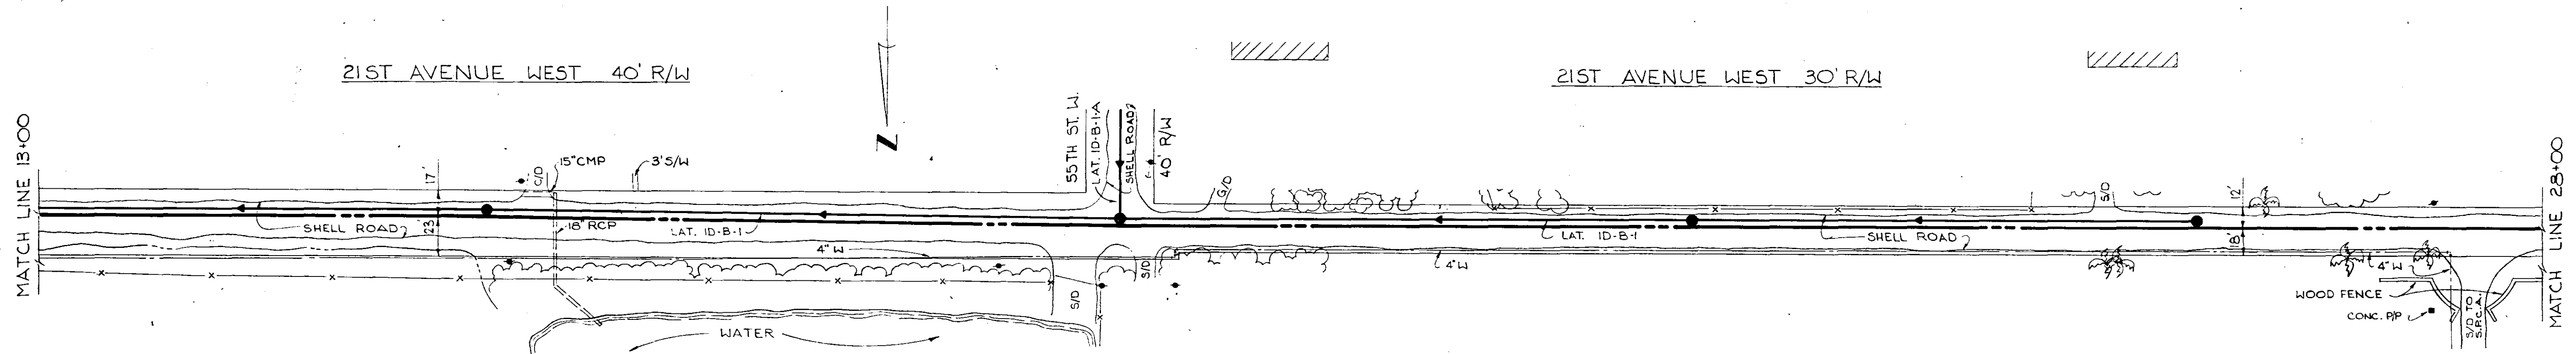


PROPOSED 20" FORCE MAIN ID

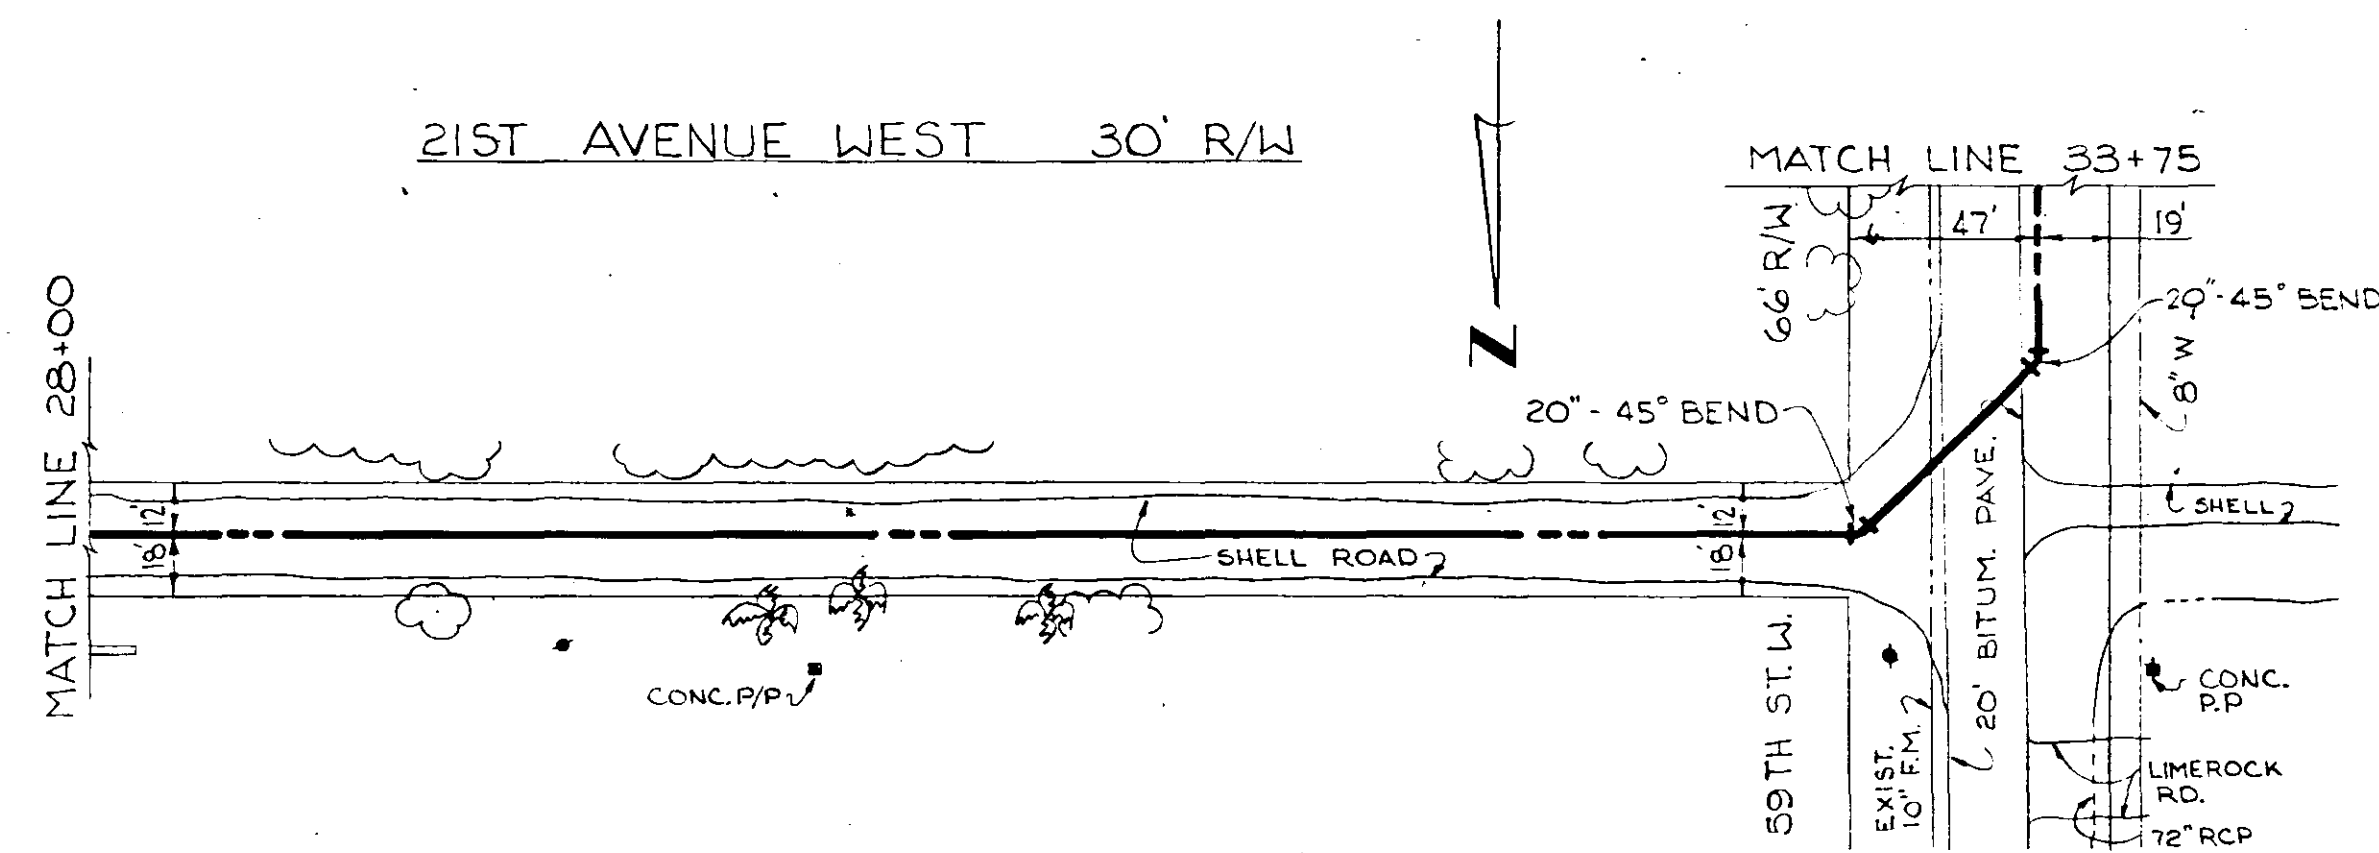

PROPOSED 20" FORCE MAIN ID

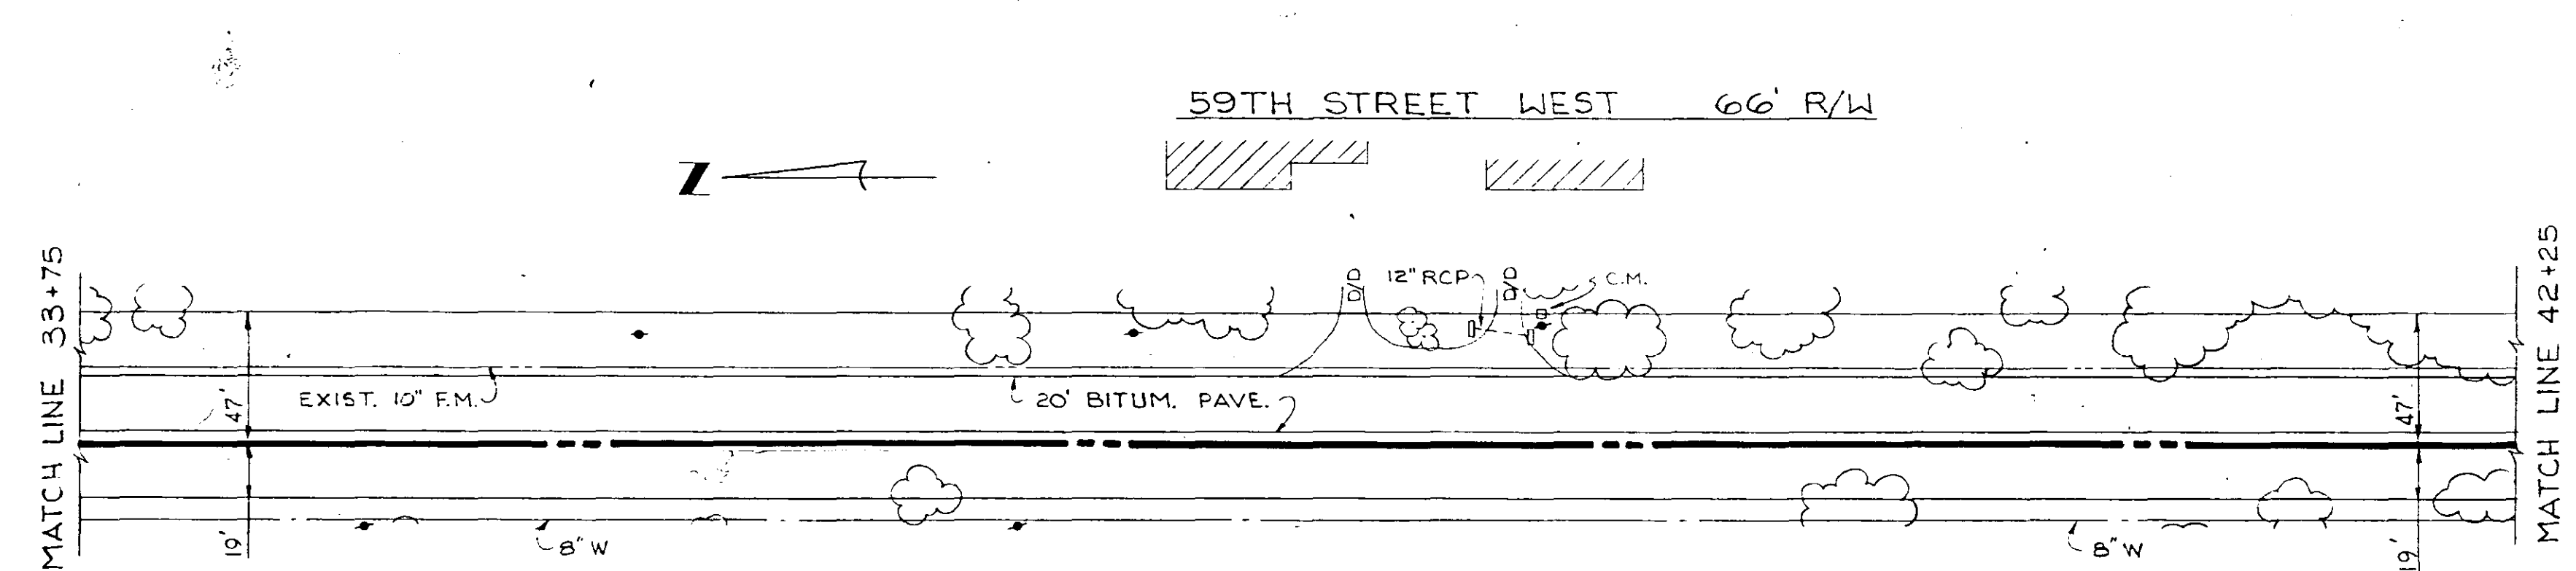

PROPOSED 20" FORCE MAIN ID

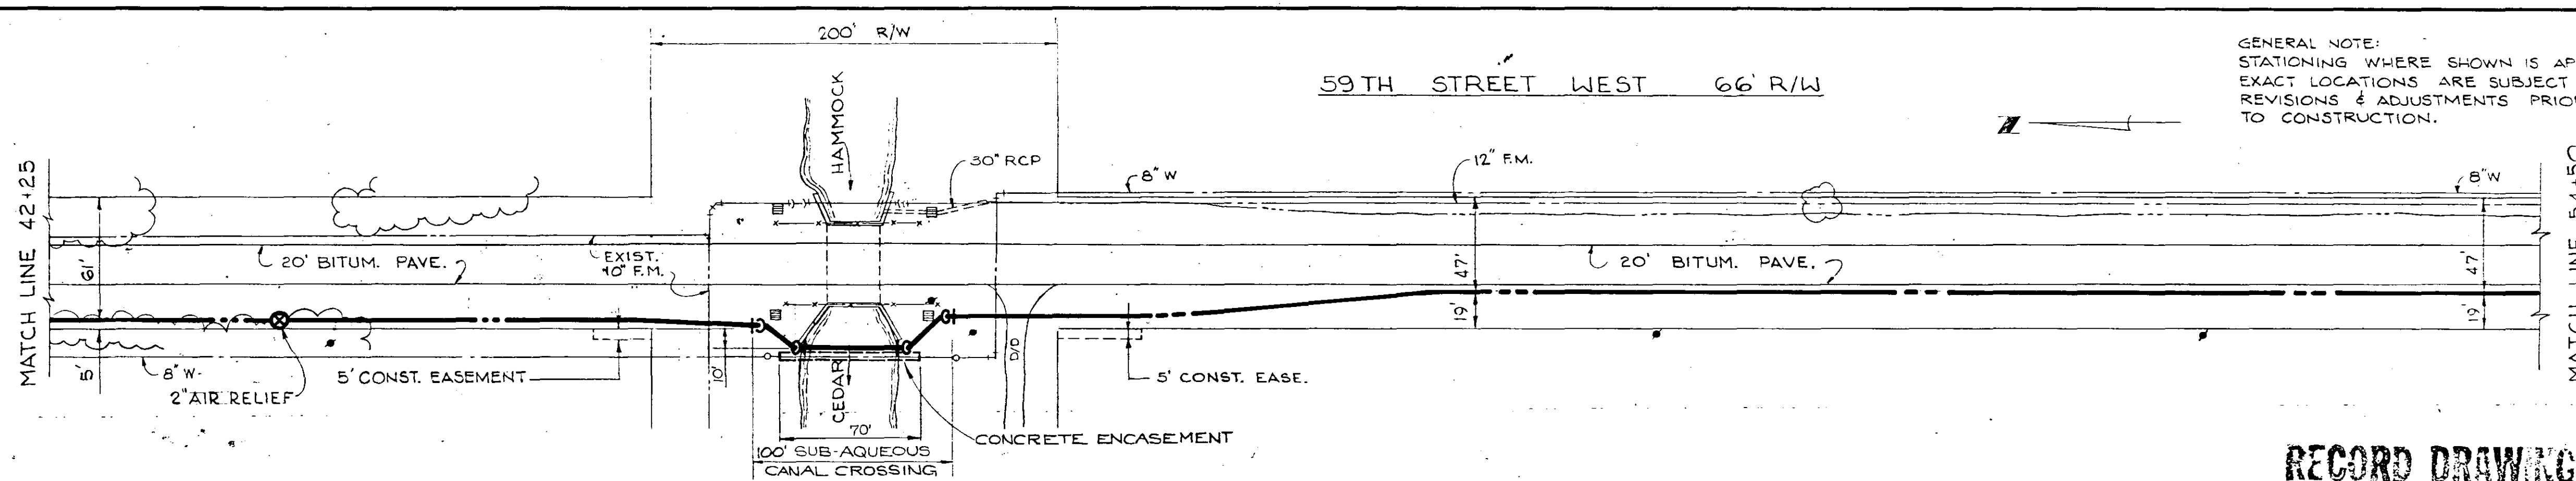

PROPOSED 20" FORCE MAIN ID

GENERAL NOTE:
STATIONING WHERE SHOWN IS APPROXIMATE
EXACT LOCATIONS ARE SUBJECT TO
REVISIONS & ADJUSTMENTS PRIOR
TO CONSTRUCTION.

NO.	DATE	DESCRIPTION	BY	CHKD.
1-26-76		RELOCATED F.M. (RECORD DRAWING)	J.R.L.	W
10-25-74		RELOCATED L.S. ID IN ACCORD WITH C.O.	R.W.B.	
5-24-74		REV. NOTE ON F.M. COVER (CANALING PERIOD #2)	G.G.Z.	
5-23-74		RELOCATED L.S. ID PER ADDENDUM #2	G.G.Z.	D.E.C. J.W.C.

RUSSELL & AXON
Engineers — Planners — Architects
DAYTONA BEACH, FLORIDA





SANITARY SEWERAGE PROJECT
PART D
SECTION IV — FORCE MAIN ID

MANATEE COUNTY	DESIGNED BY GER	FILE NO. 6681-8b	T293 FLORIDA
	DRAWN BY HT	SHEET	
	CHECKED BY J.W.C.	OF 23	
	DATE OCT. 1973	SCALE: 1" = 50'	

RECORD DRAWING

DATE 6-7-76 BY J.R.L.

CK J.R.L. 18-05

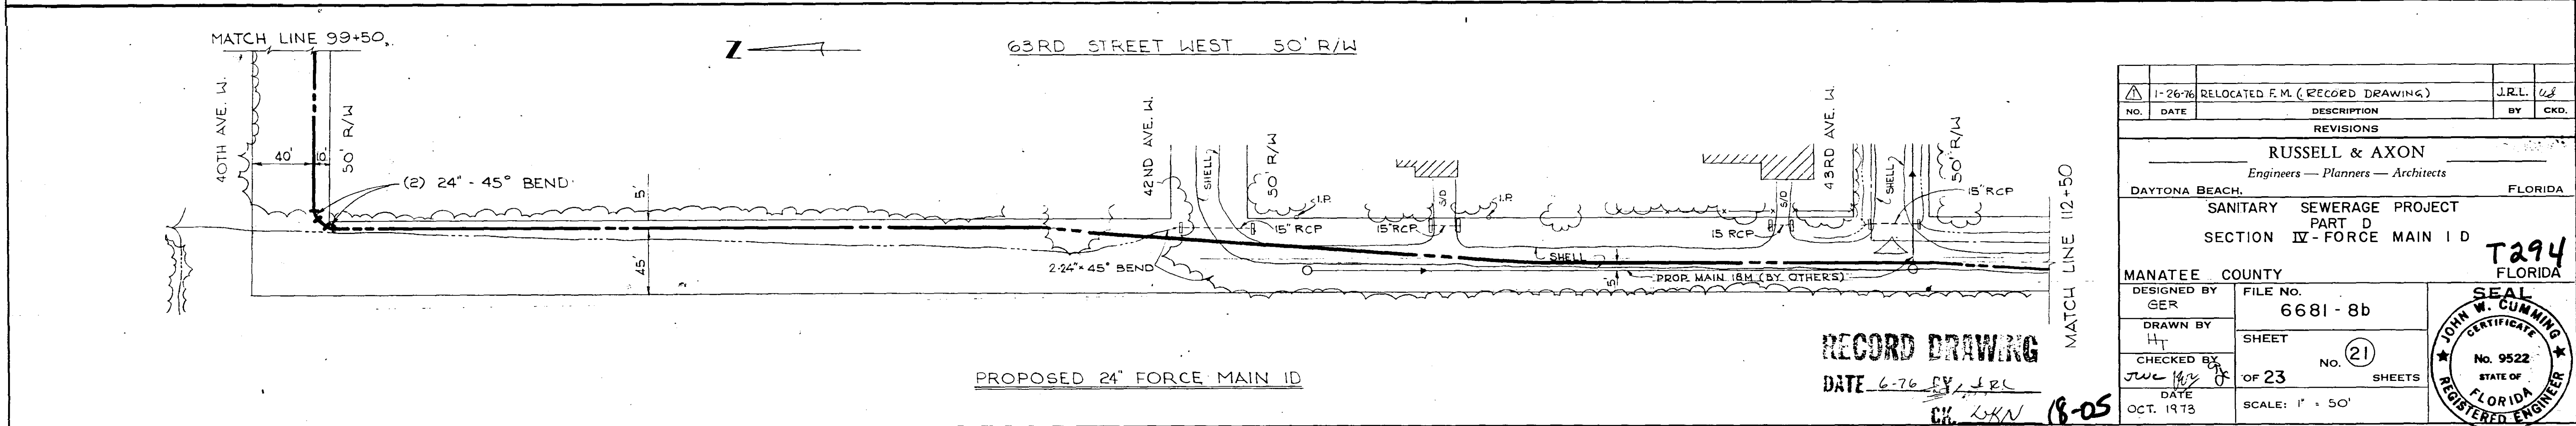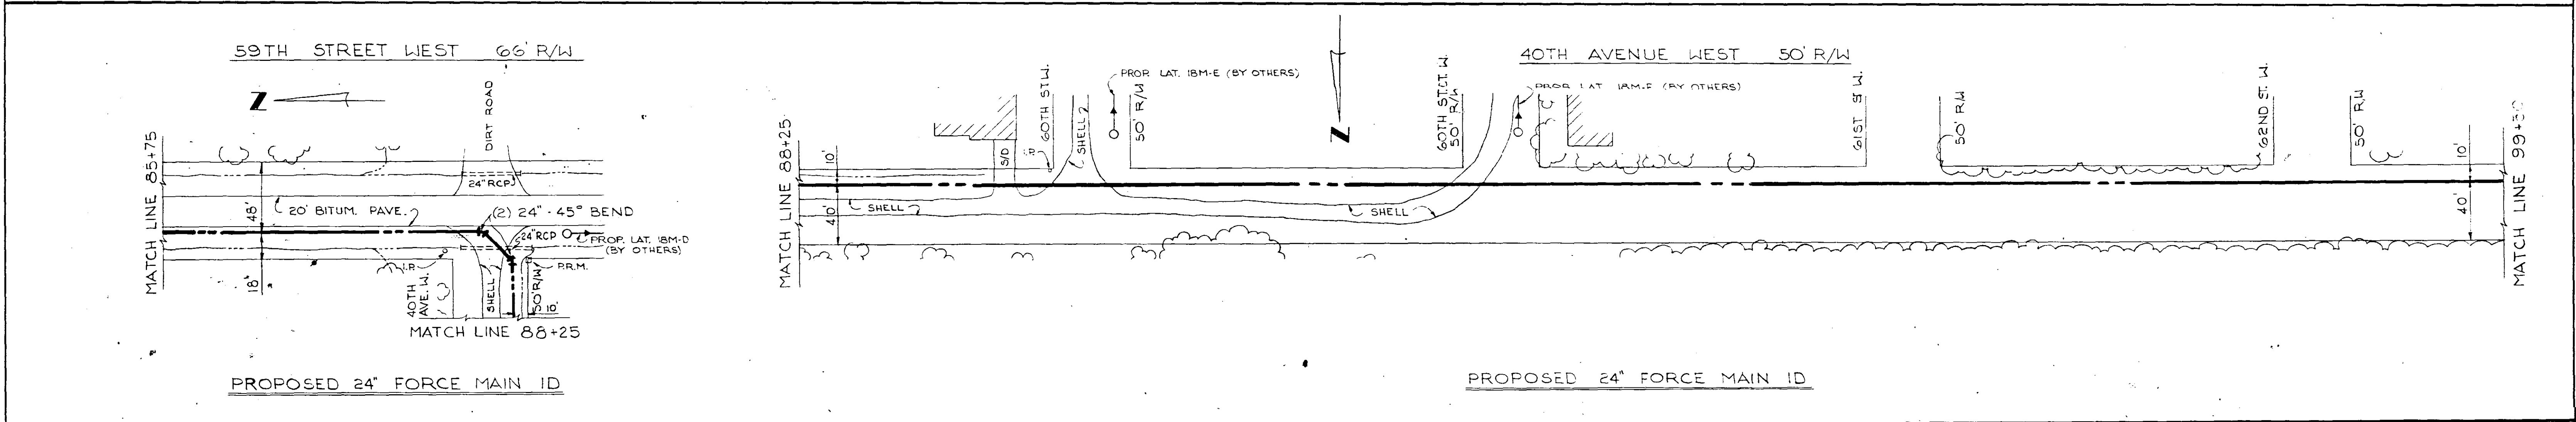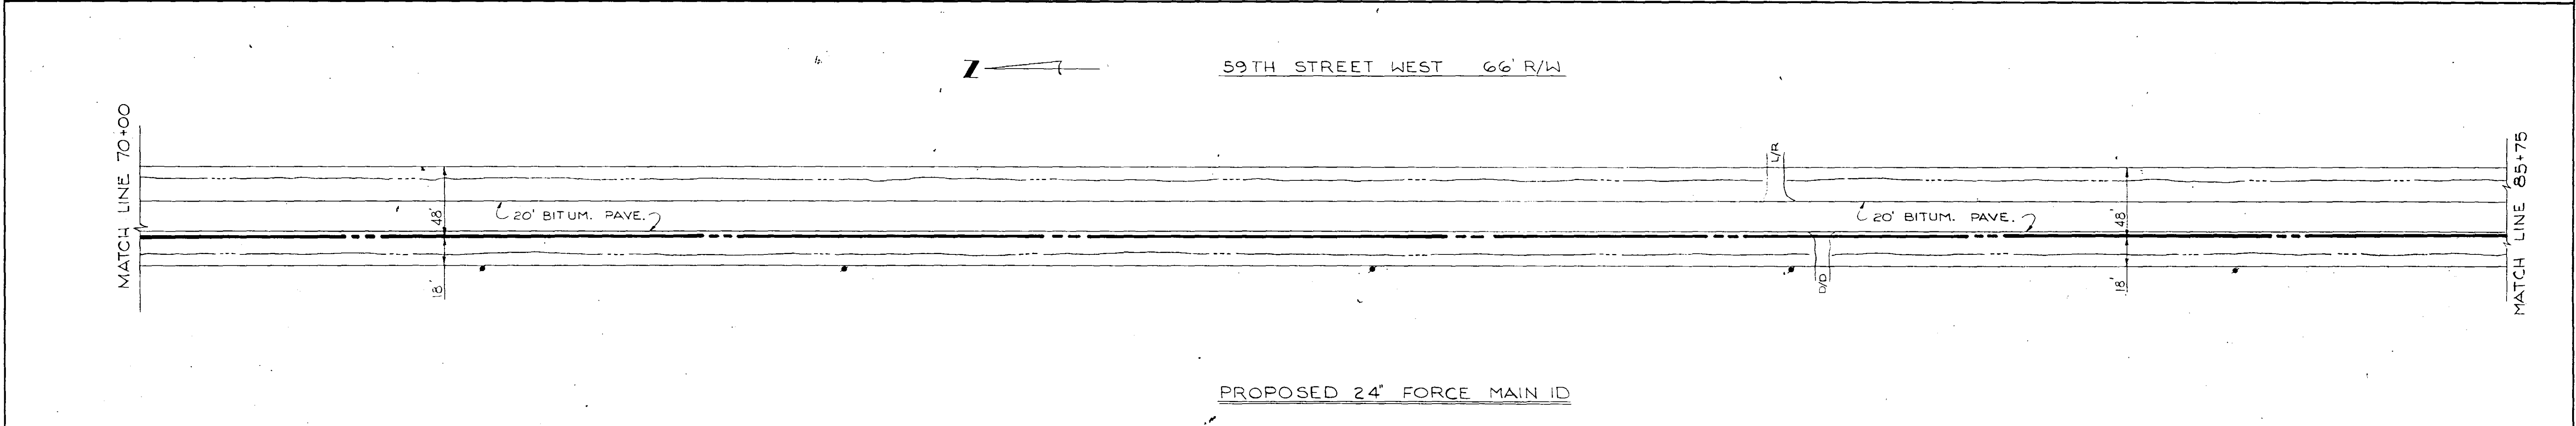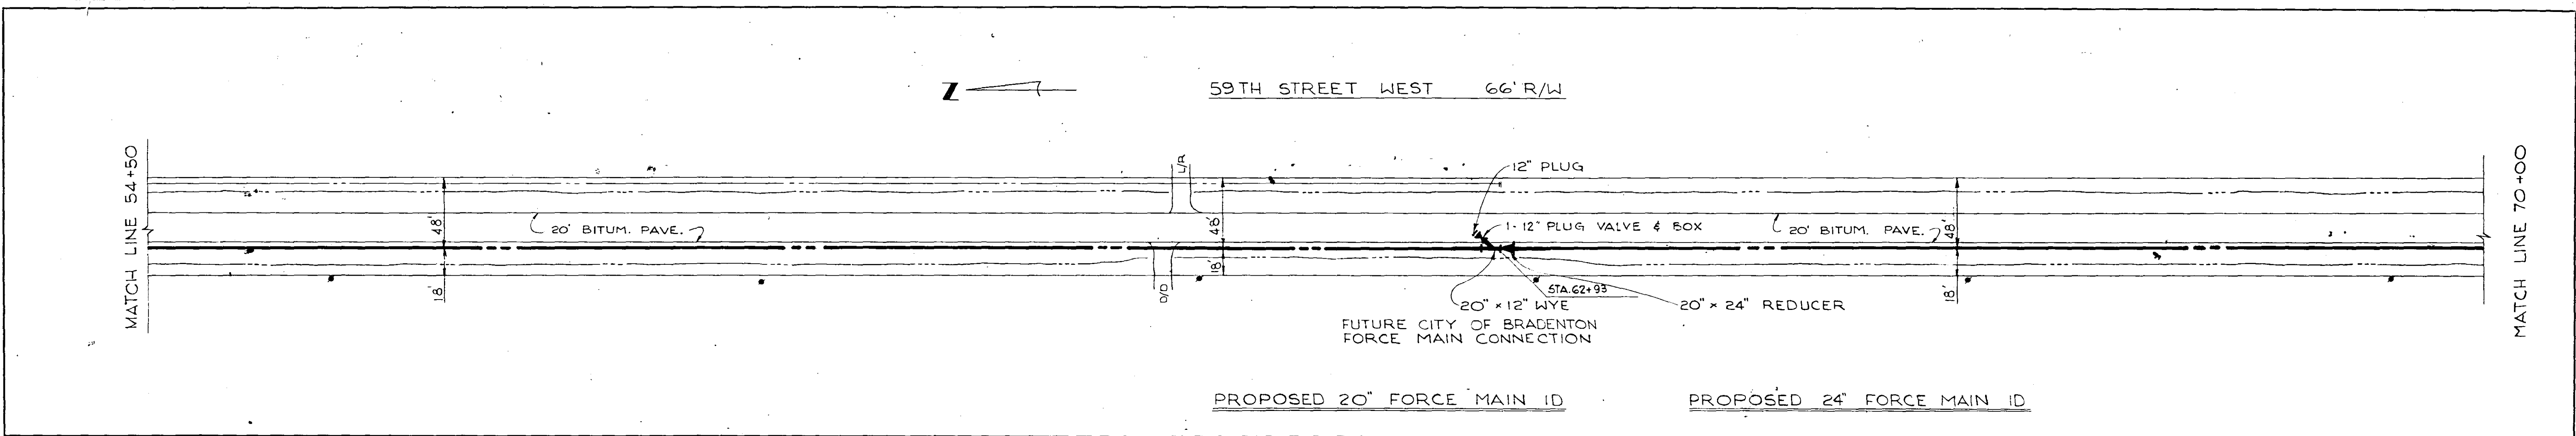

RECORD DRAWING

DATE 6-76 BY JRL

CK. LKN 18-05

1-26-76	RELOCATED F.M. (RECORD DRAWING)	JRL	ck
NO.	DATE	DESCRIPTION	BY
REVISIONS			
RUSSELL & AXON			
Engineers — Planners — Architects			
DAYTONA BEACH, FLORIDA			
SANITARY SEWERAGE PROJECT			
PART D			
SECTION IV - FORCE MAIN ID			
MANATEE COUNTY			
DESIGNED BY	FILE NO.	FLORIDA	
GER	6681-8b		
DRAWN BY	SHEET		
H	(21)		
CHECKED BY	OF 23		
JRL	NO.		
DATE	SHEETS		
OCT. 1973	SCALE: 1" = 50'		

SEAL



JOHN W. CUMMINS

CERTIFICATE

No. 9522







STATE OF FLORIDA

REGISTERED ENGINEER

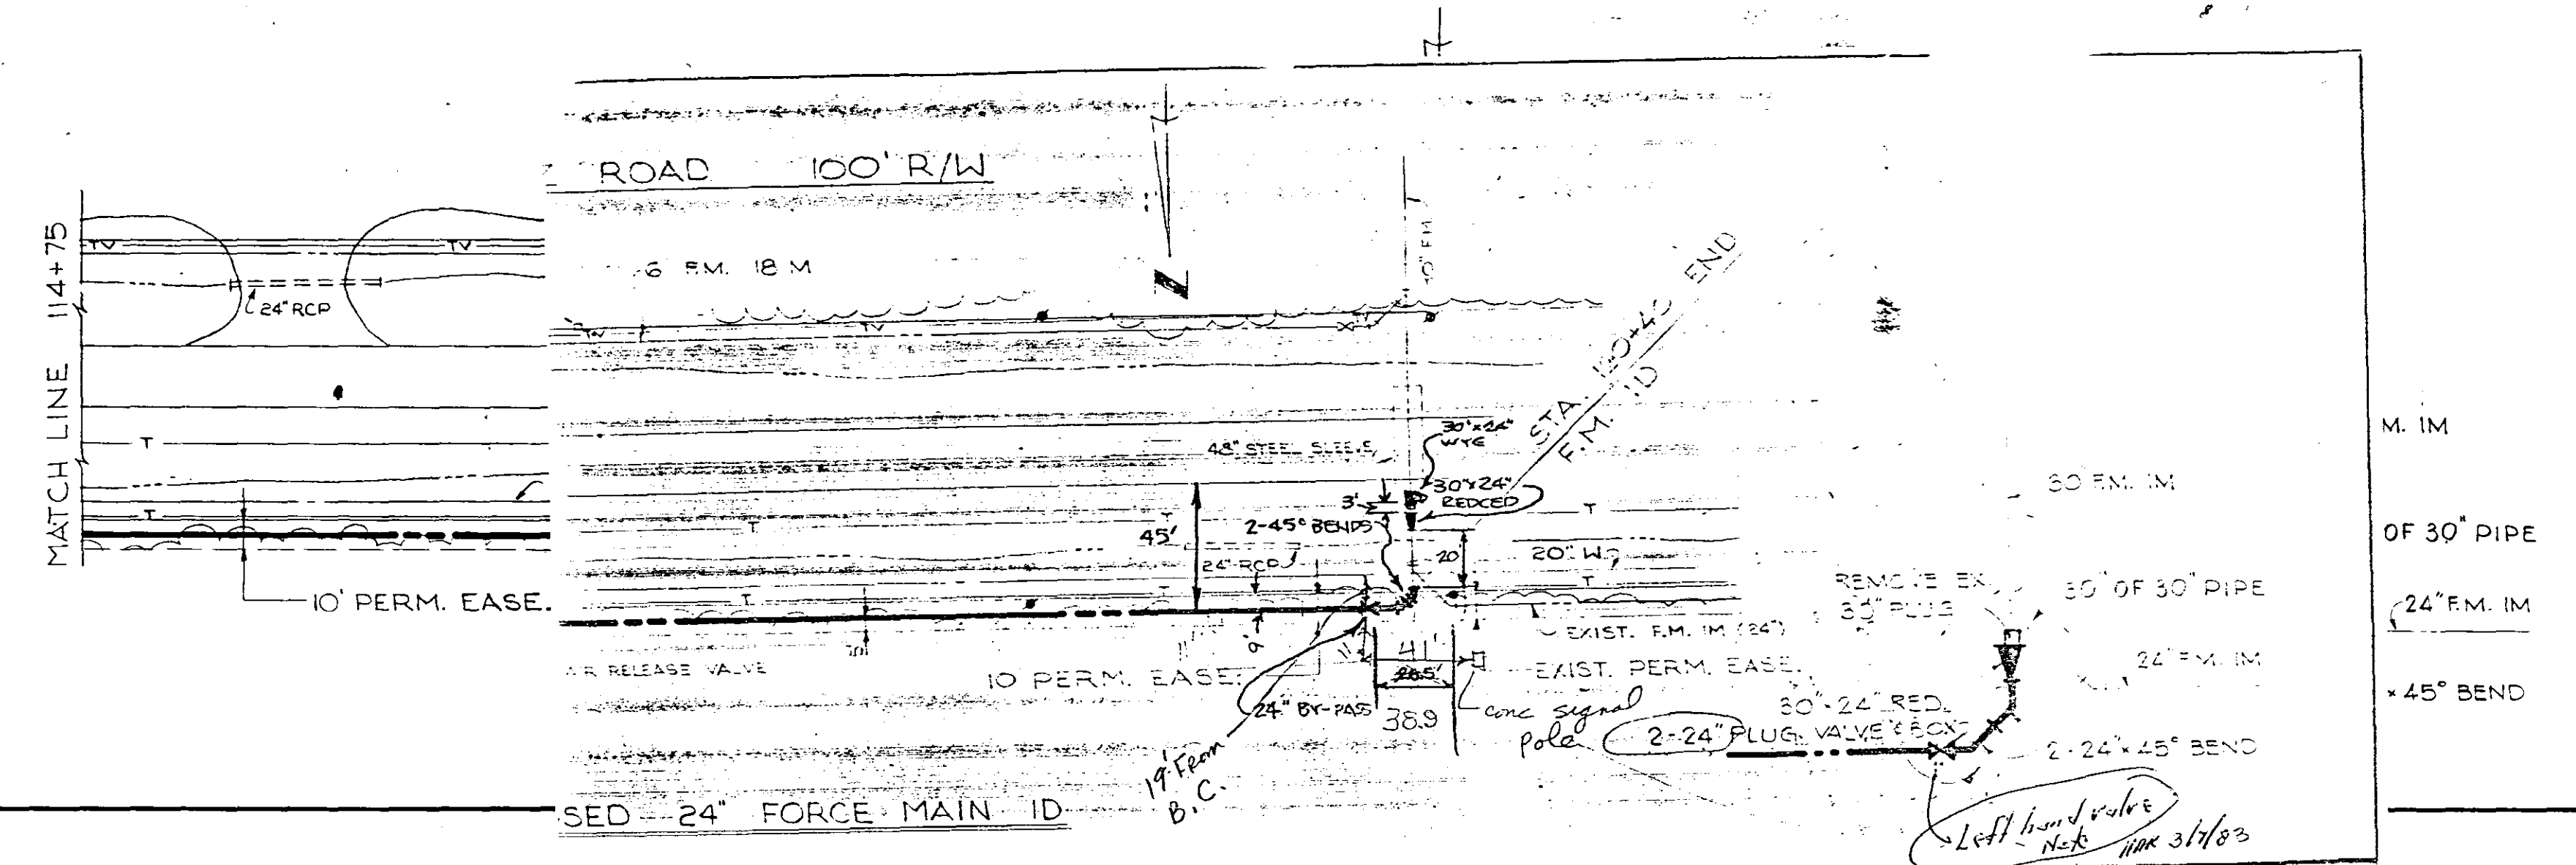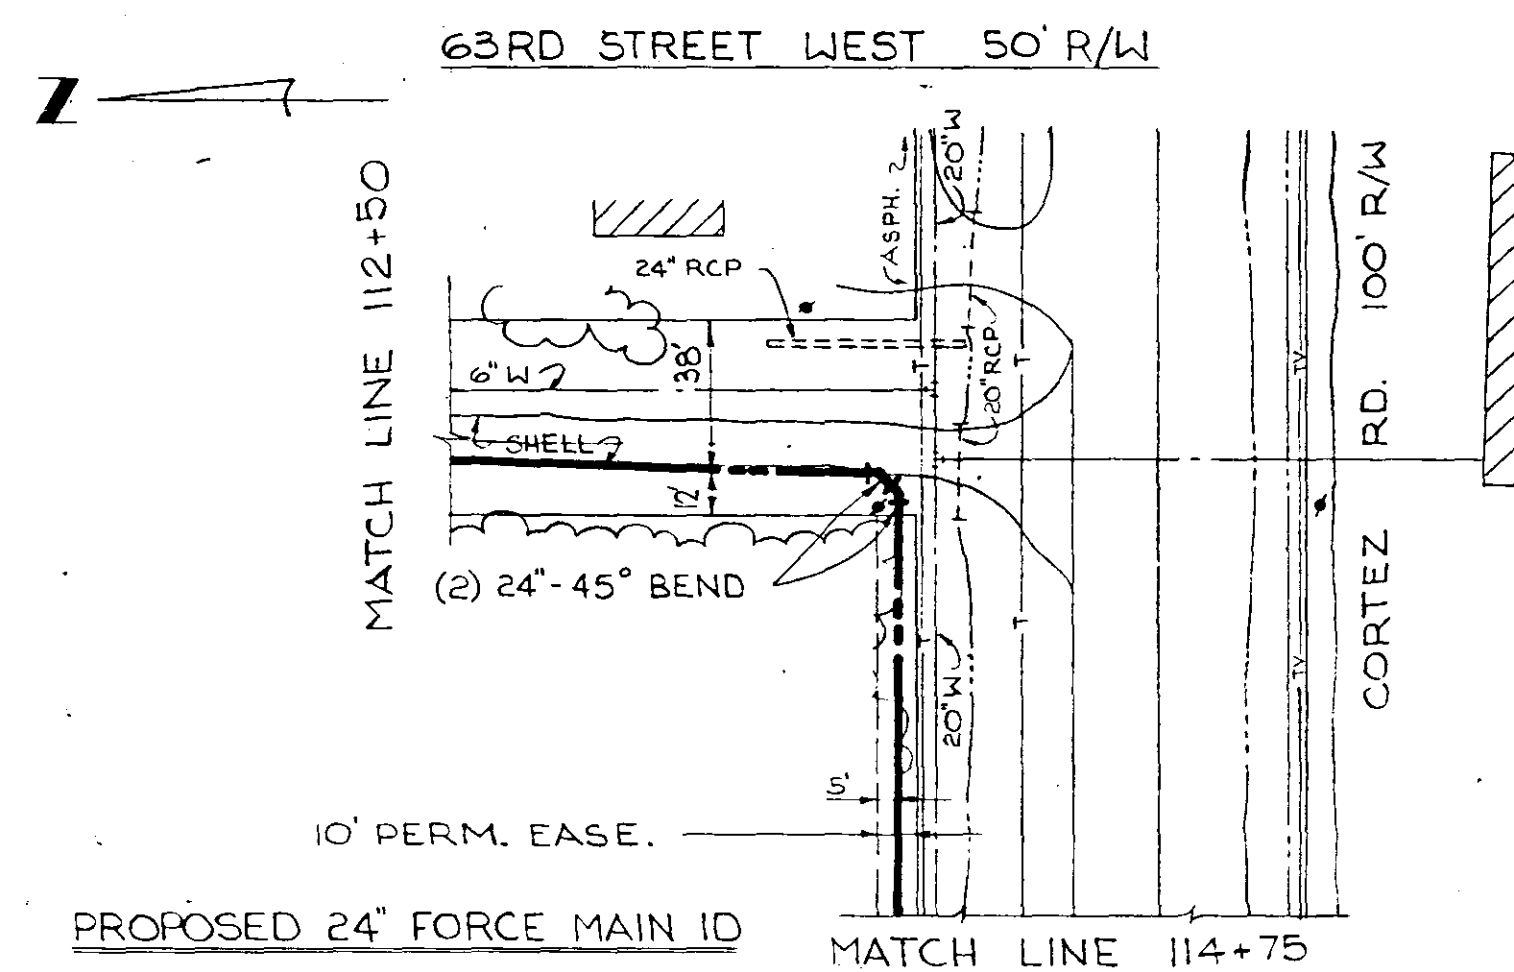


SEWAGE FORCE MAIN ANCHOR SYSTEM

PIPE (IN.)	THRUST BLOCKS				ANCHOR BLOCKS				BEARING PADS			
	90° BENDS	45° BENDS	22.5° BENDS	WYES & TEES	90° BENDS	45° BENDS	22.5° BENDS	WYES & TEES	90° BENDS	45° BENDS	22.5° BENDS	WYES & TEES
	B D REINF. (E.W.)	B D REINF. (E.W.)	B D REINF. (E.W.)	B D REINF. (E.W.)	B D REINF. (E.W.)	B D REINF. (E.W.)	B D REINF. (E.W.)	B D REINF. (E.W.)	B D REINF. (E.W.)	B D REINF. (E.W.)	B D REINF. (E.W.)	B D REINF. (E.W.)
4	10' 07"	10' 07"	10' 07"	10' 07"	16'	13'	10'	23'	10' 07"	10' 07"	10' 07"	10' 07"
6	10' 07"	10' 07"	10' 07"	14' 07"	21'	17'	14'	30'	10' 07"	10' 07"	10' 07"	10' 07"
8	14' 07"	10' 07"	10' 07"	17' 08"	26'	21'	17'	37'	12' 08"	10' 07"	10' 07"	13' 07"
10	17' 08"	14' 07"	10' 07"	20' 08"	30'	24'	20'	43'	14' 08"	12' 08"	10' 07"	17' 08"
12	20' 08"	14' 07"	10' 07"	23' 10"	34'	28'	22'	48'	17' 08"	12' 08"	10' 07"	20' 08"
14	23' 10" 3#5	17' 08"	14' 07"	27' 10" 3#5	38'	31'	24'	53'	20' 08" 2#5	14' 08"	12' 07"	23' 10" 2#5
16	27' 10" 3#5	20' 08" 2#5	14' 07"	32' 10" 4#5	41'	34'	26'	58'	23' 10" 3#5	17' 08"	13' 07"	27' 10" 3#5
18	28' 10" 4#5	23' 10" 3#5	17' 08"	35' 10" 5#5	45'	36'	29'	63'	25' 10" 3#5	19' 08" 2#5	15' 08"	30' 10" 4#5
20	32' 10" 4#5	25' 10" 3#5	17' 08"	39' 10" 5#5	48'	39'	31'	67'	28' 10" 4#5	21' 08" 2#5	17' 08"	33' 10" 4#5
24	39' 10" 5#5	28' 10" 4#5	20' 08" 2#5	46' 12" 5#5	54'	44'	35'	76'	33' 10" 4#5	25' 10" 3#5	20' 08" 2#5	40' 10" 5#5
30	55' 12" 6#5	36' 10" 5#5	27' 10" 3#5	58' 13" 7#5	63'	51'	41'	88'	42' 12" 5#5	31' 10" 4#5	25' 10" 2#5	50' 12" 6#5
36	59' 3" 7#5	43' 12" 5#5	30' 10" 4#5	69' 15" 8#5	70'	57'	46'	100'	50' 12" 6#5	37' 10" 5#5	30' 10" 4#5	60' 13" 7#5
42	66' 15" 8#5	50' 12" 6#5	36' 10" 5#5	81' 18" 9#5	78'	64'	51'	113'	58' 13" 7#5	43' 2" 5#5	35' 10" 5#5	70' 15" 6#5

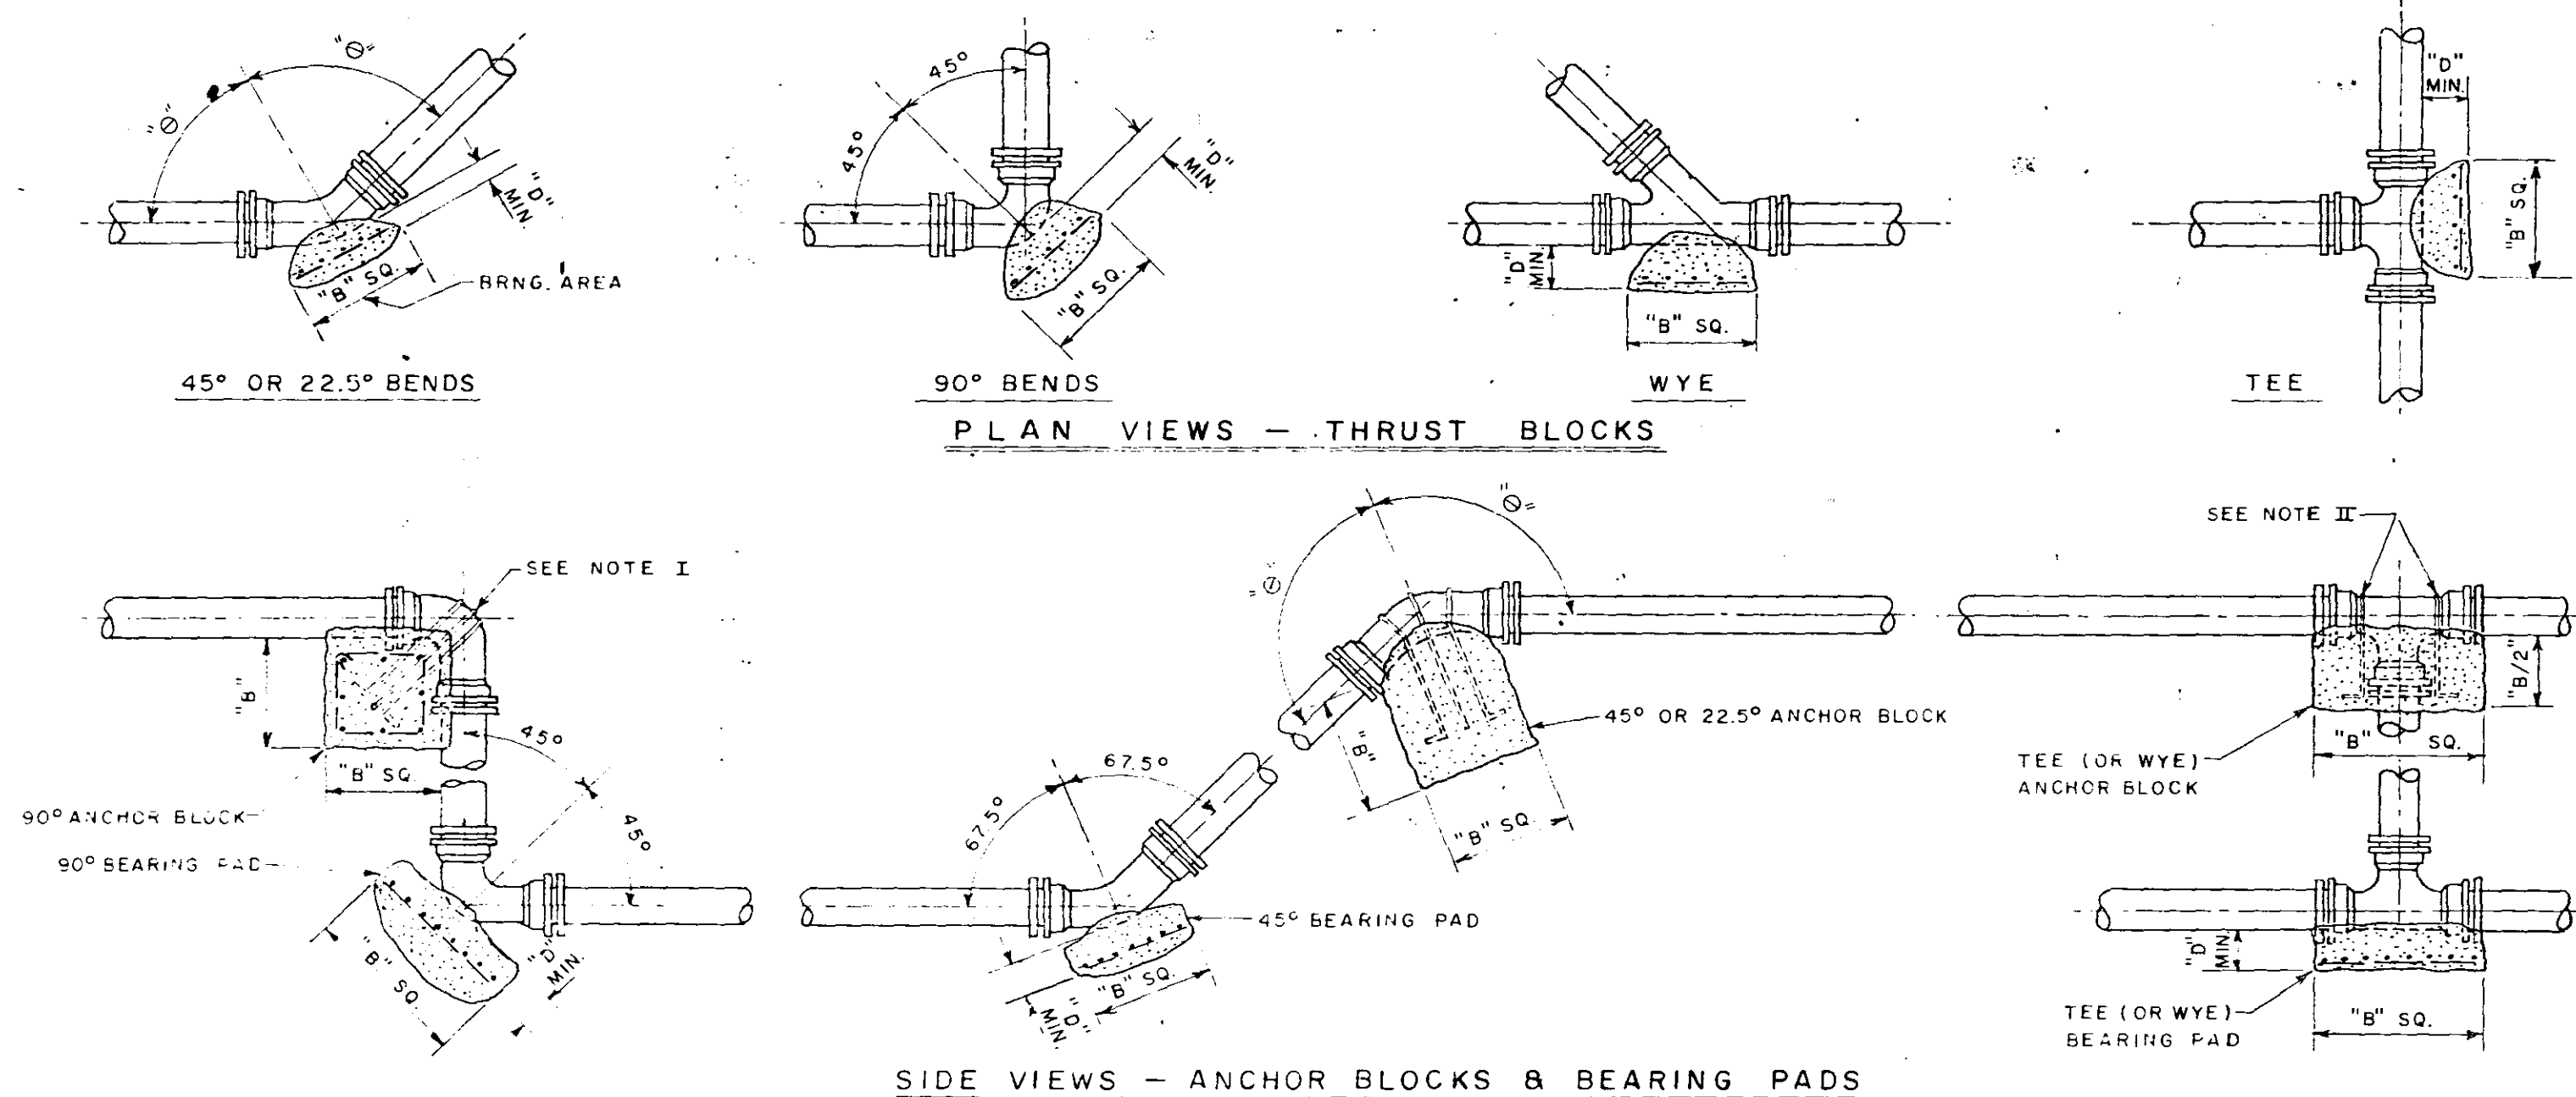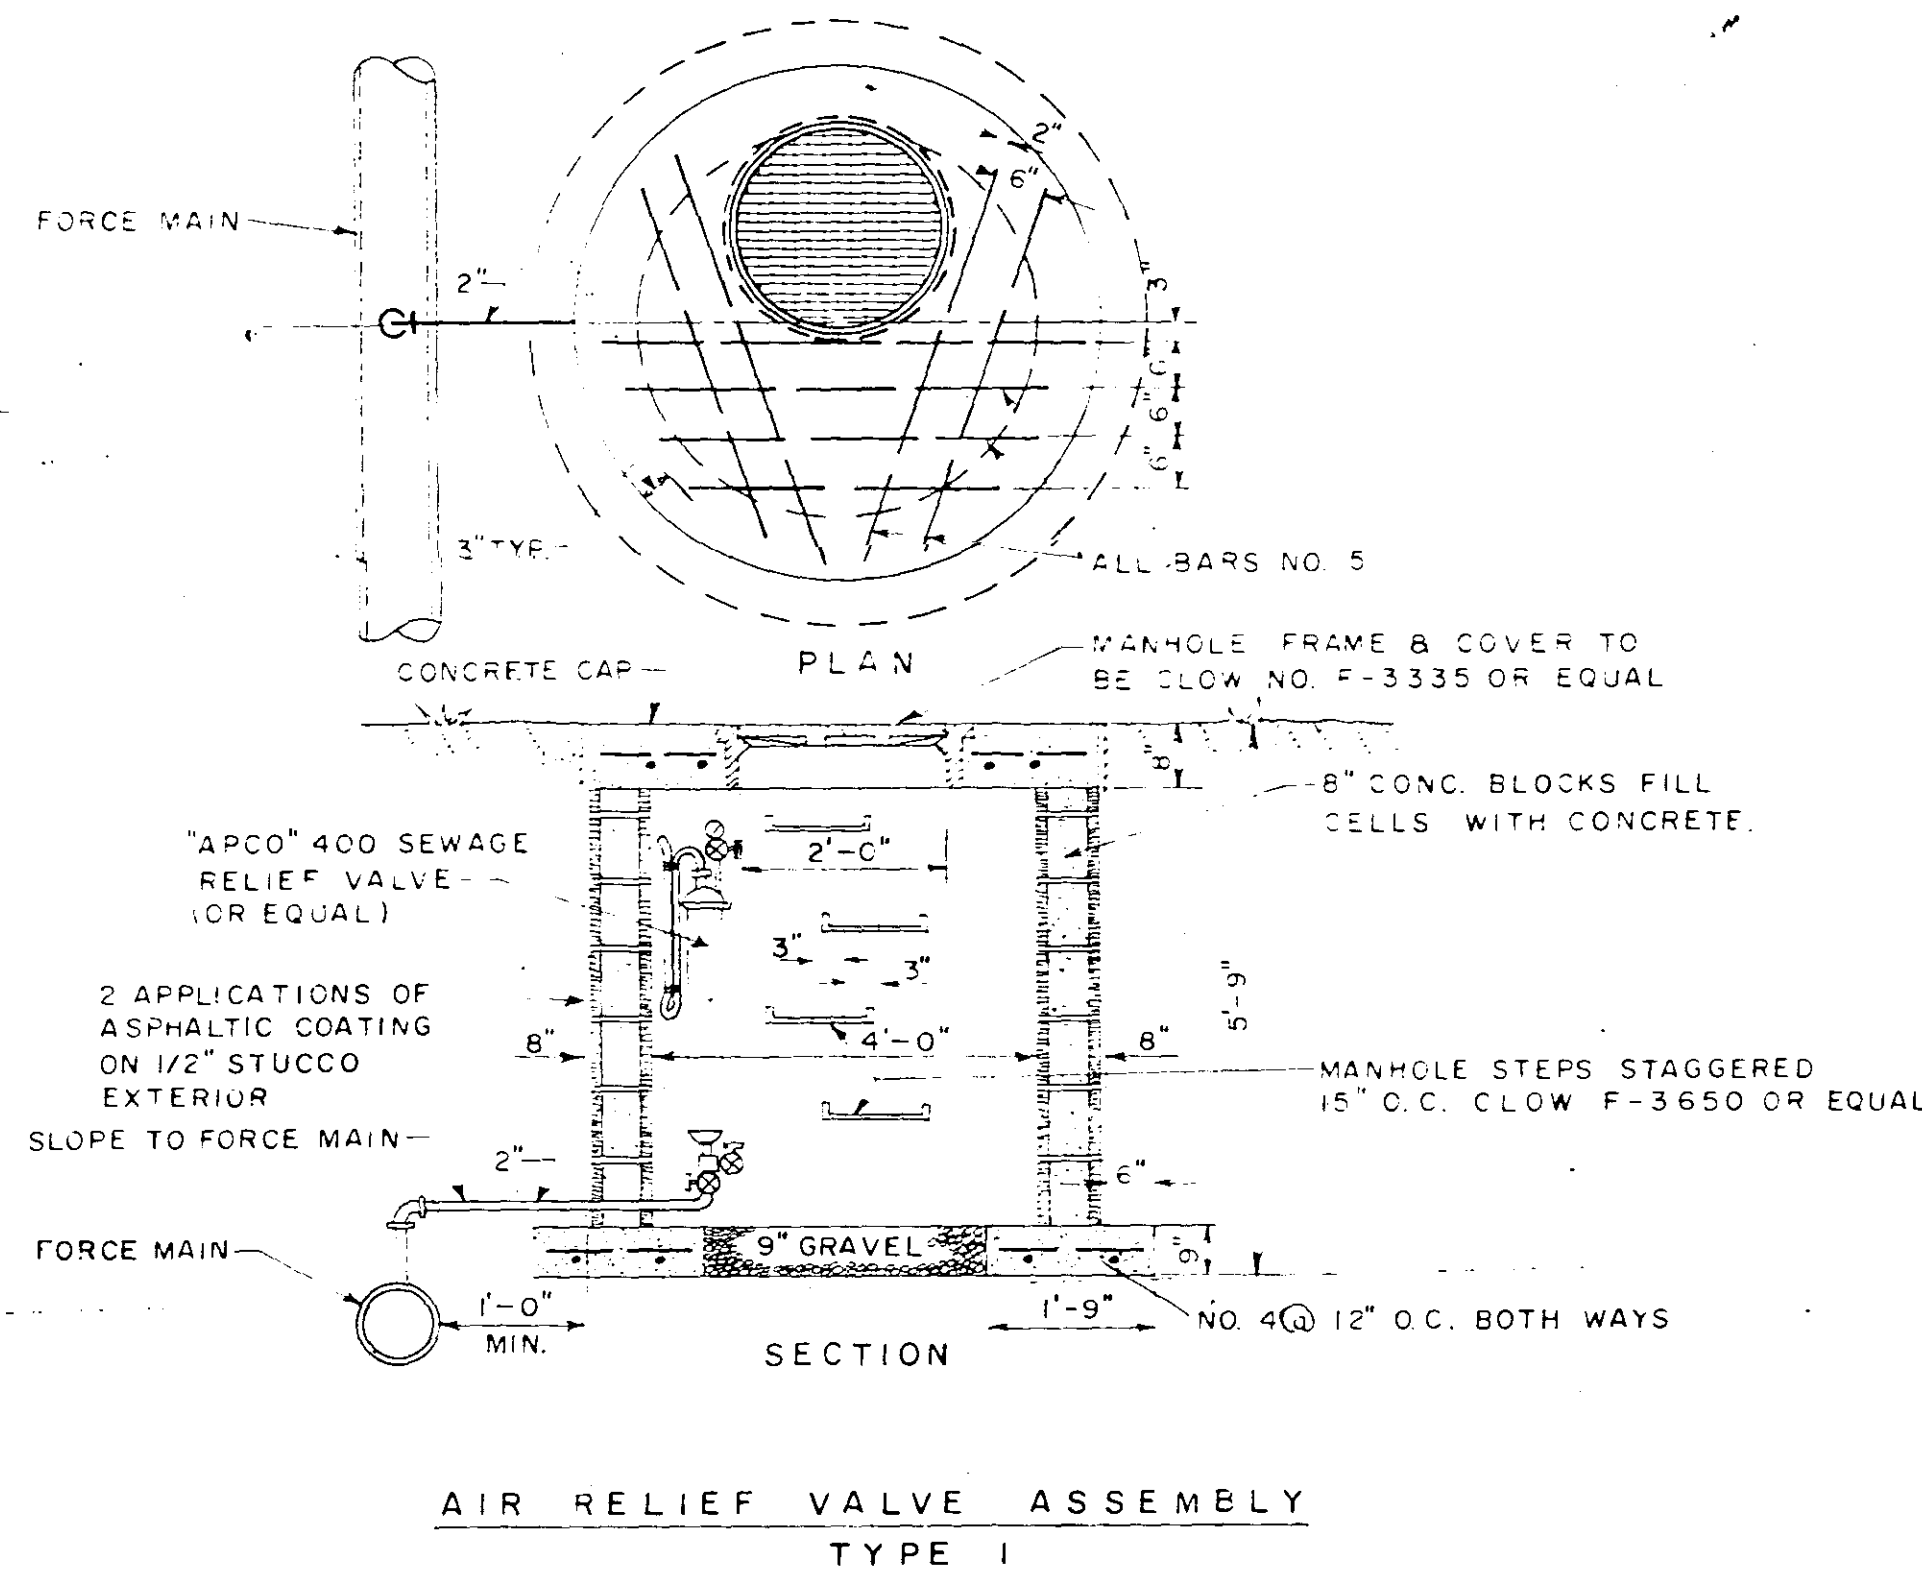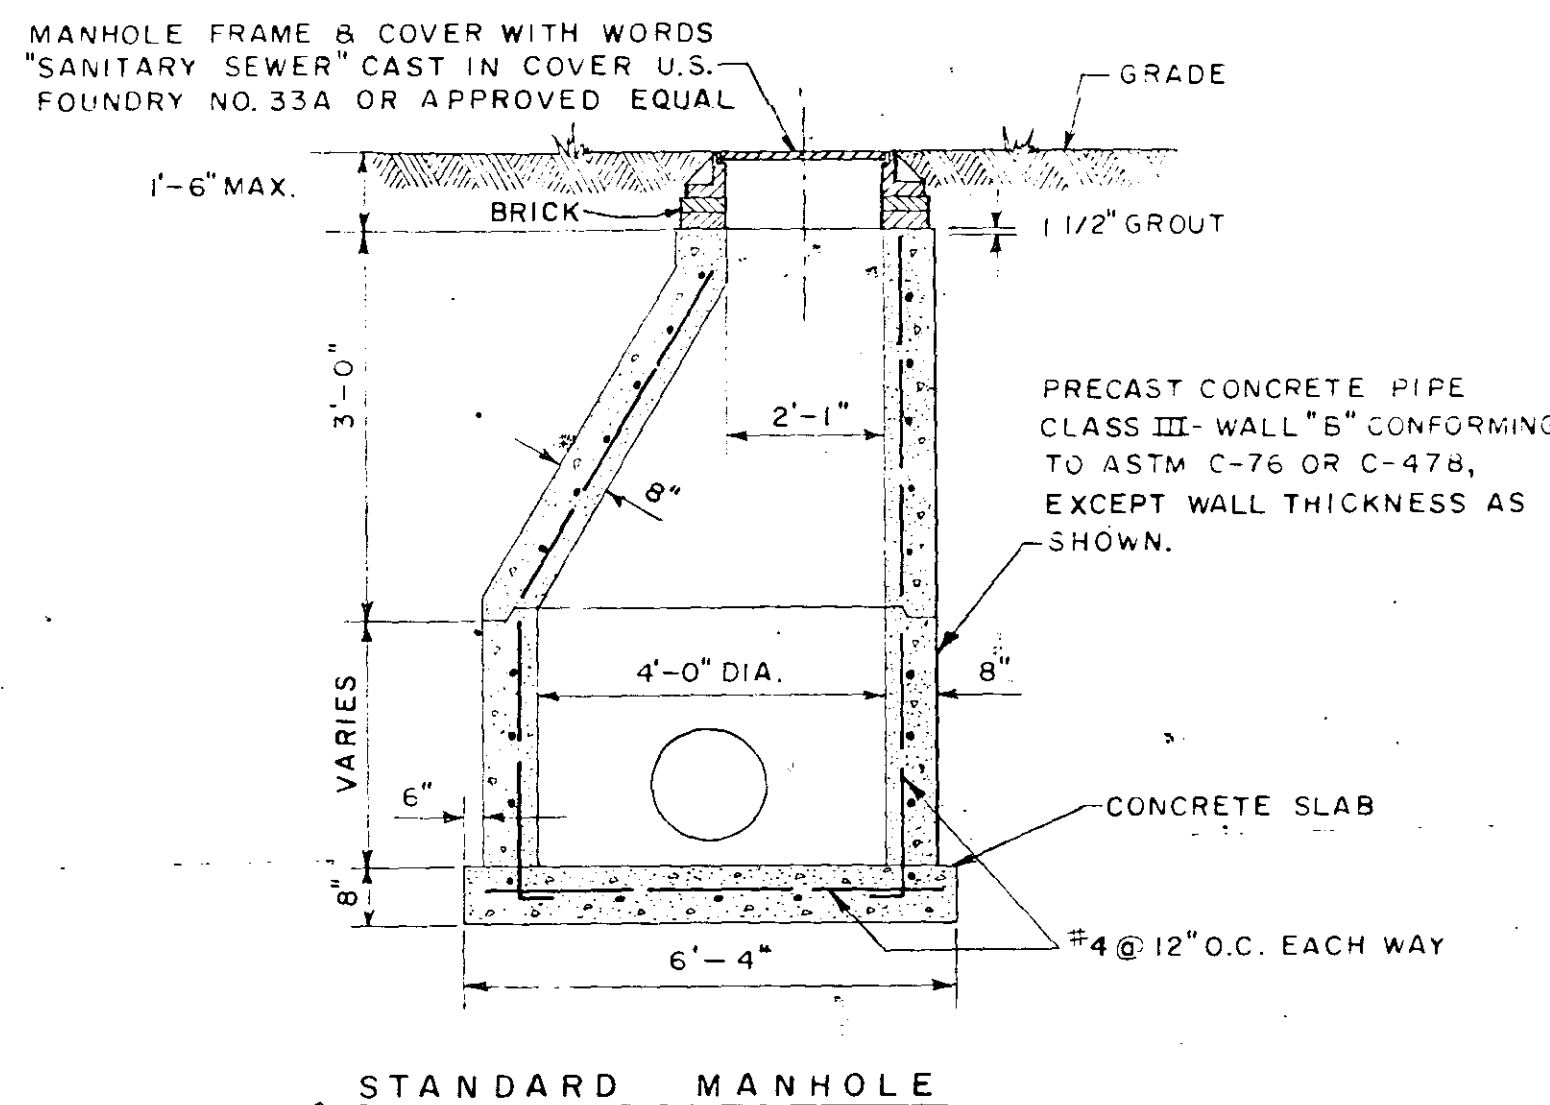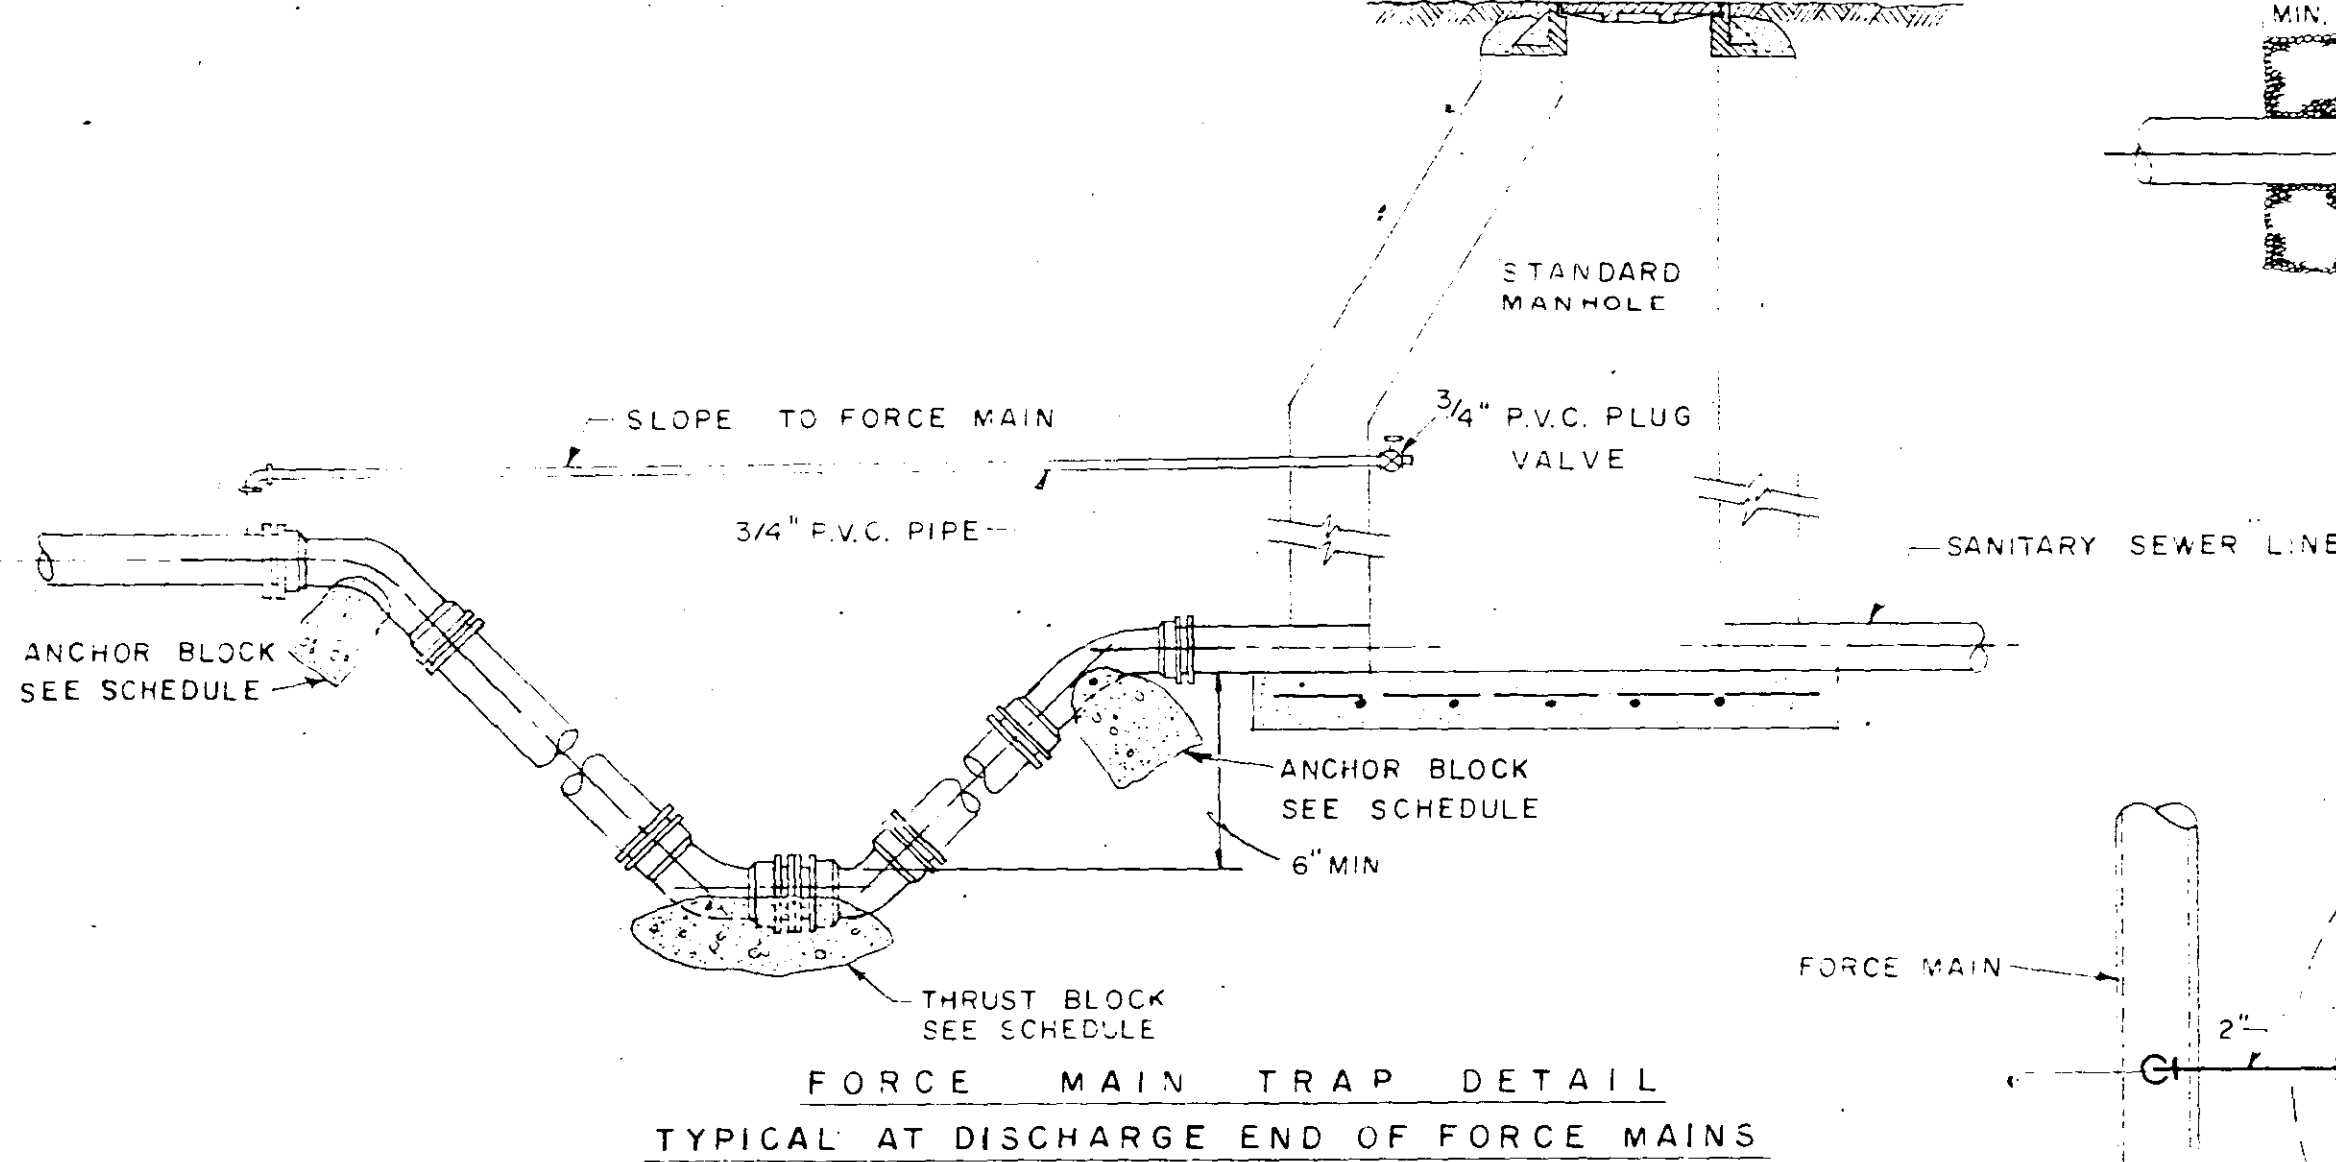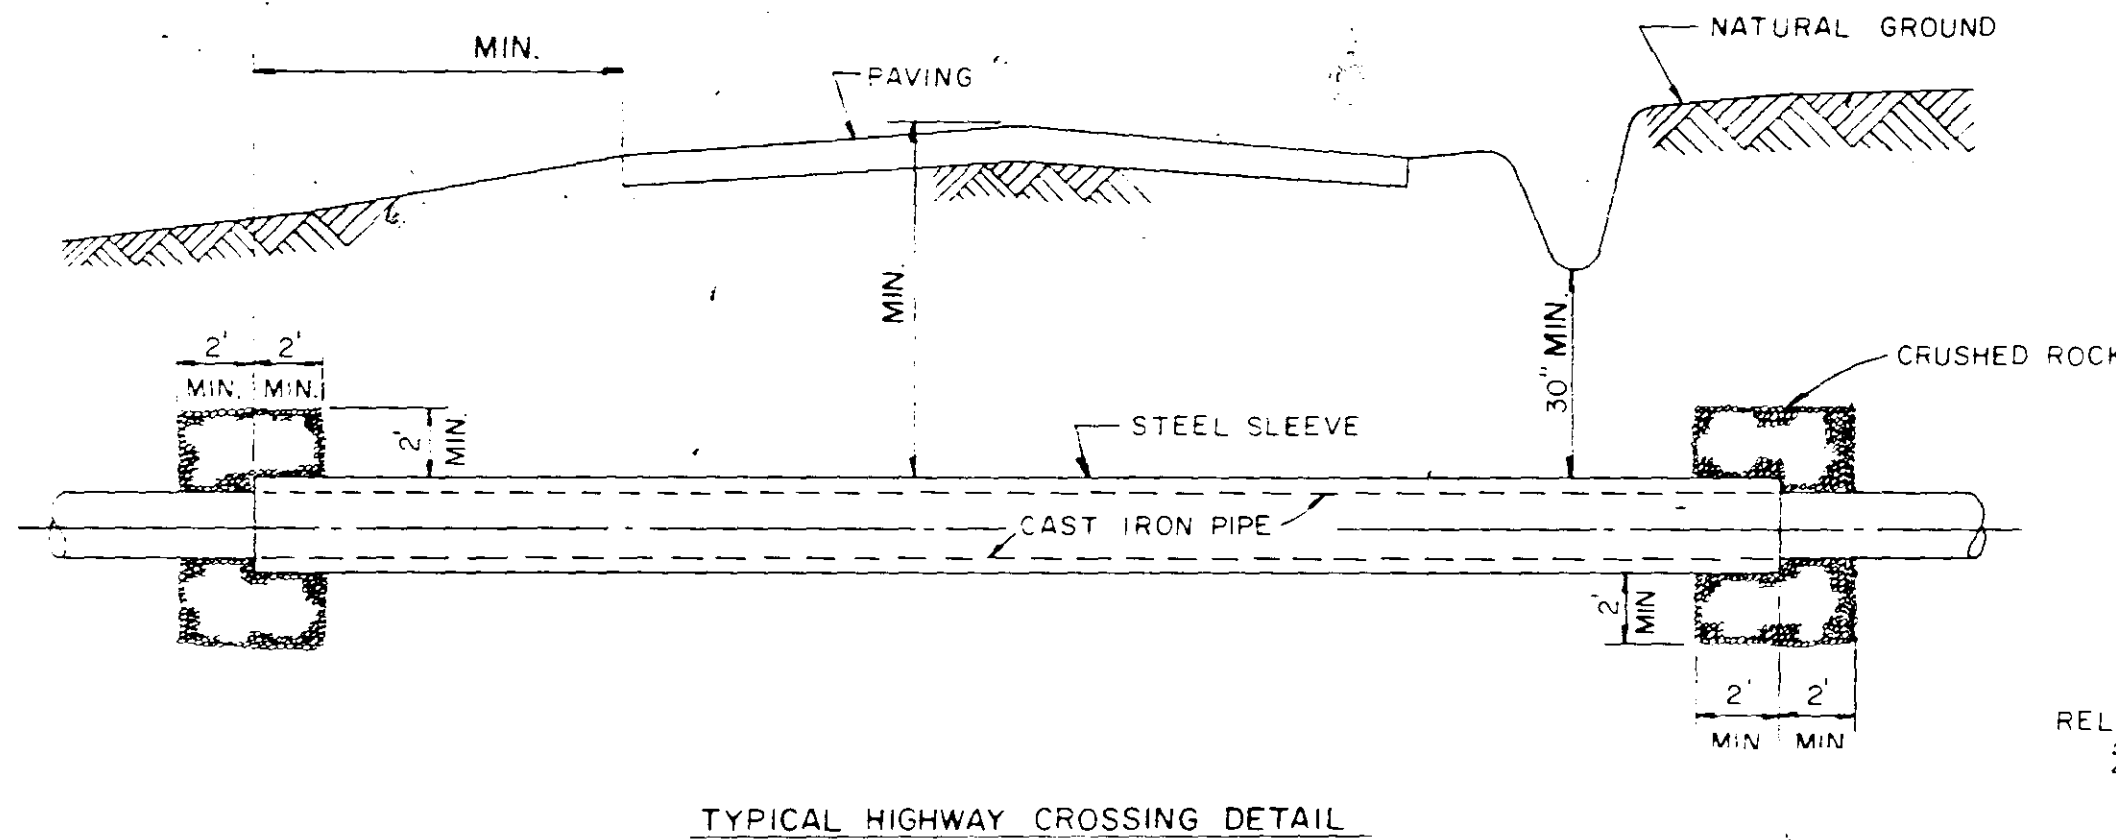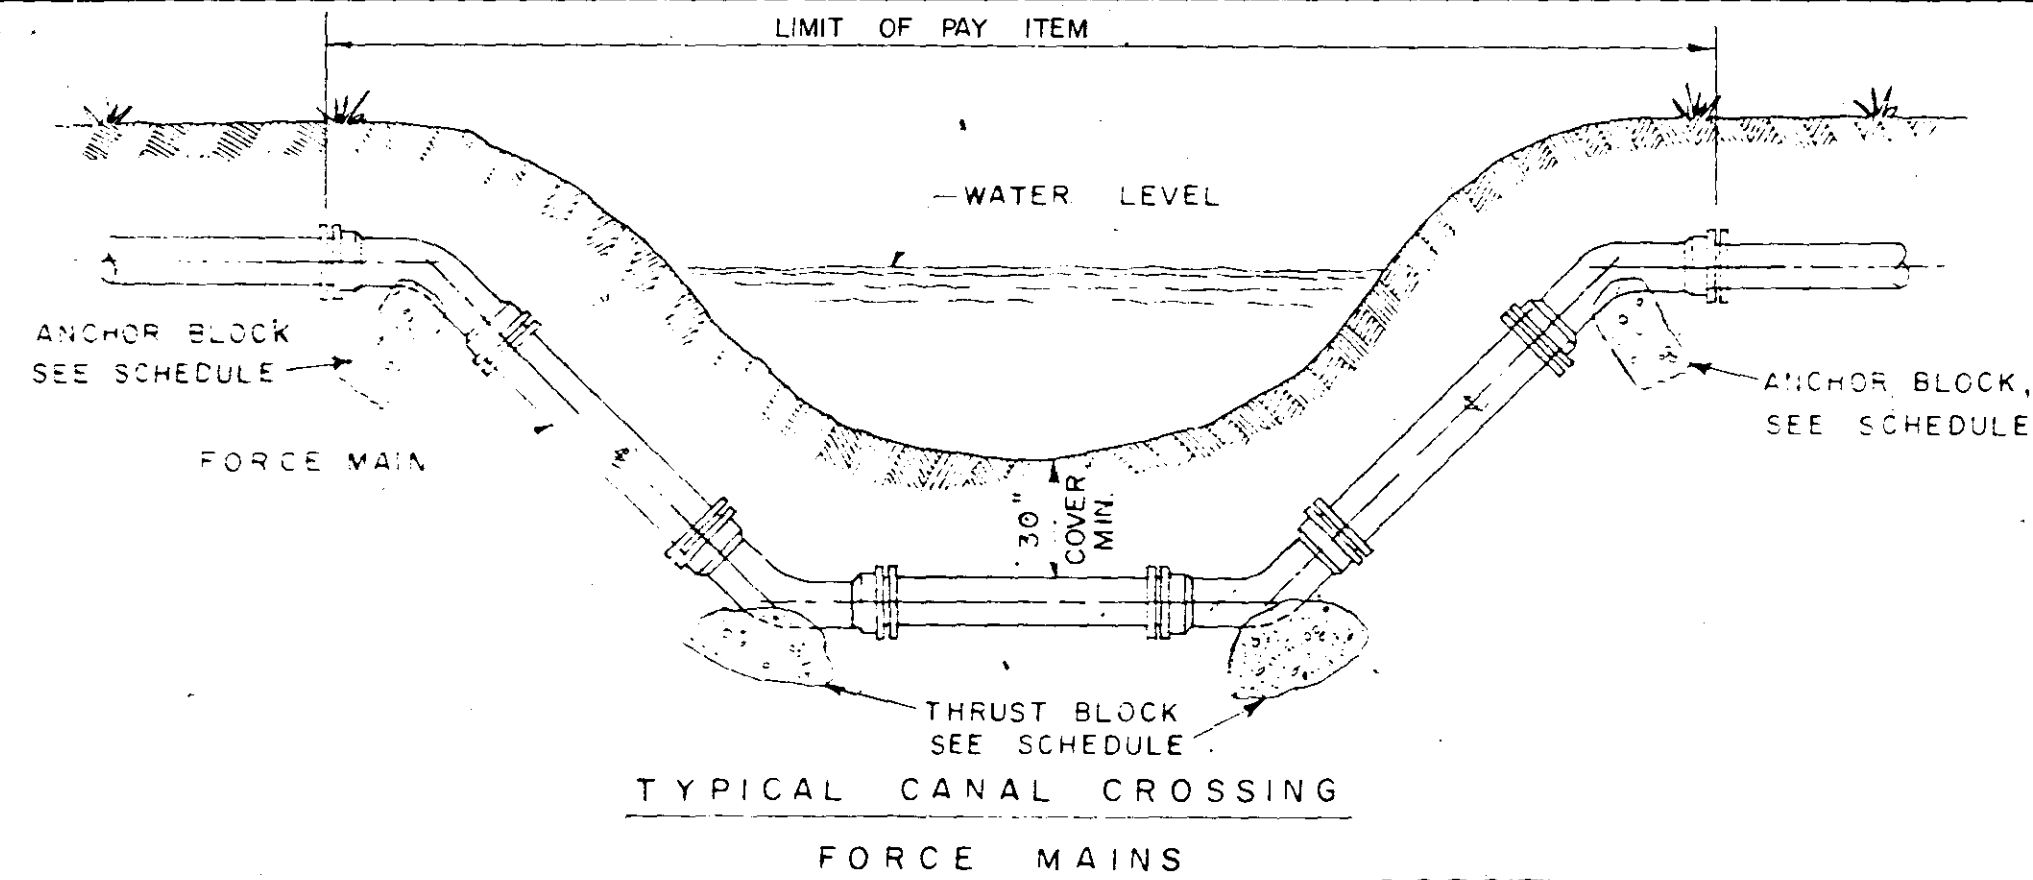


GENERAL NOTES:
1. BLOCK AND PAD SIZES INDICATED IN SCHEDULE ARE TO BE USED IN SOILS WITH A MIN. BEARING CAPACITY OF 2500 PSF WHERE BAD SOILS ARE ENCOUNTERED THEY ARE TO BE REMOVED OR THE CONTRACTOR MAY SUBMIT REVISED ANCHORAGE BLOCKS TO ENGINEER FOR APPROVAL.
2. FOR DETAILS COVERING CONDITIONS NOT SHOWN SEE DETAILS ELSEWHERE IN THESE DRAWINGS OR SUBMIT DETAILS TO ENGINEER FOR APPROVAL.

NOTE: I
ANCHOR BARS:
2" THRU 6" PIPE: 2# 5
8" THRU 16" PIPE: 2# 6
18" THRU 24" PIPE: 3# 8
30" THRU 42" PIPE: 3# 10
HOT-DIP GALV. BARS AFTER FABRICATION, COMPLETELY COAT EXPOSED BARS AFTER INSTALLATION WITH TWO COATS OF BITUMINOUS MASTIC.
NOTE: II
ANCHOR BARS:
2" THRU 6" PIPE: 2# 5
8" THRU 16" PIPE: 2# 6
18" THRU 24" PIPE: 4# 8
30" THRU 42" PIPE: 4# 10
HOT-DIP GALV. BARS AFTER FABRICATION, COMPLETELY COAT EXPOSED BARS AFTER INSTALLATION WITH TWO COATS OF BITUMINOUS MASTIC.

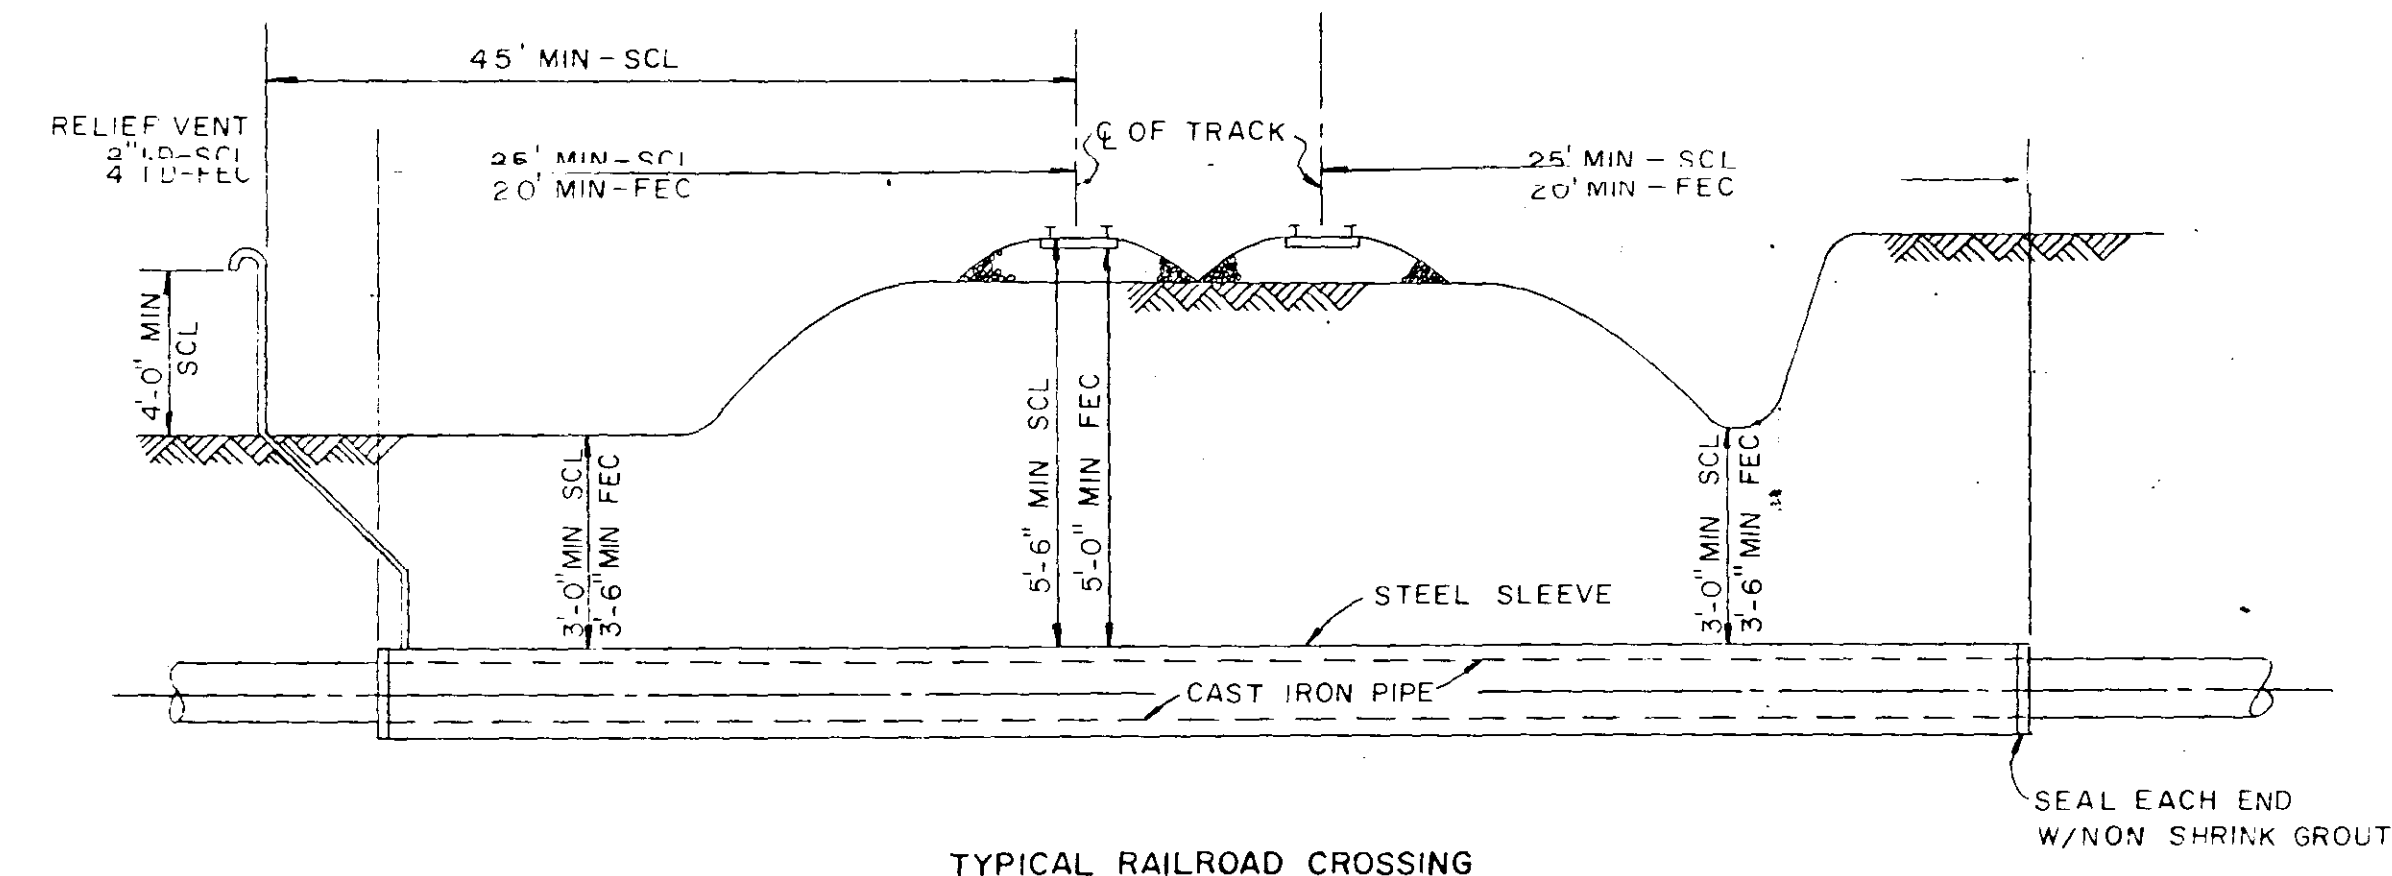

RECORD DRAWING
DATE 6-76 BY JRL
CK

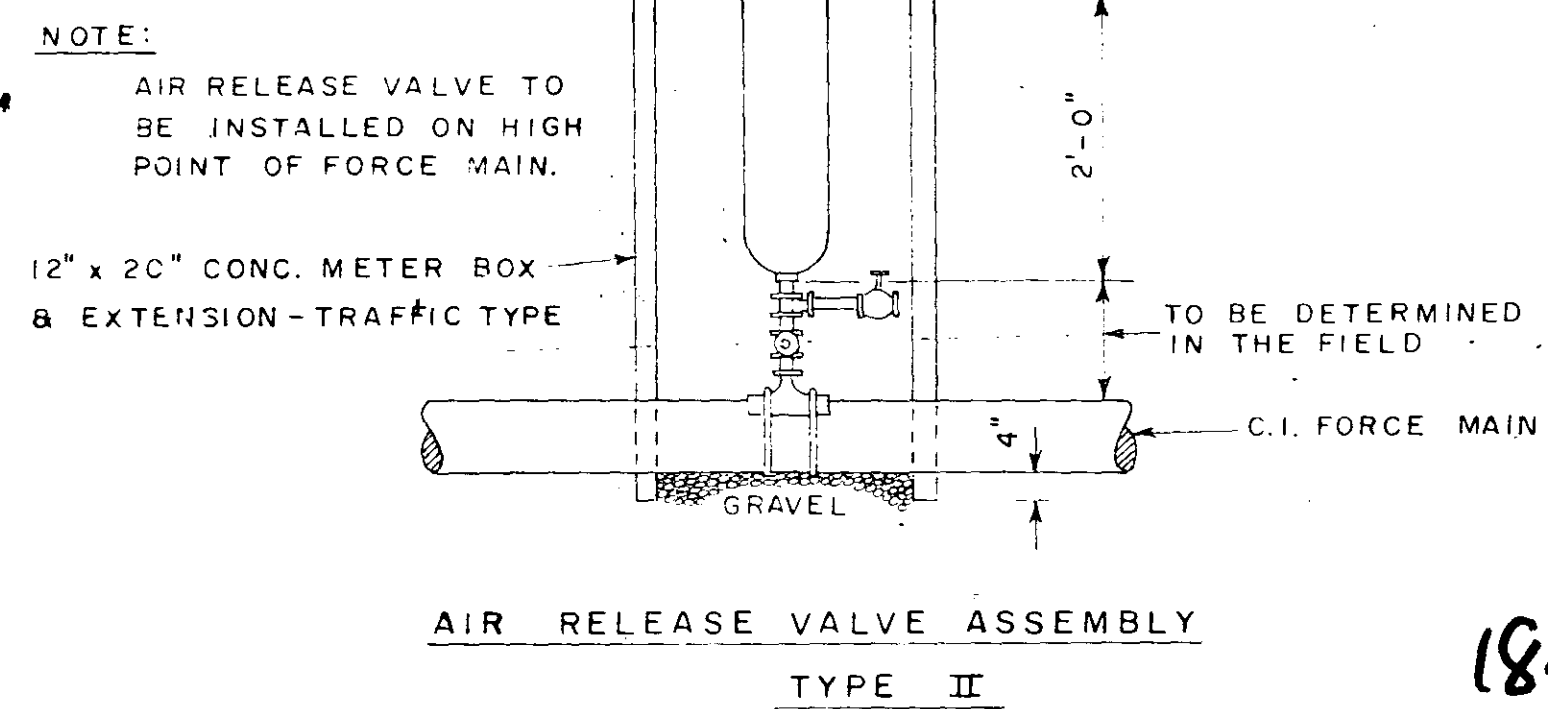

DISREGARD DETAILS THAT ARE NOT APPLICABLE TO THIS PROJECT

RECORD DRAWING		WD
NO.	DATE	DESCRIPTION
REVISIONS		
RUSSELL & AXON Engineers - Planners - Architects DAYTONA BEACH, FLA. ST. LOUIS, MO.		
SANITARY SEWERAGE PROJECT PART D SECTION II FORCE MAIN ID FORCE MAIN, STANDARD DETAILS		
MANATEE COUNTY, FLORIDA		
DESIGNED BY GER	FILE NO. 6681-8b	
DRAWN BY RLB	SHEET NO. 23	
CHECKED BY JWC	OF 23 SHEETS	
DATE OCT 1975	SCALE: NOT TO SCALE	

18-05